




DETAIL 01  
ESC: 3" = 1' 0"

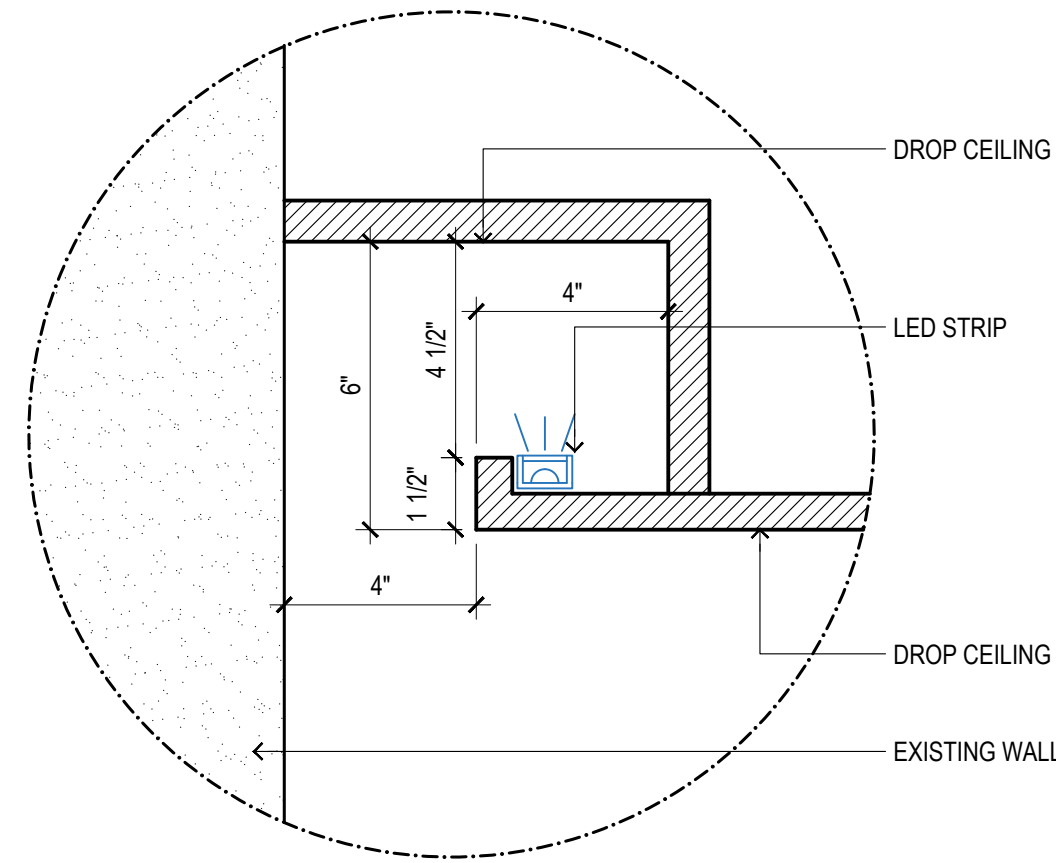

DETAIL 02  
ESC: 3" = 1' 0"

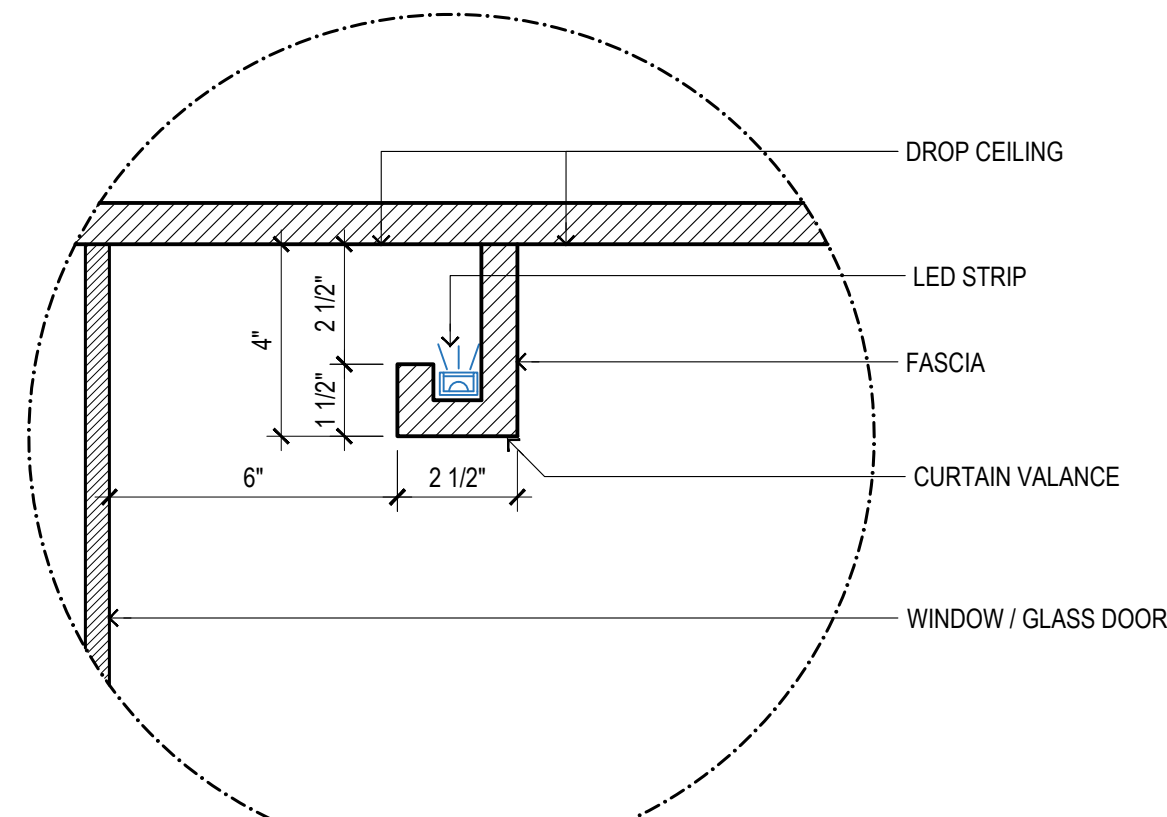

DETAIL 03  
ESC: 3" = 1' 0"

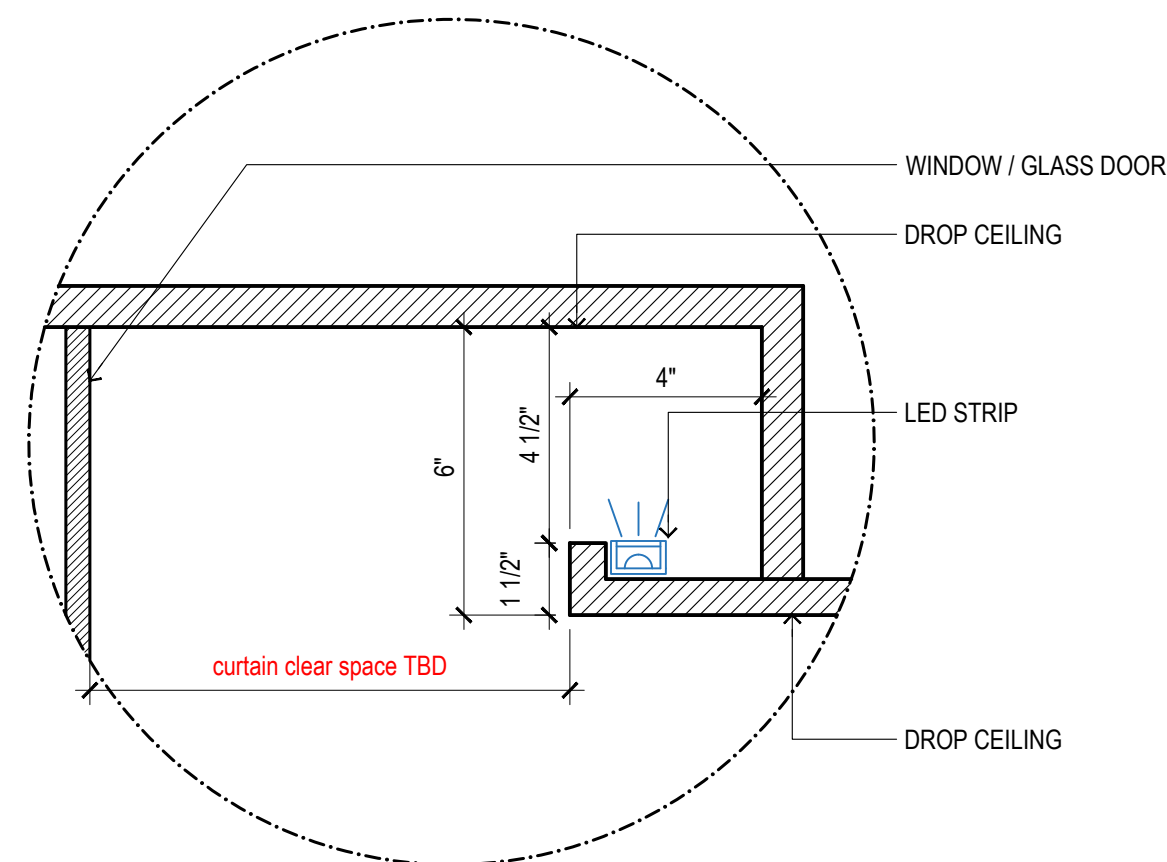

DETAIL 04  
ESC: 3" = 1' 0"  
NOTE: CURTAIN POCKET TO ALIGN WITH EXISTING WALL DENT. CURTAIN CLEAR SPACE TO BE DETERMINED ON SITE ACCORDING TO WALL GAP.



LIGHTING LEGEND		
LEGEND	DESCRIPTION	QTY.
	RECESSED SQUARED FRAMED FIXTURE TBD, WHITE FINISH. VAPOR PROOF INSIDE BATHROOM SHOWERS.	72
	RECESSED SQUARED FRAMED FIXTURE TBD, ADJUSTABLE FIXTURE, WHITE FINISH.	10
	J BOX FOR CHANDELIER / FLUSH MOUNT TBD, FORESEE STRUCTURE TO SUPPORT WEIGHT FOR THE FUTURE CHANDELIER.	8
	WALL STEPLIGHT FIXTURE TBD - WHITE FINISH. H = 12"	4
	WALL SCONCE / LIGHT FIXTURE TBD. (CHECK HEIGHT ON PLAN)	1
	LED STRIP RECESSED IN CHANNEL - 3000K	132' LINEAR FT.
	LED STRIP FOR MILLWORK - 3000K	130' LINEAR FT.
	LED STRIP FOR MIRRORS - 3000K	17' LINEAR FT.
	POWER SUPPLY FOR CLOSET LIGHTS. FOLLOW THE INSTRUCTIONS OF THE FABRICATOR FOR LOCATION.	
	CEILING MOUNT EXHAUST FAN	5

NOTES:  
- CONSIDER ALLOWANCE FOR RELOCATION OF A/C GRILLS AND CONNECTIONS.  
- CONFIRM FIRE ALARM LOCATIONS WITH DESIGNER.

PROJECT NAME:  
**SNYDER RESIDENCE**

ADDRESS:  
**100 South Pointe Dr. Miami Beach, FL 33139.  
South Tower #3606**

**ALL THE DIMENSIONS MUST BE CHECKED ON SITE**  
THESE DOCUMENTS ARE THE SOLE PROPERTY OF DESIGN SOLUTIONS AND SUBJECT TO COPY RIGHTS/LAWS. ANY COPYING OR RELEASE OF INFORMATION THERE IN, WITHOUT THE EXPRESS WRITTEN PERMISSION OF DESIGN SOLUTIONS, IS PROHIBITED.

# DESIGN/SOLUTIONS

INTERIOR DESIGN & ARCHITECTURE

2900 SW 28th Terrace Unit 402 Miami, FL 33133  
TEL: 305.778.6860 / 786.391.1418  
<https://ds-miami.com>

REV.	DESCRIPTION	BY:	DATE:
R00	ORIGINAL DRAWING	ANDRE'S TEAM	08/15/2023
R01	OVERALL UPDATES	ANDRE'S TEAM	08/22/2023

DRAWING TITLE:  
**PROPOSED LIGHTING PLAN**

DRAWN BY:  
**ANDRE'S TEAM**

SCALE:  
**1/4" = 1'-0"**

DATE:  
October 11, 2023

SHEET NO:  
**I-108**

PROJECT NO: