


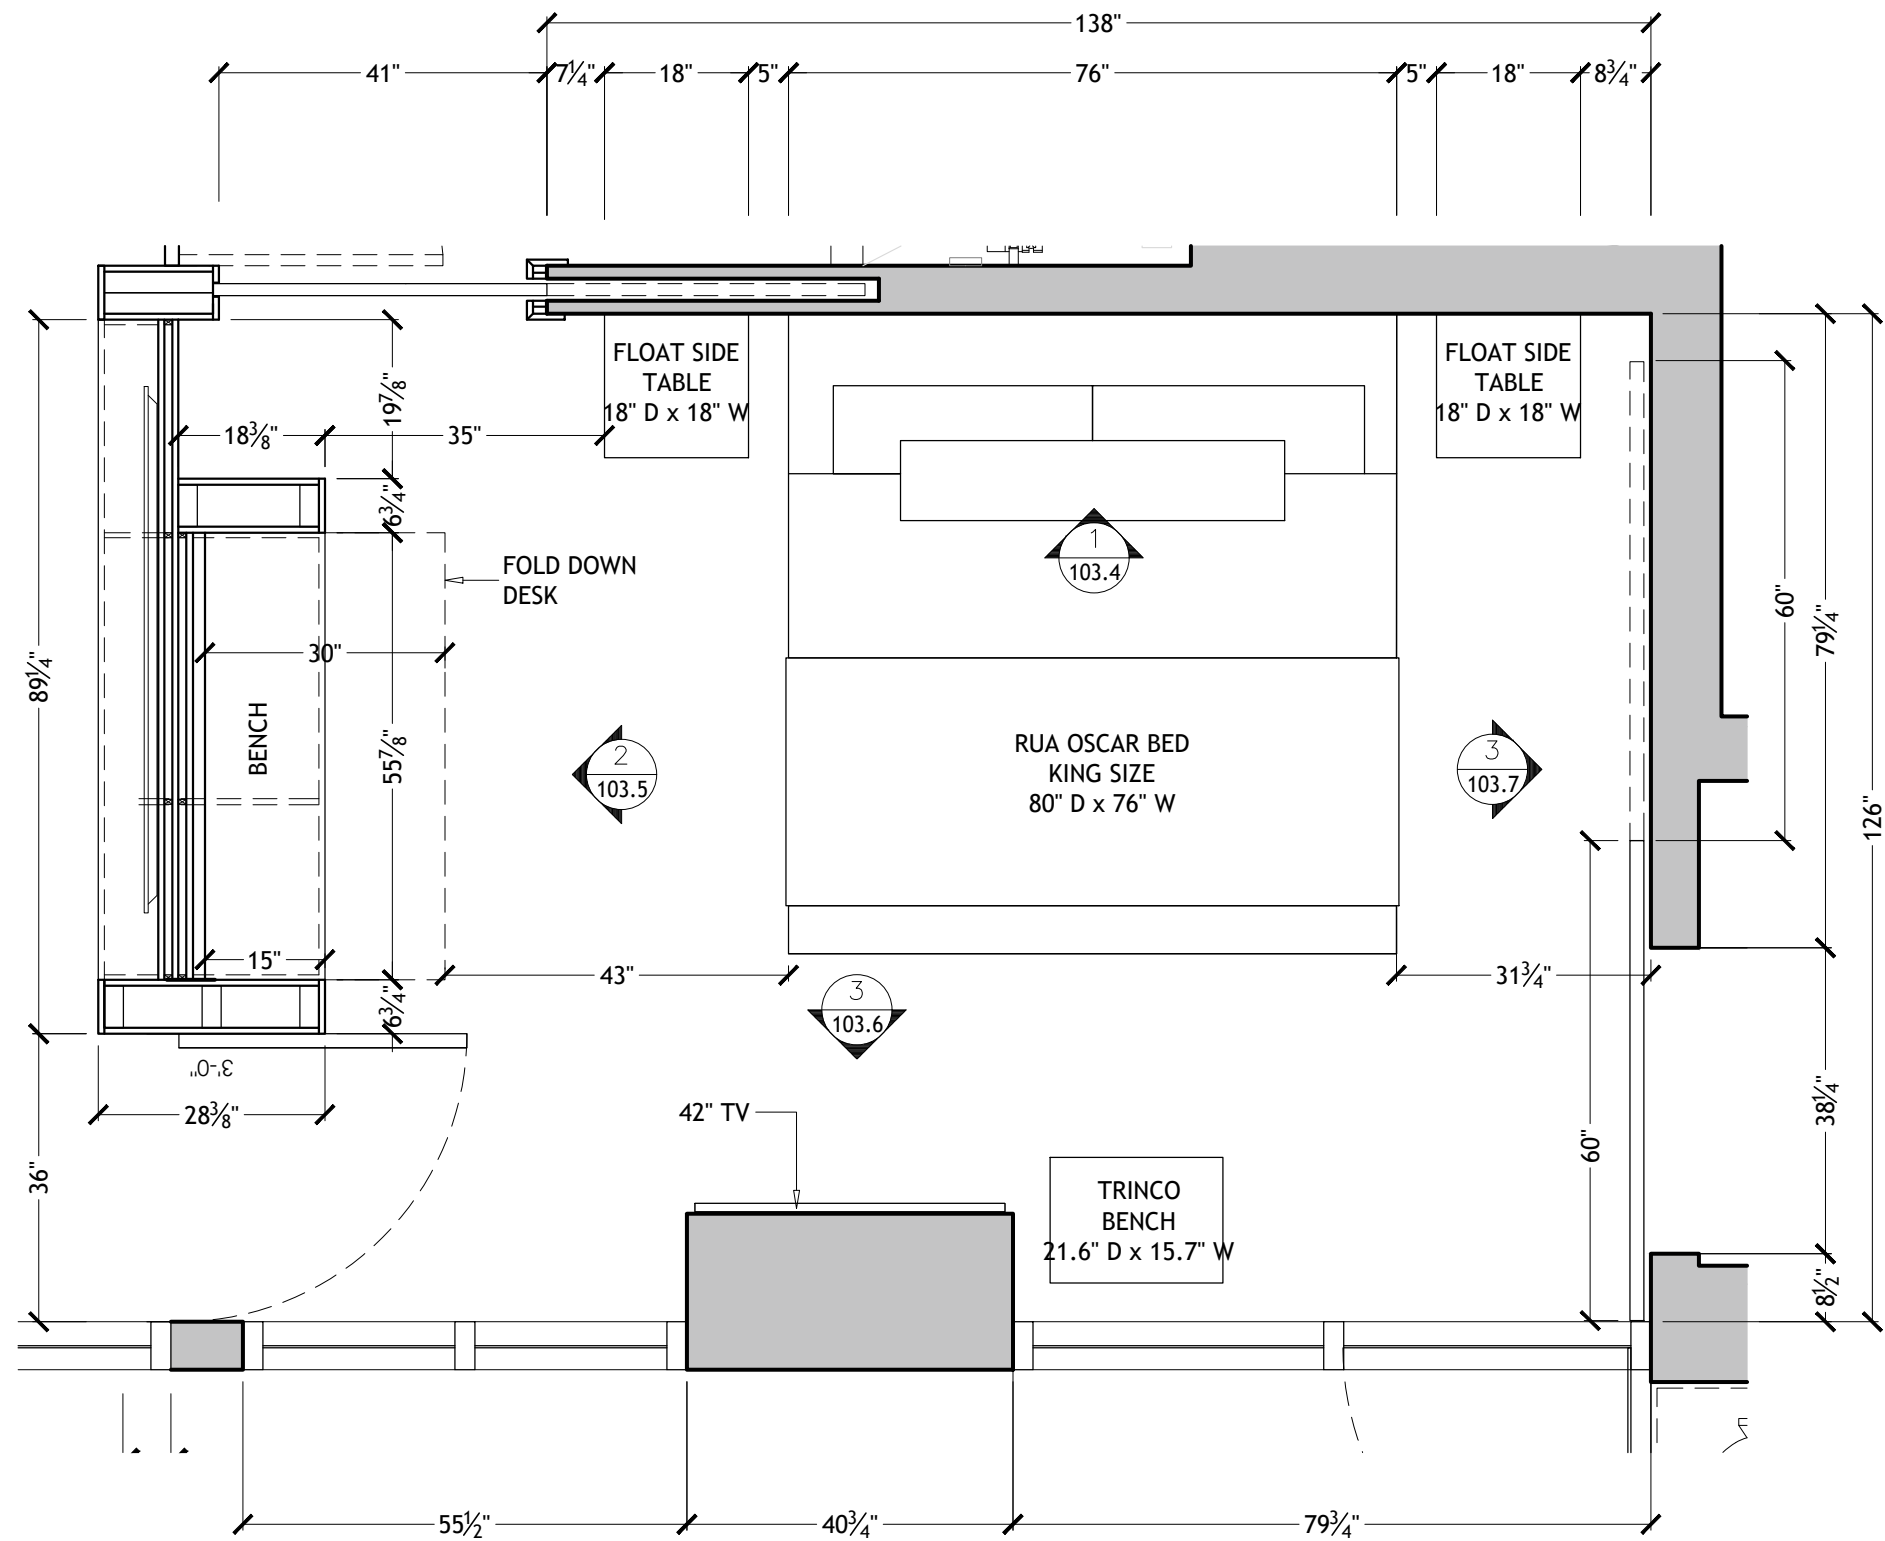

1 PLAN
103.1 SCALE 1/2"=1'-0"

FOR CONSTRUCTION
AUGUST 12, 2022

REVISIONS:
JULY 25 CHANGE DOOR IN CLOSET TO A BARN DOOR
EXPOSE CONCRETE COLUMN IN WINDOW WALL

All site measurements must be verified by the contractor.
Any substitutes in materials, finishes or otherwise specified items are not acceptable without written approval of the designer.
This document and all associated documents are prepared for a specific site and event, and incorporate calculations and measurements available from the client at the time of drafting.
The contents of this document are not to be reproduced or copied in whole or part without the written permission of Fleur-de-Lis Interior Design Inc.
It is the responsibility of the contractor to build in compliance to and abide by all pertainable building codes.
Copyright © 2015



Fleur-de-lis
interior design inc.
294 Eglinton Ave W
Toronto, ON M4R 1B2
Voice: (416) 929-8599
Fax: (416) 929.8535
www.fleurdelis.ca
consults@fleurdelis.ca

PROJECT NAME:
100 SOUTH POINT DRIVE, UNIT #613


SHEET TITLE:
**MAIN BEDROOM
PLAN**

SCALE:
1/2"=1'-0"

LAST DRAWN
AUGUST 12, 2022

**103.1
ID**

DRAWN BY:
PM

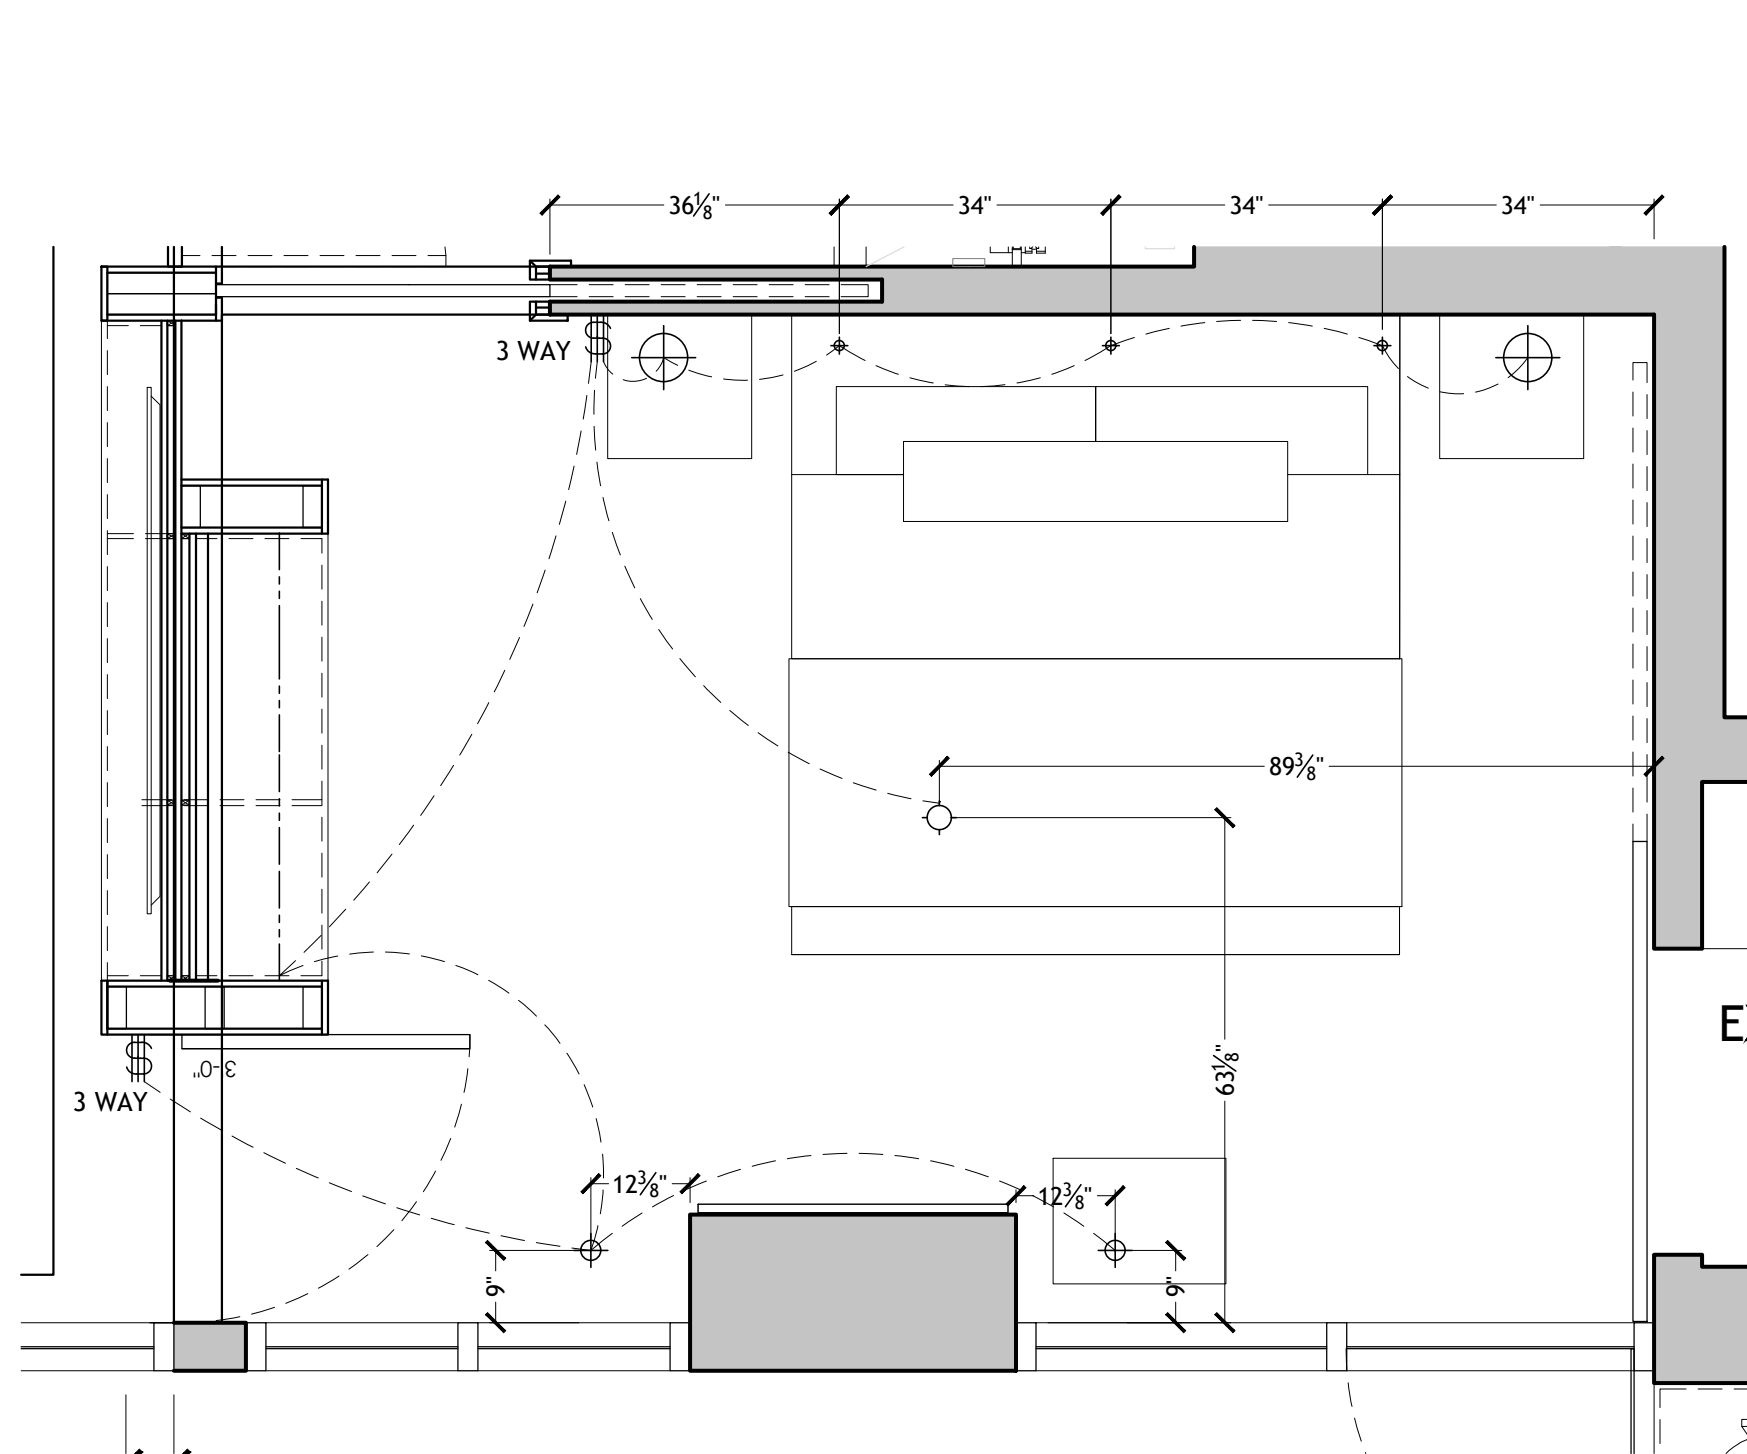

- LEGEND - LIGHTING**
- PUCK LIGHT
 - FLUSH MOUNT
 - POTLIGHT
 - TABLE LAMP
 - LED STRIP LIGHT
 - WALL SWITCH, TRIPLE

2 RCP & LIGHTING PLAN
103.2 SCALE 1/2"=1'-0"

FOR CONSTRUCTION
AUGUST 12, 2022

REVISIONS:
MAY 25 REMOVE GRAPHIC EYES FROM LIGHT PLAN

All site measurements must be verified by the contractor.
Any substitutes in materials, finishes or otherwise specified items are not acceptable without written approval of the designer.
This document and all associated documents are prepared for a specific site and event, and incorporate calculations and measurements available from the client at the time of drafting.
The contents of this document are not to be reproduced or copied in whole or part without the written permission of Fleur-de-Lis Interior Design Inc.
It is the responsibility of the contractor to build in compliance to and abide by all pertainable building codes.
Copyright © 2015



Fleur-de-lis
interior design inc.
294 Eglinton Ave W
Toronto, ON M4R 1B2
Voice: (416) 929-8599
Fax: (416) 929.8535
www.fleurdellis.ca
consults@fleurdellis.ca


PROJECT NAME:
50 SOUTH POINT DRIVE, UNIT #613
SHEET TITLE:
**MAIN BEDROOM
RCP & LIGHTING PLAN**
SCALE:
1/2"=1'-0"
LAST DRAWN
AUGUST 12, 2022

103.2
ID
DRAWN BY:
PM



LEGEND - ELECTRICAL

- DUPLEX RECEPTACLE
- USB RECEPTACLE
- INTERNET / CABLE

NOTE:
- ALL RECEPTACLES TO BE HORIZONTAL 6" AFF UNLESS NOTED.

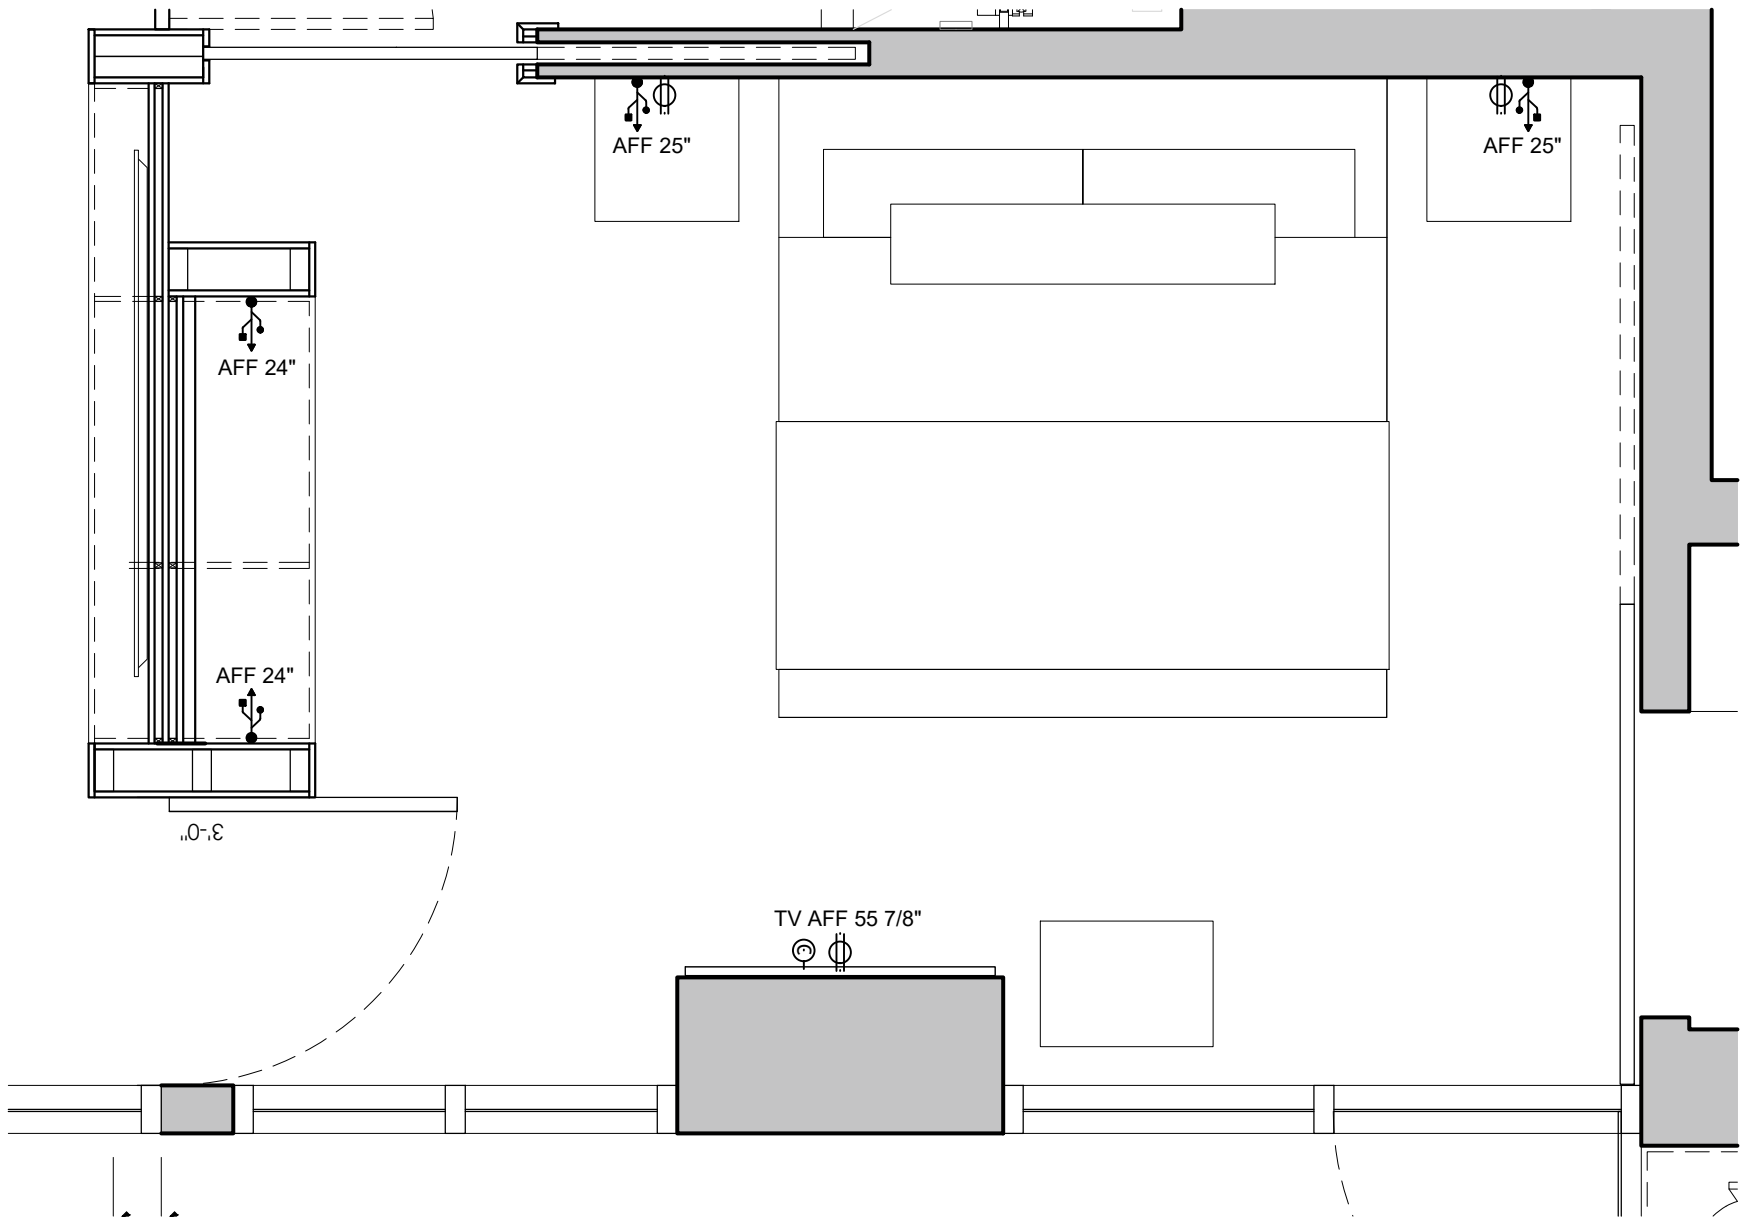

 FOR CONSTRUCTION AUGUST 12, 2022	REVISIONS:	All site measurements must be verified by the contractor. Any substitutes in materials, finishes or otherwise specified items are not acceptable without written approval of the designer. This document and all associated documents are prepared for a specific site and event, and incorporate calculations and measurements available from the client at the time of drafting. The contents of this document are not to be reproduced or copied in whole or part without the written permission of Fleur-de-Lis Interior Design Inc. It is the responsibility of the contractor to build in compliance to and abide by all pertainable building codes. Copyright © 2015	 Fleur-de-lis interior design inc. 294 Eglinton Ave W Toronto, ON M4R 1B2 Voice: (416) 929-8599 Fax: (416) 929.8535 www.fleurdelis.ca consults@fleurdelis.ca	PROJECT NAME: 50 SOUTH POINT DRIVE, UNIT #613	103.3 ID
				SHEET TITLE: MAIN BEDROOM ELECTRICAL PLAN	
				SCALE: 1/2"=1'-0"	
				LAST DRAWN AUGUST 12, 2022	DRAWN BY: PM

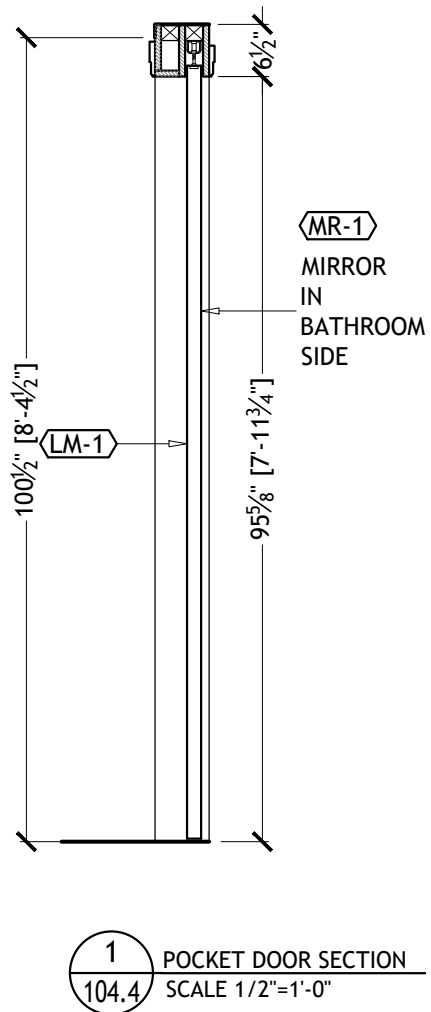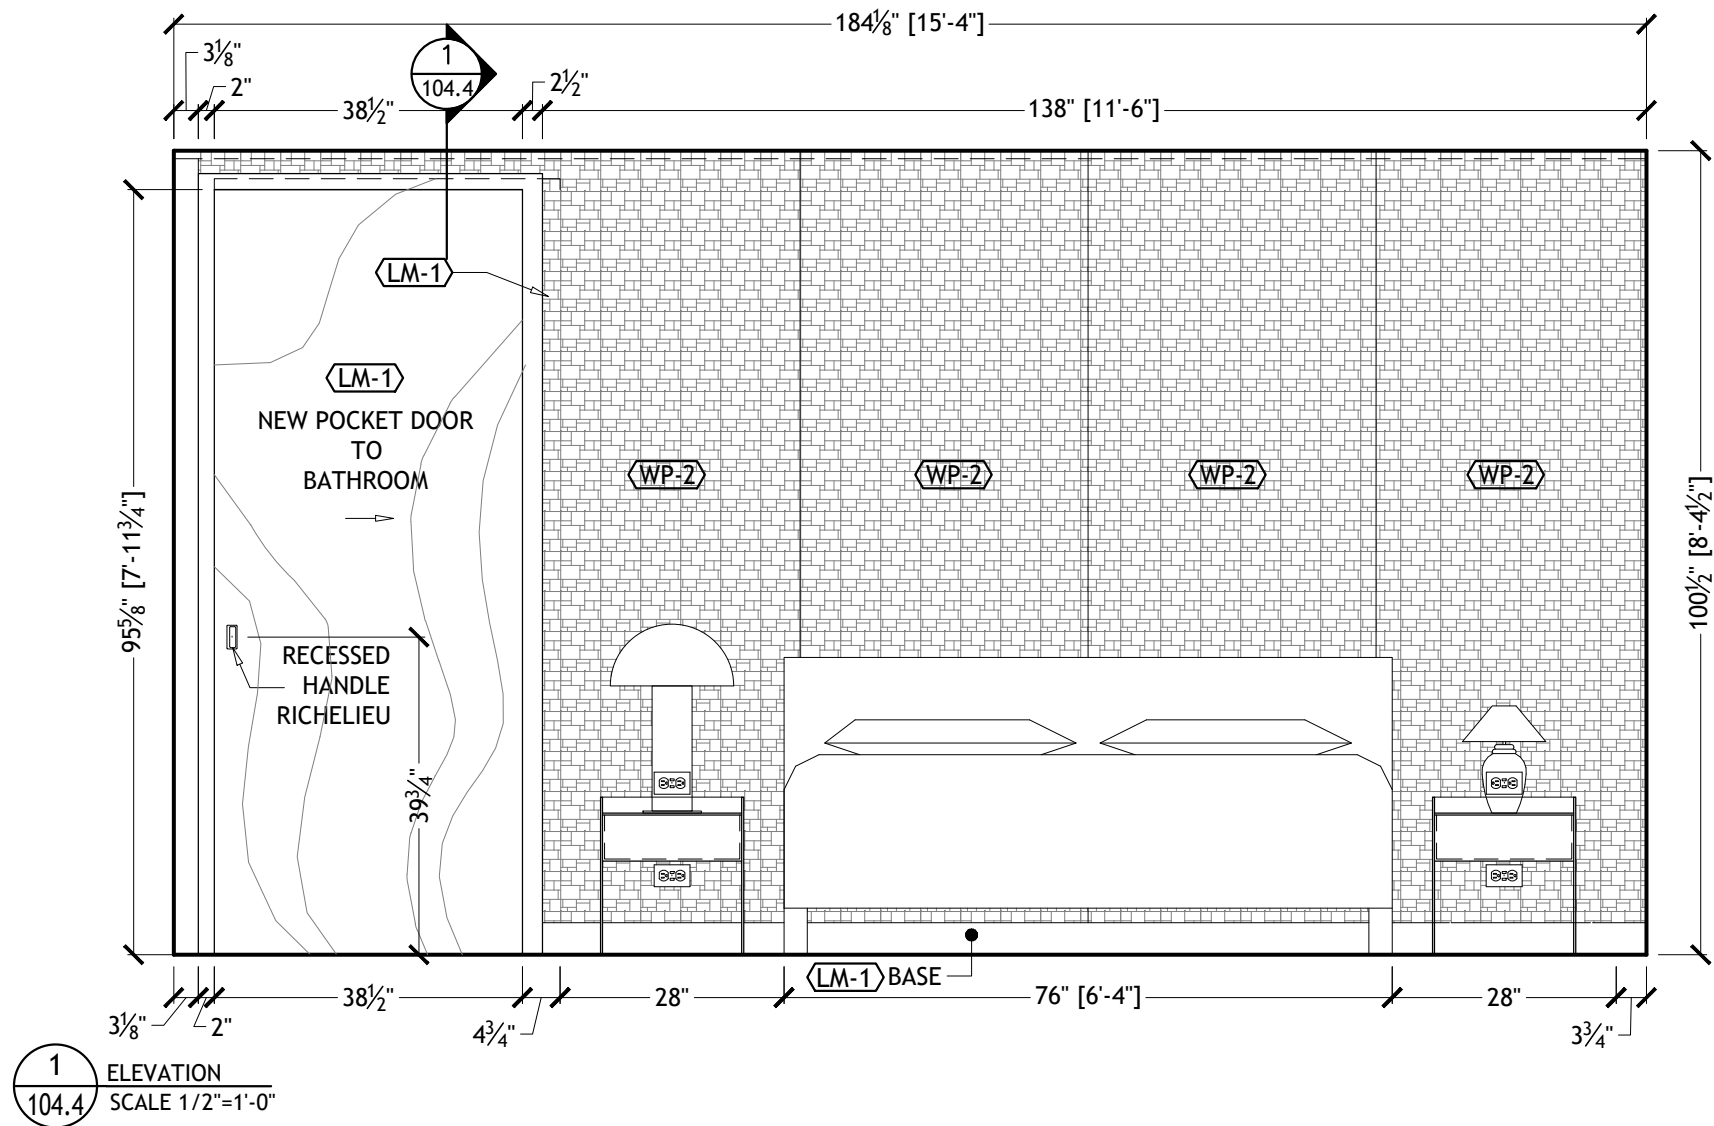

Pocket Door Pull - Rectangular

Compatible with left-hand and right-hand doors.


Designed to be installed on most types of doors, this pocket door pull is available in a variety of finishes and is sure to suit any design. It will complete any room. Easy to install.

Product № 17C10


Color/Finish Chrome


Door Thickness 1 3/8 in

Packaging format Per unit

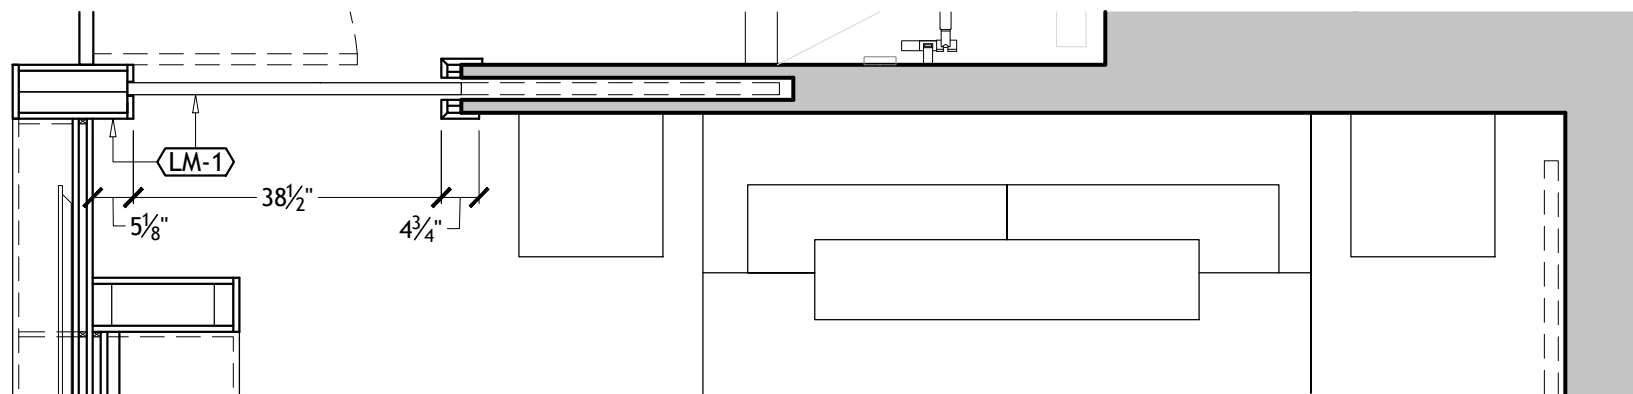


- WP-2 NATURAL WALL COVERINGS, CROWN WALLPAPER, SG6001 - GREY CORK
- WD-1 UNIBOARD, K62 FEATHER WHITE, NOBELLA FINISH
- LM-1 OCTOLUX #15-STAINLESS STEEL ALUMINUM
- ML-1 UNIBOARD 123, CHARCOAL (INTERIOR)
- SP-1 EXISITING EXPOSED CONCRETE

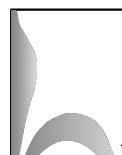 FOR CONSTRUCTION AUGUST 12, 2022	REVISIONS: JUNE 13 UPDATE THE WALLPAPER BEHIND HEADBOARD, INCLUDE THE FURNITURE	All site measurements must be verified by the contractor. Any substitutes in materials, finishes or otherwise specified items are not acceptable without written approval of the designer. This document and all associated documents are prepared for a specific site and event, and incorporate calculations and measurements available from the client at the time of drafting. The contents of this document are not to be reproduced or copied in whole or part without the written permission of Fleur-de-Lis Interior Design Inc. It is the responsibility of the contractor to build in compliance to and abide by all pertainable building codes. Copyright © 2015	 Fleur-de-lis interior design inc. 294 Eglinton Ave W Toronto, ON M4R 1B2 Voice: (416) 929-8599 Fax: (416) 929.8535 www.fleurdelis.ca consults@fleurdelis.ca	PROJECT NAME: 50 SOUTH POINT DRIVE, UNIT #613	103.4 ID
				SHEET TITLE: MAIN BEDROOM ELEVATIONS	
					SCALE: 1/2"=1'-0"

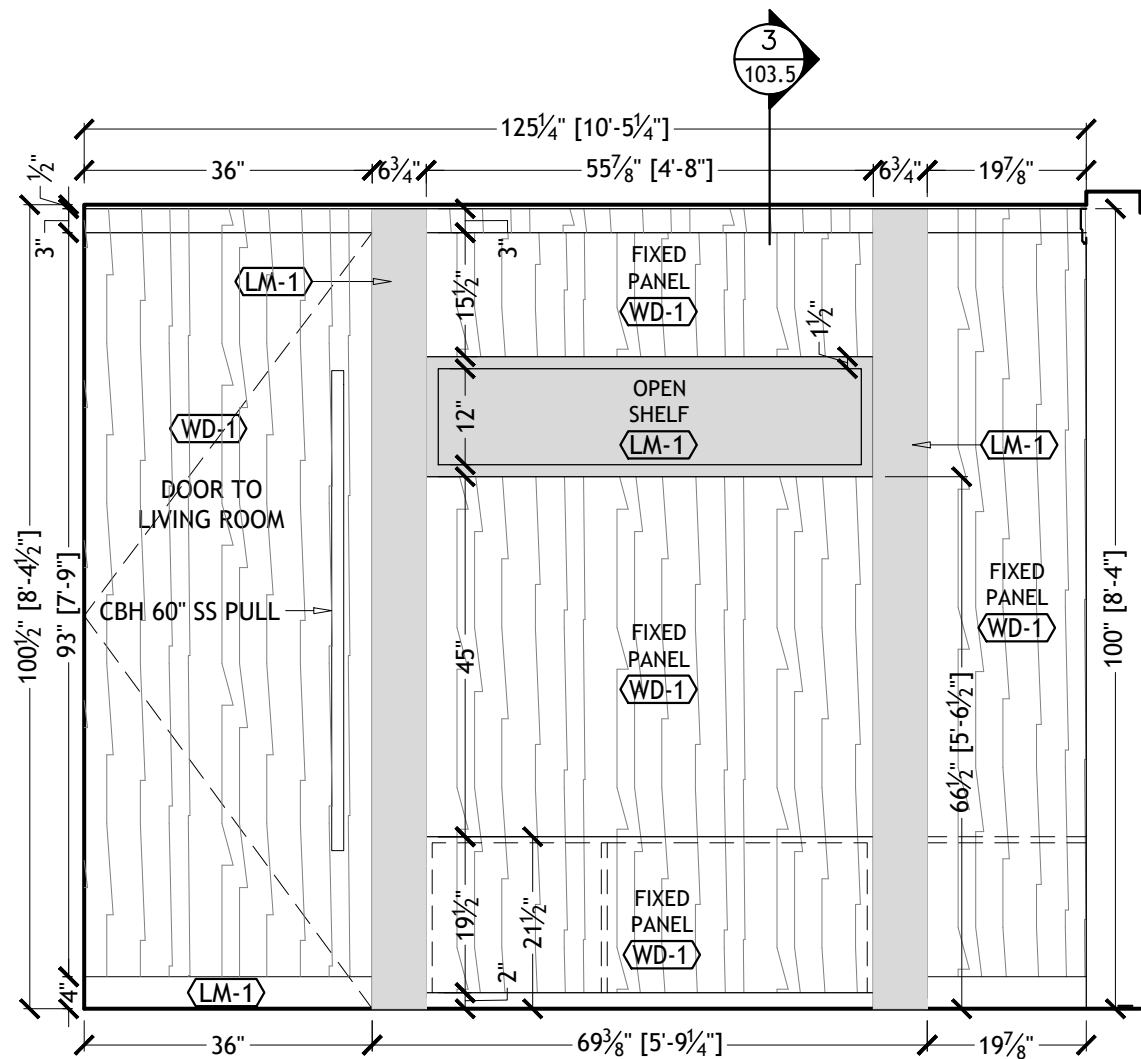

2 ELEVATION
104.5 SCALE 1/2"=1'-0"

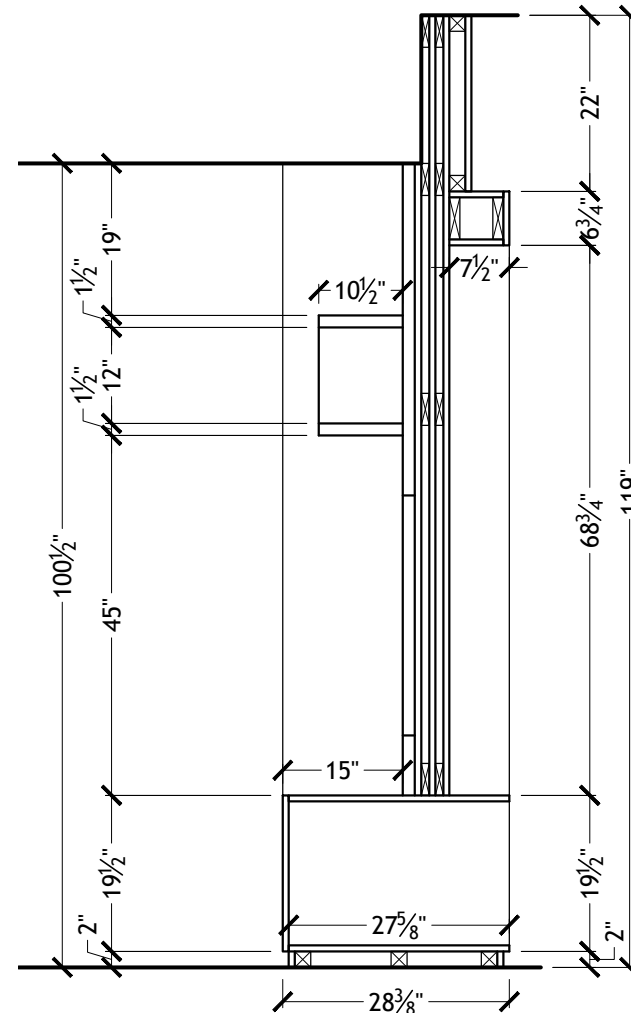

3 SECTION
103.5 SCALE 1/2"=1'-0"



CBH 6041

MATERIAL:
1" OR 1 1/4" BRASS, BRONZE, ALUMI-
NUM AND STAINLESS STEEL, 1 1/2"
DIA STAINLESS STEEL

FINISHES: ALL STANDARD

MOUNTING: 1, 3 OR 6.
#1 MTG 5/16-18 NC
#3 MTG 5/16-18 NC
#6 MTG 3/8-16 NC

SKUS: CBH 6041-1 -1" DIA
CBH 6041-2-1-1/4" DIA
CBH 6041-3-1-1/2" DIA

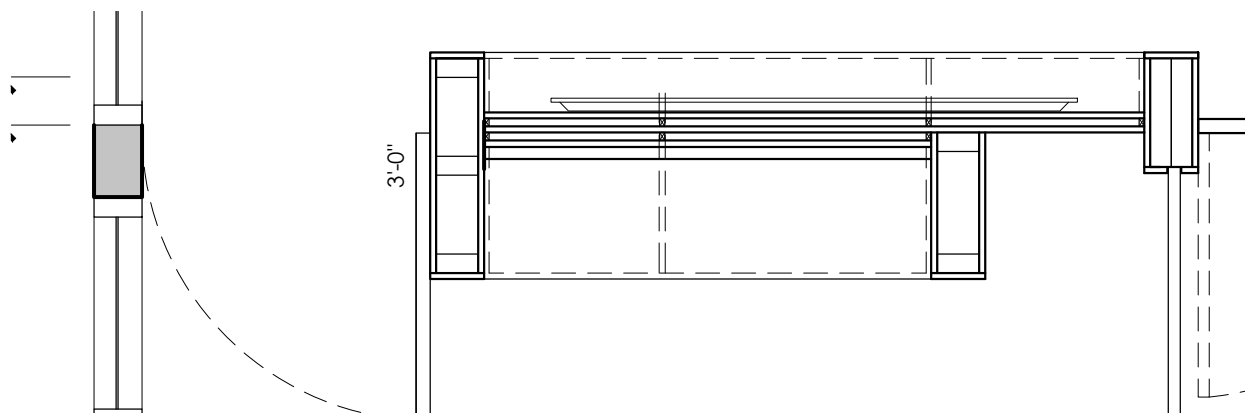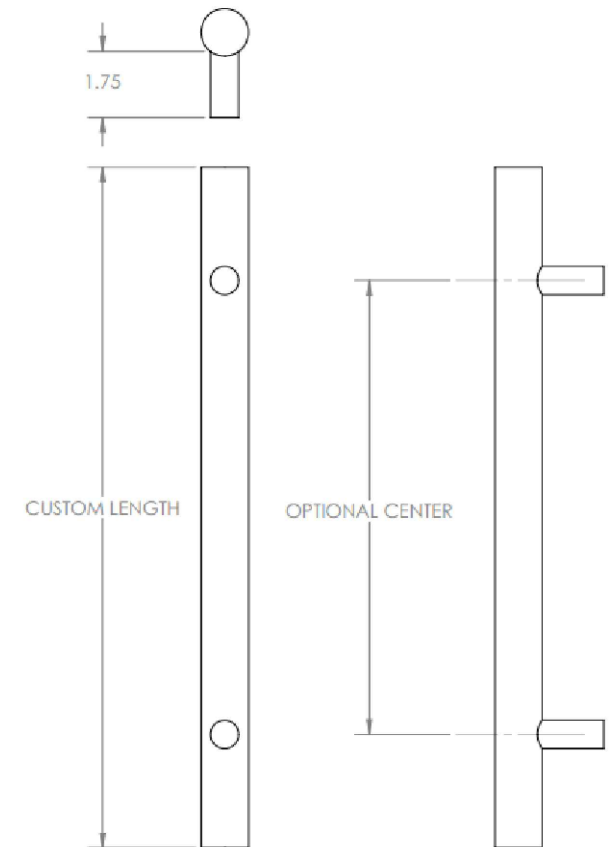

- WP-2** NATURAL WALL COVERINGS, CROWN WALLPAPER, SG6001 - GREY CORK
- WD-1** UNIBOARD, K62 FEATHER WHITE, NOBELLA FINISH
- LM-1** OCTOLUX #15-STAINLESS STEEL ALUMINUM
- ML-1** UNIBOARD 123, CHARCOAL (INTERIOR)
- SP-1** EXISITING EXPOSED CONCRETE

FOR CONSTRUCTION
AUGUST 12, 2022



REVISIONS:

All site measurements must be verified by the contractor.
Any substitutes in materials, finishes or otherwise specified items are not acceptable without written approval of the designer.
This document and all associated documents are prepared for a specific site and event, and incorporate calculations and measurements available from the client at the time of drafting.
The contents of this document are not to be reproduced or copied in whole or part without the written permission of Fleur-de-Lis Interior Design Inc.
It is the responsibility of the contractor to build in compliance to and abide by all pertainable building codes.
Copyright © 2015




Fleur-de-lis
interior design inc.
294 Eglinton Ave W
Toronto, ON M4R 1B2
Voice: (416) 929-8599
Fax: (416) 929-8535
www.fleurdelis.ca
consults@fleurdelis.ca

PROJECT NAME: 50 SOUTH POINT DRIVE, UNIT #613	103.5 ID
SHEET TITLE: MAIN BEDROOM ELEVATIONS	
SCALE: 1/2"=1'-0"	LAST DRAWN AUGUST 12, 2022 DRAWN BY: PM

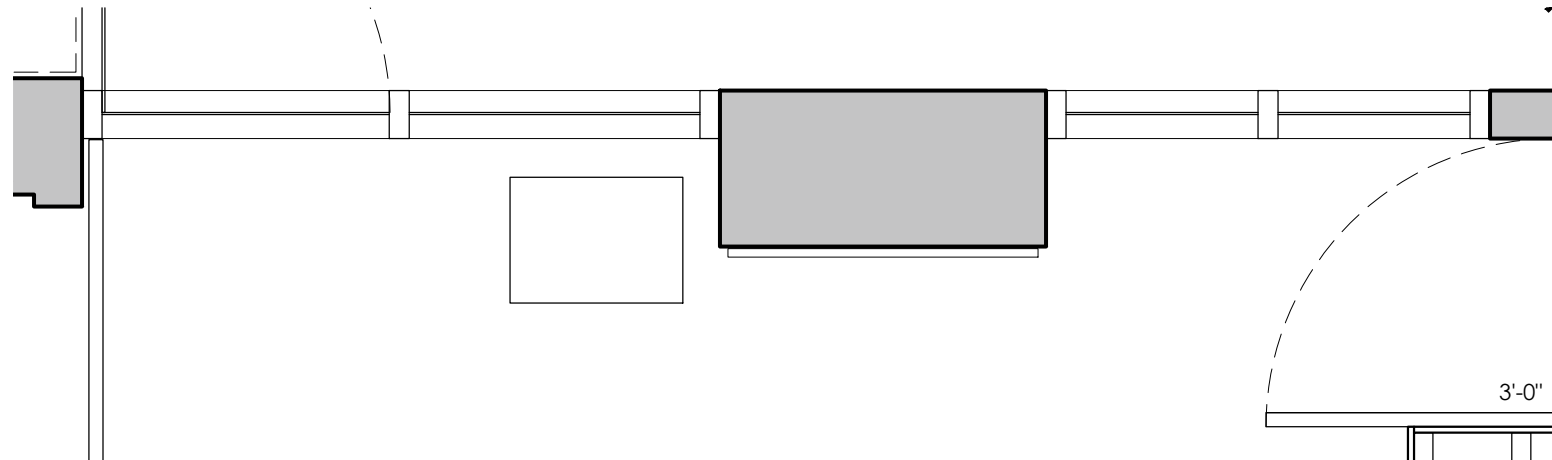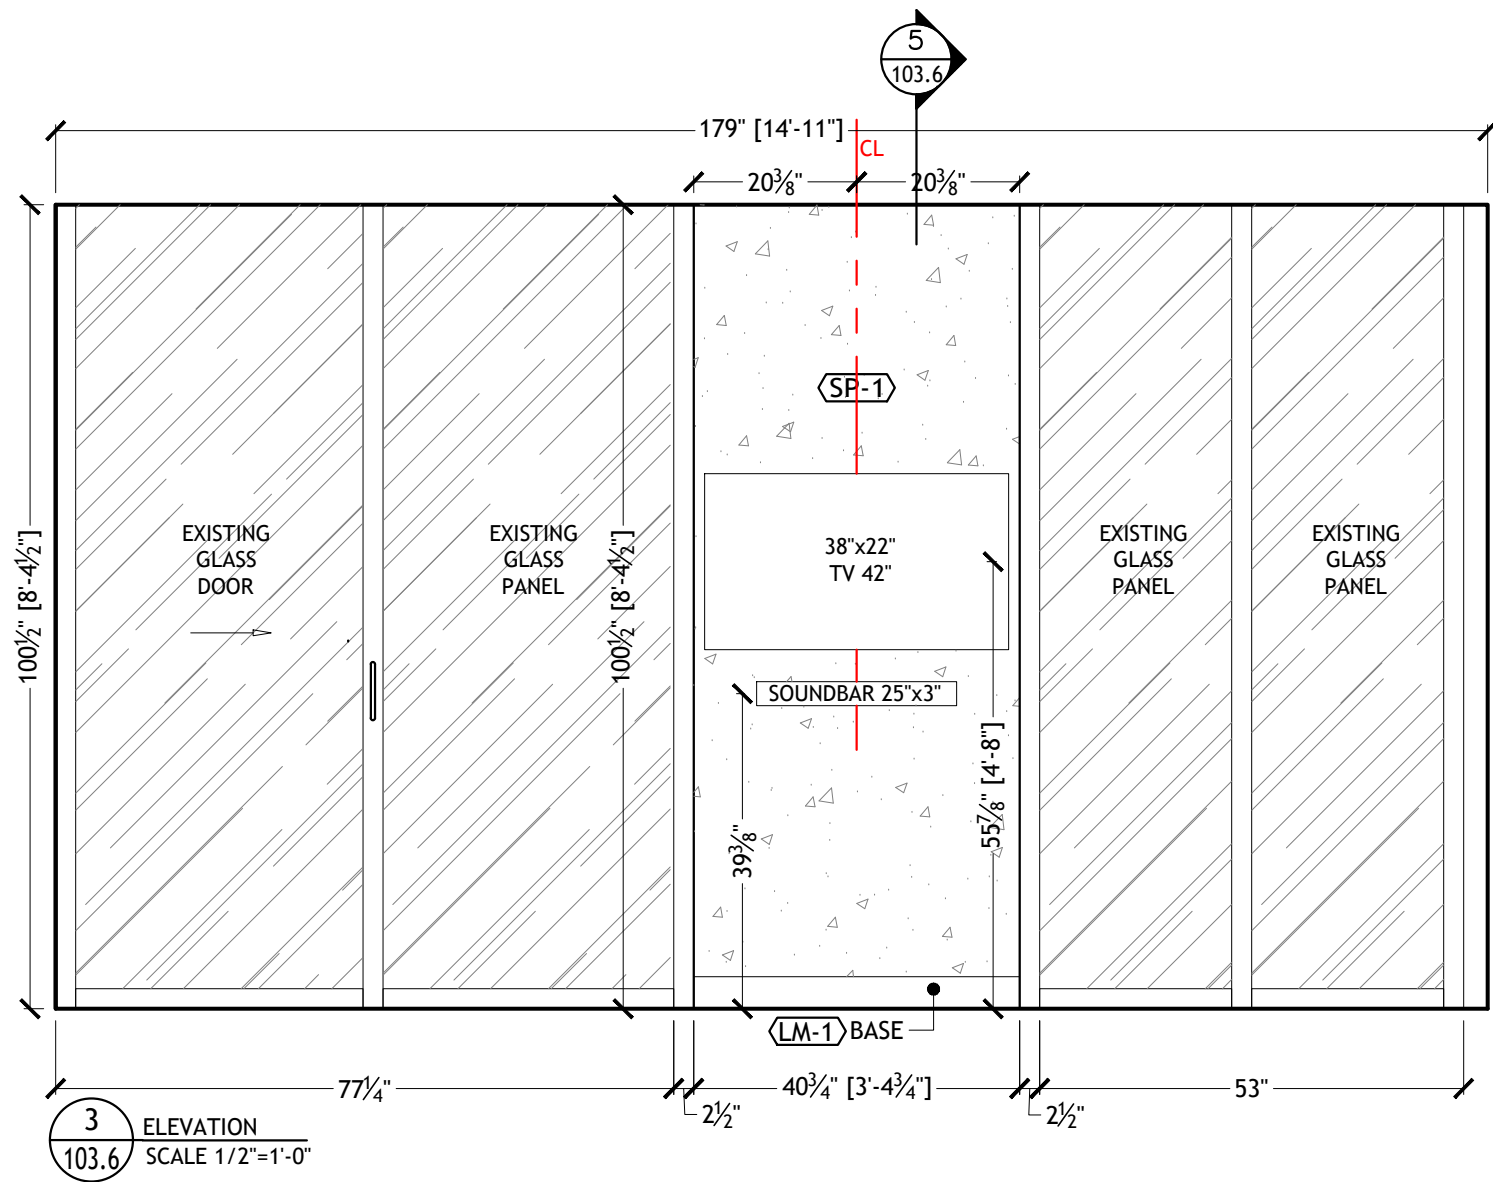

- LM-1 OCTOLUX #15-STAINLESS STEEL ALUMINUM
- SP-1 EXISITING EXPOSED CONCRETE

 FOR CONSTRUCTION AUGUST 12, 2022	REVISIONS: JULY 25 EXPOSED CONCRETE IN COLUMN	All site measurements must be verified by the contractor. Any substitutes in materials, finishes or otherwise specified items are not acceptable without written approval of the designer. This document and all associated documents are prepared for a specific site and event, and incorporate calculations and measurements available from the client at the time of drafting. The contents of this document are not to be reproduced or copied in whole or part without the written permission of Fleur-de-Lis Interior Design Inc. It is the responsibility of the contractor to build in compliance to and abide by all perttainable building codes. Copyright © 2015	 Fleur-de-lis interior design inc. 294 Eglinton Ave W Toronto, ON M4R 1B2 Voice: (416) 929-8599 Fax: (416) 929.8535 www.fleurdelis.ca consults@fleurdelis.ca	PROJECT NAME: 50 SOUTH POINT DRIVE, UNIT #613	103.6 ID
		SHEET TITLE: MAIN BEDROOM ELEVATIONS			
				SCALE: 1/2"=1'-0"	LAST DRAWN AUGUST 12, 2022

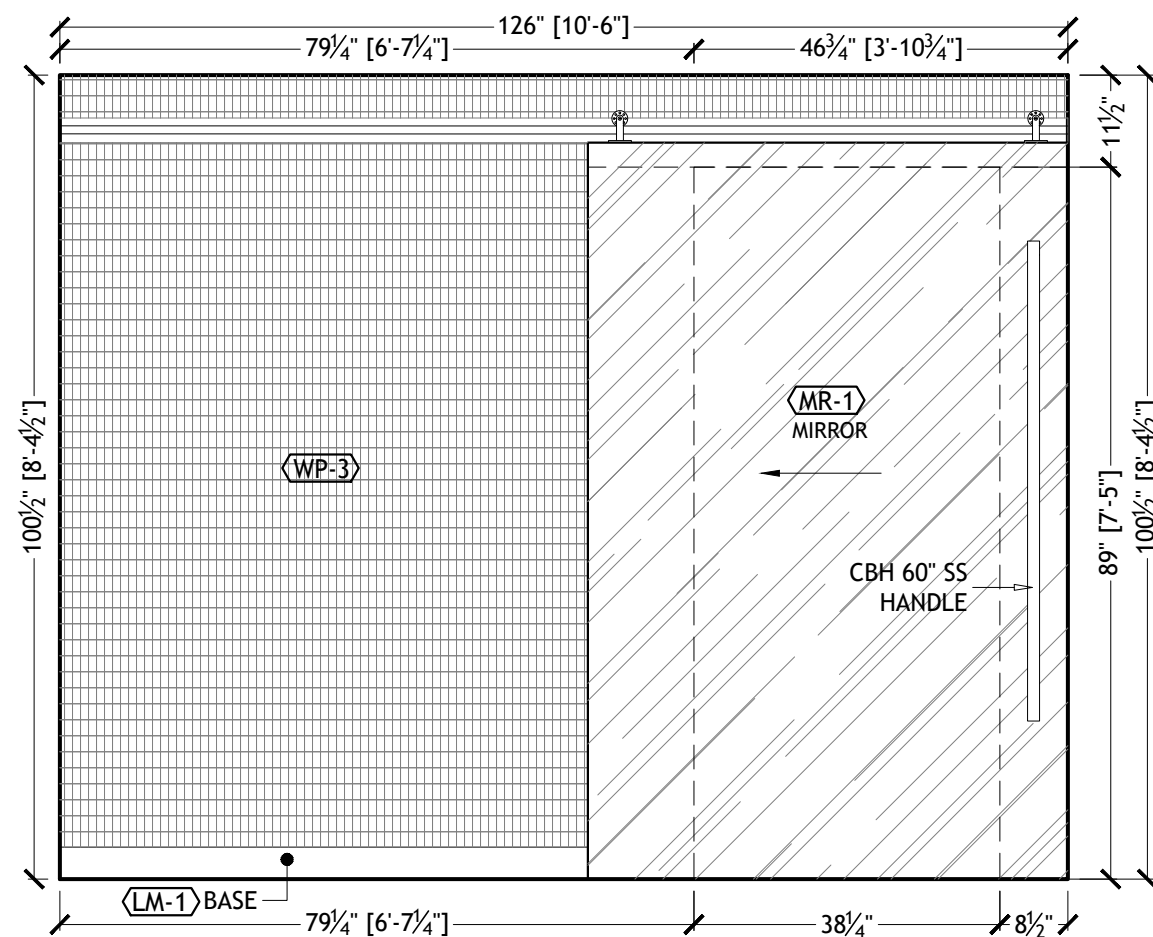

4
103.7

ELEVATION
SCALE 1/2"=1'-0"



CBH 6041

MATERIAL:
1" OR 1 1/4" BRASS, BRONZE, ALUMI-
NUM AND STAINLESS STEEL, 1 1/2"
DIA STAINLESS STEEL

FINISHES: ALL STANDARD

MOUNTING: 1, 3 OR 6.
#1 MTG 5/16-18 NC
#3 MTG 5/16-18 NC
#6 MTG 3/8-16 NC

SKUS: CBH 6041-1 -1" DIA
CBH 6041-2-1-1/4" DIA
CBH 6041-3-1-1/2" DIA

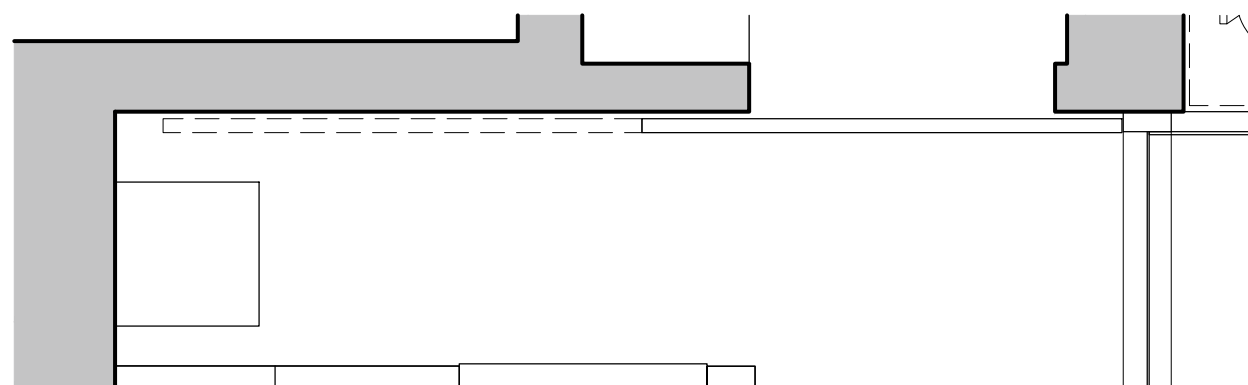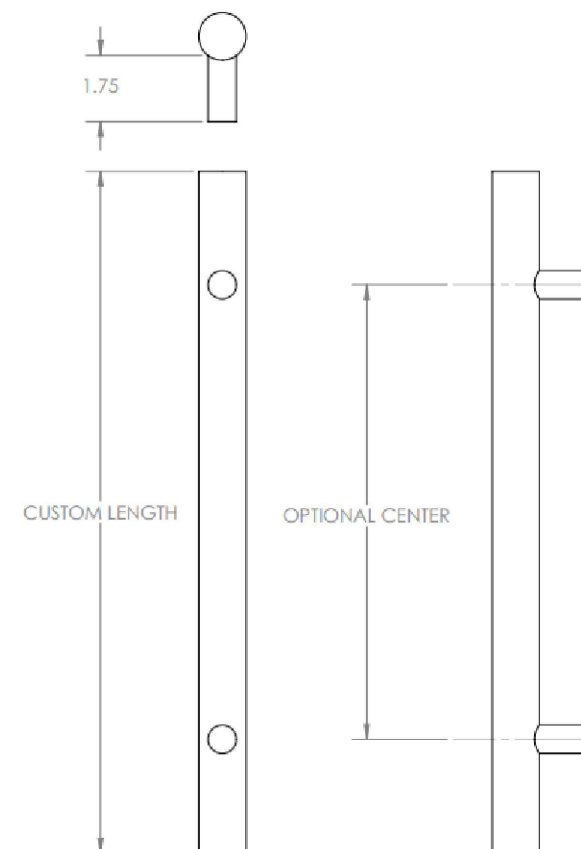

- WP-3 NATURAL WALL COVERINGS, CROWN WALLPAPER,
SG6091 - SILVER GRASSCLOTH
- WD-1 UNIBOARD, K62 FEATHER WHITE, NOBELLA FINISH
- LM-1 OCTOLUX #15-STAINLESS STEEL ALUMINUM
- ML-1 UNIBOARD 123, CHARCOAL (INTERIOR)
- SP-1 EXISITING EXPOSED CONCRETE

 FOR CONSTRUCTION AUGUST 12, 2022	REVISIONS:	All site measurements must be verified by the contractor. Any substitutes in materials, finishes or otherwise specified items are not acceptable without written approval of the designer. This document and all associated documents are prepared for a specific site and event, and incorporate calculations and measurements available from the client at the time of drafting. The contents of this document are not to be reproduced or copied in whole or part without the written permission of Fleur-de-Lis Interior Design Inc. It is the responsibility of the contractor to build in compliance to and abide by all pertainable building codes. Copyright © 2015	 Fleur-de-lis interior design inc. 294 Eglinton Ave W Toronto, ON M4R 1B2 Voice: (416) 929-8599 Fax: (416) 929.8535 www.fleurdelis.ca consults@fleurdelis.ca	PROJECT NAME: 50 SOUTH POINT DRIVE, UNIT #613	103.7 ID
				SHEET TITLE: MAIN BEDROOM ELEVATIONS	
				SCALE: 1/2"=1'-0" LAST DRAWN AUGUST 12, 2022 DRAWN BY: PM	