

CONTINUUM UNIT 2901

I KITCHEN I OFFICE I CLOSETS I VANITIES I

50 S. POINTE DR, 2901, MIAMI BEACH FL 33139

WESTHAVEN CONSTRUCTION | 305.556.1416 | joelalonso@westhaven.com

CLIENT APPROVED


DRAWINGS ☐
NOTES ☐
DATE: _____
SIGNATURE: _____

REVISION LOG

1.0	03/30/2026
2.0	05/12/2026
3.0	05/13/2026
4.0	05/19/2026
5.0	06/02/2026
6.0	06/09/2026
7.0	06/16/2026
8.0	06/30/2026
9.0	07/06/2026
10.0	07/14/2026

SCOPE

GROUND FLOOR	
#	AREA
1	KITCHEN
2	BATHROOM 3
3	CLOSET 3
4	TV UNIT BEDROOM 2
5	CLOSET 2
6	POWDER
7	TV UNIT MASTER
8	OFFICE
9	BATHROOM 2
10	HER CLOSET
11	HIS CLOSET
12	MASTER BATHROOM

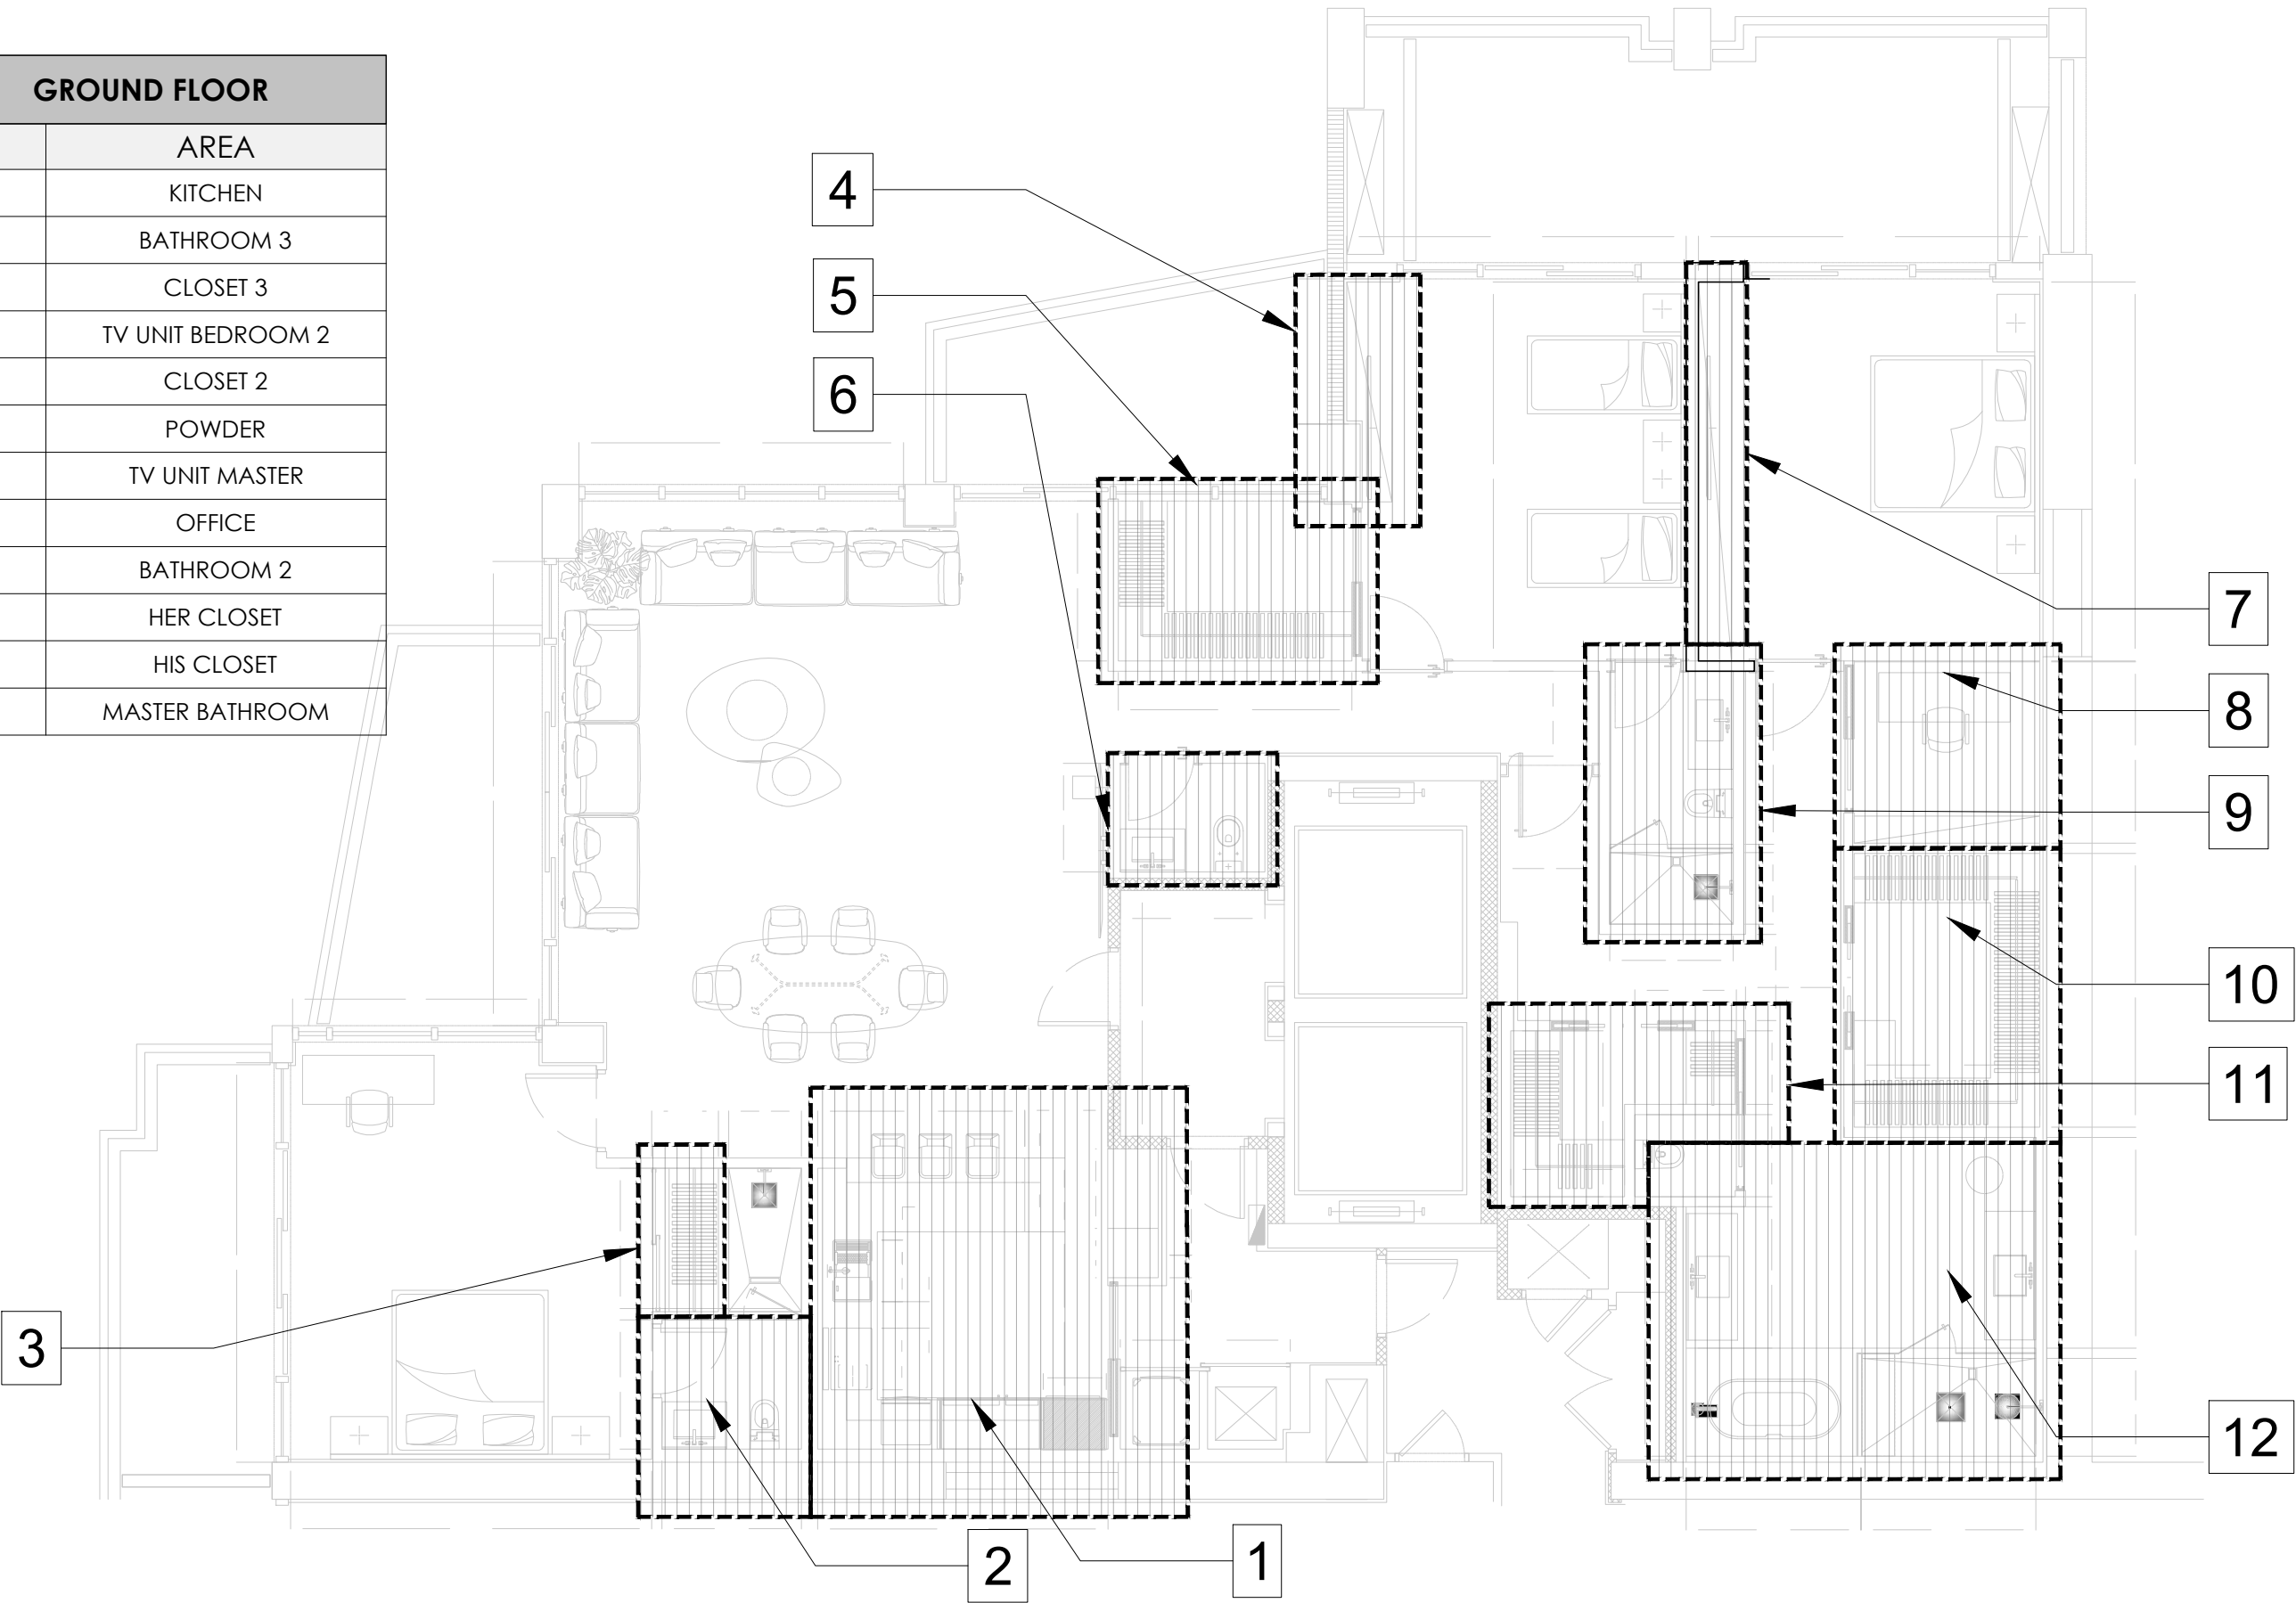

PROJECT # 0000-000

CONTINUUM NORTH

KITCHEN - OFFICE - CLOSETS - VANITIES

NOTES:

CLIENT APPROVED

DRAWINGS ☐

NOTES ☐

DATE: _____

SIGNATURE: _____

REVISION LOG

1.0	03/30/2026
2.0	05/12/2026
3.0	05/13/2026
4.0	05/19/2026
5.0	06/02/2026
6.0	06/09/2026
7.0	06/16/2026
8.0	06/30/2026
9.0	07/06/2026
10.0	07/14/2026

DATE: 07/14/2026

REV: 9.0

DIMENSION: CM/INCH

DRAWN BY: KVA

APPLIANCES

QTY	SIZE	MODEL	CUSTOM PANEL	BY CLIENT
1	30"	SUBZERO DESIGNER COLUMN REFRIGERATOR MODEL DEC3050RR - PANEL READY BY CLIENT	x	x
1	18"	SUBZERO DESIGNER COLUMN FREEZER WITH ICE MAKER MODEL DEC1850FIL - PANEL READY BY CLIENT	x	x
1	30"	MIELE CONVECTION OVEN H 7880 MODEL H7880BPXGRGR BY CLIENT		x
1	30"	MIELE SPEED OVEN MODEL H 7870BMXGRGR BY CLIENT		x
1	30"	MIELE INDUCTION COOKTOP MODEL KM 7730 FR BY CLIENT		x
1	30"	FALMEC VALENTINA MODEL FIVAL28B5SSR1 BY CLIENT		x
1	24"	MIELE DISHWASHER MODEL G 5051 SCVI ADA BY CLIENT	x	x
1	24"	MIELE MASTER COOL WINE MODEL KWT2662VIS BY CLIENT	x	x



REFRIGERATOR
SUB ZERO DESIGNER COLUMN REFRIGERATOR
DEC3050RR



FREEZER
SUB ZERO DESIGNER COLUMN FREEZER
DEC1850FIL



OVEN
MIELE CONVECTION OVEN
H 7880 BPXGRGR



SPEED OVEN
MIELE SPEED OVEN
H 7880 BMXGRGR



COOKTOP
MIELE INDUCTION COOKTOP
KM 7730 FR



HOOD
FALMEC VALENTINA
FIVAL28B5SSR1



DISHWASHER
MIELE ADA DISHWASHER
G 5051 SCVI ADA



WINE COOLER
MIELE MASTER COOL WINE
KWT2662VIS

PROJECT # 0000-000

CONTINUUM NORTH

KITCHEN - OFFICE - CLOSETS - VANITIES

NOTES:

CLIENT APPROVED

DRAWINGS☐

NOTES☐

DATE:

SIGNATURE:

REVISION LOG

1.0	03/30/2026
2.0	05/12/2026
3.0	05/13/2026
4.0	05/19/2026
5.0	06/02/2026
6.0	06/09/2026
7.0	06/16/2026
8.0	06/30/2026
9.0	07/06/2026
10.0	07/14/2026

DATE: 07/14/2026

REV: 9.0

DIMENSION: CM/INCH

DRAWN BY: KVA

KITCHEN


DETAILS

FINISH 1




ASTER
OAK WOOD VENEER - W30 ROVERE GRIGIO LAPIS

FINISH 2

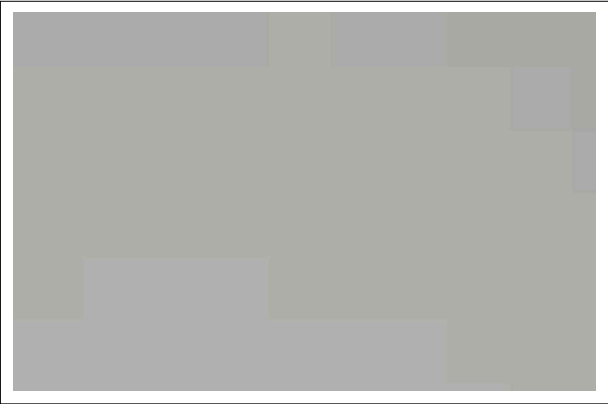


ASTER
ACCIAIO AC1 FINTURA SATINATO

HANDLE COLOR

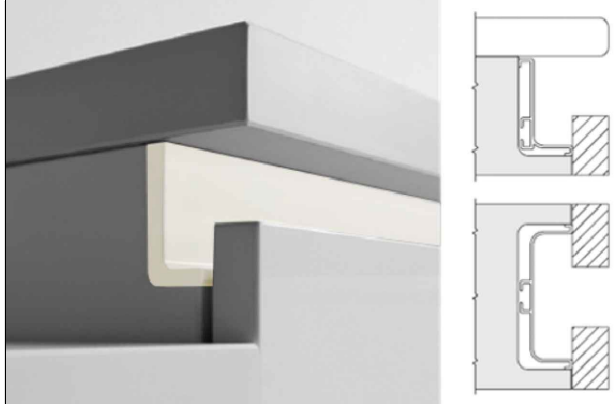


BASE CABINETS
INTEGRATED GOLA C CHANNEL - BLACK

TOE KICK

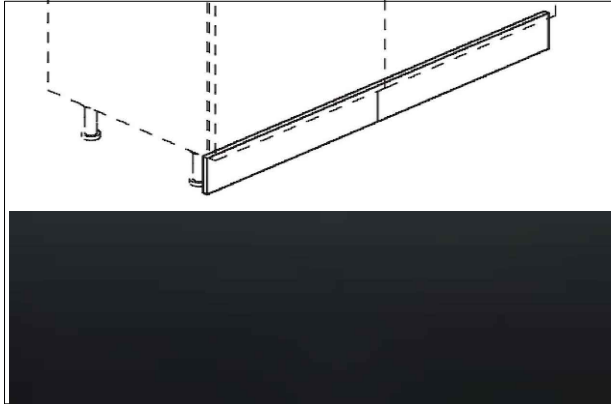

BASE CABINETS
TOE KICK 10CM - BLACK

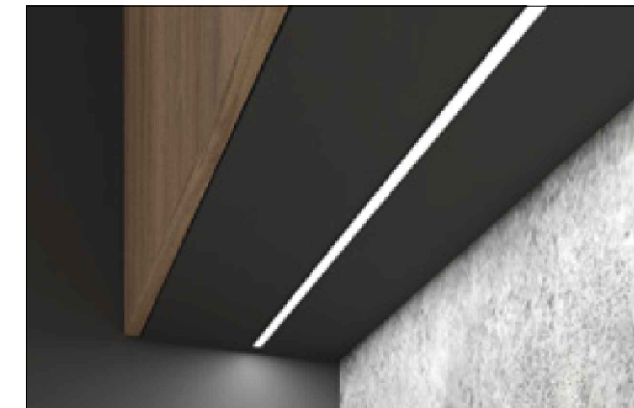

LED LIGHTS
INTEGRATED LED LIGHTS UNDER WALL CABINETS



DRAWERS
BLUM LEGRABOX



PULL OUT
TRASH BIN PULL OUT



INTERNAL DRAWERS
BLUM LEGRABOX - GREY

PROJECT # 0000-000

CONTINUUM NORTH

KITCHEN - OFFICE - CLOSETS - VANITIES

NOTES:

CLIENT APPROVED

DRAWINGS ☐

NOTES ☐

DATE: _____

SIGNATURE: _____

REVISION LOG

1.0	03/30/2026
2.0	05/12/2026
3.0	05/13/2026
4.0	05/19/2026
5.0	06/02/2026
6.0	06/09/2026
7.0	06/16/2026
8.0	06/30/2026
9.0	07/06/2026
10.0	07/14/2026

DATE: 07/14/2026

REV: 9.0

DIMENSION: CM/INCH

DRAWN BY: KVA

K-D

NOTES:

!

GC WILL DROP SOFFIT

!

PENDING LIFT UP WALL CABINETS DETAIL

FLOOR PLAN


SCALE 1/2"=1'-0"

CONTINUUM NORTH UNIT / KITCHEN

| ITALKRAFT | AS

- FINISH 1
- STRUCTURE
- DRAWER
- HANDLE
- TOE KICK
- LIGHTS
- OAK WOOD VENEER - W30 ROVERE GRIGIO LAPIS
- 18mm - GRAFFITE
- BLUM LEGRABOX - GREY
- INTEGRATED GOLA CHANNEL - BLACK
- 10CM - BLACK
- LED LIGHTS UNDER WALL CABINET 3000K

- FINISH 2
- FINISH 3
- UPPER CABINETS STAINLESS STEEL - ACCIAIO AC1 FINUTURA SATINATO
- STONE - COLOR TBD - BY CLIENT

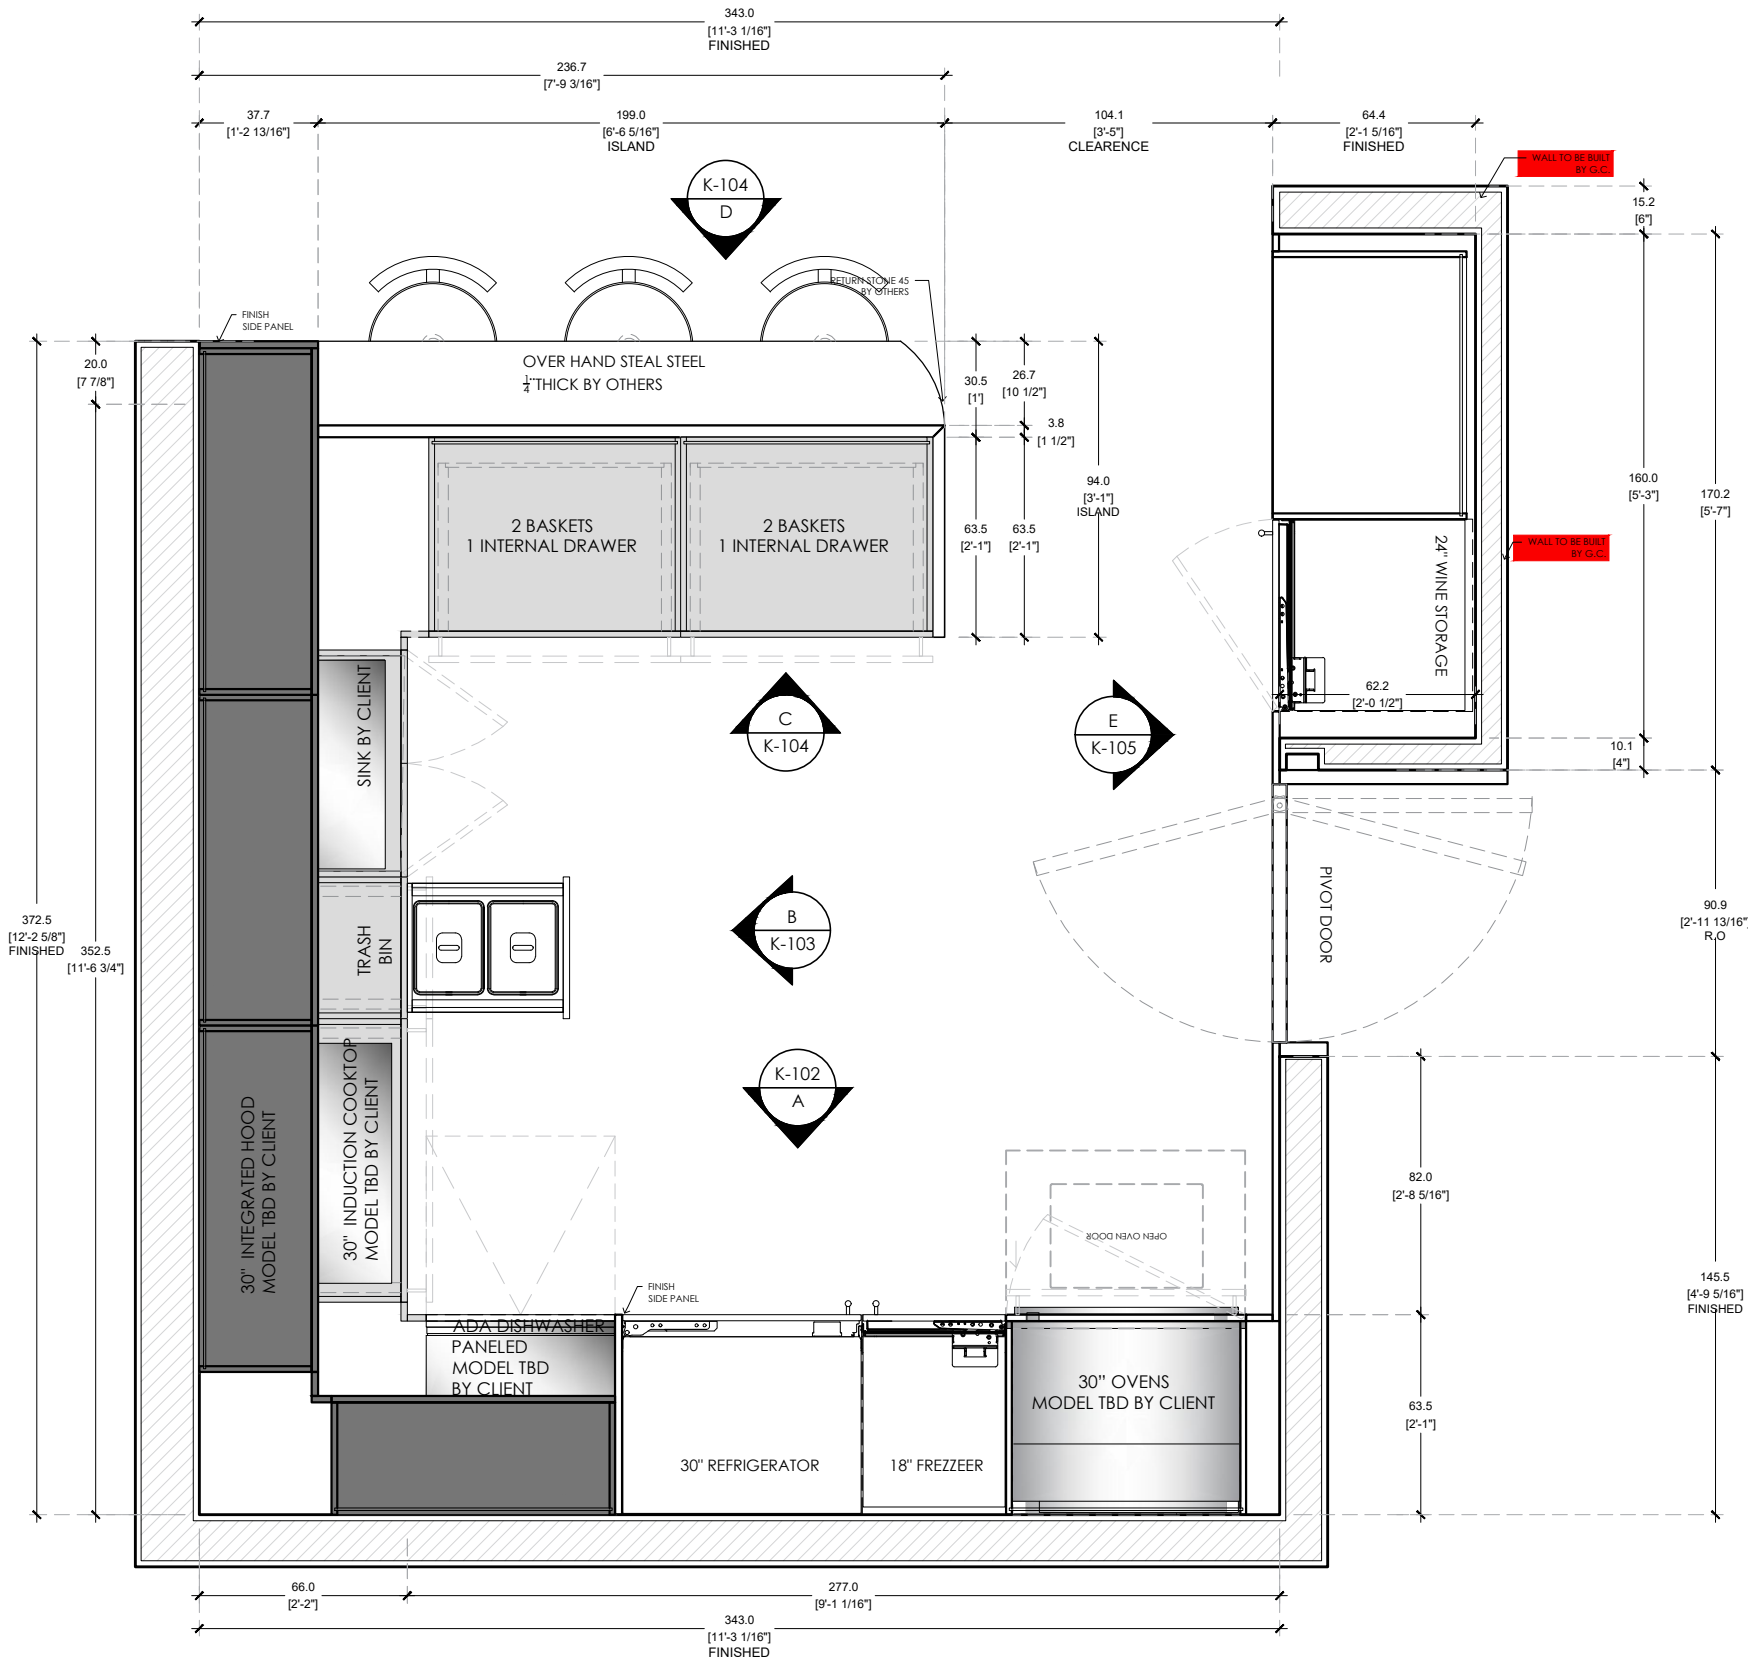

ITALKRAFT

KITCHENS | BATHS | CLOSETS

2900 NW 77TH CT. MIAMI FL. 33122
T. 305 406 1301 - F. 305 406 1302

PROJECT # 0000-000

CONTINUUM NORTH

KITCHEN - OFFICE - CLOSETS - VANITIES

NOTES:

CLIENT APPROVED

DRAWINGS ☐

NOTES ☐

DATE: _____

SIGNATURE: _____

REVISION LOG

1.0	03/30/2026
2.0	05/12/2026
3.0	05/13/2026
4.0	05/19/2026
5.0	06/02/2026
6.0	06/09/2026
7.0	06/16/2026
8.0	06/30/2026
9.0	07/06/2026
10.0	07/14/2026

DATE: 07/14/2026

REV: 9.0

DIMENSION: CM/INCH

DRAWN BY: KVA


NOTES:

!

GC WILL DROP SOFFIT

!

PENDING LIFT UP WALL CABINETS DETAIL

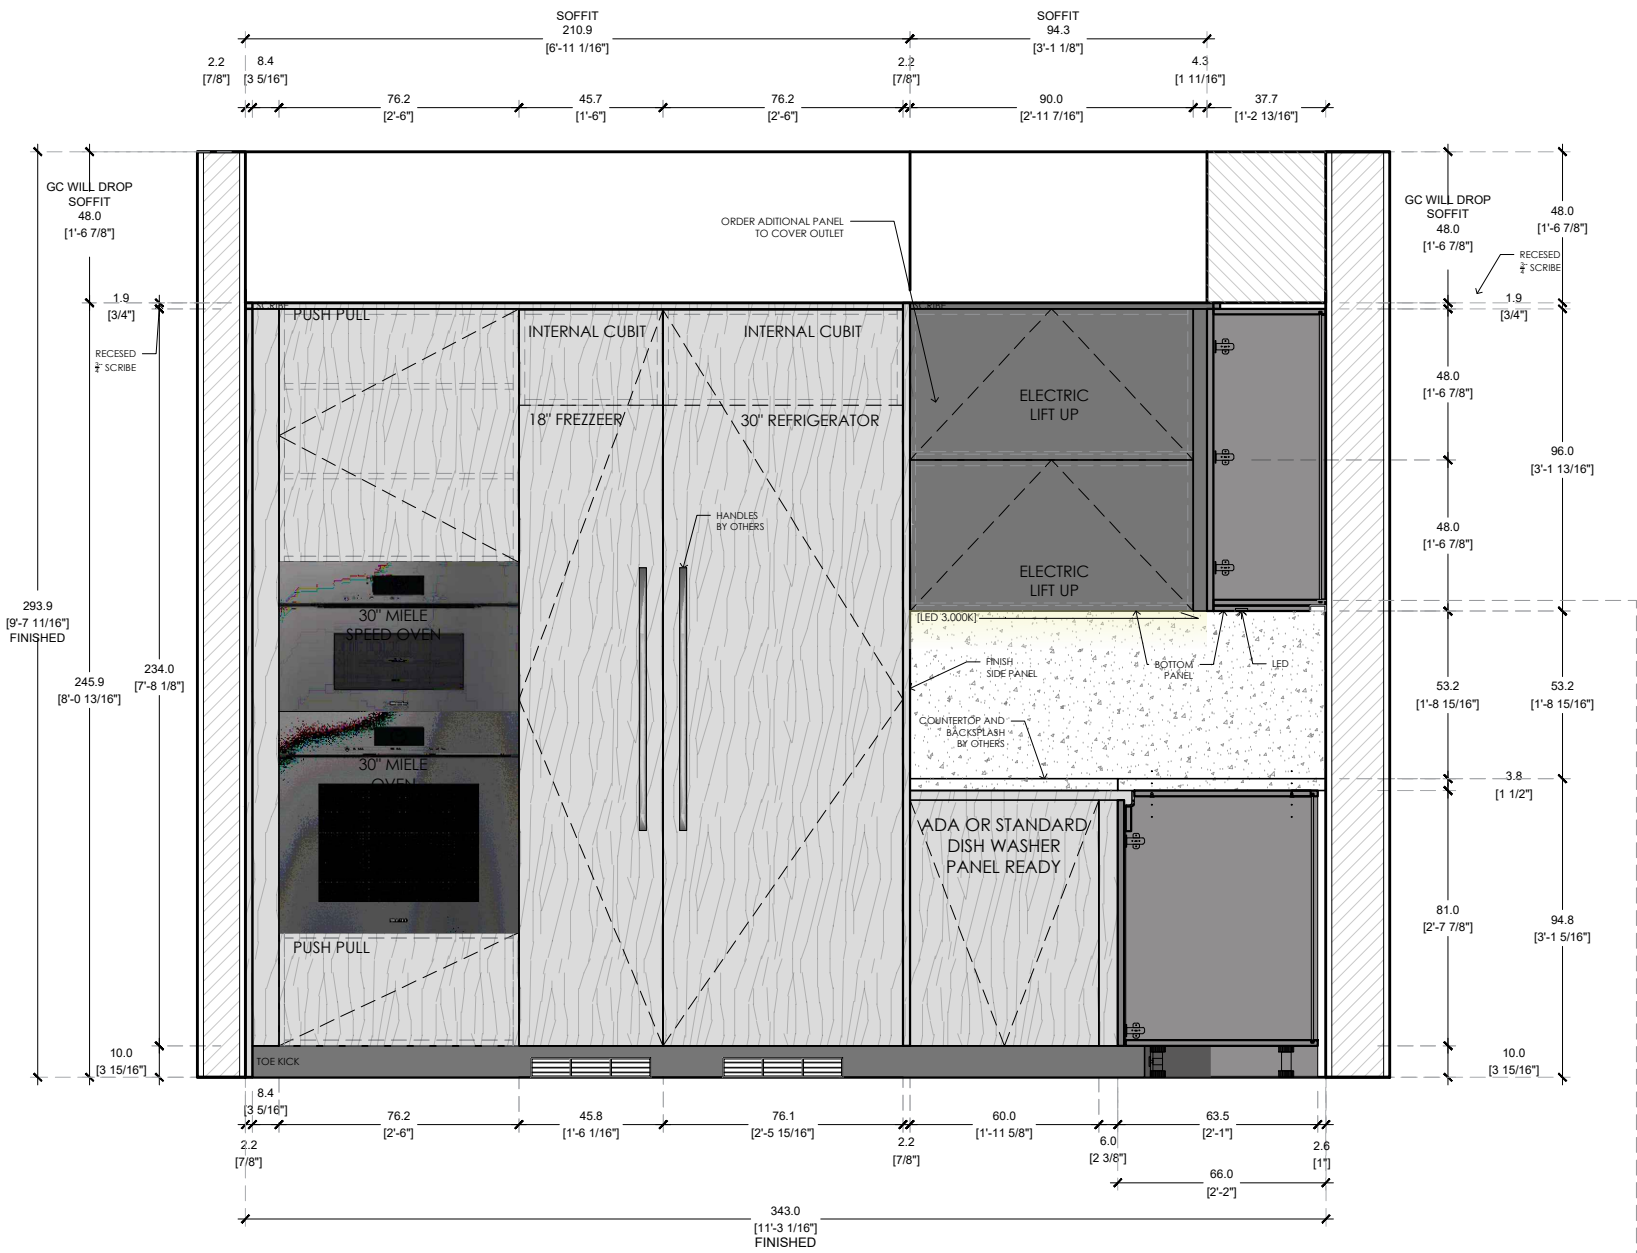

ELEVATION A

SCALE 1/2"=1'-0"

CONTINUUM NORTH UNIT / KITCHEN

| ITALKRAFT | AS

- FINISH 1
- STRUCTURE
- DRAWER
- HANDLE
- TOE KICK
- LIGHTS
- OAK WOOD VENEER - W30 ROVERE GRIGIO LAPIS
- 18mm - GRAFFITE
- BLUM LEGRABOX - GREY
- INTEGRATED GOLA CHANNEL - BLACK
- 10CM - BLACK
- LED LIGHTS UNDER WALL CABINET 3000K

- FINISH 2
- FINISH 3

UPPER CABINETS STAINLESS STEEL - ACCIAIO AC1 FINUTURA SATINATO
STONE - COLOR TBD - BY CLIENT

ITALKRAFT

KITCHENS | BATHS | CLOSETS

2900 NW 77TH CT. MIAMI FL. 33122

T. 305 406 1301 - F. 305 406 1302

PROJECT # 0000-000

CONTINUUM NORTH

KITCHEN - OFFICE - CLOSETS - VANITIES

NOTES:

CLIENT APPROVED

DRAWINGS ☐

NOTES ☐

DATE:

SIGNATURE:

REVISION LOG

1.0

03/30/2026

2.0

05/12/2026

3.0

05/13/2026

4.0

05/19/2026

5.0

06/02/2026

6.0

06/09/2026

7.0

06/16/2026

8.0

06/30/2026

9.0

07/06/2026

10.0

07/14/2026

DATE: 07/14/2026

REV: 9.0

DIMENSION: CM/INCH

DRAWN BY: KVA

K-102

NOTES:



GC WILL DROP SOFFIT




PENDING LIFT UP WALL CABINETS DETAIL

ELEVATION B SCALE 1/2"=1'-0"
CONTINUUM NORTH UNIT / KITCHEN

| ITALKRAFT | AS

- FINISH 1
STRUCTURE
DRAWER
HANDLE
TOE KICK
LIGHTS
- OAK WOOD VENEER - W30 ROVERE GRIGIO LAPIS
18mm - GRAFFITE
BLUM LEGRABOX - GREY
INTEGRATED GOLA CHANNEL - BLACK
10CM - BLACK
LED LIGHTS UNDER WALL CABINET 3000K

- FINISH 2
FINISH 3
- UPPER CABINETS STAINLESS STEEL - ACCIAIO AC1 FINUTURA SATINATO
STONE - COLOR TBD - BY CLIENT

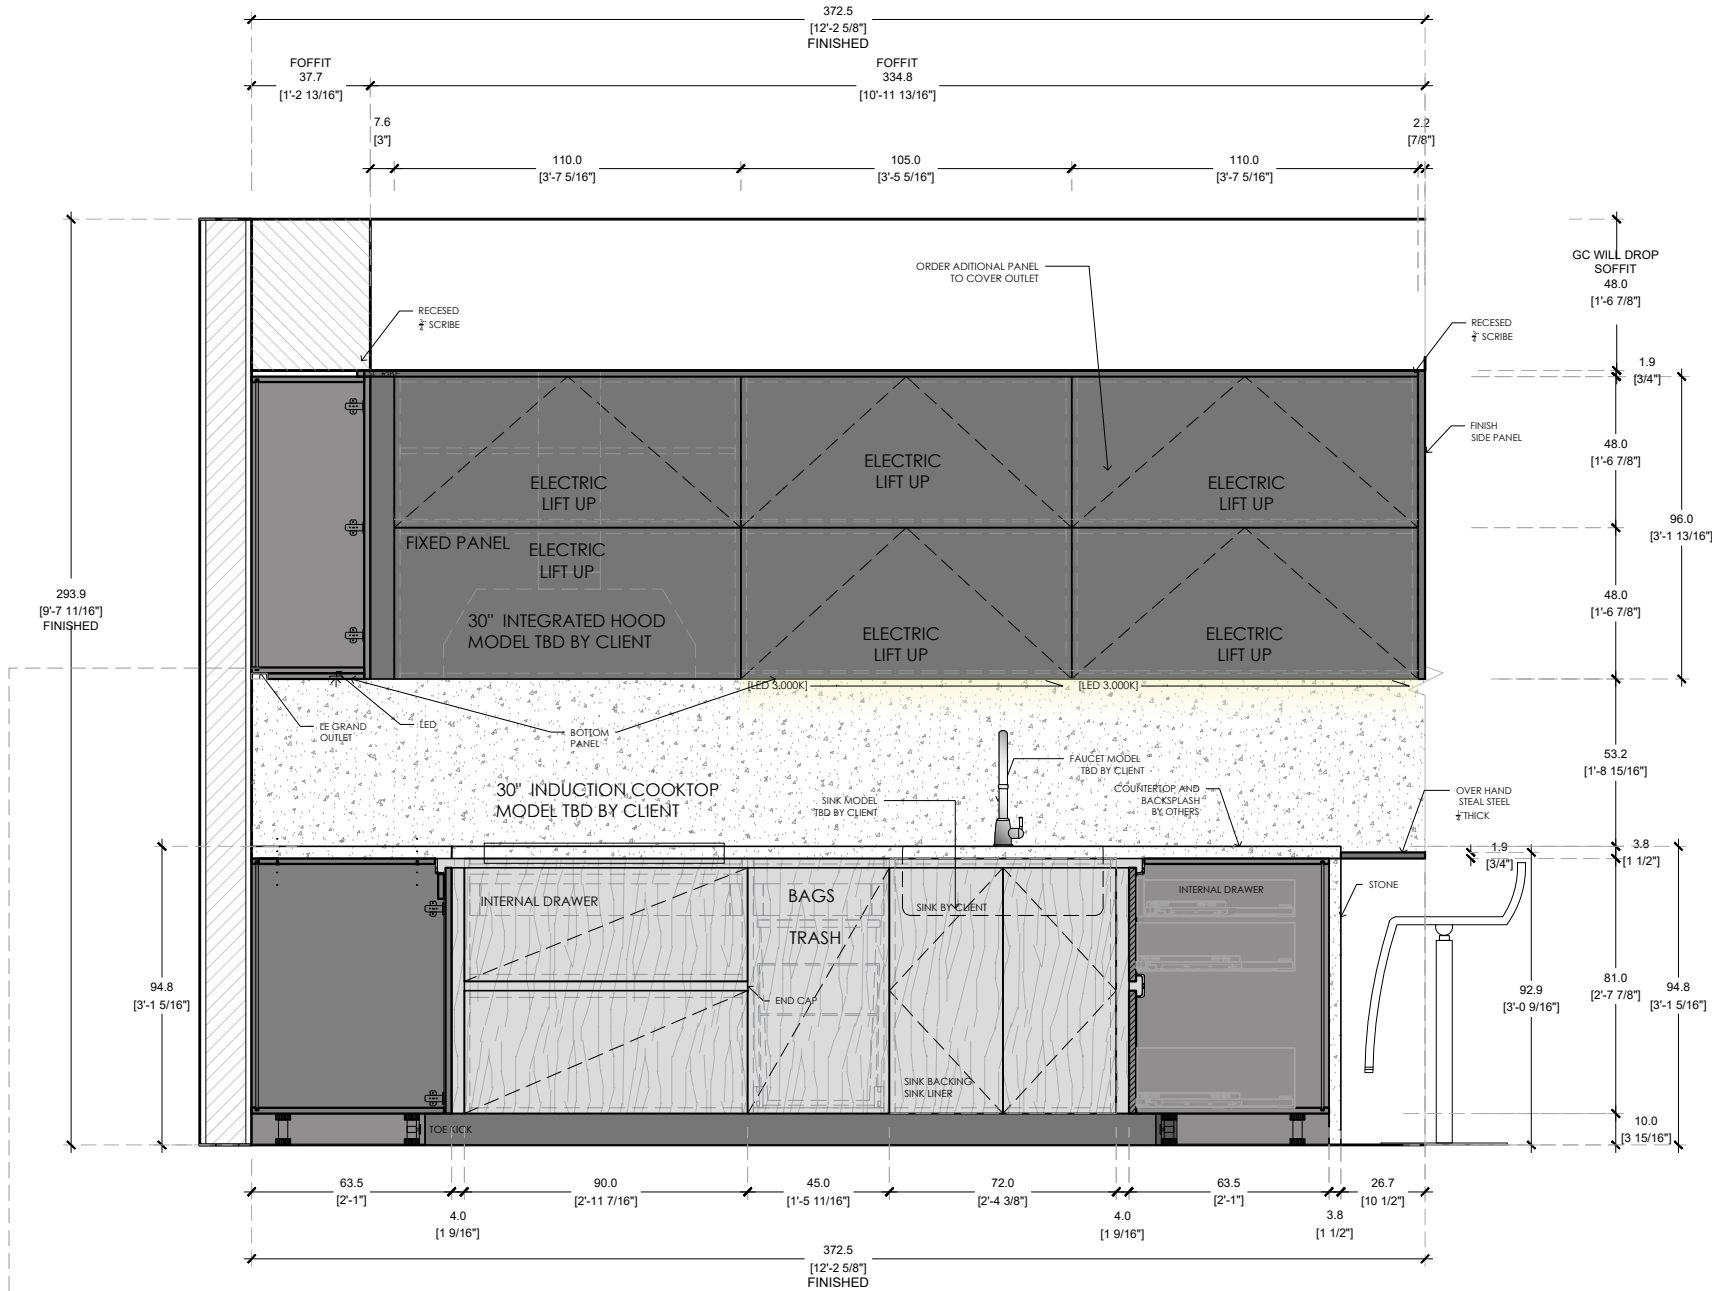

LEGRAND OUTLET



ITALKRAFT

KITCHENS | BATHS | CLOSETS

2900 NW 77TH CT. MIAMI FL. 33122
T. 305 406 1301 - F. 305 406 1302

PROJECT # 0000-000

CONTINUUM NORTH

KITCHEN - OFFICE - CLOSETS - VANITIES

NOTES:

CLIENT APPROVED

DRAWINGS ☐

NOTES ☐

DATE: _____

SIGNATURE: _____

REVISION LOG

1.0	03/30/2026
2.0	05/12/2026
3.0	05/13/2026
4.0	05/19/2026
5.0	06/02/2026
6.0	06/09/2026
7.0	06/16/2026
8.0	06/30/2026
9.0	07/06/2026
10.0	07/14/2026

DATE: 07/14/2026

REV: 9.0


DIMENSION: CM/INCH

DRAWN BY: KVA

NOTES:

⚠ GC WILL DROP SOFFIT

⚠ PENDING LIFT UP WALL CABINETS DETAIL

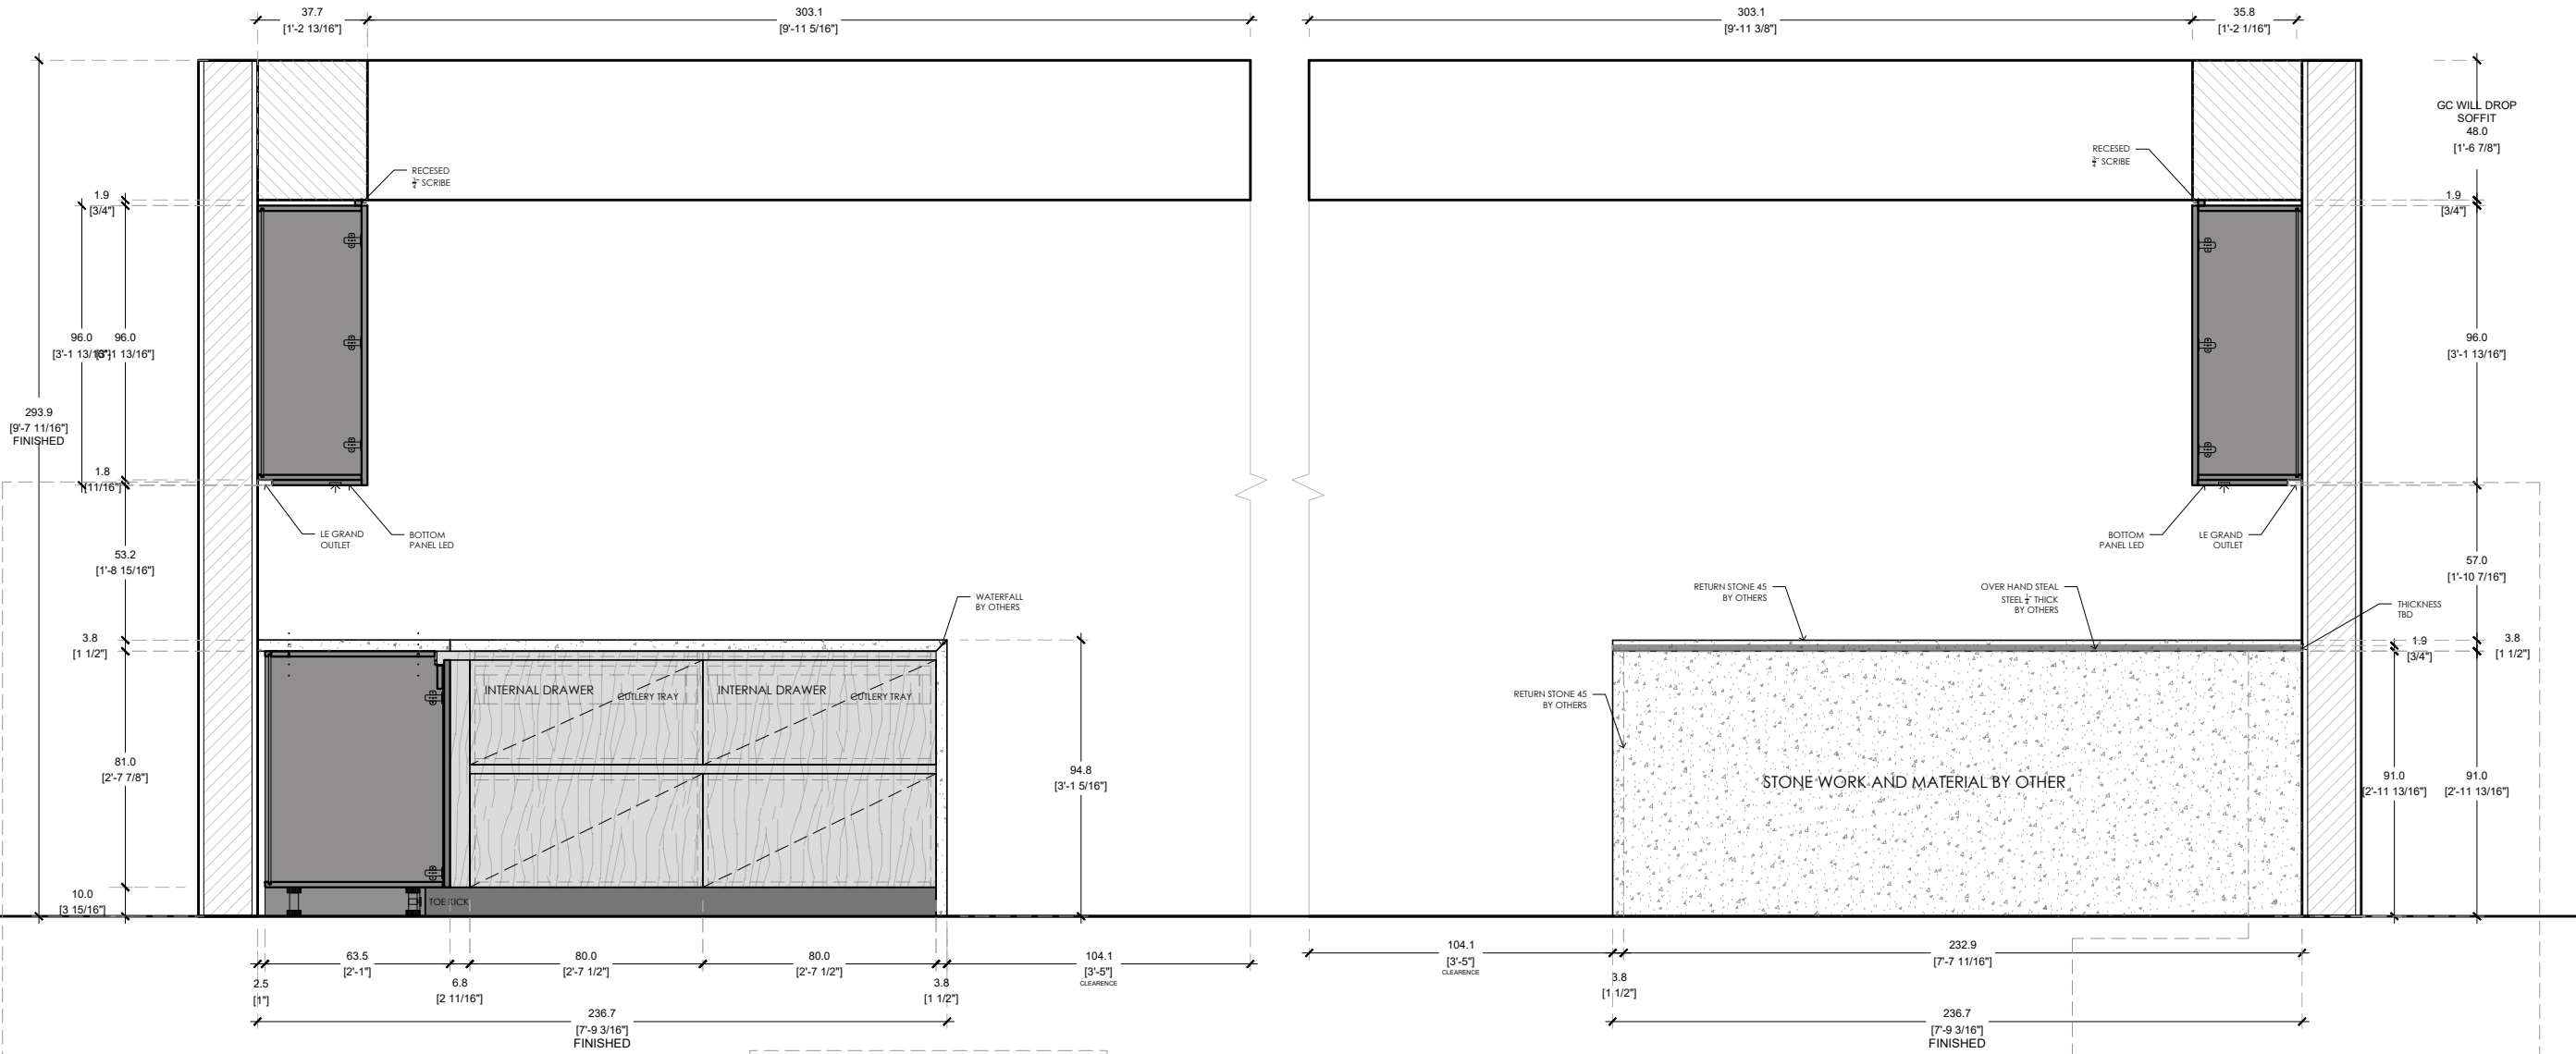

ELEVATION C SCALE 1/2"=1'-0"
CONTINUUM NORTH UNIT / KITCHEN

| ITALKRAFT | AS

LEGRAND OUTLET



ELEVATION D SCALE 1/2"=1'-0"
CONTINUUM NORTH UNIT / KITCHEN

OVER HAND STEAL



LEGRAND OUTLET



- FINISH 1 OAK WOOD VENEER - W30 ROVERE GRIGIO LAPIS
- STRUCTURE 18mm - GRAFFITE
- DRAWER BLUM LEGRABOX - GREY
- HANDLE INTEGRATED GOLA CHANNEL - BLACK
- TOE KICK 10CM - BLACK
- LIGHTS LED LIGHTS UNDER WALL CABINET 3000K

- FINISH 2
- FINISH 3

UPPER CABINETS STAINLESS STEEL - ACCIAIO AC1 FINUTURA SATINATO
STONE - COLOR TBD - BY CLIENT

PROJECT # 0000-000

CONTINUUM NORTH

KITCHEN - OFFICE - CLOSETS - VANITIES

NOTES:

CLIENT APPROVED

DRAWINGS ☐
NOTES ☐
DATE:
SIGNATURE:

REVISION LOG

1.0	03/30/2026
2.0	05/12/2026
3.0	05/13/2026
4.0	05/19/2026
5.0	06/02/2026
6.0	06/09/2026
7.0	06/16/2026
8.0	06/30/2026
9.0	07/06/2026
10.0	07/14/2026

DATE: 07/14/2026
REV: 9.0
DIMENSION: CM/INCH
DRAWN BY: KVA


NOTES:

⚠

GC WILL DROP SOFFIT

⚠

PENDING LIFT UP WALL CABINETS DETAIL

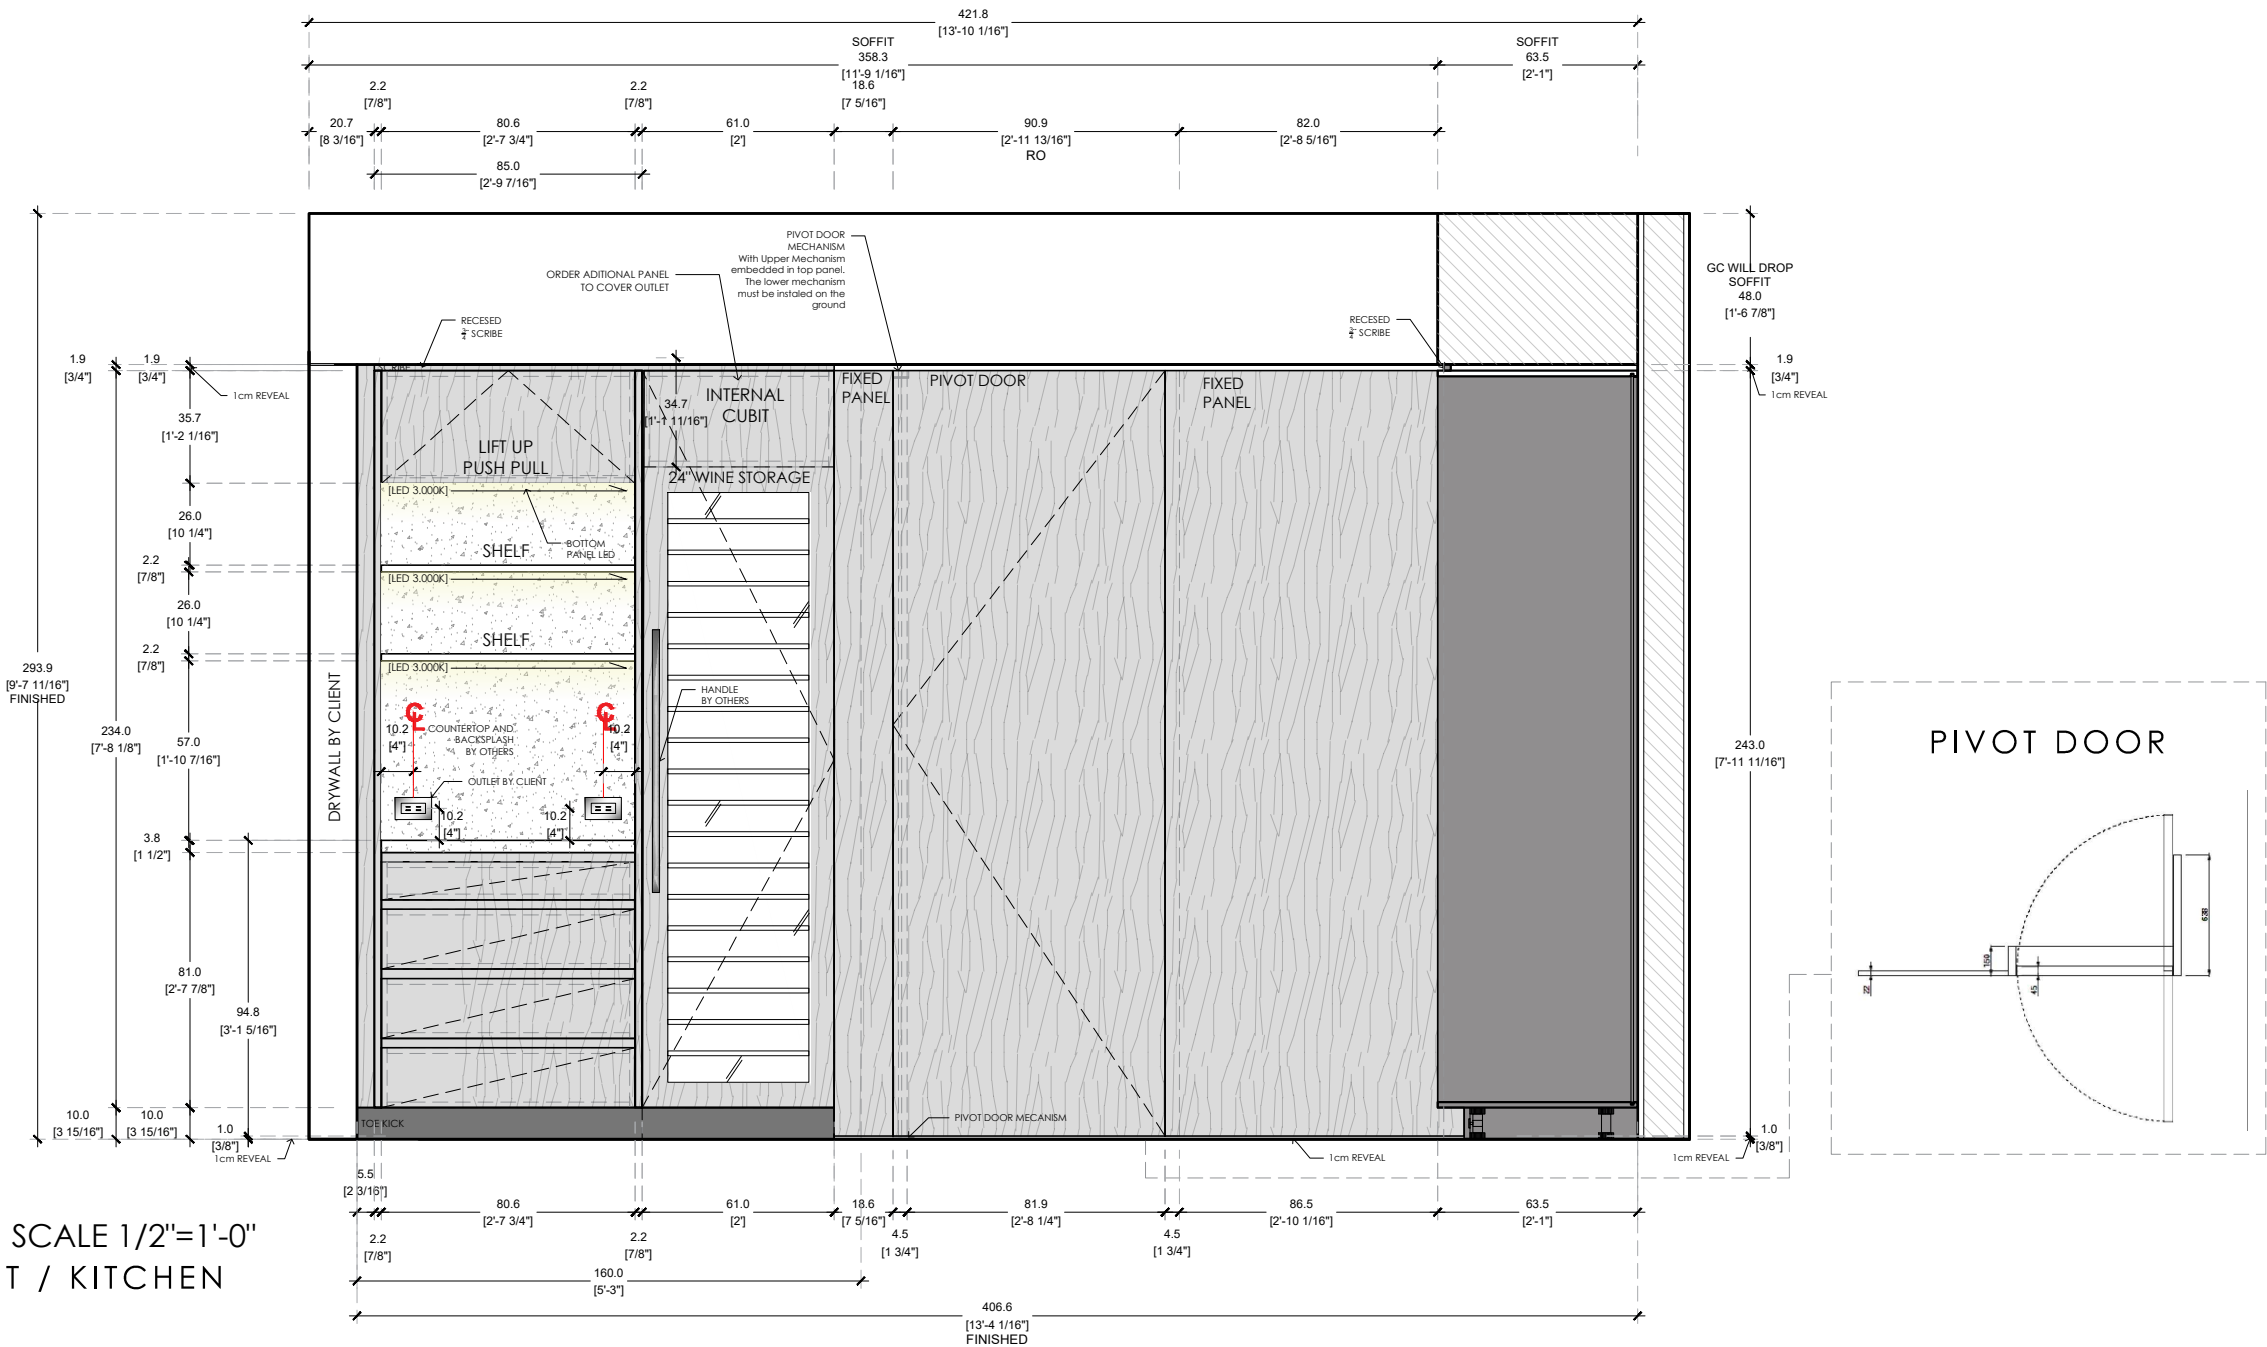

PROJECT # 0000-000
CONTINUUM NORTH
KITCHEN - OFFICE - CLOSETS - VANITIES
NOTES:

CLIENT APPROVED

DRAWINGS ☐

NOTES ☐

DATE: _____

SIGNATURE: _____

REVISION LOG

1.0	03/30/2026
2.0	05/12/2026
3.0	05/13/2026
4.0	05/19/2026
5.0	06/02/2026
6.0	06/09/2026
7.0	06/16/2026
8.0	06/30/2026
9.0	07/06/2026
10.0	07/14/2026

DATE: 07/14/2026
REV: 9.0
DIMENSION: CM/INCH
DRAWN BY: KVA

K-105

TV UNIT BEDROOM 2

DETAILS

FINISH 1



KICO
MELAMINE DOLCE MORDESCO

FINISH 2



KICO
LACQUER IVORY

FINISH 3




KICO
LINO TESSUTO - CARCASS



LED LIGHTS
INTEGRATED LED LIGHTS UNDER WALL CABINETS

HANDLE COLOR

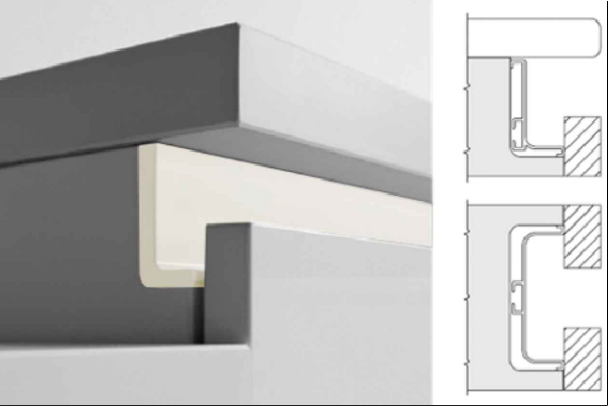

BASE CABINETS
INTEGRATED GOLA - MATCH FINISH 2



DRAWERS
BLUM LEGRABOX



INTERNAL DRAWERS
BLUM LEGRABOX - GREY

PROJECT # 0000-000

CONTINUUM NORTH

KITCHEN - OFFICE - CLOSETS - VANITIES

NOTES:

CLIENT APPROVED

DRAWINGS ☐

NOTES ☐

DATE: _____

SIGNATURE: _____

REVISION LOG

1.0	03/30/2026
2.0	05/12/2026
3.0	05/13/2026
4.0	05/19/2026
5.0	06/02/2026
6.0	06/09/2026
7.0	06/16/2026
8.0	06/30/2026
9.0	07/06/2026
10.0	07/14/2026

DATE: 07/14/2026

REV: 9.0


DIMENSION: CM/INCH

DRAWN BY: KVA

NOTES:

!

GC WILL DROP DOWN THE CEILING LIKE A SOFFIT 6"

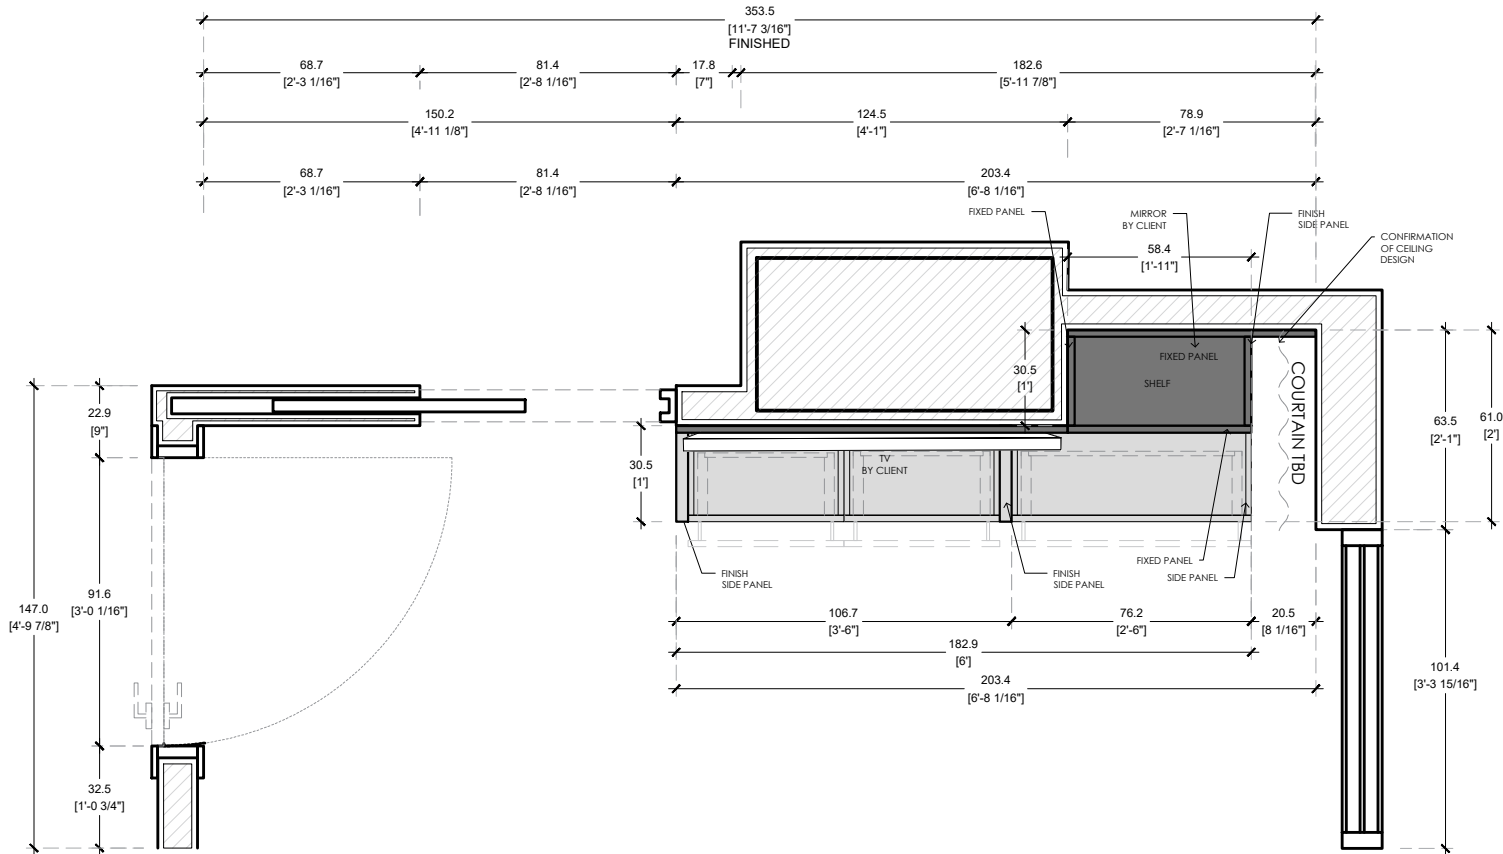

FLOOR PLAN SCALE 1/2"=1'-0"

CONTINUUM NORTH UNIT /TV UNIT BEDROOM 2

| ITALKRAFT | KC

- FINISH 1
- MELAMINE DOLCE MORDESCO
- FINISH 2
- LACQUER IVORY
- STRUCTURE
- 18mm - LINO TESSUTO
- DRAWER
- BLUM LEGRABOX - GREY
- HANDLE
- INTEGRATED GOLA CHANNEL - MATCH FINISH 2
- TOE KICK
- 5.1CM - MATCH FINISH 2
- LIGHTS
- LED LIGHTS UNDER SHELVES 3000K

ITALKRAFT

KITCHENS | BATHS | CLOSETS

2900 NW 77TH CT. MIAMI FL. 33122

T. 305 406 1301 - F. 305 406 1302

PROJECT # 0000-000

CONTINUUM NORTH

KITCHEN - OFFICE - CLOSETS - VANITIES

NOTES:

CLIENT APPROVED

DRAWINGS ☐

NOTES ☐

DATE:

SIGNATURE:

REVISION LOG

1.0

03/30/2026

2.0

05/12/2026

3.0

05/13/2026

4.0

05/19/2026

5.0

06/02/2026

6.0

06/09/2026

7.0

06/16/2026

8.0

06/30/2026

9.0

07/06/2026

10.0

07/14/2026

DATE: 07/14/2026

REV: 9.0

DIMENSION: CM/INCH

DRAWN BY: KVA


TVB2-101

NOTES:




GC WILL DROP DOWN THE
CEILING LIKE A SOFFIT 6"

BRACKET
LENGHT 6"

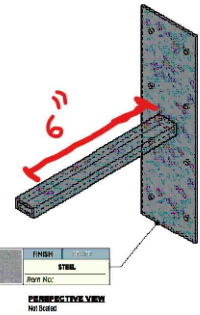

BRACKET DETAIL

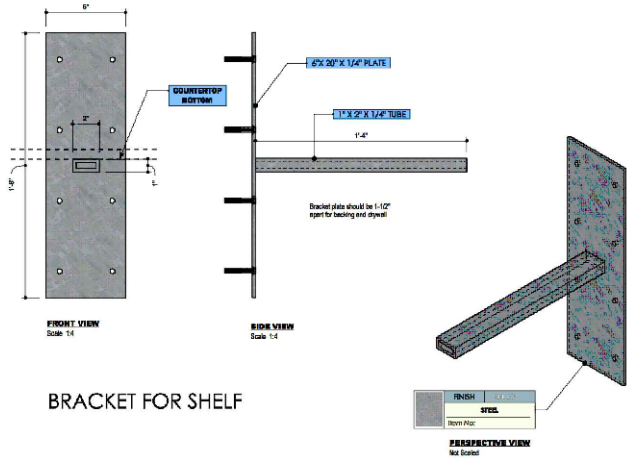


BRACKET FOR SHELF


ELEVATION A SCALE 1/2"=1'-0"
CONTINUUM NORTH UNIT / TV UNIT BEDROOM 2

| ITALKRAFT | KC

- | | |
|-----------|--|
| FINISH 1 | MELAMINE DOLCE MORDESCO |
| FINISH 2 | LACQUER IVORY |
| STRUCTURE | 18mm - LINO TESSUTO |
| DRAWER | BLUM LEGRABOX - GREY |
| HANDLE | INTEGRATED GOLA CHANNEL - MATCH FINISH 2 |
| TOE KICK | 5.1CM - MATCH FINISH 2 |
| LIGHTS | LED LIGHTS UNDER SHELVES 3000K |

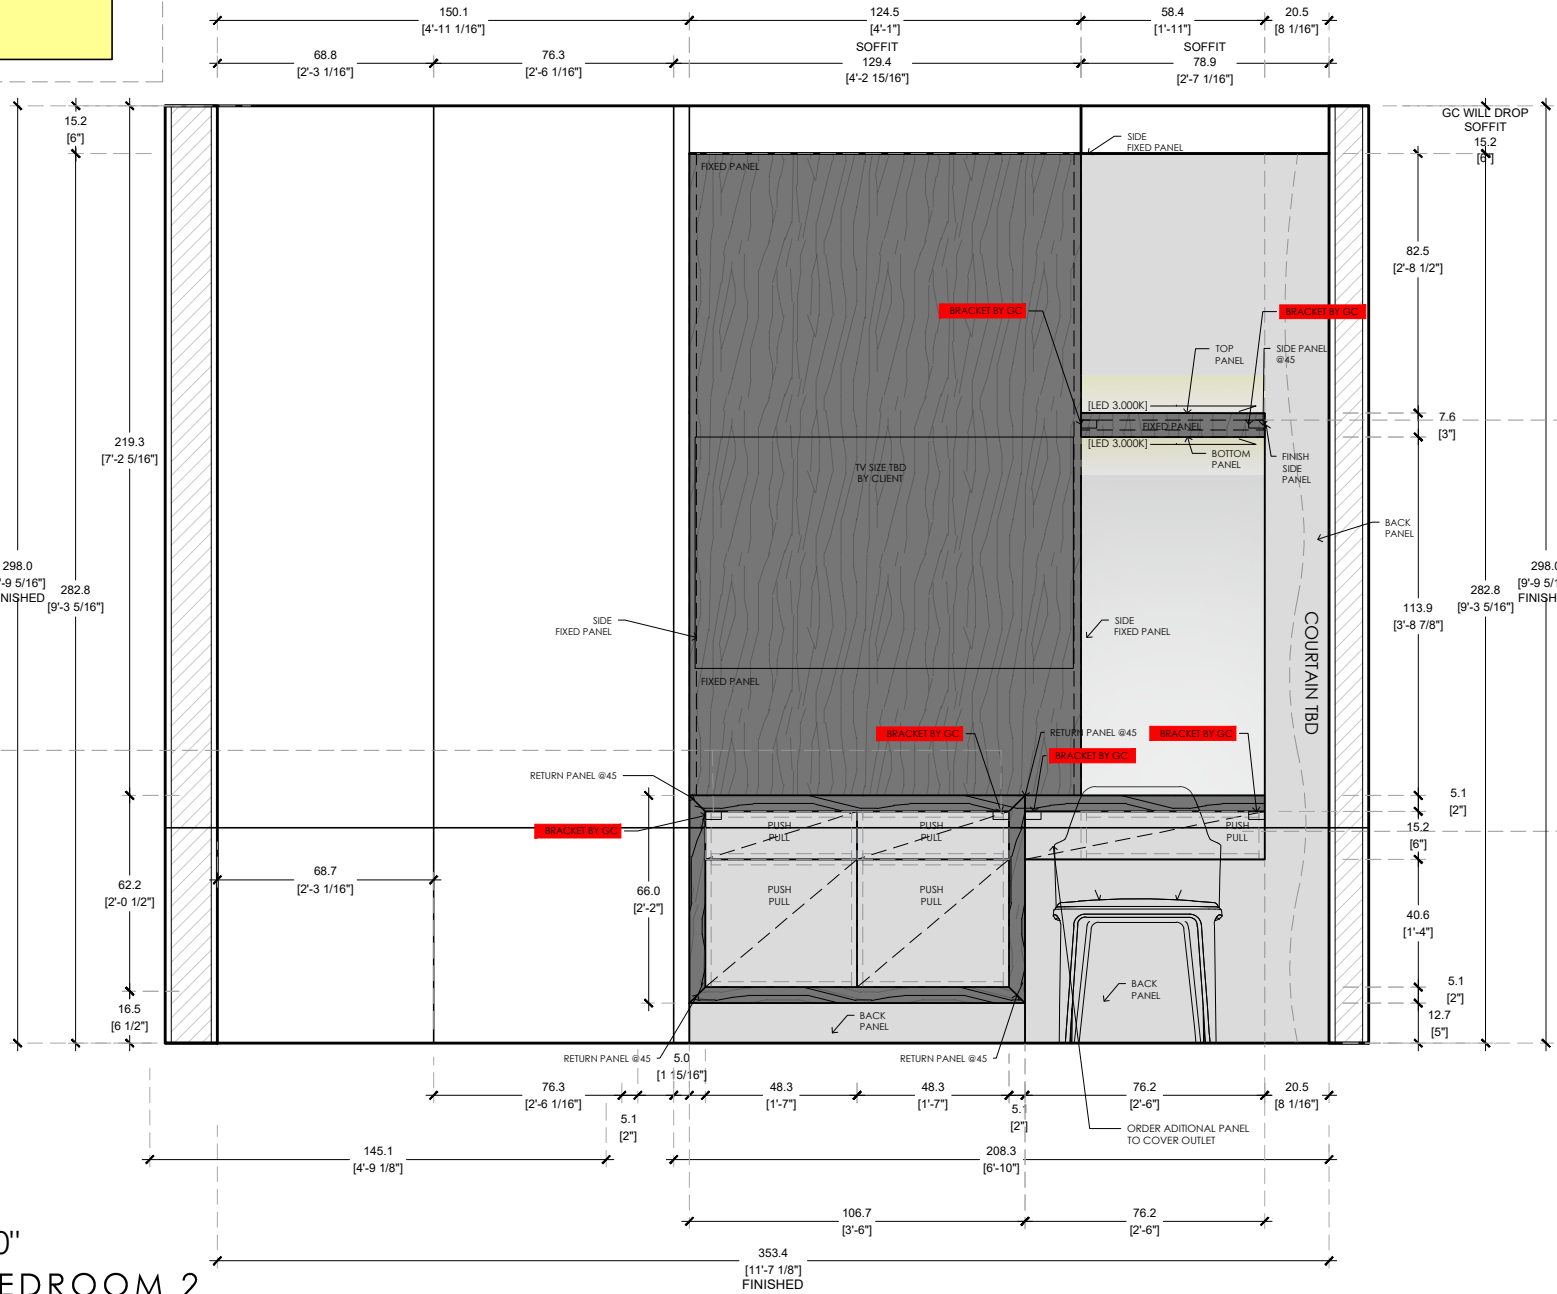

DRAWER DETAIL

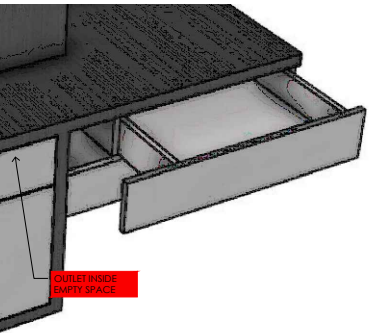

ITALKRAFT

KITCHENS | BATHS | CLOSETS

2900 NW 77TH CT. MIAMI FL. 33122
T. 305 406 1301 - F. 305 406 1302

PROJECT # 0000-000

CONTINUUM NORTH

KITCHEN - OFFICE - CLOSETS - VANITIES

NOTES:

CLIENT APPROVED

DRAWINGS ☐

NOTES ☐

DATE: _____

SIGNATURE: _____

REVISION LOG

1.0	03/30/2026
2.0	05/12/2026
3.0	05/13/2026
4.0	05/19/2026
5.0	06/02/2026
6.0	06/09/2026
7.0	06/16/2026
8.0	06/30/2026
9.0	07/06/2026
10.0	07/14/2026

DATE: 07/14/2026

REV: 9.0

DIMENSION: CM/INCH

DRAWN BY: KVA

TVB2-102

TV UNIT MASTER BEDROOM

DETAILS

FINISH 1



KICO
MELAMINE DOLCE MORDESCO

FINISH 2



KICO
LACQUER IVORY

FINISH 3




KICO
LINO TESSUTO - CARCASS




LED LIGHTS
INTEGRATED LED LIGHTS UNDER WALL CABINETS

HANDLE COLOR

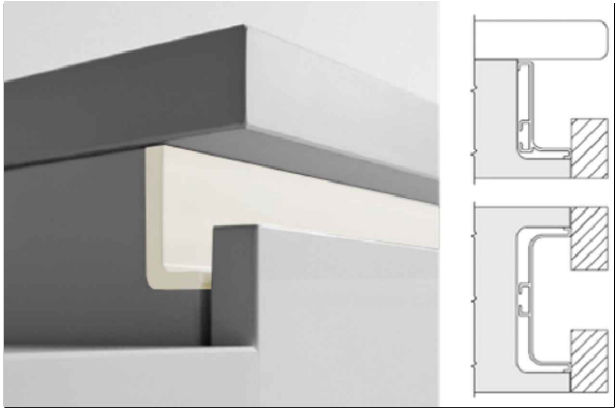

BASE CABINETS
INTEGRATED GOLA - MATCH FINISH 2

TOE KICK

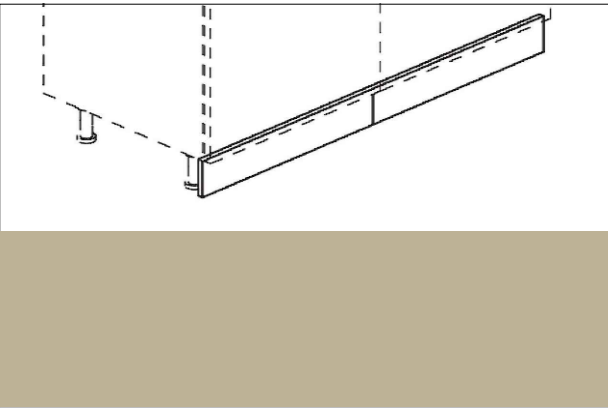

BASE CABINETS
MATCH FINISH 2



DRAWERS
BLUM LEGRABOX



INTERNAL DRAWERS
BLUM LEGRABOX - GREY

PROJECT #	0000-000
CONTINUUM NORTH	
KITCHEN - OFFICE - CLOSETS - VANITIES	
NOTES:	

CLIENT APPROVED	
DRAWINGS	☐
NOTES	☐
DATE:	
SIGNATURE:	

REVISION LOG	
1.0	03/30/2026
2.0	05/12/2026
3.0	05/13/2026
4.0	05/19/2026
5.0	06/02/2026
6.0	06/09/2026
7.0	06/16/2026
8.0	06/30/2026
9.0	07/06/2026
10.0	07/14/2026

DATE:	07/14/2026
REV:	9.0
DIMENSION:	CM/INCH
DRAWN BY:	KVA

REVISION LOG		
1.0	03/30/2026	
2.0	05/12/2026	
3.0	05/13/2026	
4.0	05/19/2026	
5.0	06/02/2026	
6.0	06/09/2026	
7.0	06/16/2026	
8.0	06/30/2026	
9.0	07/06/2026	
10.0	07/14/2026	


NOTE:



PENDING CONFIRMATION OF CEILING DESIGN




GC WILL DROP DOWN THE CEILING LIKE A SOFFIT 6"

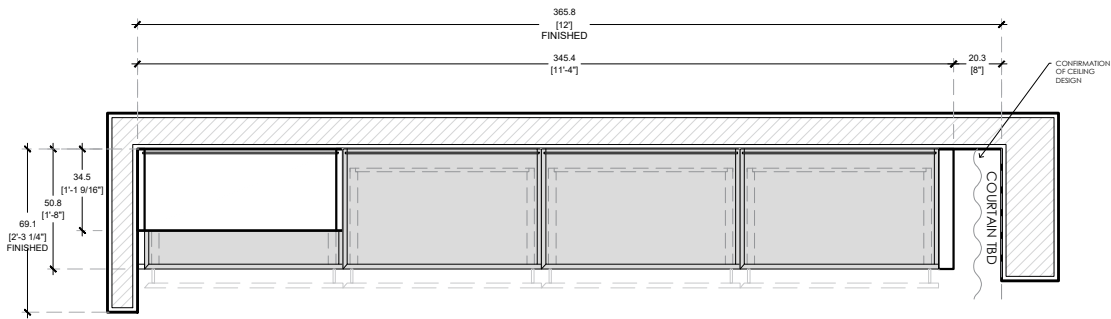

FLOOR PLAN SCALE 1/2"=1'-0"
CONTINUUM NORTH UNIT /TV UNIT MASTER BEDROOM

| ITALKRAFT | KC

- | | |
|-----------|--|
| FINISH 1 | MELAMINE DOLCE MORDESCO |
| FINISH 2 | LACQUER IVORY |
| STRUCTURE | 18mm - LINO TESSUTO |
| DRAWER | BLUM LEGRABOX - GREY |
| HANDLE | INTEGRATED GOLA CHANNEL - MATCH FINISH 2 |
| TOE KICK | 5.1CM - MATCH FINISH 2 |
| LIGHTS | LED LIGHTS UNDER SHELVES 3000K |

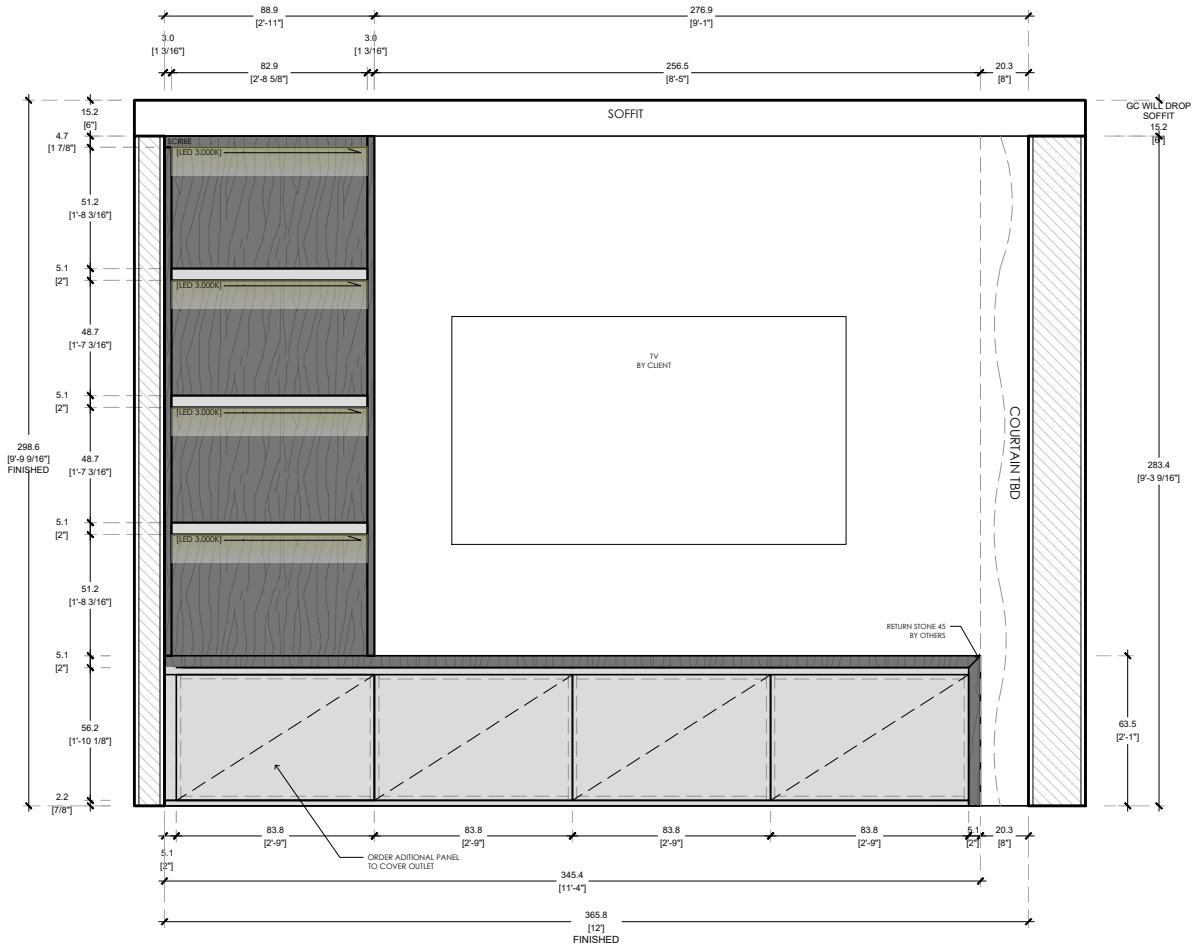

ELEVATION A SCALE 1/2"=1'-0"
CONTINUUM NORTH UNIT / TV UNIT MASTER BEDROOM

OFFICE

DETAILS

FINISH 1



KICO
MELAMINE DOLCE MORDESCO

FINISH 2



KICO
LACQUER IVORY

FINISH 3




KICO
LINO TESSUTO - CARCASS




LED LIGHTS
INTEGRATED LED LIGHTS UNDER WALL CABINETS

HANDLE COLOR

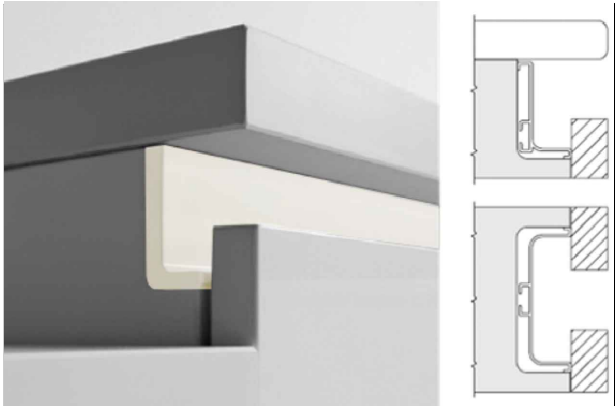

BASE CABINETS
INTEGRATED GOLA - MATCH FINISH 2

TOE KICK

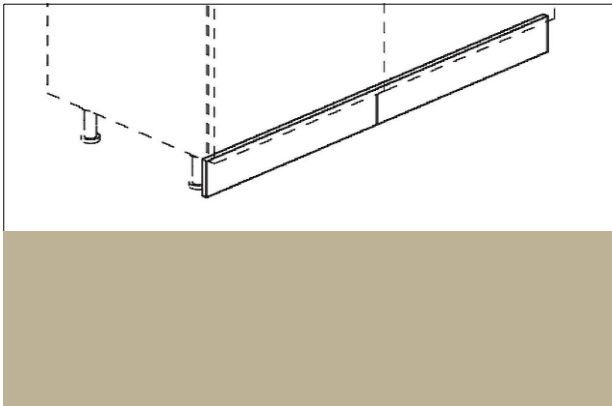

BASE CABINETS
MATCH FINISH 2



DRAWERS
BLUM LEGRABOX



INTERNAL DRAWERS
BLUM LEGRABOX - GREY

PROJECT # 0000-000

CONTINUUM NORTH

KITCHEN - OFFICE - CLOSETS - VANITIES

NOTES:

CLIENT APPROVED

DRAWINGS ☐

NOTES ☐

DATE: _____

SIGNATURE: _____

REVISION LOG

1.0	03/30/2026
2.0	05/12/2026
3.0	05/13/2026
4.0	05/19/2026
5.0	06/02/2026
6.0	06/09/2026
7.0	06/16/2026
8.0	06/30/2026
9.0	07/06/2026
10.0	07/14/2026

DATE: 07/14/2026

REV: 9.0

DIMENSION: CM/INCH

DRAWN BY: KVA

O-D


NOTES:




G.C. WILL DROP SOFFIT




WALL TO BE BUILD BY G.C.

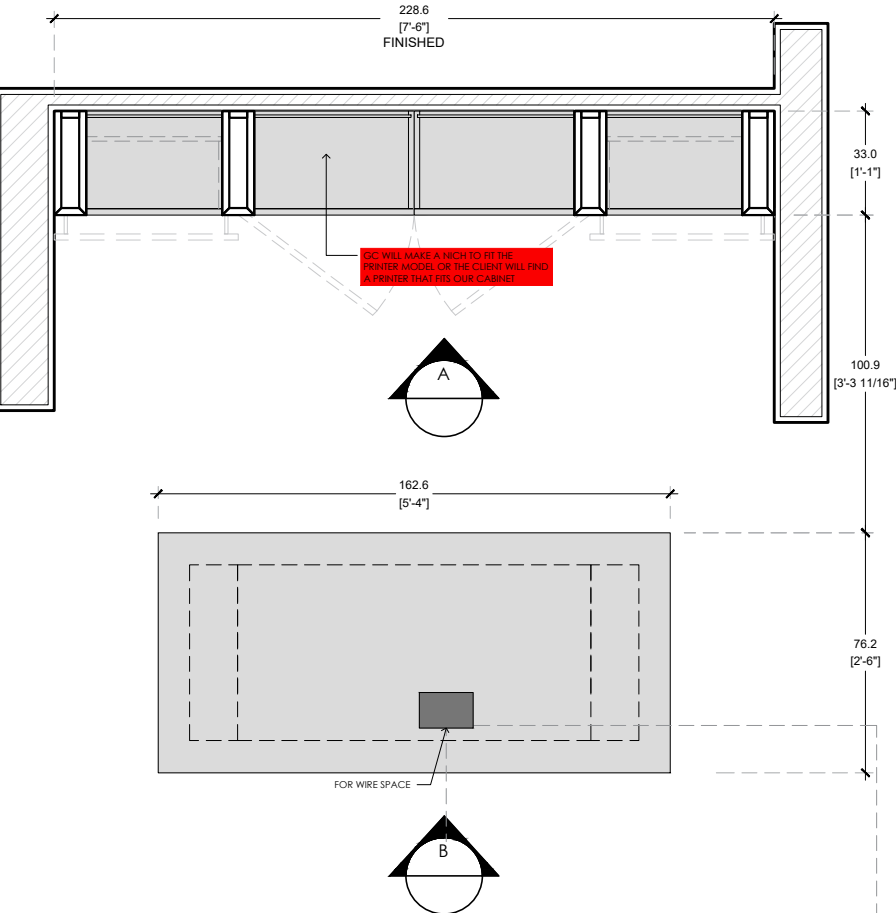

FLOOR PLAN SCALE 1/2"=1'-0"
CONTINUUM NORTH UNIT /OFFICE

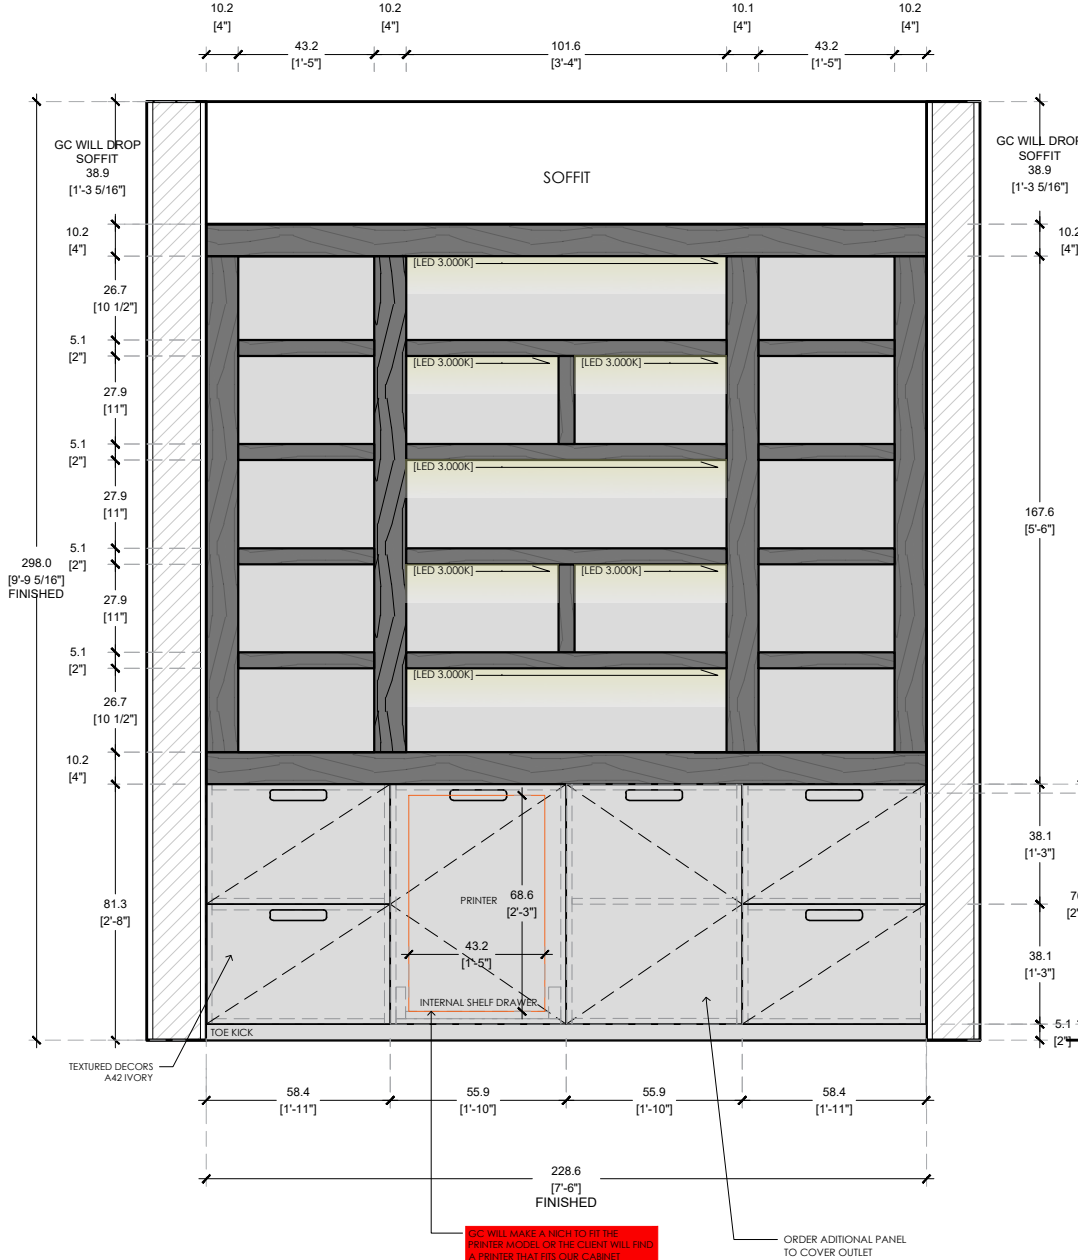


ELEVATION A SCALE 1/2"=1'-0"
CONTINUUM NORTH UNIT /OFFICE

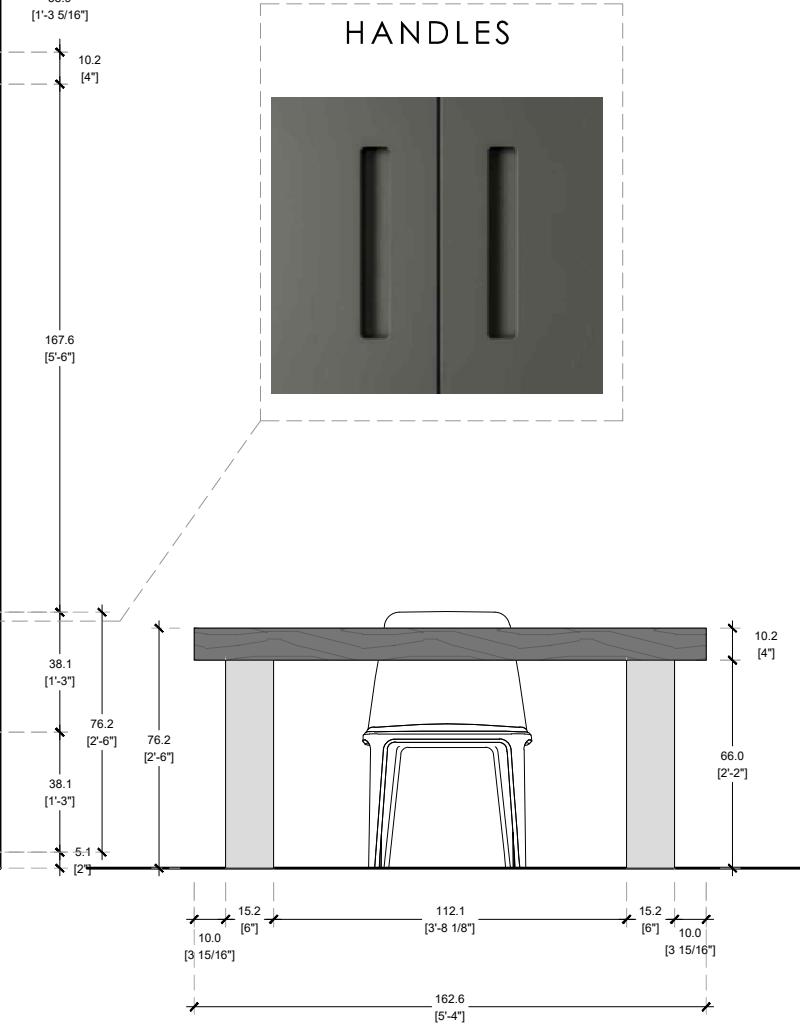

ELEVATION B SCALE 1/2"=1'-0"
CONTINUUM NORTH UNIT /OFFICE

DETAIL REFERENCE
POP OUT OUTLET BY G.C.

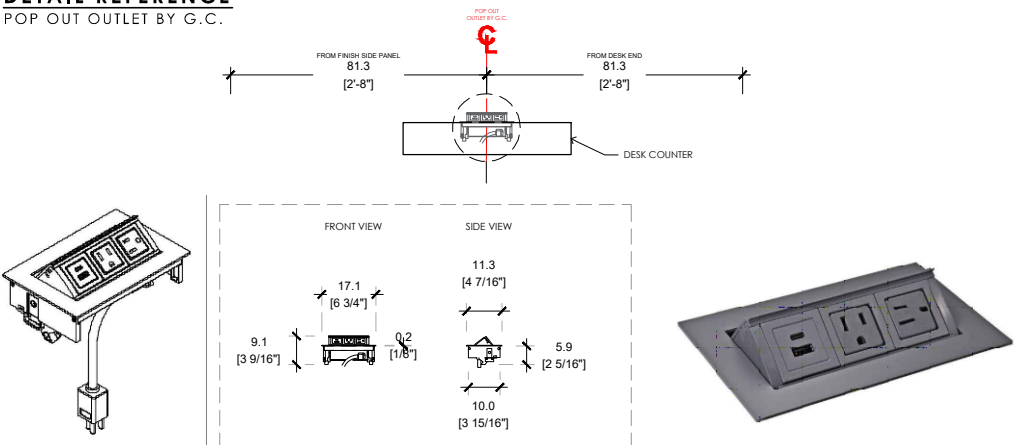

- FINISH 1

FINISH 2

STRUCTURE

DRAWER

HANDLE

TOE KICK

LIGHTS
- MELAMINE DOLCE MORDESCO
LACQUER IVORY

18mm - LINO TESSUTO

BLUM LEGRABOX - GREY

INTEGRATED GOLA CHANNEL - MATCH FINISH 2

5.1CM - MATCH FINISH 2

LED LIGHTS UNDER SHELVES 3000K

ITALKRAFT

KITCHENS | BATHS | CLOSETS
2900 NW 77TH CT. MIAMI FL. 33122
T. 305 406 1301 - F. 305 406 1302

PROJECT # 0000-000
CONTINUUM NORTH
KITCHEN - OFFICE - CLOSETS - VANITIES
NOTES:

CLIENT APPROVED

DRAWINGS ☐
NOTES ☐
DATE: _____
SIGNATURE: _____


REVISION LOG		
1.0	03/30/2026	
2.0	05/12/2026	
3.0	05/13/2026	
4.0	05/19/2026	
5.0	06/02/2026	
6.0	06/09/2026	
7.0	06/16/2026	
8.0	06/30/2026	
9.0	07/06/2026	
10.0	07/14/2026	

DATE: 07/14/2026
REV: 9.0
DIMENSION: CM/INCH
DRAWN BY: KVA

CLOSET - BEDROOM 3

DETAILS

FINISHES

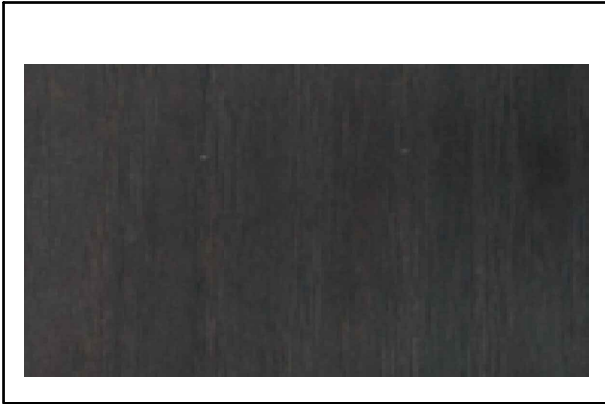


FINISH 1
MELAMINE DOLCE MORDESCO

FINISHES




FINISH 2
LINO TESSUTO

HANDLE STYLES

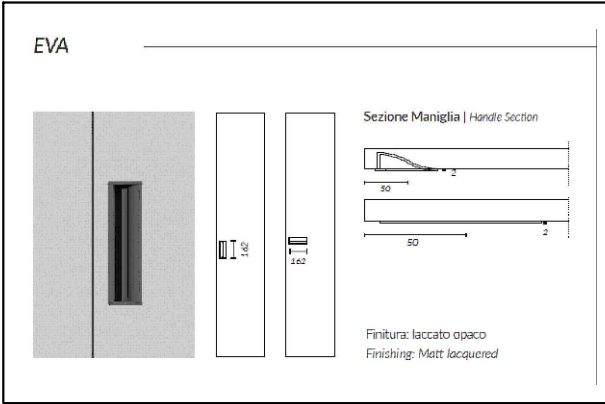


HANDLE DRAWERS
EVA

DRAWERS

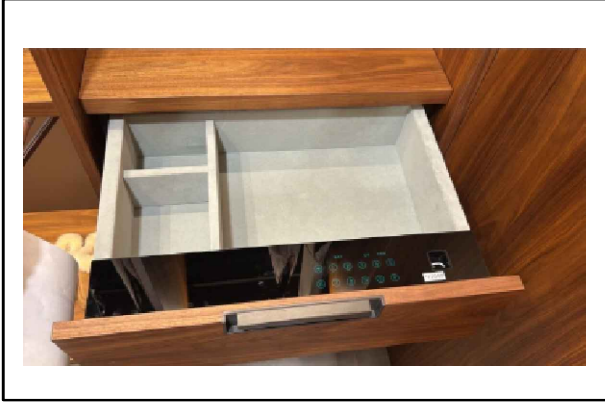


DRAWERS
DRAWER SAFE ALL WALKING CLOSET

ROD

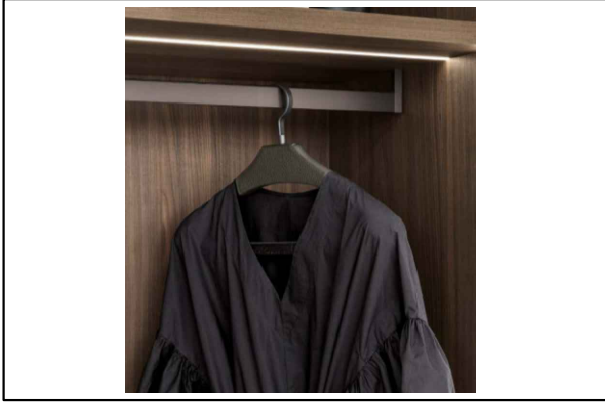


ROD
HANGING ROD

DOORS

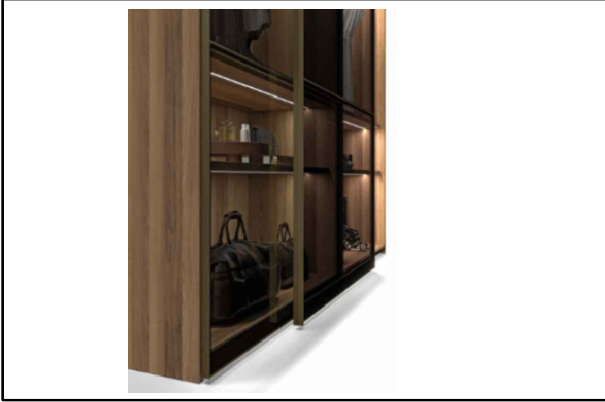


SLIDING DOORS
SLIDING MODEL VITRUM

LIGHTS

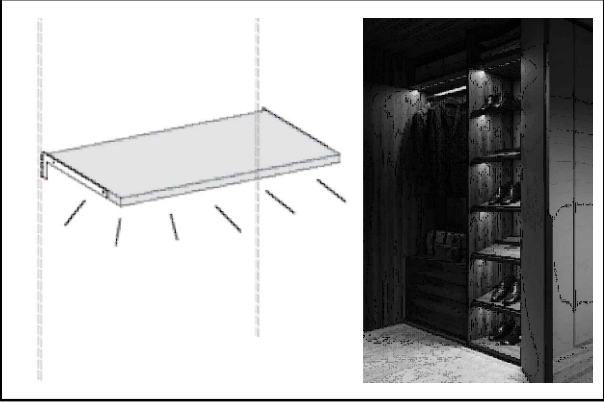


LED LIGHT
HORIZONTAL

DOORS

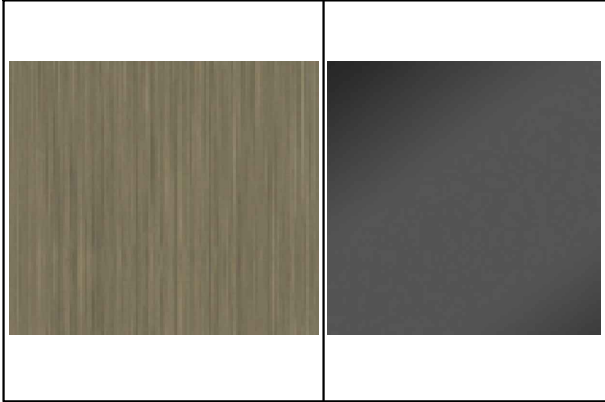


FRAME AND GLASS
FRAME BRONZATO PELTRO ORO - GLASS SPECCHIO DARK

DOORS

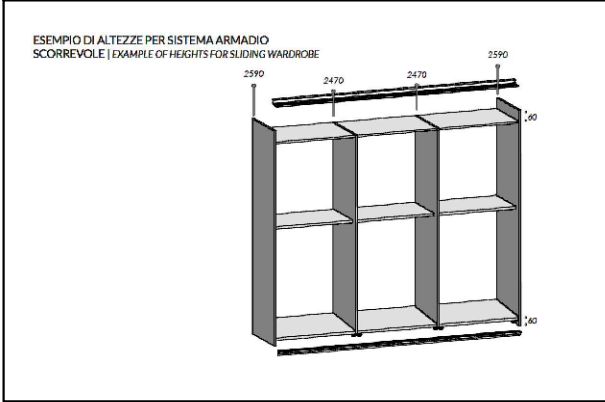

SLIDING DOORS
SLIDING WARDROBE

DOORS

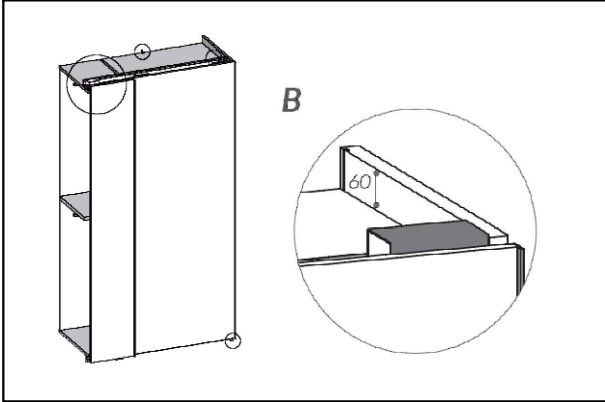

SLIDING DOORS
SLIDING WARDROBE DETAIL

CLIENT APPROVED

DRAWINGS ☐

NOTES ☐

DATE: _____

SIGNATURE: _____

REVISION LOG

1.0	03/30/2026
2.0	05/12/2026
3.0	05/13/2026
4.0	05/19/2026
5.0	06/02/2026
6.0	06/09/2026
7.0	06/16/2026
8.0	06/30/2026
9.0	07/06/2026
10.0	07/14/2026

DATE: 07/14/2026

REV: 9.0

DIMENSION: CM/INCH

DRAWN BY: KVA

CLIENT APPROVED

DRAWINGS ☐

NOTES ☐

DATE: _____

SIGNATURE: _____

REVISION LOG



1.0	03/30/2026
2.0	05/12/2026
3.0	05/13/2026
4.0	05/19/2026
5.0	06/02/2026
6.0	06/09/2026
7.0	06/16/2026
8.0	06/30/2026
9.0	07/06/2026
10.0	07/14/2026

DATE: 07/14/2026

REV: 9.0

DIMENSION: CM/INCH

DRAWN BY: KVA

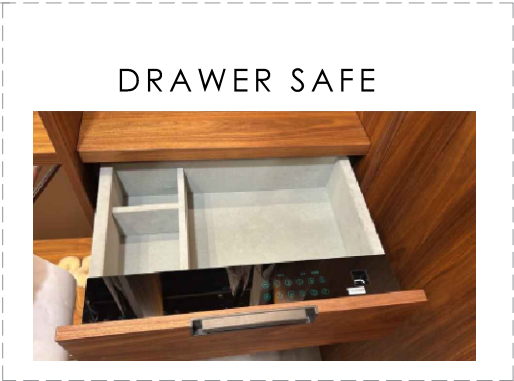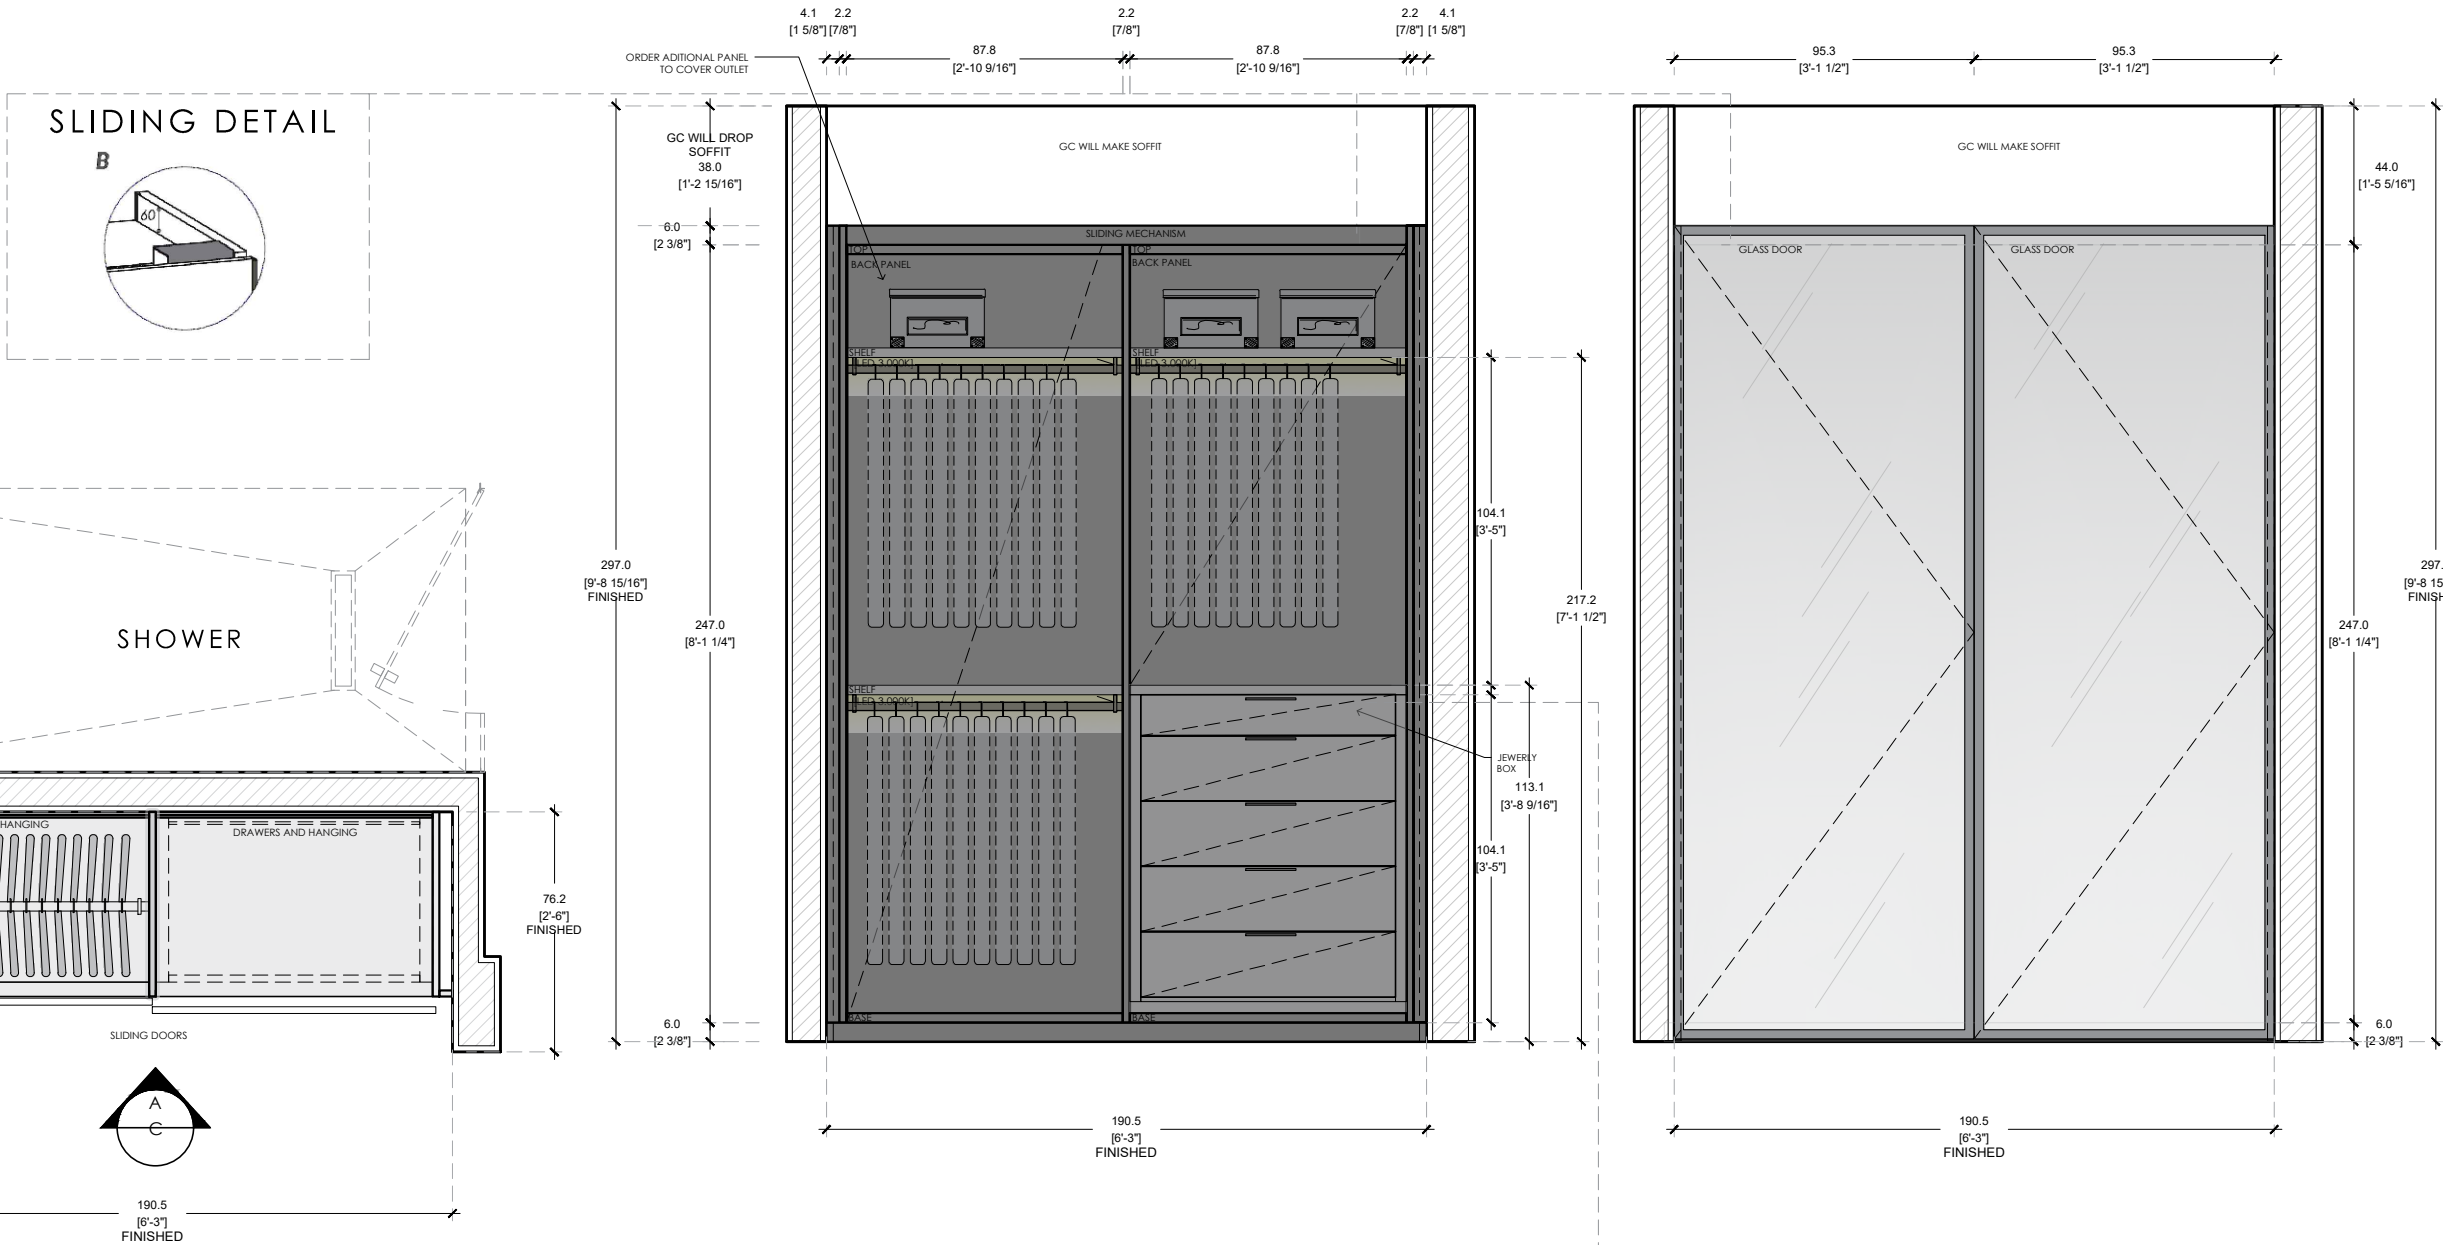

CLOSET - BEDROOM 2

DETAILS

FINISHES




FINISH 1
MELAMINE DOLCE MORDESCO

FINISHES




FINISH 2
LINO TESSUTO

HANDLE STYLES

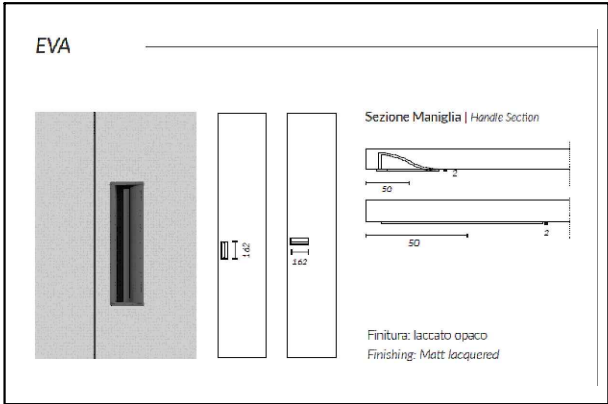


HANDLE DRAWERS
EVA

DRAWERS

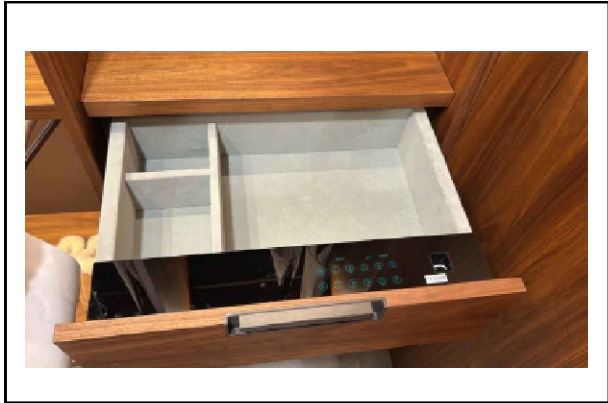


DRAWERS
DRAWER SAFE ALL WALKING CLOSET

ROD

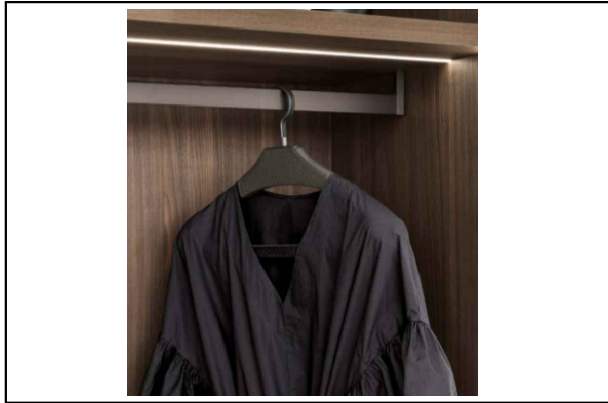

ROD
HANGING ROD

LIGHTS

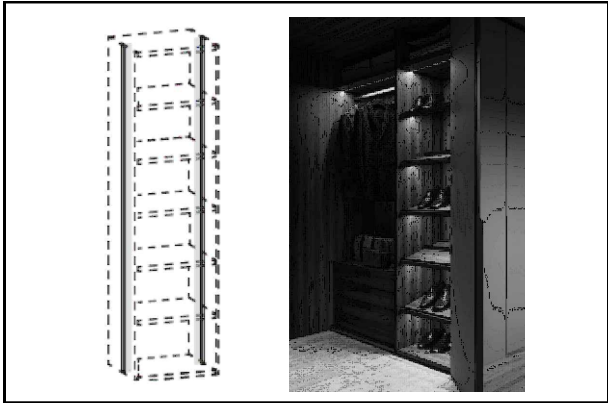

LED LIGHT
VERTICAL

PROJECT #	0000-000
CONTINUUM NORTH	
KITCHEN - OFFICE - CLOSETS - VANITIES	
NOTES:	

CLIENT APPROVED	
DRAWINGS	☐
NOTES	☐
DATE:	
SIGNATURE:	

REVISION LOG	
1.0	03/30/2026
2.0	05/12/2026
3.0	05/13/2026
4.0	05/19/2026
5.0	06/02/2026
6.0	06/09/2026
7.0	06/16/2026
8.0	06/30/2026
9.0	07/06/2026
10.0	07/14/2026


DATE:	07/14/2026
REV:	9.0
DIMENSION:	CM/INCH
DRAWN BY:	KVA

PROJECT #	0000-000
CONTINUUM NORTH	
KITCHEN - OFFICE - CLOSETS - VANITIES	
NOTES:	

CLIENT APPROVED	
DRAWINGS	☐
NOTES	☐
DATE:	
SIGNATURE:	

REVISION LOG	
1.0	03/30/2026
2.0	05/12/2026
3.0	05/13/2026
4.0	05/19/2026
5.0	06/02/2026
6.0	06/09/2026
7.0	06/16/2026
8.0	06/30/2026
9.0	07/06/2026
10.0	07/14/2026

DATE: 07/14/2026
REV: 9.0
DIMENSION: CM/INCH
DRAWN BY: KVA

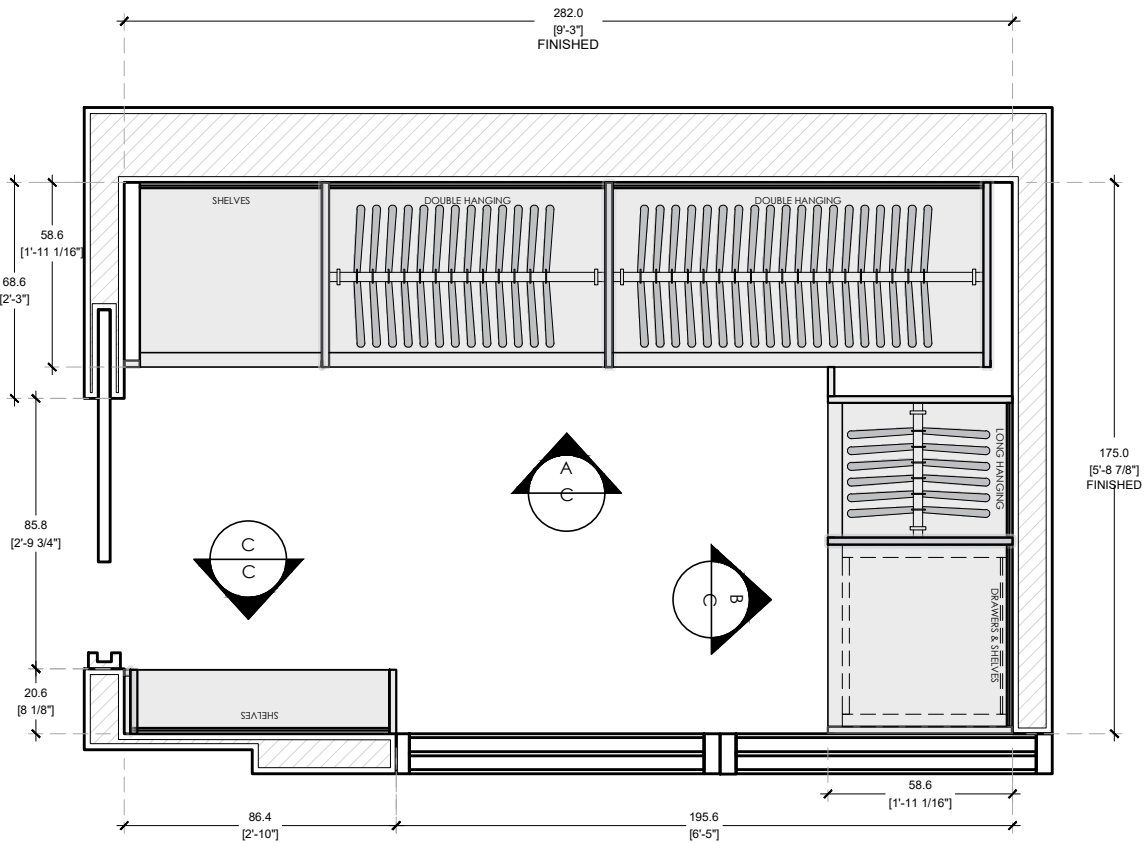

FLOOR PLAN SCALE 1/2"=1'-0"
CONTINUUM NORTH UNIT / BEDROOM 2 CLOSET


| ITALRKRAFT | KICO

- FINISH 1
- FINISH 2
- MELAMINE DOLCE MORDESCO
- LINO TESSUTO FOR SHELVES AND FRONT DRAWERS

NOTES:




G.C.WILL BUILT BASE IN OUR FINISHED DIMENSION

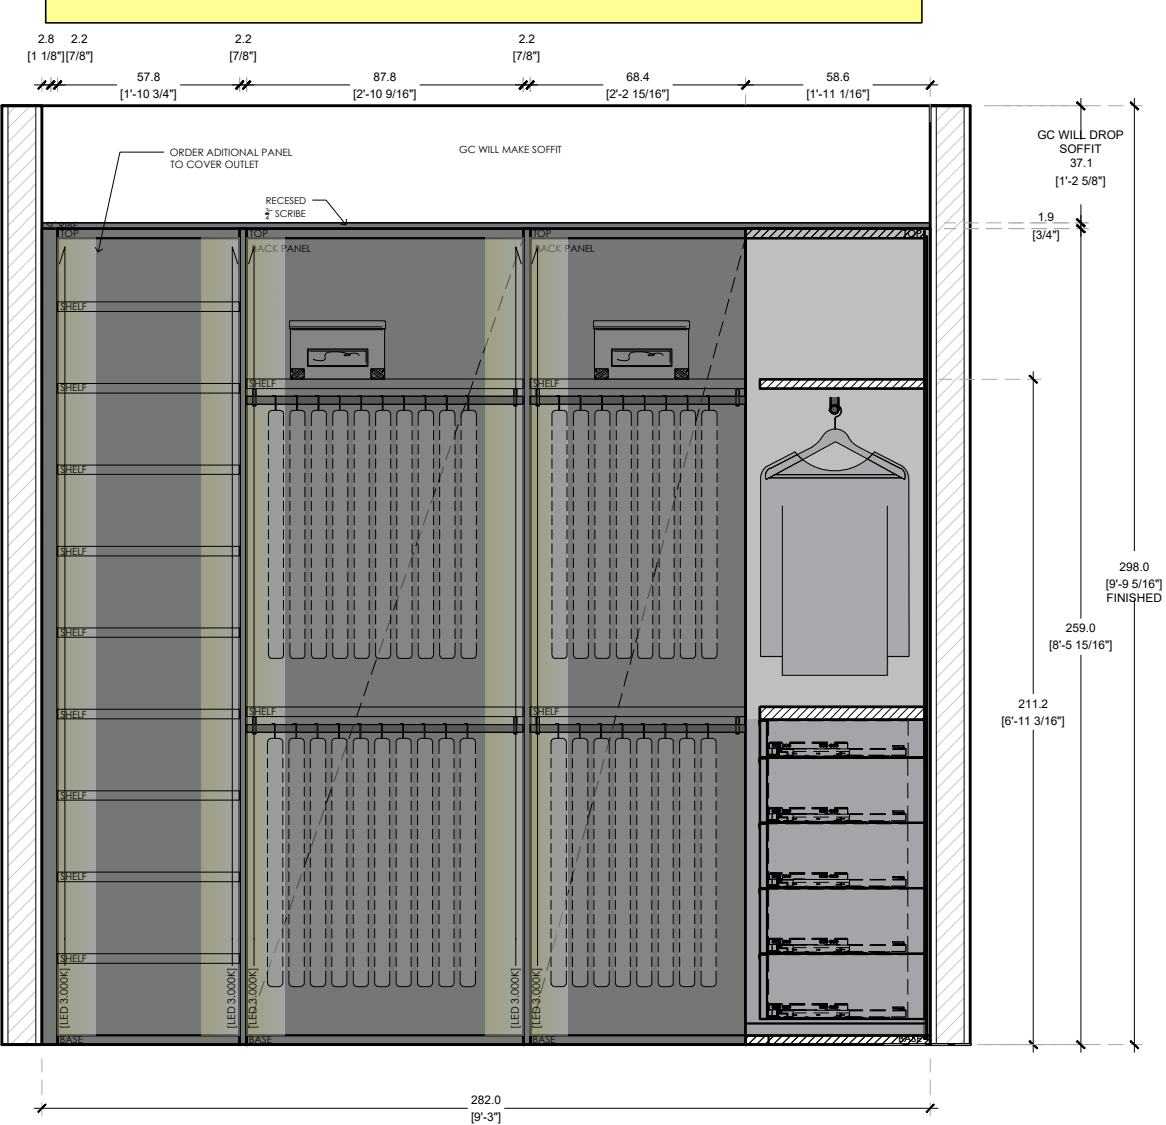

ELEVATION A SCALE 1/2"=1'-0"
CONTINUUM NORTH UNIT / BEDROOM 2 CLOSET

| ITALRKRAFT | KICO

FINISH 1
FINISH 2
MELAMINE DOLCE MORDESCO
LINO TESSUTO FOR SHELVES AND FRONT DRAWERS

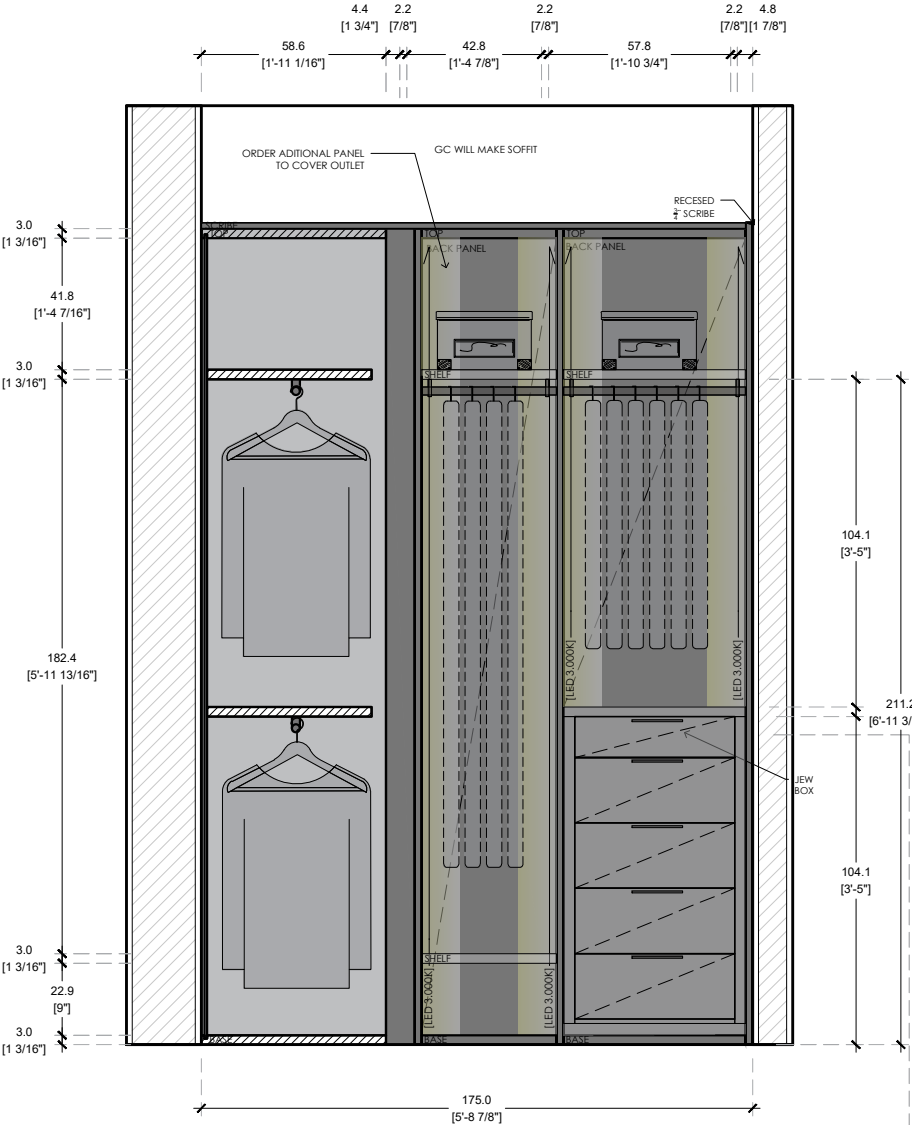


ELEVATION B SCALE 1/2"=1'-0"
CONTINUUM NORTH UNIT / BEDROOM 2 CLOSET

DRAWER SAFE



HANDLES

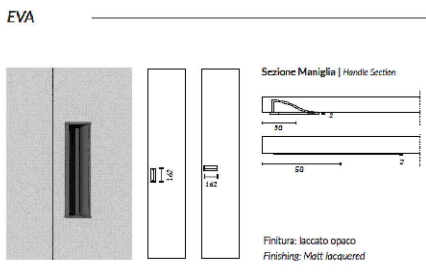

LED LIGHTS



PROJECT # 0000-000
CONTINUUM NORTH
KITCHEN - OFFICE - CLOSETS - VANITIES
NOTES:

CLIENT APPROVED

DRAWINGS
NOTES
DATE:
SIGNATURE:

REVISION LOG	
1.0	03/30/2026
2.0	05/12/2026
3.0	05/13/2026
4.0	05/19/2026
5.0	06/02/2026
6.0	06/09/2026
7.0	06/16/2026
8.0	06/30/2026
9.0	07/06/2026
10.0	07/14/2026

DATE: 07/14/2026
REV: 9.0
DIMENSION: CM/INCH
DRAWN BY: KVA

HIS CLOSET

DETAILS

FINISHES




FINISH 1
MELAMINE DOLCE MORDESCO

FINISHES




FINISH 2
LINO TESSUTO

HANDLE STYLES

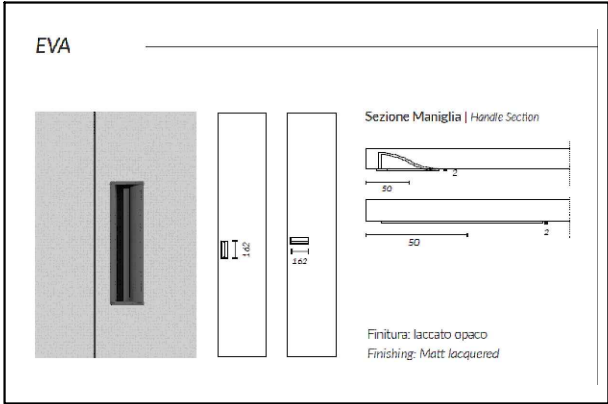


HANDLE DRAWERS
EVA

DRAWERS

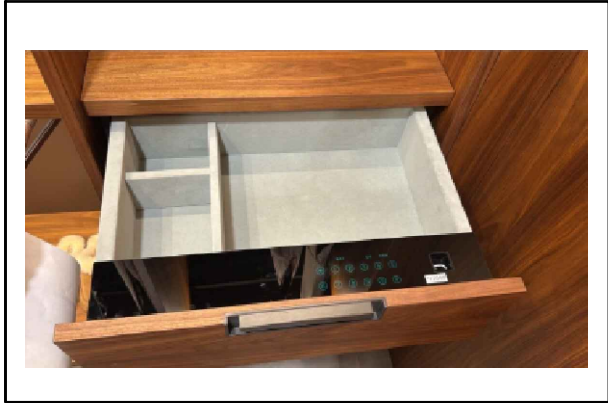


DRAWERS
DRAWER SAFE ALL WALKING CLOSET

ROD

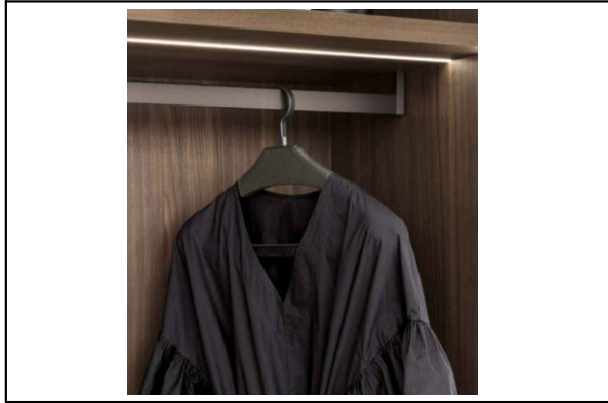

ROD
HANGING ROD

LIGHTS

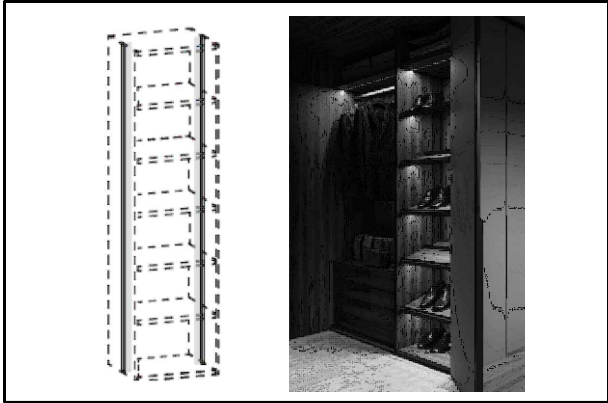

LED LIGHT
VERTICAL

PROJECT #	0000-000
CONTINUUM NORTH	
KITCHEN - OFFICE - CLOSETS - VANITIES	
NOTES:	

CLIENT APPROVED	
DRAWINGS	☐
NOTES	☐
DATE:	
SIGNATURE:	

REVISION LOG	
1.0	03/30/2026
2.0	05/12/2026
3.0	05/13/2026
4.0	05/19/2026
5.0	06/02/2026
6.0	06/09/2026
7.0	06/16/2026
8.0	06/30/2026
9.0	07/06/2026
10.0	07/14/2026

DATE:	07/14/2026
REV:	9.0
DIMENSION:	CM/INCH
DRAWN BY:	KVA

PROJECT #	0000-000
CONTINUUM NORTH	
KITCHEN - OFFICE - CLOSETS - VANITIES	
NOTES:	


CLIENT APPROVED	
DRAWINGS	☐
NOTES	☐
DATE:	
SIGNATURE:	

REVISION LOG	
1.0	03/30/2026
2.0	05/12/2026
3.0	05/13/2026
4.0	05/19/2026
5.0	06/02/2026
6.0	06/09/2026
7.0	06/16/2026
8.0	06/30/2026
9.0	07/06/2026
10.0	07/14/2026

DATE:	07/14/2026
REV:	9.0
DIMENSION:	CM/INCH
DRAWN BY:	KVA

NOTES:

G.C.WILL BUILT BASE IN OUR FINISHED DIMENSION

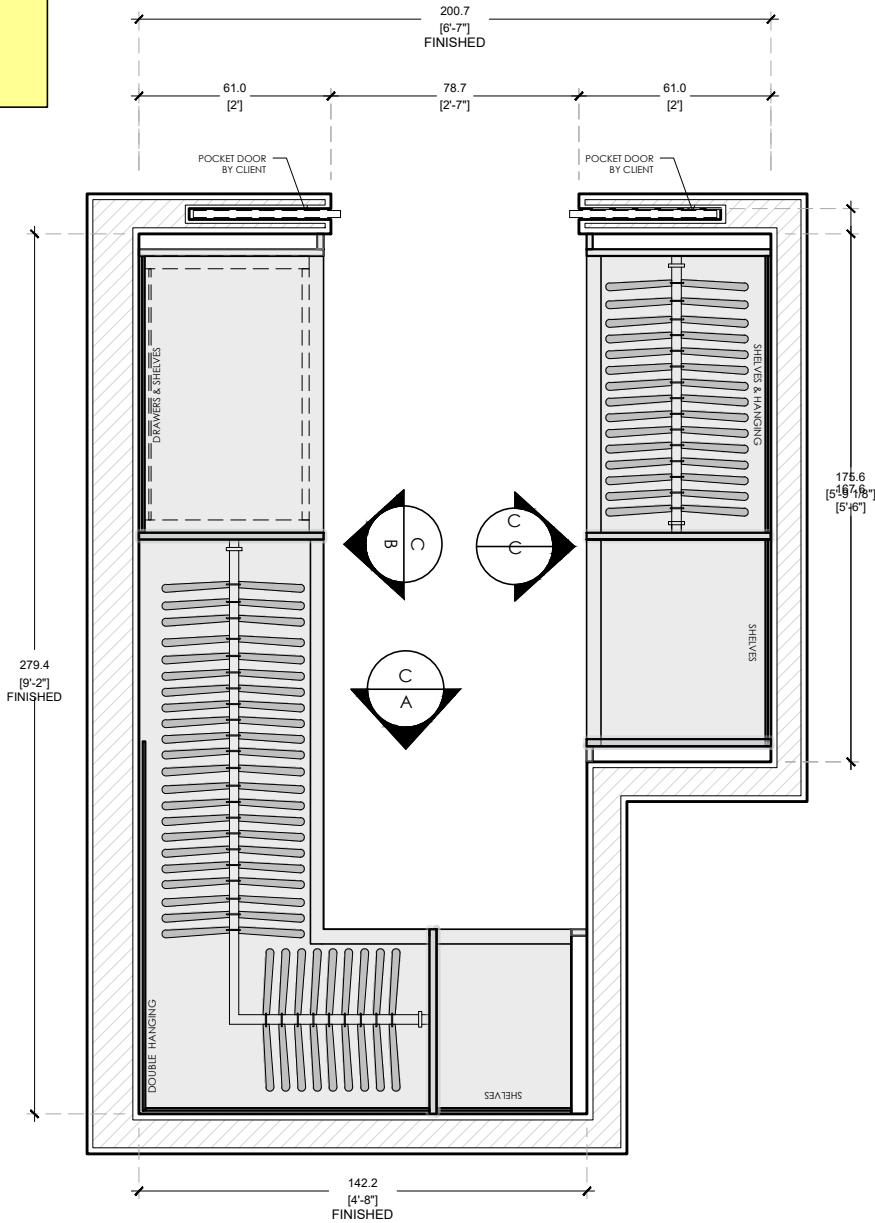

FLOOR PLAN SCALE 1/2"=1'-0"
CONTINUUM NORTH UNIT / HIS CLOSET


| ITALRKRAFT | KICO

- FINISH 1
- FINISH 2
- MELAMINE DOLCE MORDESCO
- LINO TESSUTO FOR SHELVES AND FRONT DRAWERS


NOTES:




G.C.WILL BUILT BASE IN OUR
FINISHED DIMENSION

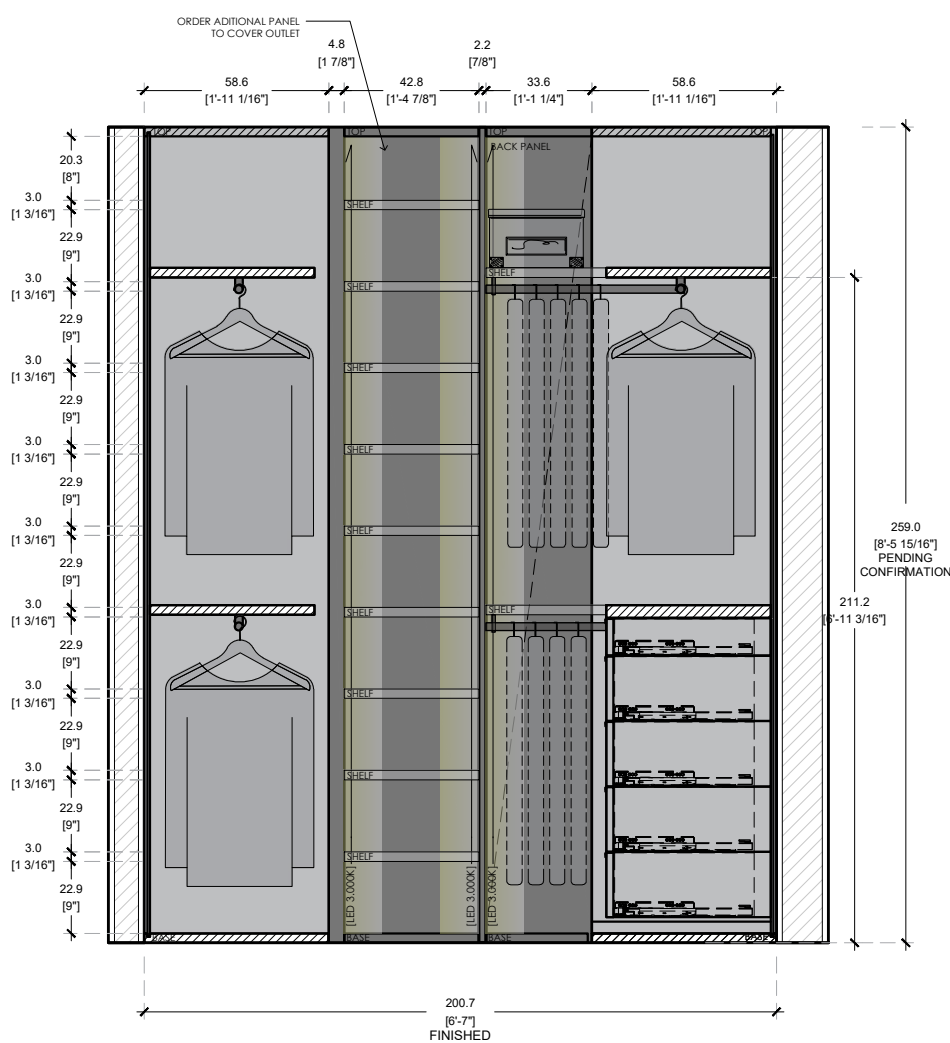

ELEVATION A SCALE 1/2"=1'-0"
CONTINUUM NORTH UNIT / HIS CLOSET

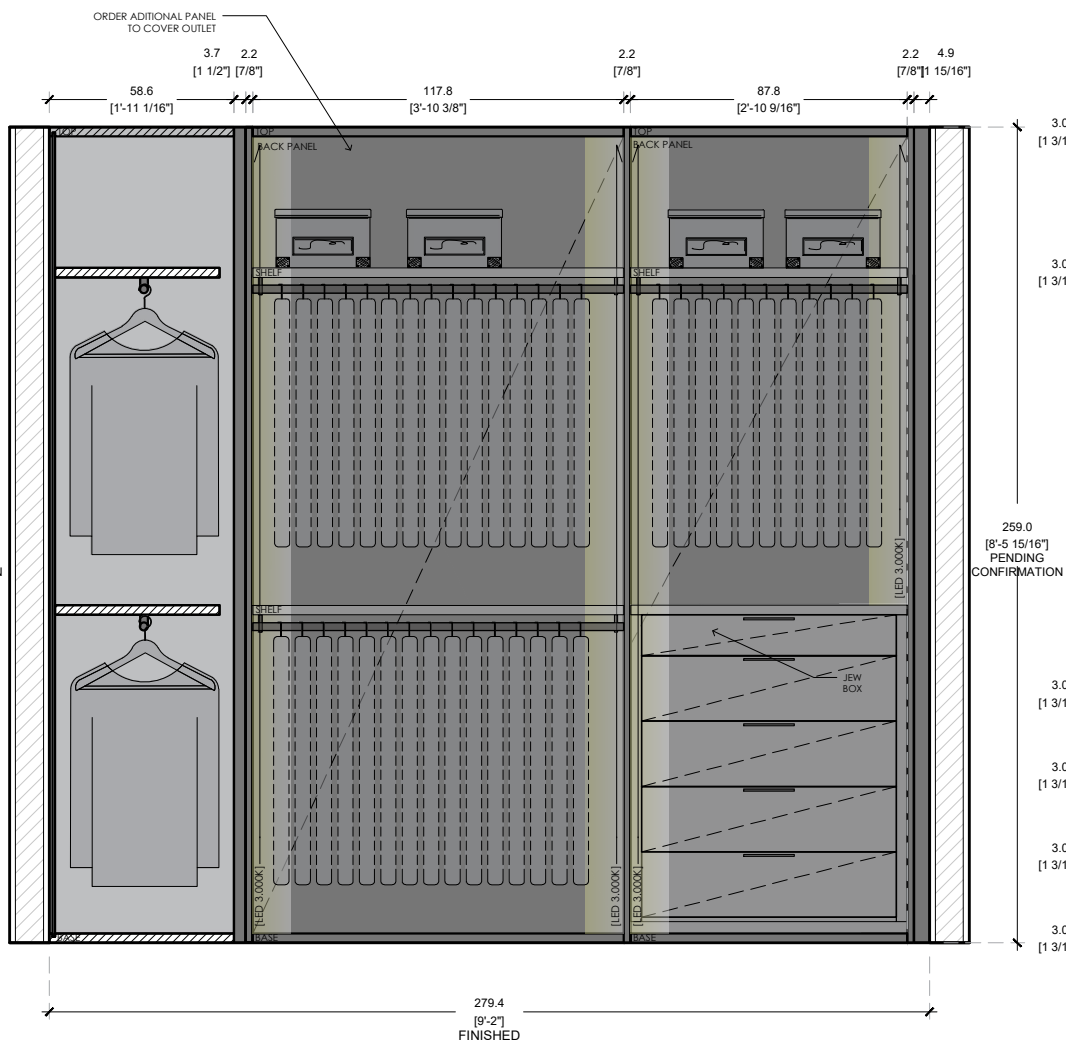

ELEVATION B SCALE 1/2"=1'-0"
CONTINUUM NORTH UNIT / HIS CLOSET

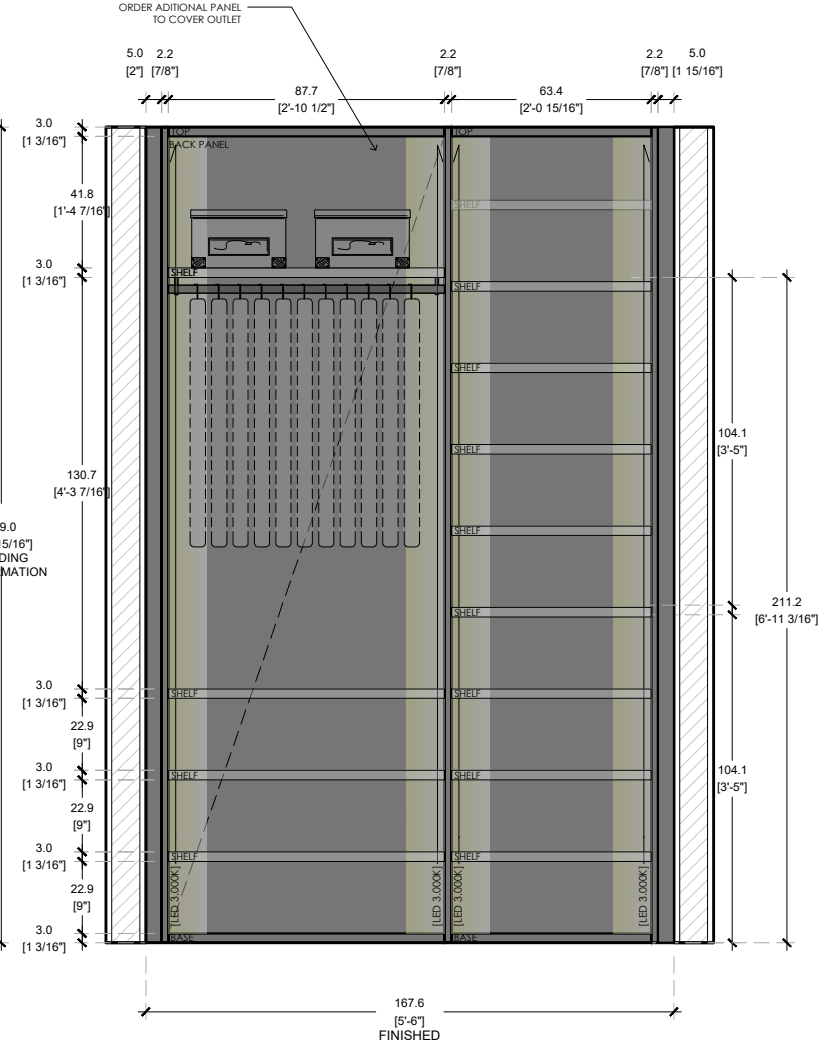

ELEVATION C SCALE 1/2"=1'-0"
CONTINUUM NORTH UNIT / HIS CLOSET

| ITALRKRAFT | KICO

- FINISH 1
FINISH 2
- MELAMINE DOLCE MORDESCO
LINO TESSUTO FOR SHELVES AND FRONT DRAWERS

DRAWER SAFE

HANDLES

EVA

LED LIGHTS

ITALRKRAFT

KITCHENS | BATHS | CLOSETS

2900 NW 77TH CT. MIAMI FL. 33122
T. 305 406 1301 - F. 305 406 1302

PROJECT # 0000-000
CONTINUUM NORTH
KITCHEN - OFFICE - CLOSETS - VANITIES
NOTES:

CLIENT APPROVED

DRAWINGS ☐
NOTES ☐
DATE:
SIGNATURE:

REVISION LOG

1.0	03/30/2026
2.0	05/12/2026
3.0	05/13/2026
4.0	05/19/2026
5.0	06/02/2026
6.0	06/09/2026
7.0	06/16/2026
8.0	06/30/2026
9.0	07/06/2026
10.0	07/14/2026

DATE: 07/14/2026
REV: 9.0
DIMENSION: CM/INCH
DRAWN BY: KVA

HER CLOSET


DETAILS

FINISHES




FINISH 1
MELAMINE DOLCE MORDESCO

FINISHES

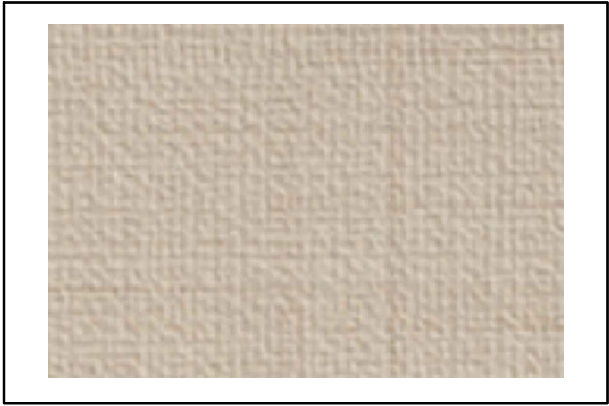


FINISH 2
LINO TESSUTO

HANDLE STYLES

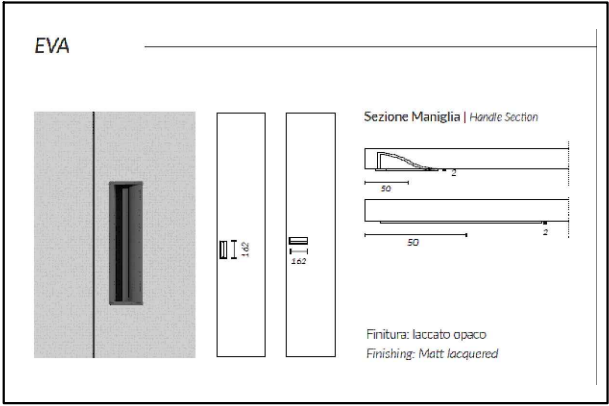


HANDLE DRAWERS
EVA

DRAWERS

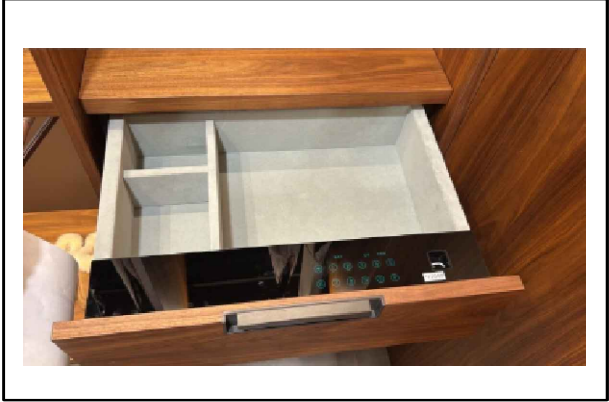

DRAWERS
DRAWER SAFE ALL WALKING CLOSET

ROD

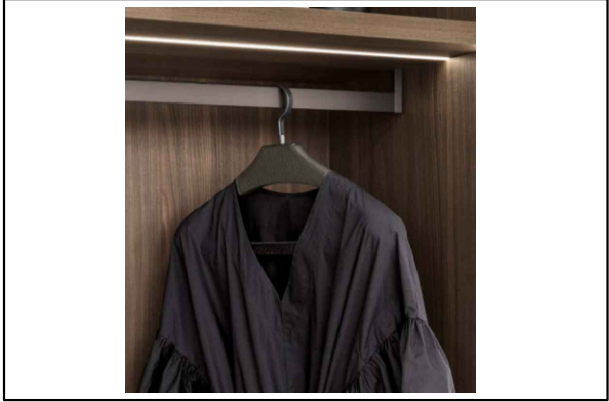


ROD
HANGING ROD

DOORS




SWING DOOR
SWING DOOR

LIGHTS

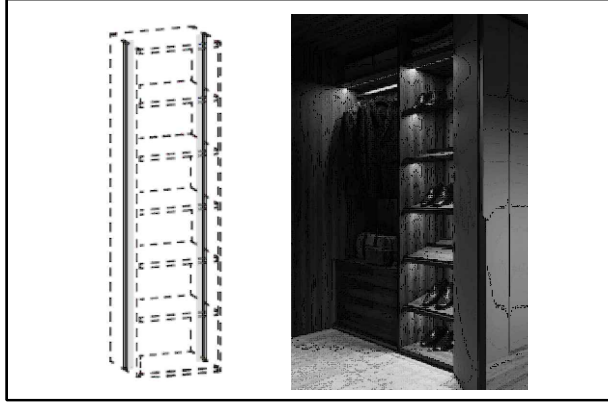


LED LIGHT
VERTICAL

DOORS

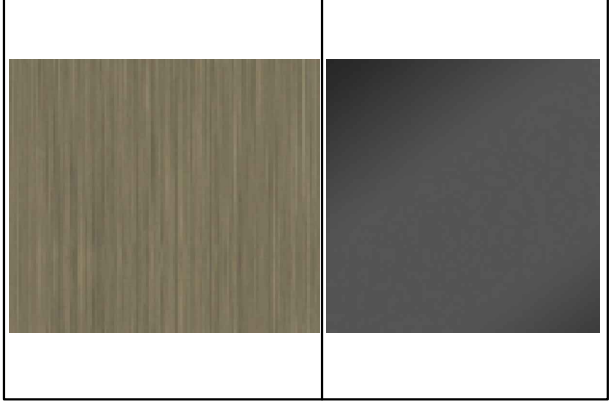


FRAME AND GLASS
FRAME BRONZATO
PELTRO ORO - GLASS SPECCHIO
DARK

DOORS

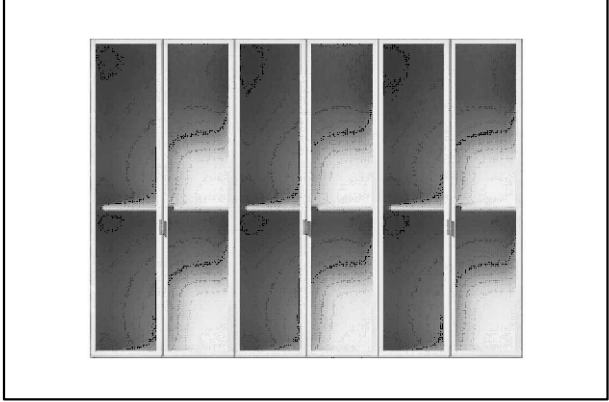

SWING DOOR
FRAME

DOORS

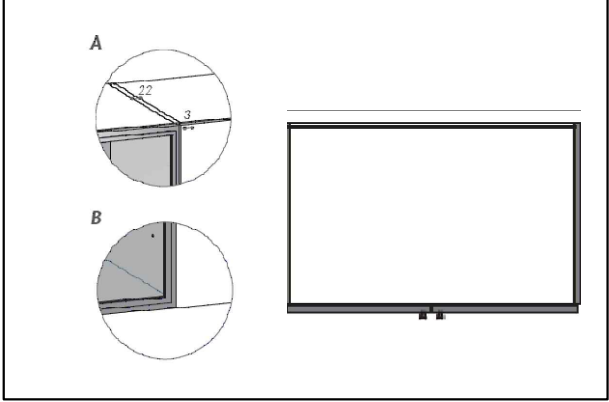

SWING DOOR
SWING DOOR DETAIL

ITALKRAFT

KITCHENS | BATHS | CLOSETS
2900 NW 77TH CT. MIAMI FL, 33122
T. 305 406 1301 - F. 305 406 1302

PROJECT # 0000-000

CONTINUUM NORTH

KITCHEN - OFFICE - CLOSETS - VANITIES

NOTES:

CLIENT APPROVED

DRAWINGS ☐

NOTES ☐

DATE: _____

SIGNATURE: _____

REVISION LOG

1.0	03/30/2026
2.0	05/12/2026
3.0	05/13/2026
4.0	05/19/2026
5.0	06/02/2026
6.0	06/09/2026
7.0	06/16/2026
8.0	06/30/2026
9.0	07/06/2026
10.0	07/14/2026

DATE: 07/14/2026


REV: 9.0

DIMENSION: CM/INCH

DRAWN BY: KVA

NOTES:

 G.C.WILL BUILT BASE IN OUR FINISHED DIMENSION

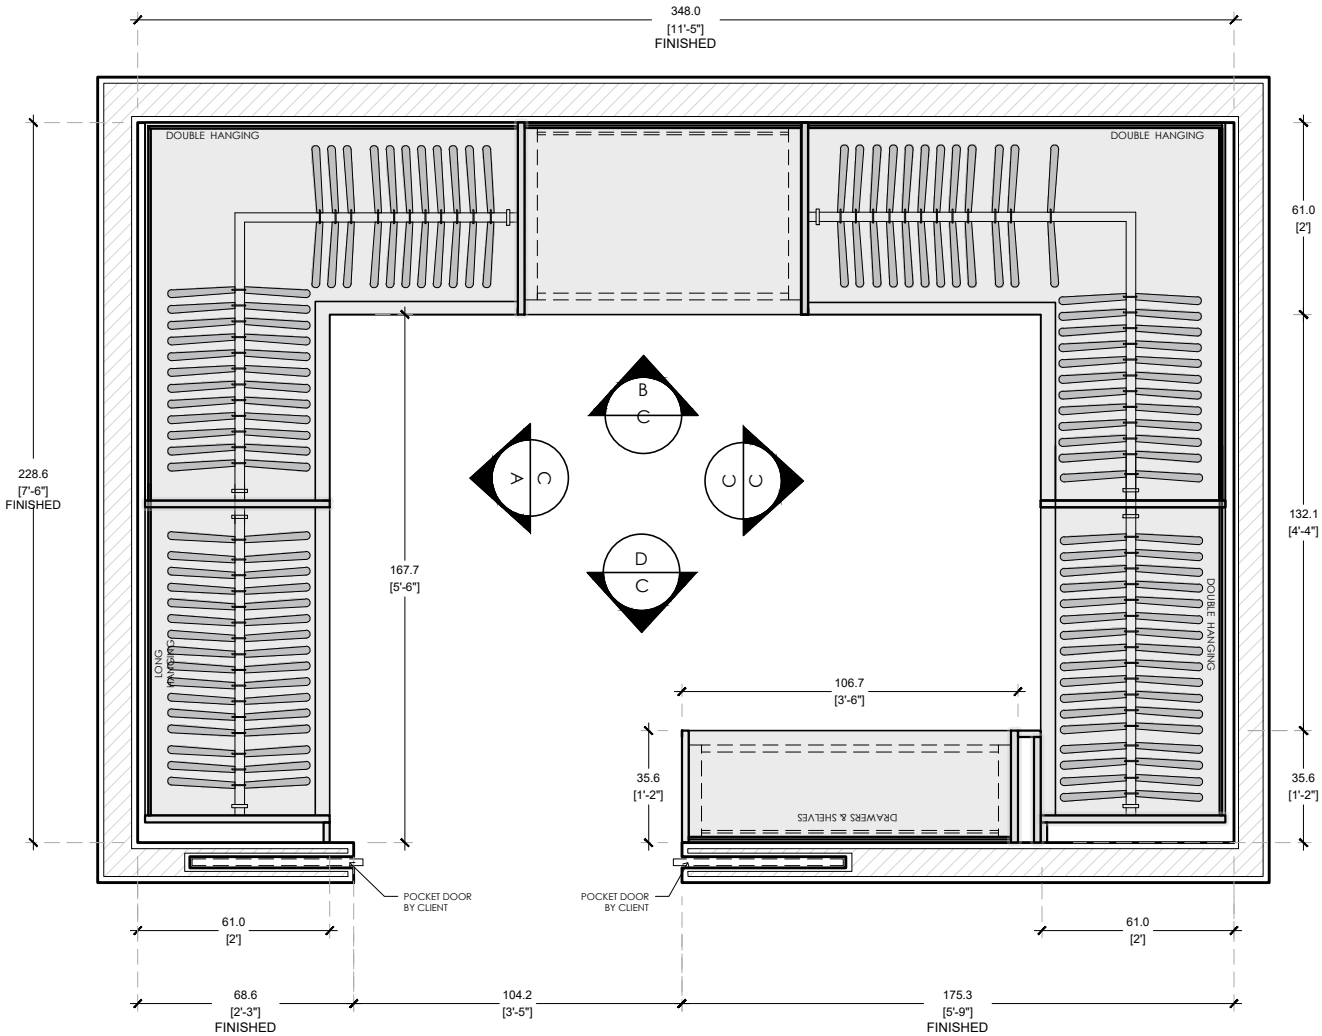

FLOOR PLAN SCALE 1/2"=1'-0"
CONTINUUM NORTH UNIT / HER CLOSET

| ITALRKRAFT | KICO

- FINISH 1
- FINISH 2
- MELAMINE DOLCE MORDESCO
- LINO TESSUTO FOR SHELVES AND FRONT DRAWERS

PROJECT #	0000-000
CONTINUUM NORTH	
KITCHEN - OFFICE - CLOSETS - VANITIES	
NOTES:	

CLIENT APPROVED

DRAWINGS ☐

NOTES ☐

DATE: _____

SIGNATURE: _____

REVISION LOG

1.0	03/30/2026
2.0	05/12/2026
3.0	05/13/2026
4.0	05/19/2026
5.0	06/02/2026
6.0	06/09/2026
7.0	06/16/2026
8.0	06/30/2026
9.0	07/06/2026
10.0	07/14/2026

DATE: 07/14/2026

REV: 9.0


DIMENSION: CM/INCH

DRAWN BY: KVA


NOTES:



G.C.WILL BUILT BASE IN OUR
FINISHED DIMENSION

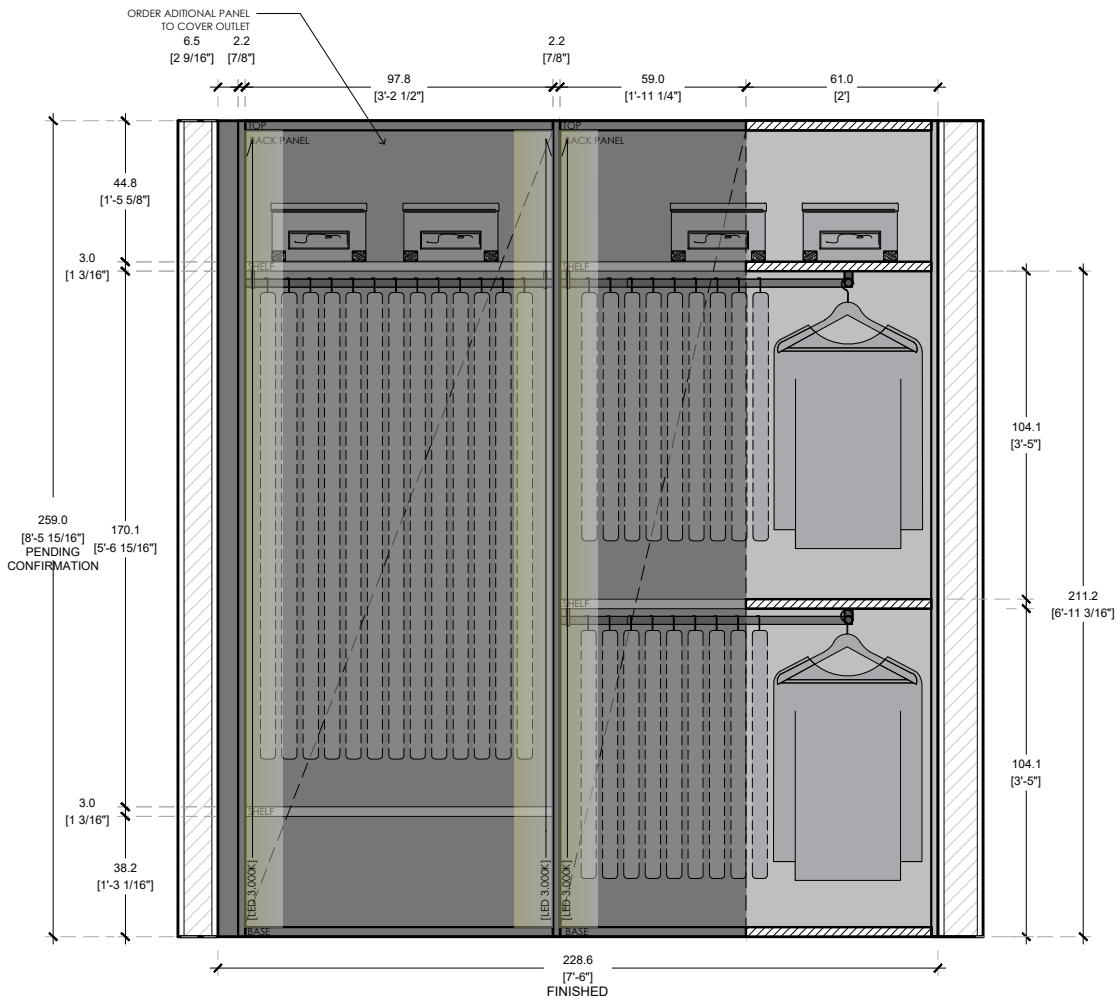

ELEVATION A PLAN SCALE 1/2"=1'-0"
CONTINUUM NORTH UNIT / HER CLOSET

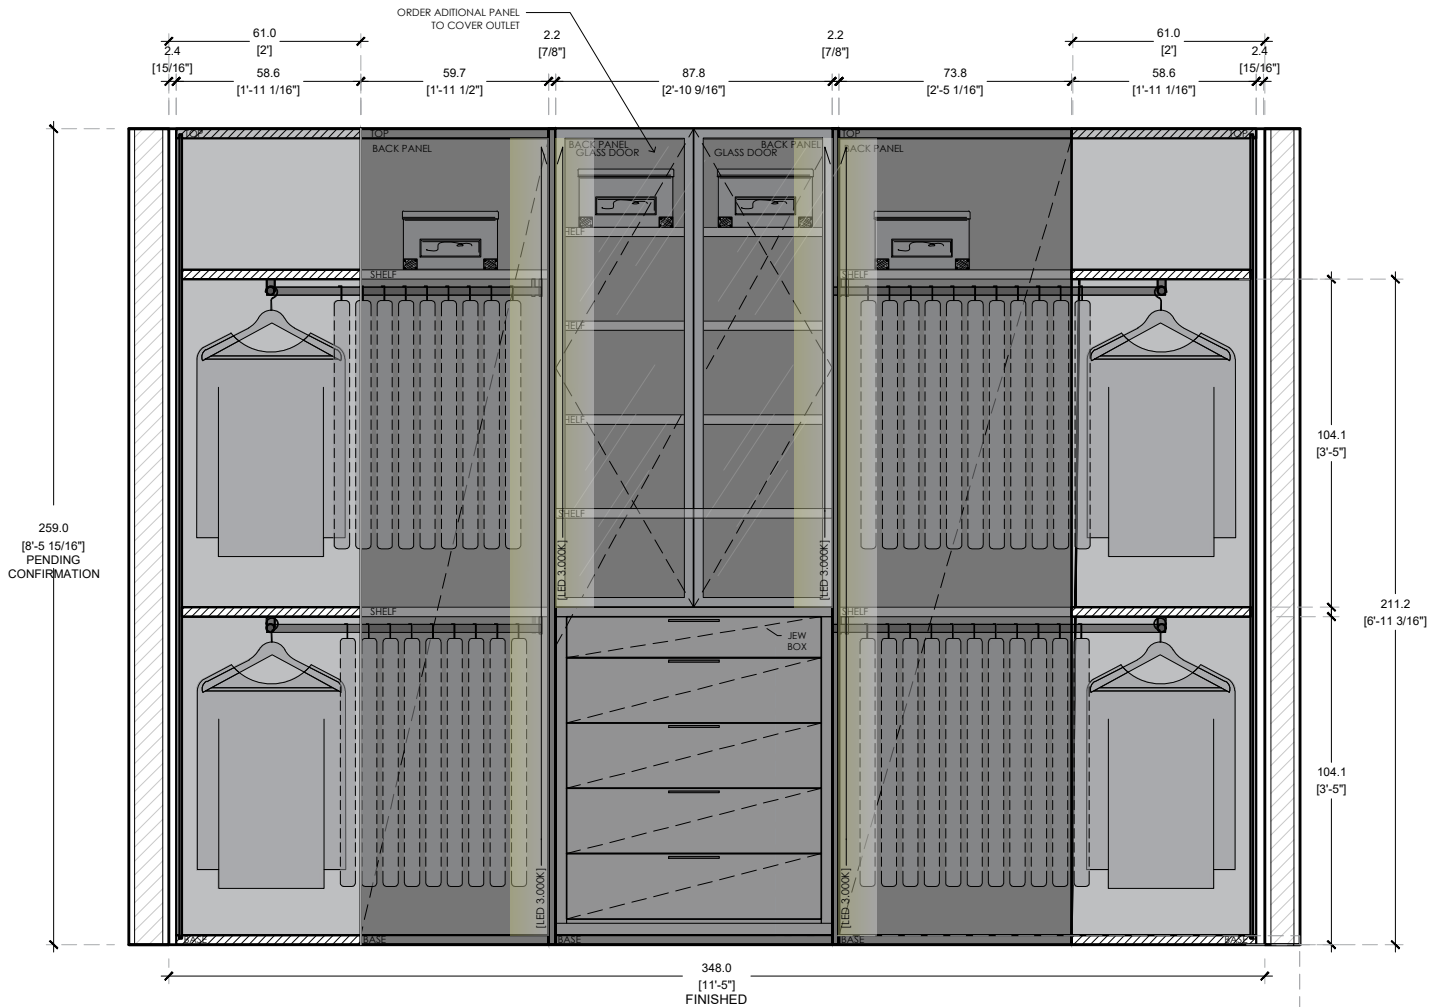

ELEVATION B SCALE 1/2"=1'-0"
CONTINUUM NORTH UNIT / HER CLOSET

| ITALKRAFT | KICO

FINISH 1
FINISH 2

MELAMINE DOLCE MORDESCO
LINO TESSUTO FOR SHELVES AND FRONT DRAWERS



PROJECT # 0000-000

CONTINUUM NORTH

KITCHEN - OFFICE - CLOSETS - VANITIES

NOTES:

CLIENT APPROVED

DRAWINGS ☐
NOTES ☐
DATE:
SIGNATURE:

REVISION LOG


1.0	03/30/2026
2.0	05/12/2026
3.0	05/13/2026
4.0	05/19/2026
5.0	06/02/2026
6.0	06/09/2026
7.0	06/16/2026
8.0	06/30/2026
9.0	07/06/2026
10.0	07/14/2026

DATE: 07/14/2026
REV: 9.0
DIMENSION: CM/INCH
DRAWN BY: KVA

NOTES:



G.C.WILL BUILT BASE IN OUR
FINISHED DIMENSION

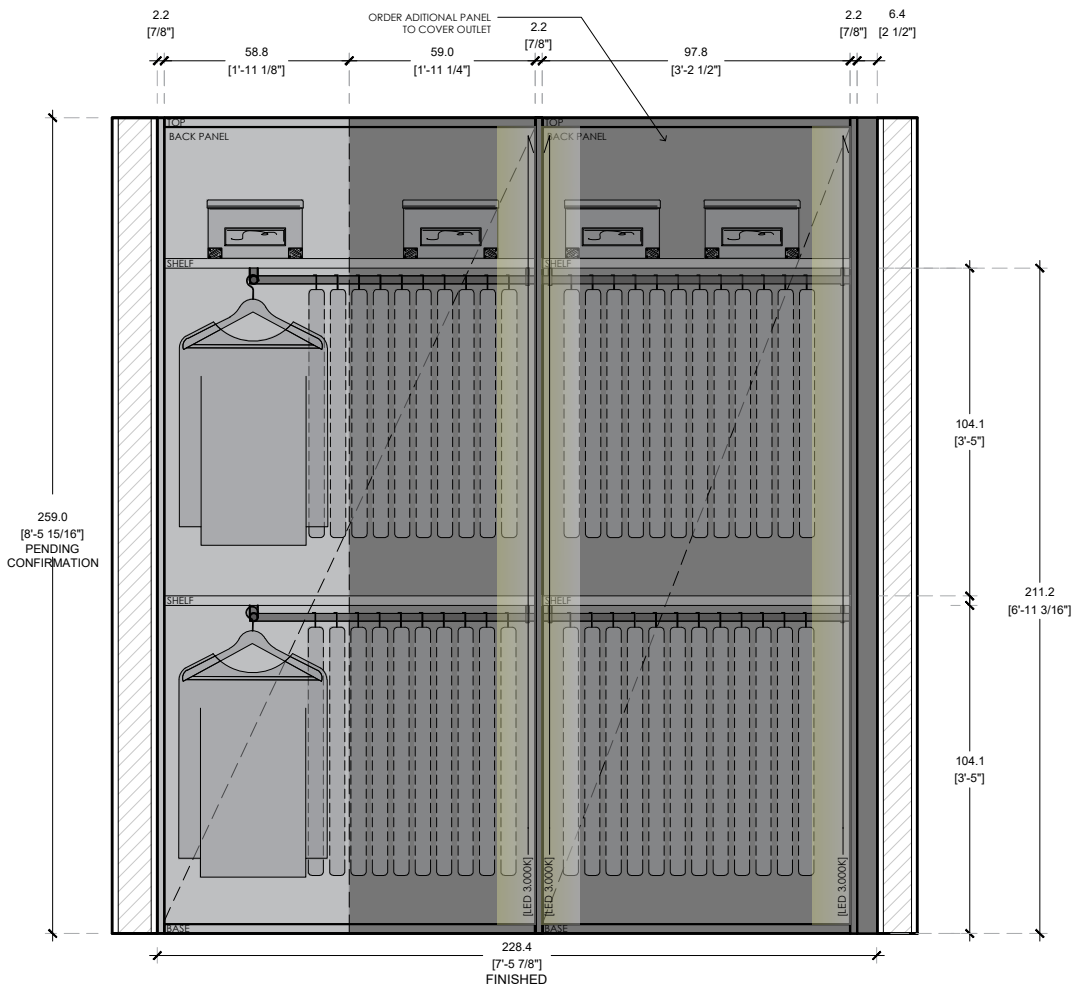


ELEVATION C SCALE 1/2"=1'-0"
CONTINUUM NORTH UNIT / HER CLOSET

| ITALRKAFT | KICO

- FINISH 1
- FINISH 2

MELAMINE DOLCE MORDESCO
LINO TESSUTO FOR SHELVES AND FRONT DRAWERS

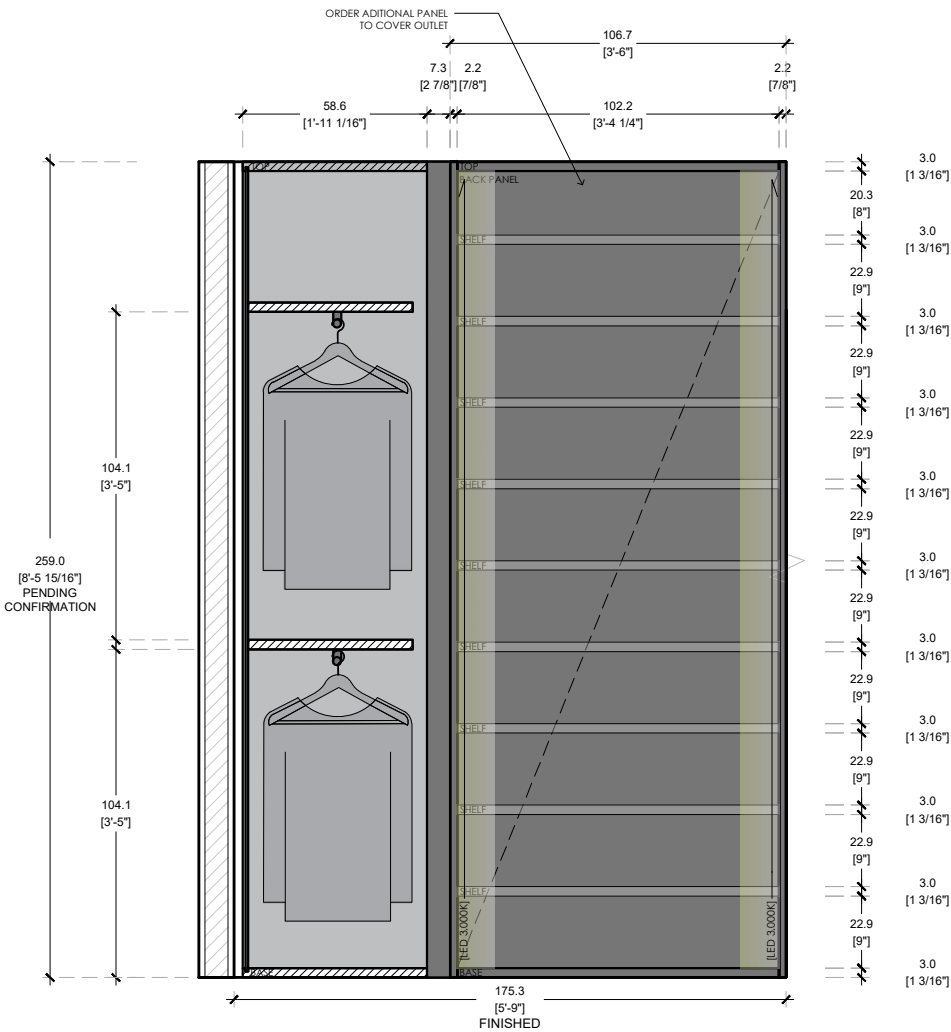


ELEVATION D SCALE 1/2"=1'-0"
CONTINUUM NORTH UNIT / HER CLOSET

DRAWER SAFE



HANDLES

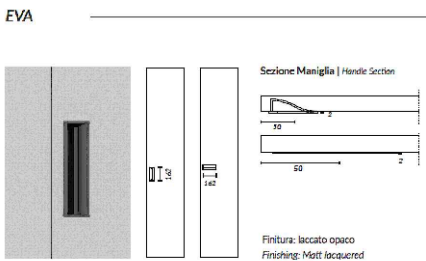

LED LIGHTS



ITALKRAFT

KITCHENS | BATHS | CLOSETS
2900 NW 77TH CT. MIAMI FL. 33122
T. 305 406 1301 - F. 305 406 1302

PROJECT # 0000-000

CONTINUUM NORTH

KITCHEN - OFFICE - CLOSETS - VANITIES

NOTES:

CLIENT APPROVED

DRAWINGS ☐
NOTES ☐
DATE:
SIGNATURE:

REVISION LOG

1.0	03/30/2026
2.0	05/12/2026
3.0	05/13/2026
4.0	05/19/2026
5.0	06/02/2026
6.0	06/09/2026
7.0	06/16/2026
8.0	06/30/2026
9.0	07/06/2026
10.0	07/14/2026

DATE: 07/14/2026
REV: 9.0
DIMENSION: CM/INCH
DRAWN BY: KVA

BATH BEDROOM 3

DETAILS

FINISH 1




KICO
LACQUER IVORY

FINISH 2



KICO
LINO TESSUTO - CARCASS

HANDLE COLOR

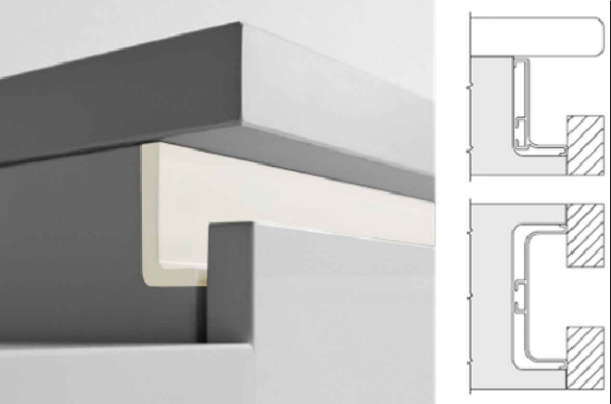

BASE CABINETS
INTEGRATED GOLA - MATCH FINISH 1



DRAWERS
BLUM LEGRABOX



INTERNAL DRAWERS
BLUM LEGRABOX - GREY

PROJECT #	0000-000
CONTINUUM NORTH	
KITCHEN - OFFICE - CLOSETS - VANITIES	
NOTES:	

CLIENT APPROVED	
DRAWINGS	☐
NOTES	☐
DATE:	
SIGNATURE:	

REVISION LOG	
1.0	03/30/2026
2.0	05/12/2026
3.0	05/13/2026
4.0	05/19/2026
5.0	06/02/2026
6.0	06/09/2026
7.0	06/16/2026
8.0	06/30/2026
9.0	07/06/2026
10.0	07/14/2026

DATE:	07/14/2026
REV:	9.0
DIMENSION:	CM/INCH
DRAWN BY:	KVA

PROJECT # 0000-000

CONTINUUM NORTH

KITCHEN - OFFICE - CLOSETS - VANITIES

NOTES:

CLIENT APPROVED


DRAWINGS ☐
NOTES ☐
DATE:
SIGNATURE:

REVISION LOG


1.0	03/30/2026
2.0	05/12/2026
3.0	05/13/2026
4.0	05/19/2026
5.0	06/02/2026
6.0	06/09/2026
7.0	06/16/2026
8.0	06/30/2026
9.0	07/06/2026
10.0	07/14/2026

DATE: 07/14/2026
REV: 9.0
DIMENSION: CM/INCH
DRAWN BY: KVA

BRACKET DETAIL

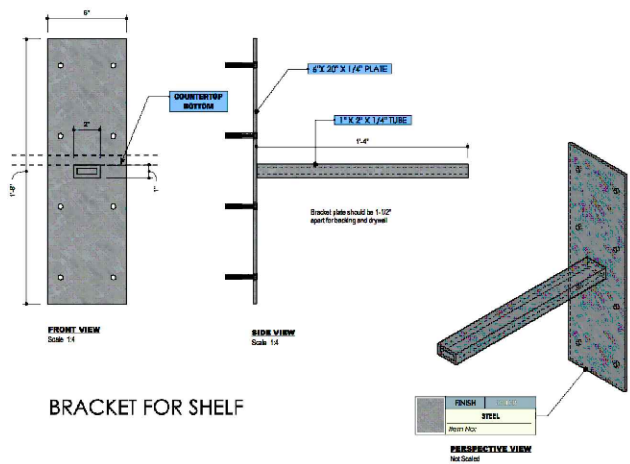

BRACKET FOR SHELF

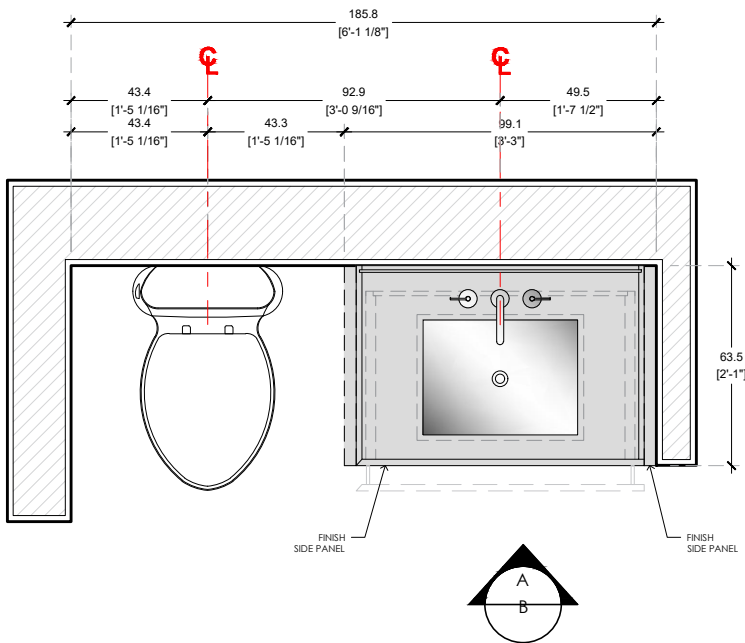


FLOOR PLAN SCALE 1/2"=1'-0"
CONTINUUM NORTH UNIT / BEDROOM 3 BATHROOM


| ITALKRAFT | KICO

FINISH 1
GBAR
TOE KICK
CARCASS
LACQUER IVORY
LACQUER IVORY
FLOATING
LINO TESSUTO

ELEVATION A SCALE 1/2"=1'-0"
CONTINUUM NORTH UNIT / BEDROOM 3 BATHROOM

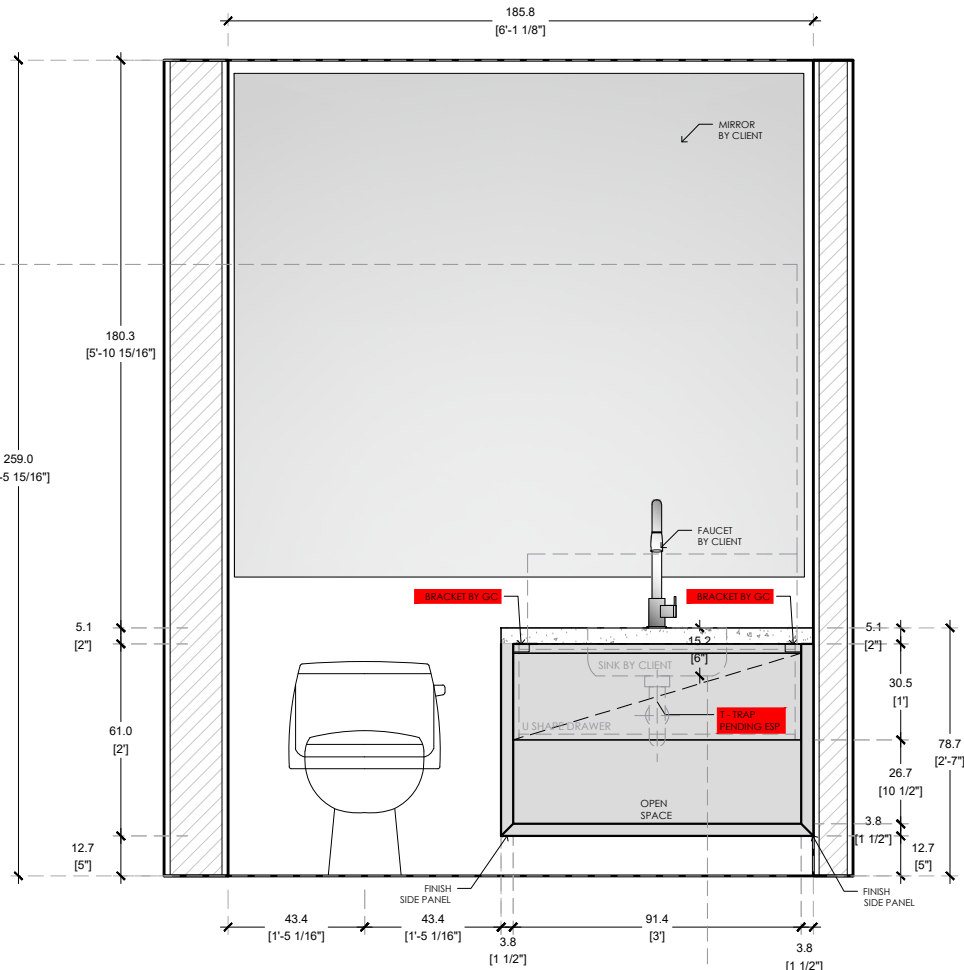

SINK DETAIL

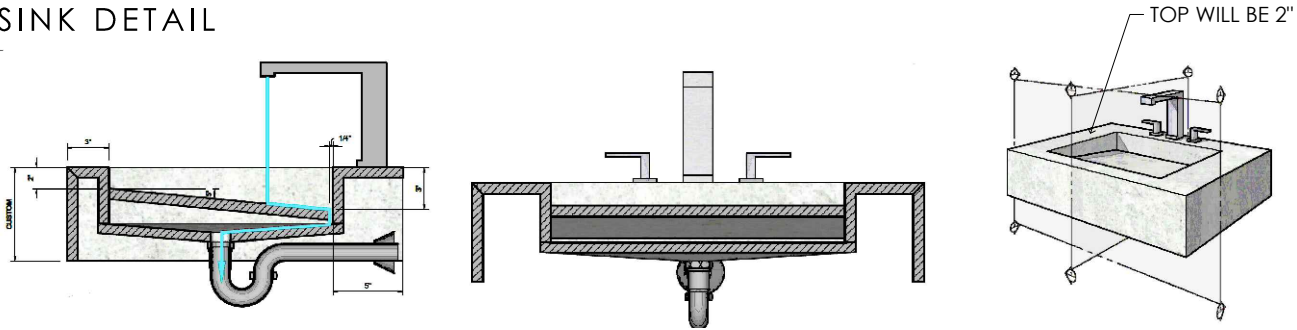

BATH BEDROOM 2

DETAILS

FINISH 1




KICO
LACQUER IVORY

FINISH 2



KICO
LINO TESSUTO - CARCASS

HANDLE COLOR

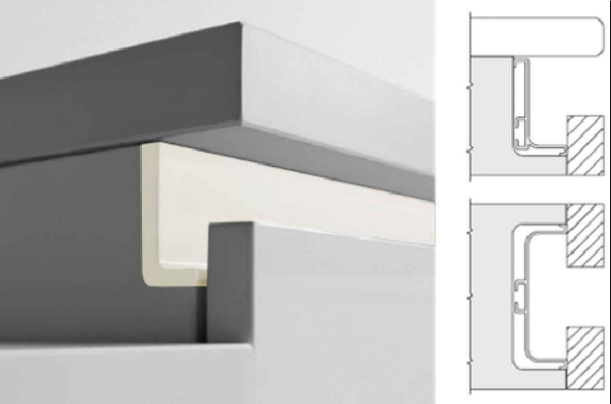

BASE CABINETS
INTEGRATED GOLA - MATCH FINISH 1



DRAWERS
BLUM LEGRABOX



INTERNAL DRAWERS
BLUM LEGRABOX - GREY

PROJECT # 0000-000

CONTINUUM NORTH

KITCHEN - OFFICE - CLOSETS - VANITIES

NOTES:

CLIENT APPROVED

DRAWINGS ☐

NOTES ☐

DATE: _____

SIGNATURE: _____

REVISION LOG

1.0	03/30/2026
2.0	05/12/2026
3.0	05/13/2026
4.0	05/19/2026
5.0	06/02/2026
6.0	06/09/2026
7.0	06/16/2026
8.0	06/30/2026
9.0	07/06/2026
10.0	07/14/2026

DATE: 07/14/2026

REV: 9.0

DIMENSION: CM/INCH

DRAWN BY: KVA

PROJECT # 0000-000

CONTINUUM NORTH

KITCHEN - OFFICE - CLOSETS - VANITIES

NOTES:

CLIENT APPROVED

DRAWINGS ☐

NOTES ☐

DATE: _____

SIGNATURE: _____

REVISION LOG

1.0	03/30/2026
2.0	05/12/2026
3.0	05/13/2026
4.0	05/19/2026
5.0	06/02/2026
6.0	06/09/2026
7.0	06/16/2026
8.0	06/30/2026
9.0	07/06/2026
10.0	07/14/2026


DATE: 07/14/2026

REV: 9.0


DIMENSION: CM/INCH

DRAWN BY: KVA

BRACKET DETAIL

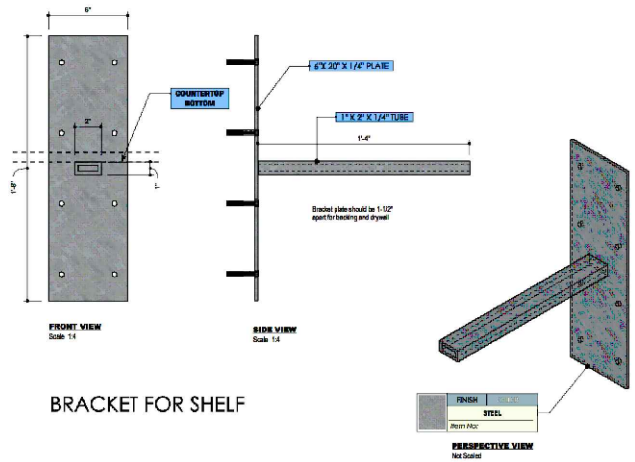


BRACKET FOR SHELF

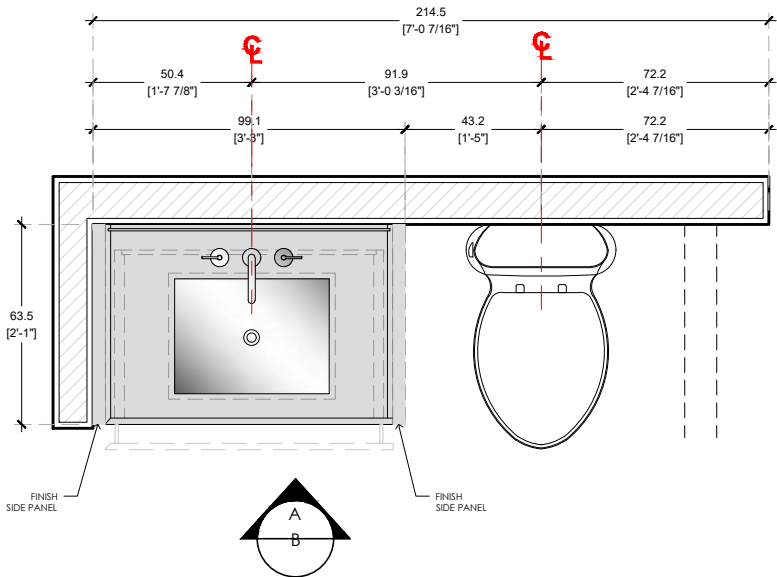

FLOOR PLAN SCALE 1/2"=1'-0"
CONTINUUM NORTH UNIT / BEDROOM 2 BATHROOM


| ITALRKRAFT | KICO

FINISH 1
GBAR
TOE KICK
CARCASS
LACQUER IVORY
LACQUER IVORY
FLOATING
LINO TESSUTO

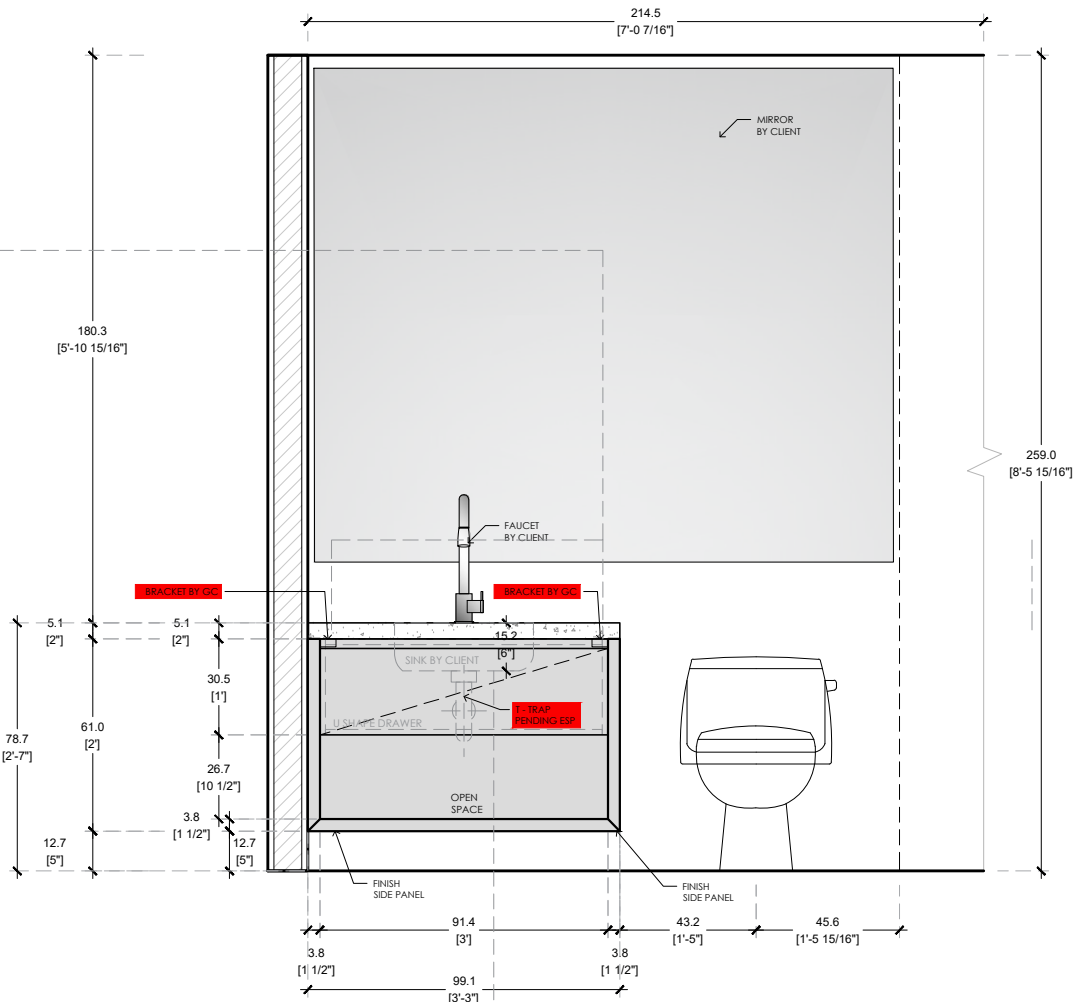

FLOOR PLAN SCALE 1/2"=1'-0"
CONTINUUM NORTH UNIT / BEDROOM 2 BATHROOM

SINK DETAIL

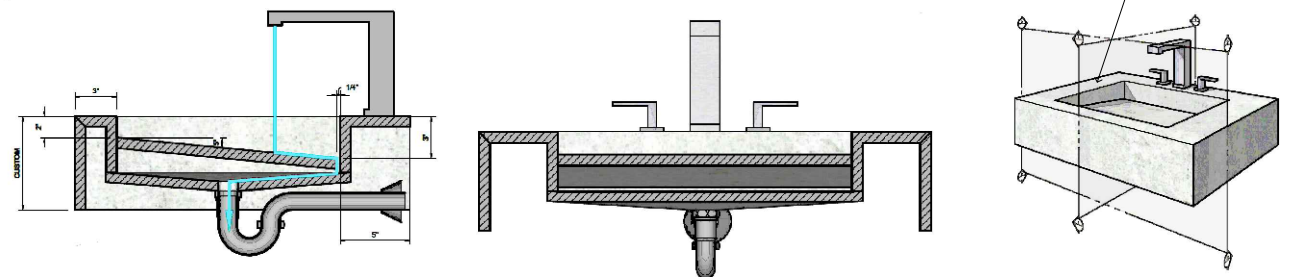

BATH MASTER BATHROOM

DETAILS

FINISH 1




KICO
MELAMINE DOLCE MORDESCO

FINISH 2



KICO
LINO TESSUTO - CARCASS

HANDLE COLOR

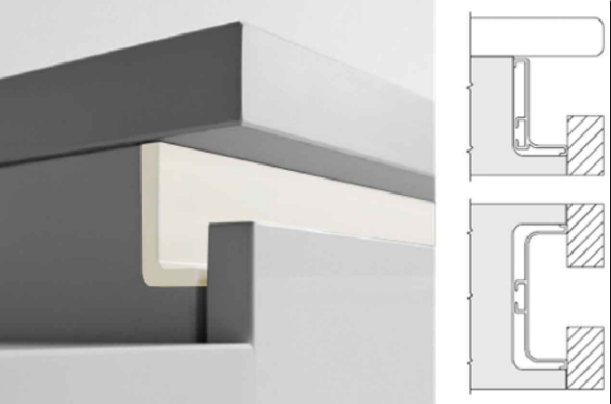

BASE CABINETS
INTEGRATED GOLA - MATCH FINISH 1



DRAWERS
BLUM LEGRABOX



INTERNAL DRAWERS
BLUM LEGRABOX - GREY



LED LIGHTS
INTEGRATED LED LIGHTS UNDER WALL CABINETS

PROJECT # 0000-000

CONTINUUM NORTH

KITCHEN - OFFICE - CLOSETS - VANITIES

NOTES:

CLIENT APPROVED

DRAWINGS ☐

NOTES ☐

DATE: _____

SIGNATURE: _____

REVISION LOG





1.0	03/30/2026
2.0	05/12/2026
3.0	05/13/2026
4.0	05/19/2026
5.0	06/02/2026
6.0	06/09/2026
7.0	06/16/2026
8.0	06/30/2026
9.0	07/06/2026
10.0	07/14/2026

DATE: 07/14/2026

REV: 9.0

DIMENSION: CM/INCH

  DRAWN BY: KVA

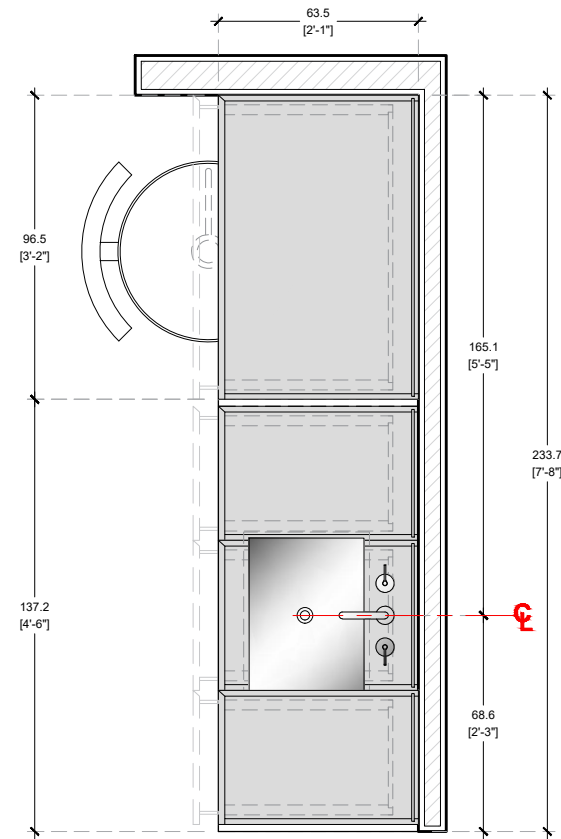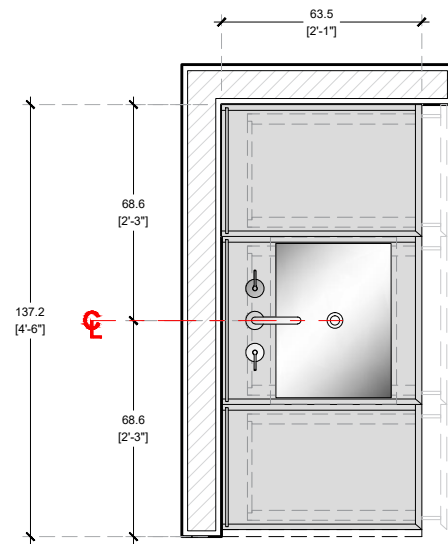

FLOOR PLAN SCALE 1/2"=1'-0"

CONTINUUM NORTH UNIT / MASTER BATHROOM

| ITALRKAFT | KICO

■ FINISH 1	MELAMINE DOLCE MORDESCO
■ GBAR	MELAMINE DOLCE MORDESCO
■ TOE KICK	FLOATING
■ CARCASS	LINO TESSUTO

PROJECT # 0000-0000

CONTINUUM NORTH

KITCHEN - OFFICE - CLOSETS - VANITIES

NOTES:

CLIENT APPROVED

DRAWINGS ☐NOTES ☐

DATE: _____

SIGNATURE:

REVISION LOG

1.0	03/30/2026
2.0	05/12/2026
3.0	05/13/2026
4.0	05/19/2026
5.0	06/02/2026
6.0	06/09/2026
7.0	06/16/2026
8.0	06/30/2026
9.0	07/06/2026
10.0	07/14/2026

DATE: 07/14/2026

REV: 9.0

DIMENSION: CM/INCH


DRAWN BY: KVA

PROJECT # 0000-000
CONTINUUM NORTH
KITCHEN - OFFICE - CLOSETS - VANITIES
NOTES:

CLIENT APPROVED
DRAWINGS ☐
NOTES ☐
DATE:
SIGNATURE:

REVISION LOG	
1.0	03/30/2026
2.0	05/12/2026
3.0	05/13/2026
4.0	05/19/2026
5.0	06/02/2026
6.0	06/09/2026
7.0	06/16/2026
8.0	06/30/2026
9.0	07/06/2026
10.0	07/14/2026


DATE: 07/14/2026
REV: 9.0
DIMENSION: CM/INCH
DRAWN BY: KVA

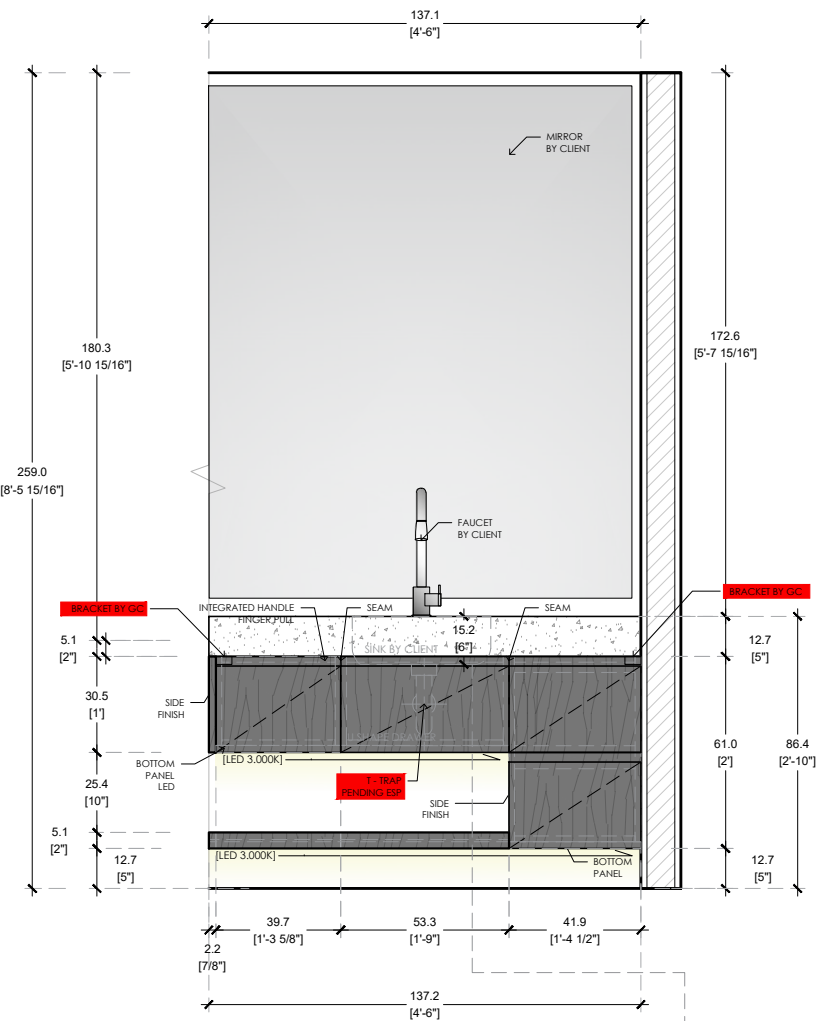

ELEVATION A SCALE 1/2"=1'-0"
CONTINUUM NORTH UNIT / MASTER BATHROOM


| ITALKRAFT | KICO

FINISH 1
GBAR
TOE KICK
CARCASS
MELAMINE DOLCE MORDESCO
MELAMINE DOLCE MORDESCO
FLOATING
LINO TESSUTO

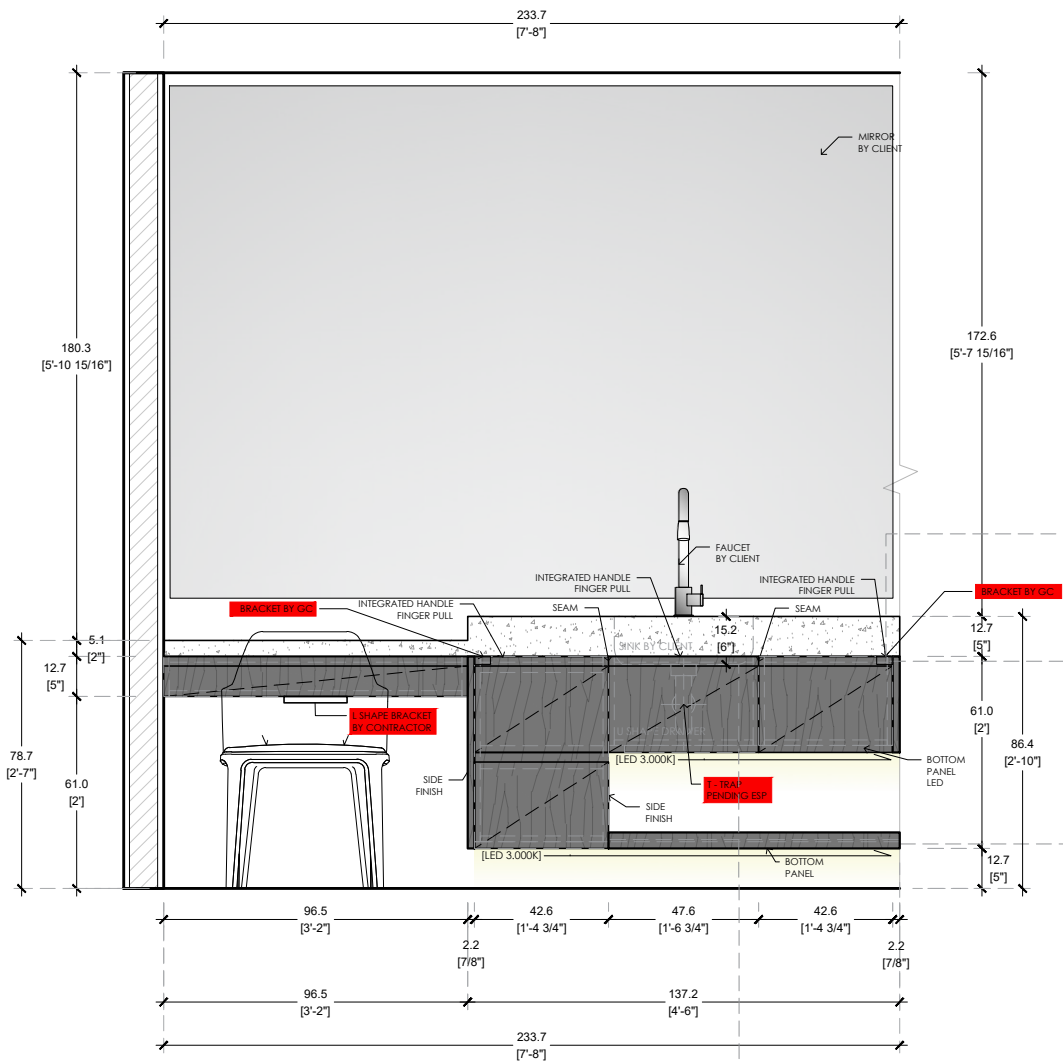


ELEVATION B SCALE 1/2"=1'-0"
CONTINUUM NORTH UNIT / MASTER BATHROOM


SINK DETAIL

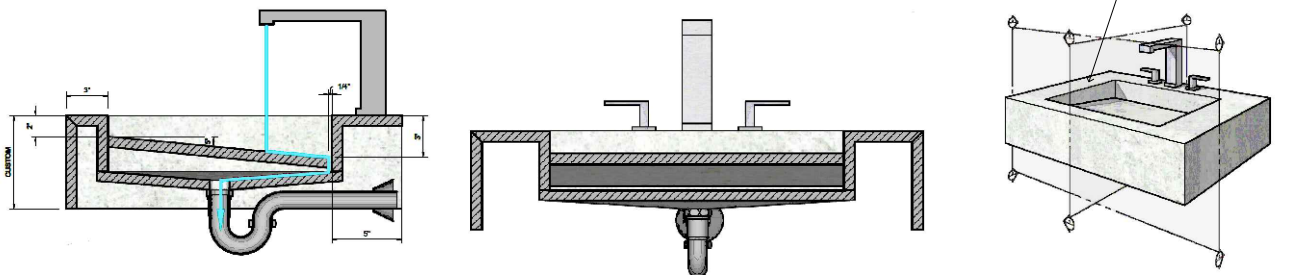


BRACKET DETAIL

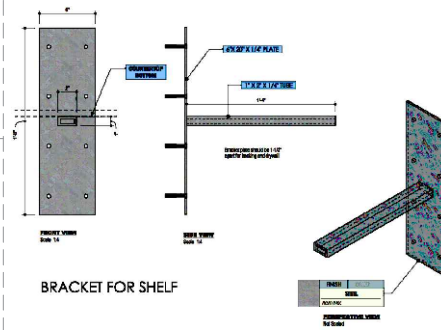


DETAIL BOTTOM
PANEL LED

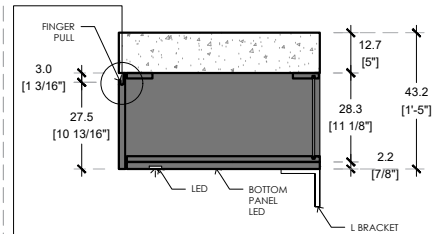

FINGER PULL

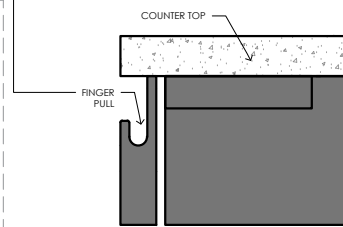

DETAIL BOTTOM
PANEL LED

 

PROJECT #	0000-000
CONTINUUM NORTH	
KITCHEN - OFFICE - CLOSETS - VANITIES	
NOTES:	

CLIENT APPROVED

DRAWINGS☐

NOTES☐

DATE: _____

SIGNATURE: _____

REVISION LOG

1.0	03/30/2026
2.0	05/12/2026
3.0	05/13/2026
4.0	05/19/2026
5.0	06/02/2026
6.0	06/09/2026
7.0	06/16/2026
8.0	06/30/2026
9.0	07/06/2026
10.0	07/14/2026

DATE: 07/14/2026

REV: 9.0

DIMENSION: CM/INCH


DRAWN BY: KVA

TECHNICAL PLANS

BUILT TO
DIMENSIONS

FLOOR PLAN SCALE 1/2"=1'-0"
CONTINUUM NORTH UNIT 2901 / KITCHEN

NEW BACKING BY CONTRACTOR
ELECTRICAL OUTLET BY CONTRACTOR
DIMENSIONS FROM ESTIMATED F.F. HEIGHT

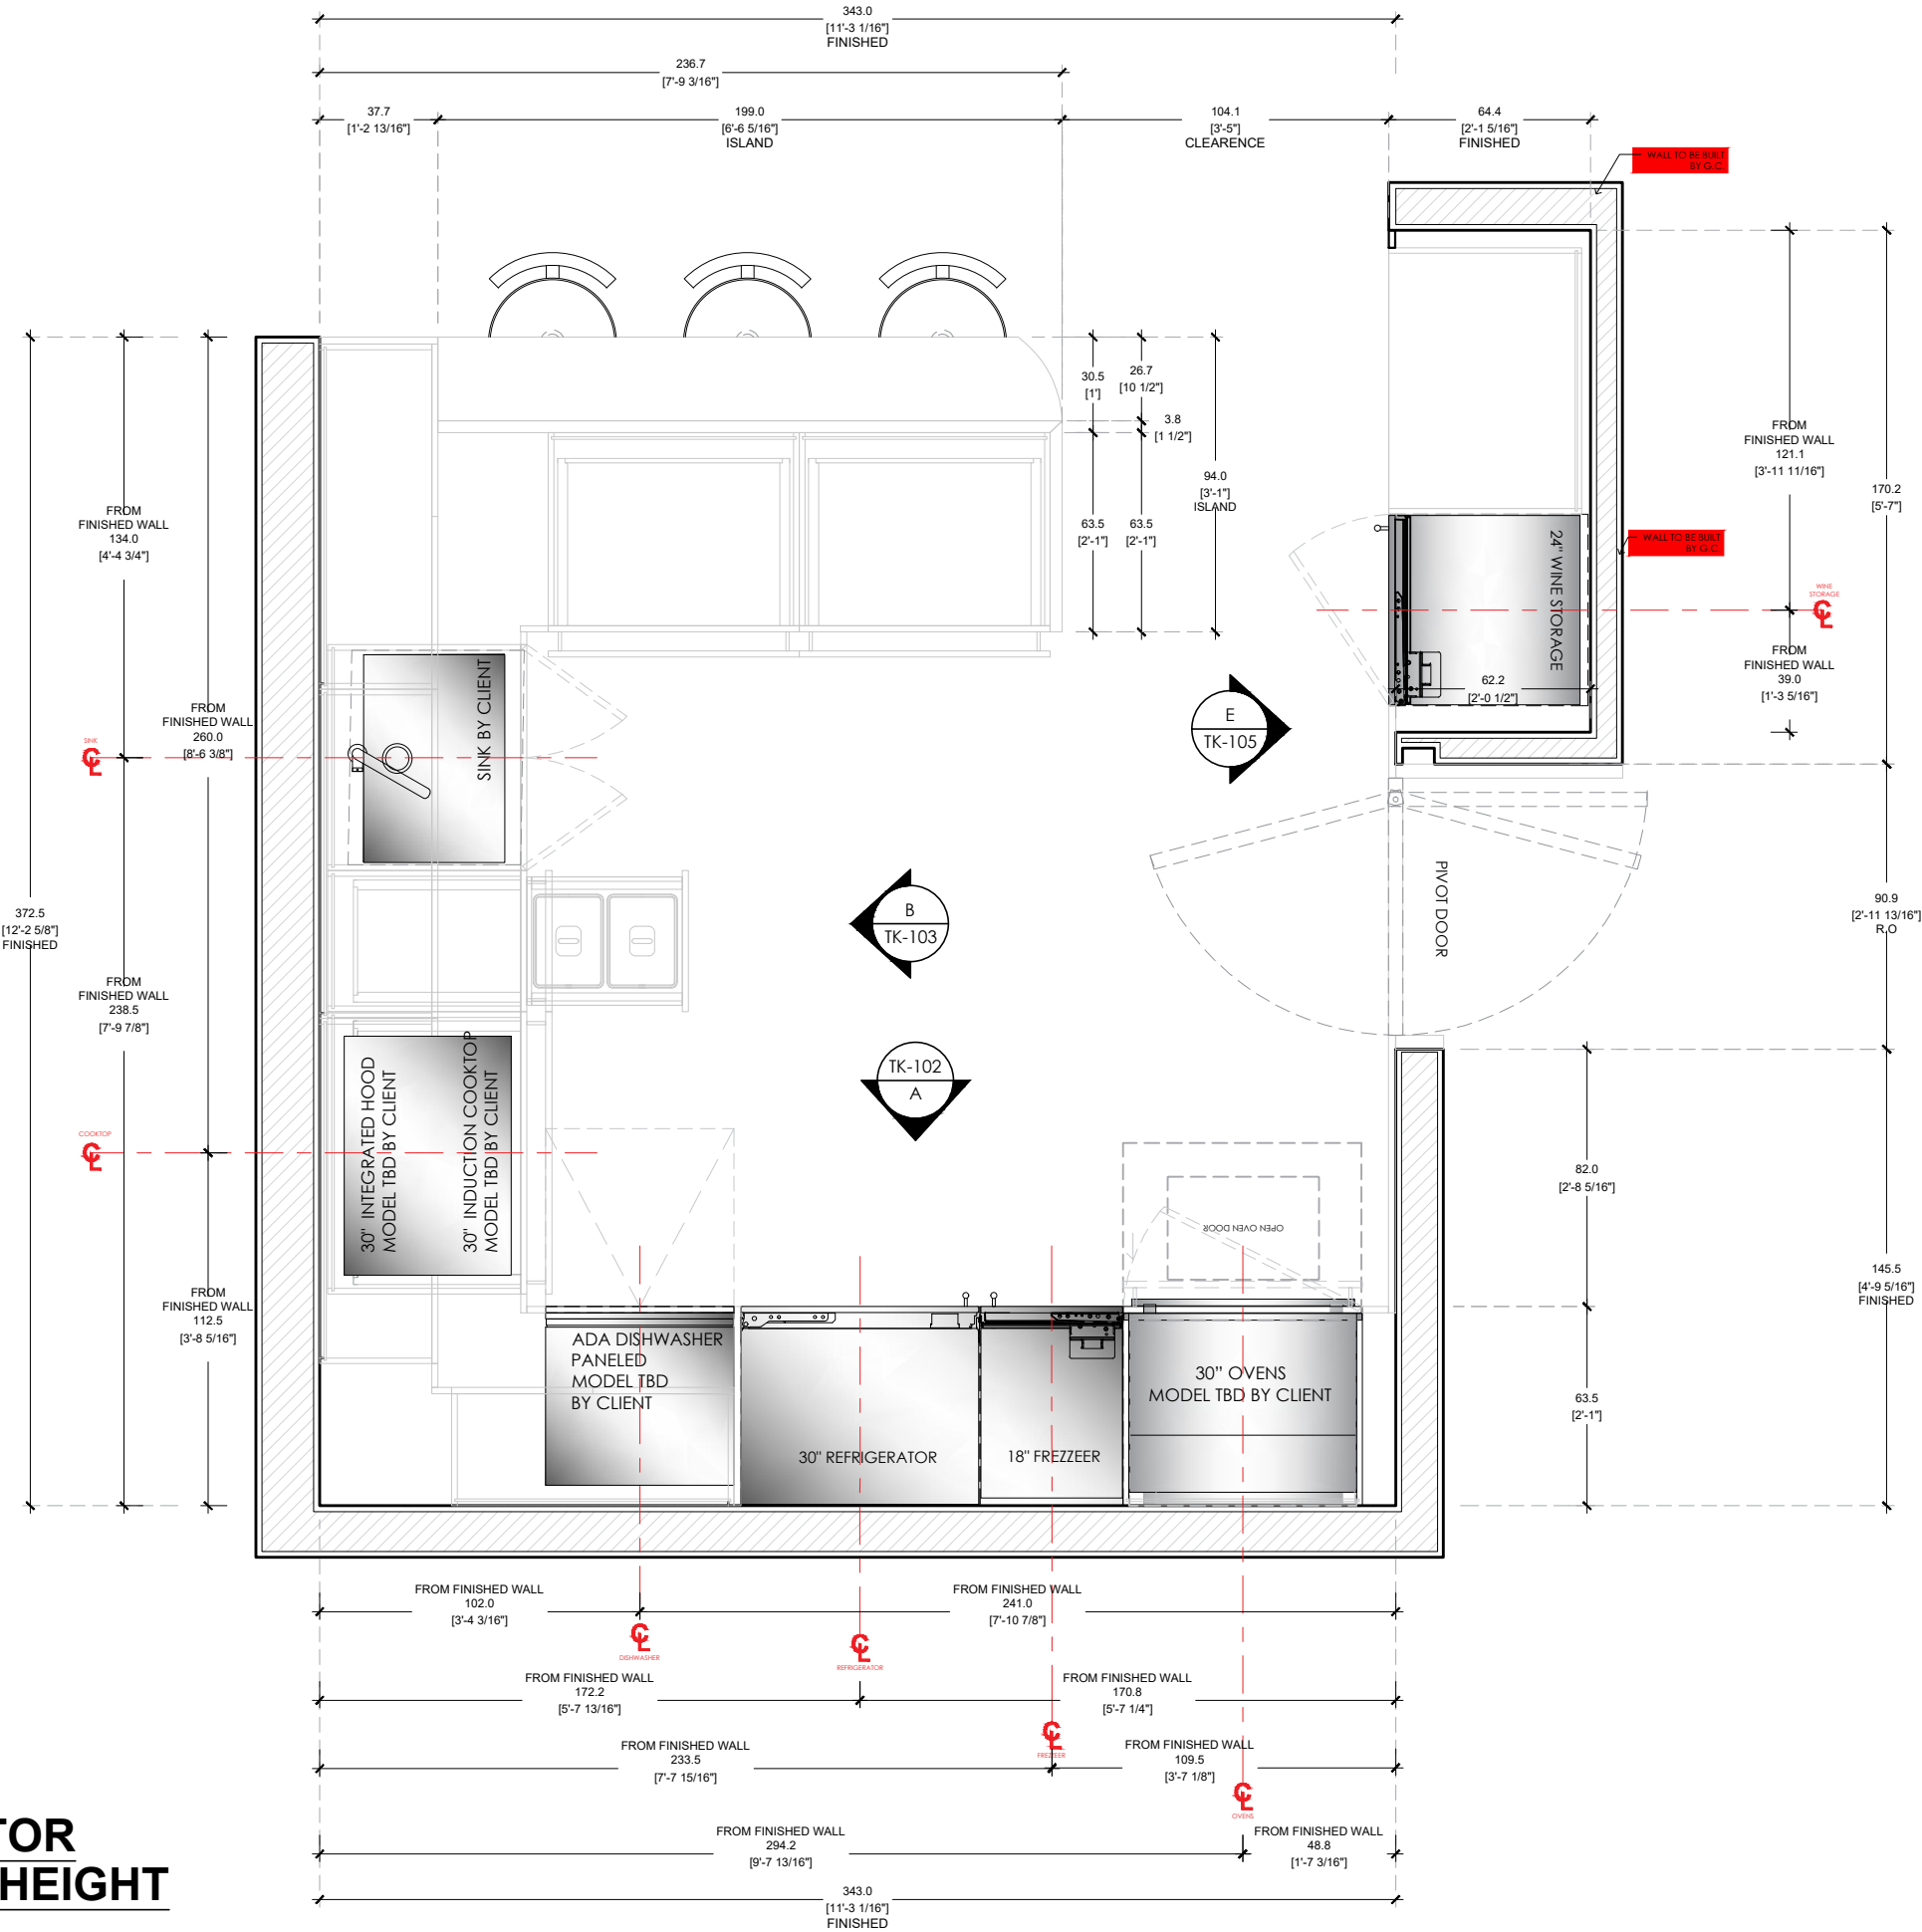

ITALKRAFT
KITCHENS | BATHS | CLOSETS

2900 NW 77TH CT. MIAMI FL, 33122
T. 305 406 1301 - F. 305 406 1302

PROJECT # 0000-000
CONTINUUM NORTH
KITCHEN - OFFICE - CLOSETS - VANITIES
NOTES:

CLIENT APPROVED

DRAWINGS ☐
NOTES ☐
DATE:
SIGNATURE:

REVISION LOG	
1.0	03/30/2026
2.0	05/12/2026
3.0	05/13/2026
4.0	05/19/2026
5.0	06/02/2026
6.0	06/09/2026
7.0	06/16/2026
8.0	06/30/2026
9.0	07/06/2026
10.0	07/14/2026

DATE: 07/14/2026
REV: 9.0
DIMENSION: CM/INCH
DRAWN BY: KVA

T-K101

PROJECT # 0000-000

CONTINUUM NORTH

KITCHEN - OFFICE - CLOSETS - VANITIES

NOTES:

CLIENT APPROVED

DRAWINGS ☐

NOTES ☐

DATE: _____

SIGNATURE: _____

REVISION LOG

1.0	03/30/2026
2.0	05/12/2026
3.0	05/13/2026
4.0	05/19/2026
5.0	06/02/2026
6.0	06/09/2026
7.0	06/16/2026
8.0	06/30/2026
9.0	07/06/2026
10.0	07/14/2026


DATE: 07/14/2026

REV: 9.0

DIMENSION: CM/INCH


DRAWN BY: KVA

BUILT TO
DIMENSIONS

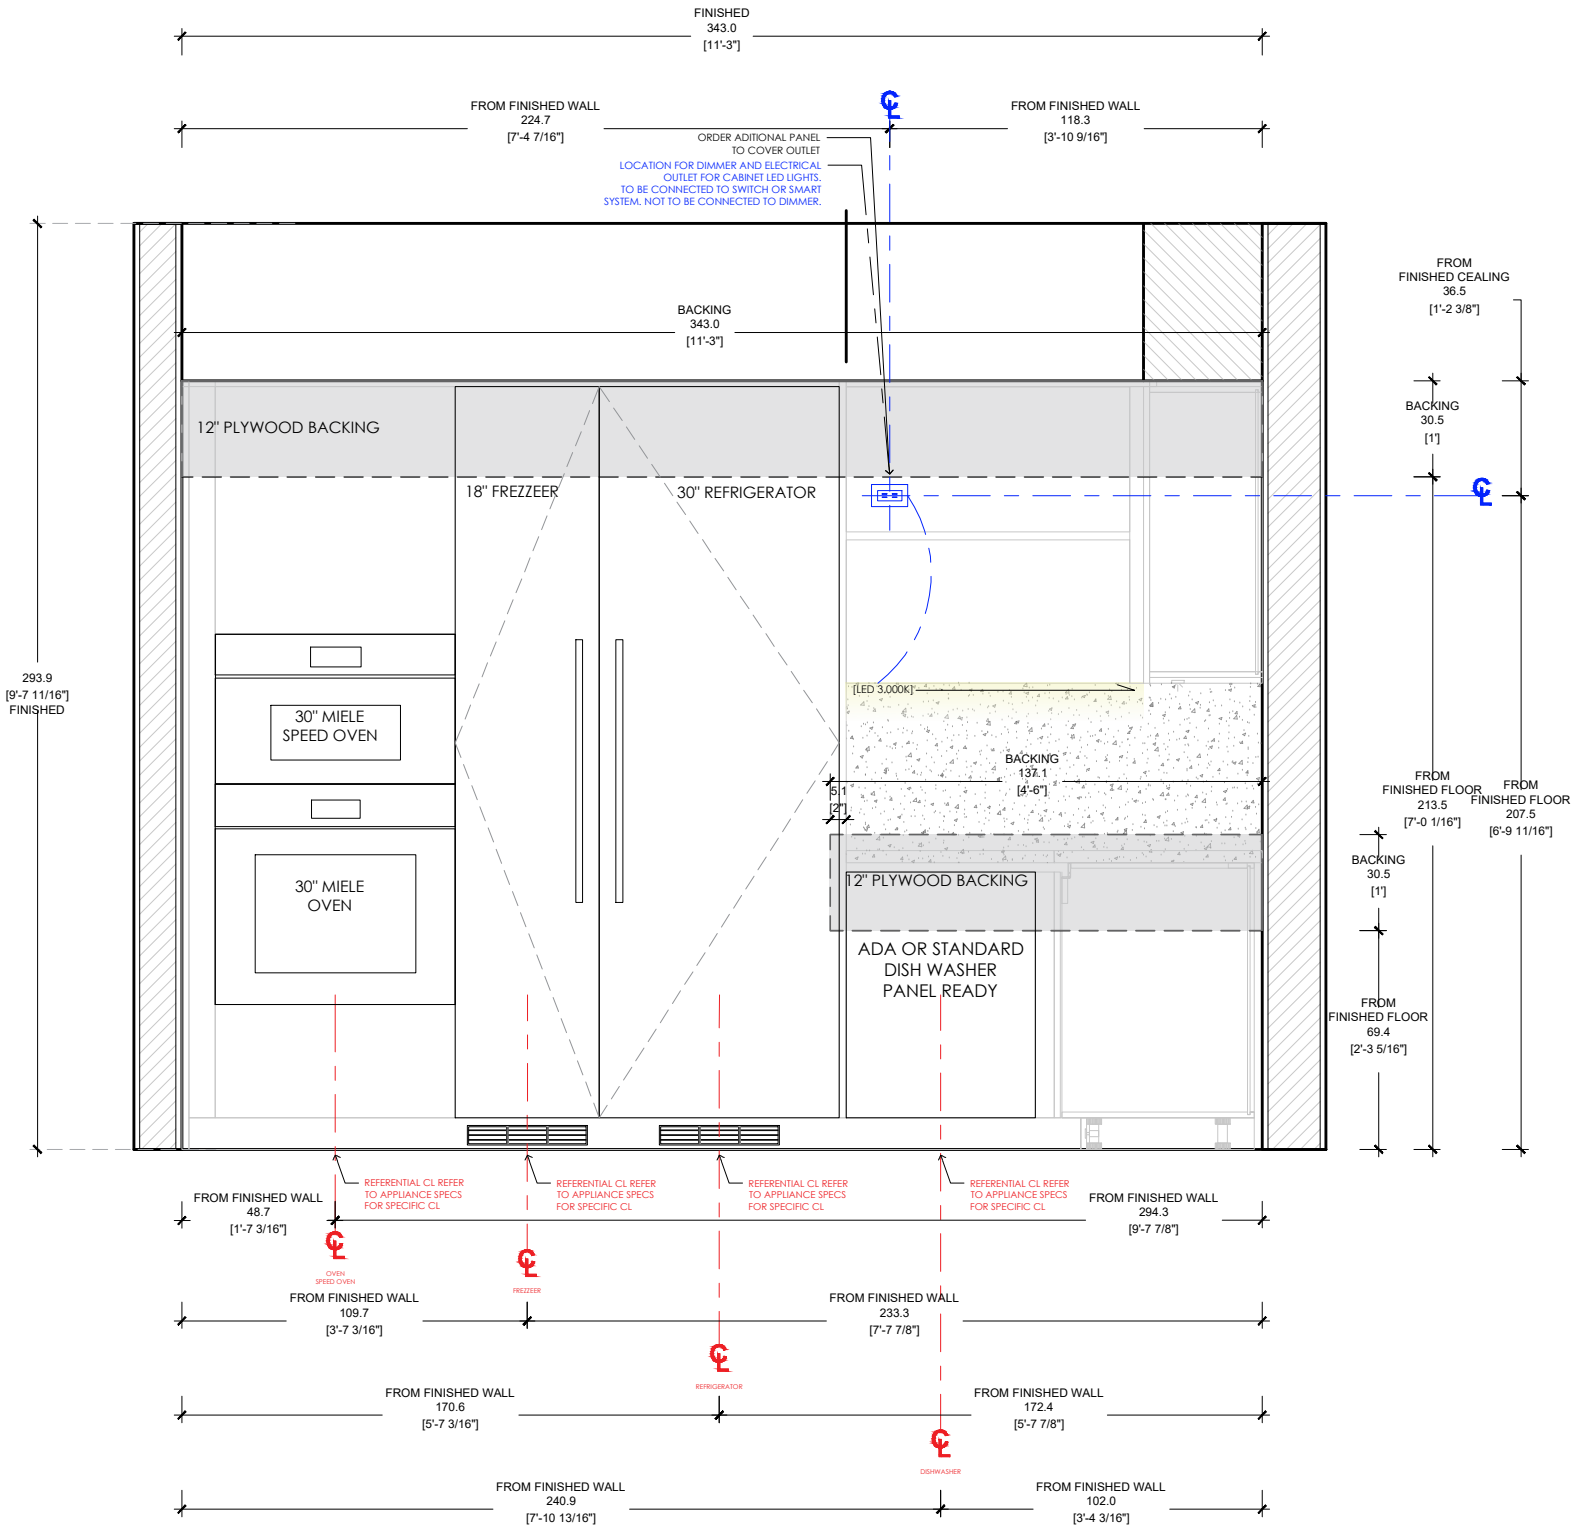


DETAIL REFERENCE

30" MIELE SINGLE OVEN
MODEL H7880BPXGRGR BY CLIENT

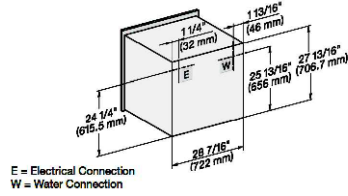


DETAIL REFERENCE

30" MIELE SPEED OVEN
MODEL H7870BMXGRGR BY CLIENT

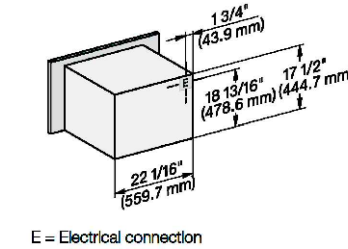


DETAIL REFERENCE

18" SUB ZERO COLUMN FREEZER
MODEL DEC1850FIL BY CLIENT

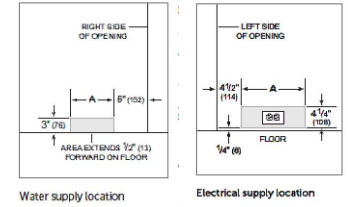

DETAIL REFERENCE


30" SUB ZERO COLUMN REFRIGERATOR
MODEL DEC3050RR BY CLIENT

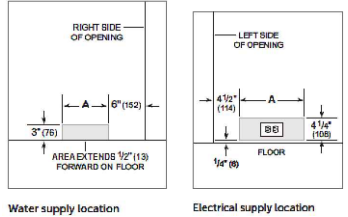


ELEVATION A SCALE 1/2"=1'-0"
CONTINUUM NORTH UNIT 2901 / KITCHEN

NEW BACKING BY CONTRACTOR
ELECTRICAL OUTLET BY CONTRACTOR
DIMENSIONS FROM ESTIMATED F.F. HEIGHT


BUILT TO DIMENSIONS

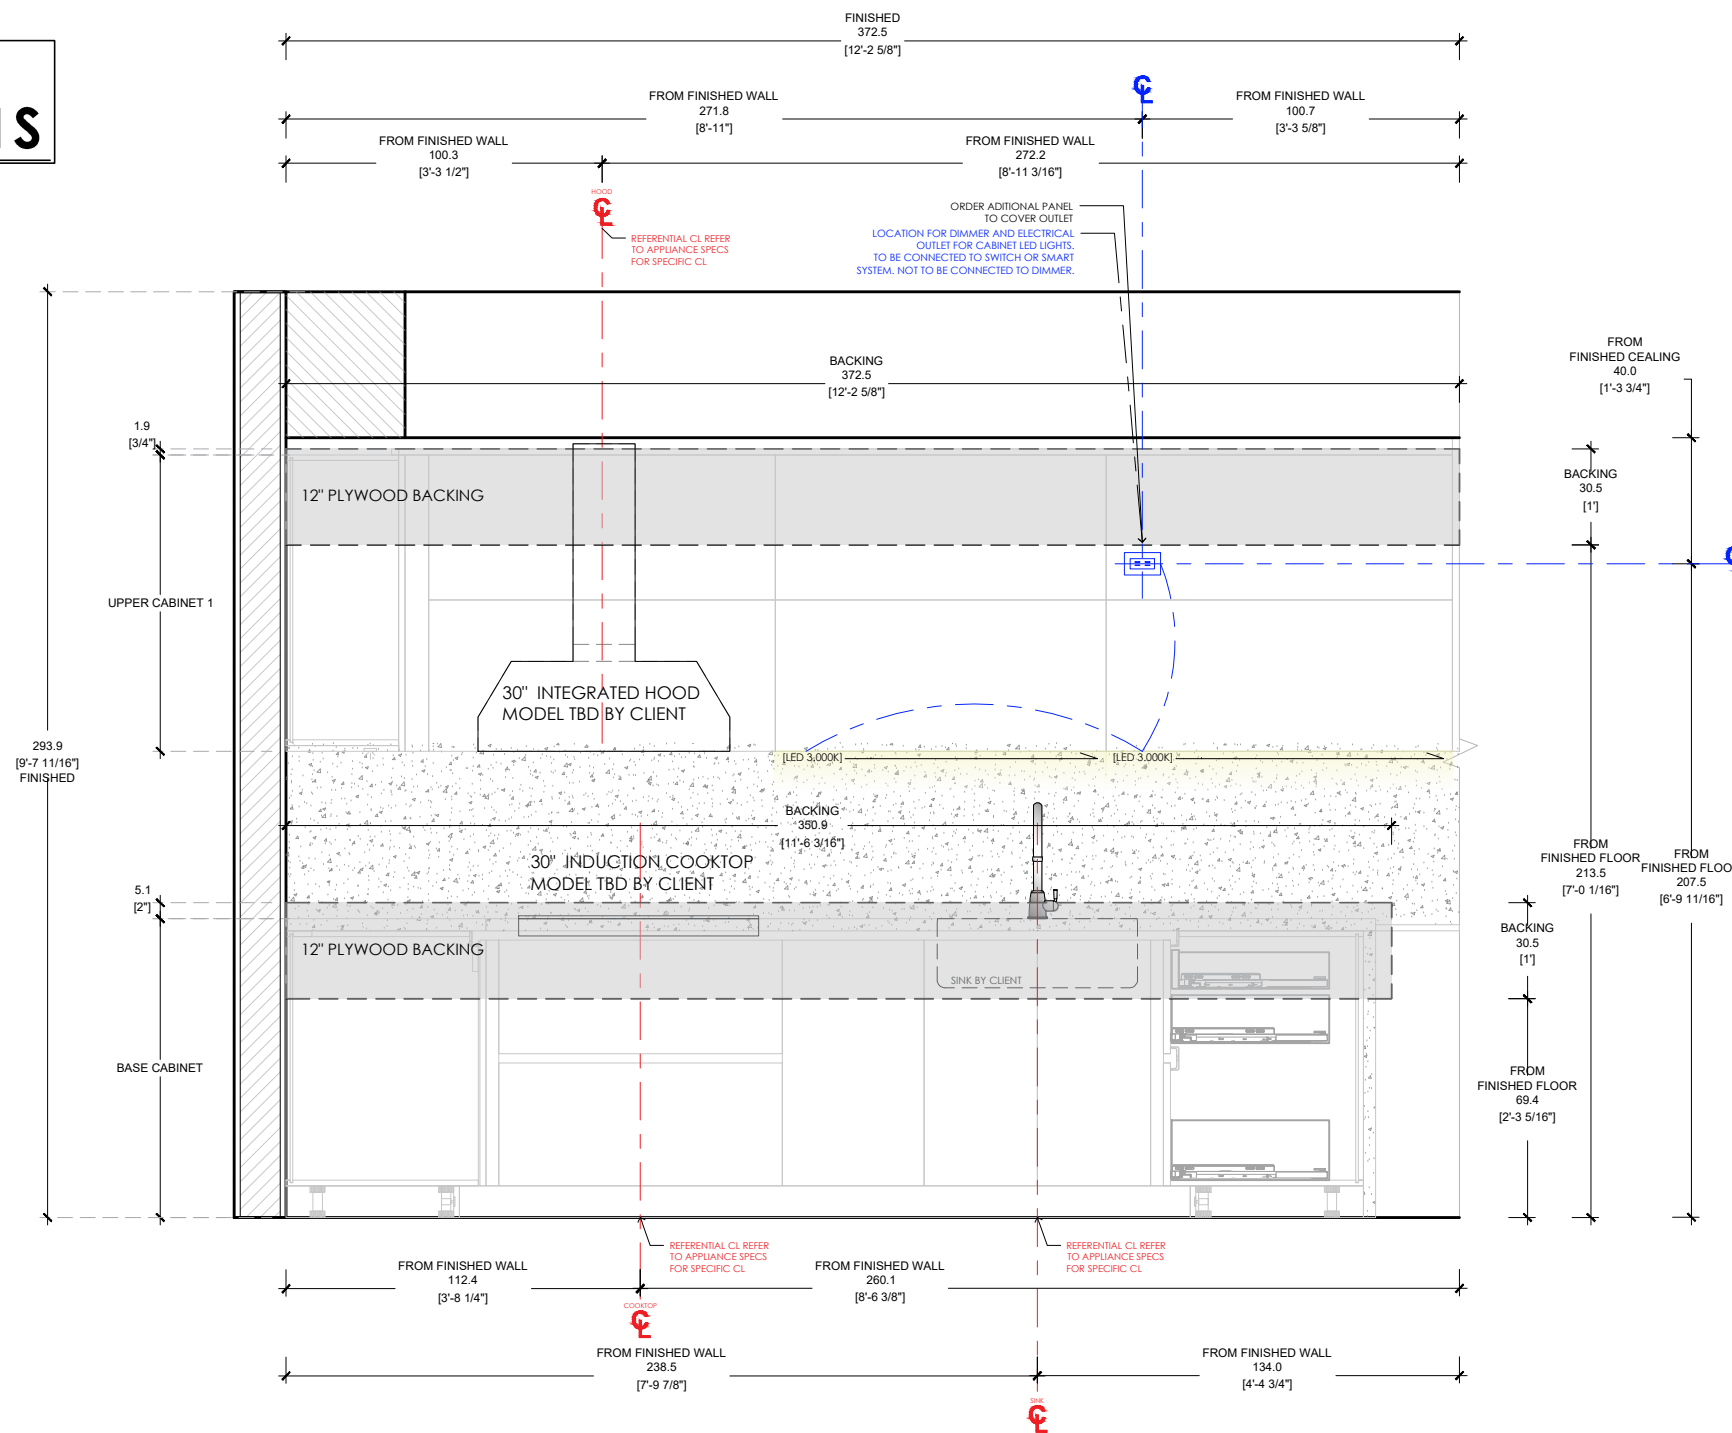

DETAIL REFERENCE
28" FALMEC VALENTINA HOOD
MODEL FIVAL28B5SSRI BY CLIENT

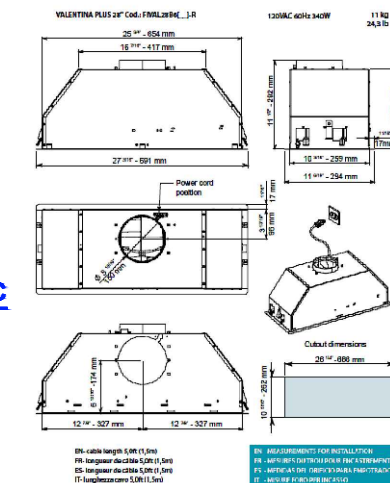

DETAIL REFERENCE
30" MIELE INDUCTION COOKTOP
MODEL H7870BMXGRGR BY CLIENT

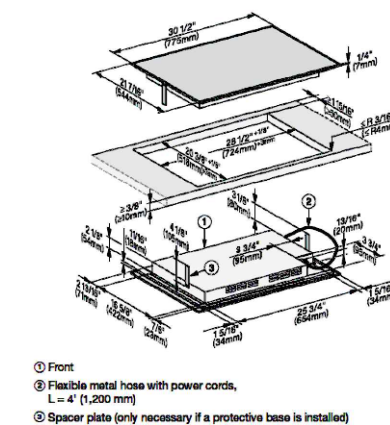

ITALKRAFT
KITCHENS | BATHS | CLOSETS

2900 NW 77TH CT. MIAMI FL, 33122
T. 305 406 1301 - F. 305 406 1302

PROJECT # 0000-000

CONTINUUM NORTH

KITCHEN - OFFICE - CLOSETS - VANITIES

NOTES:

CLIENT APPROVED

DRAWINGS 

NOTES □

DATE: _____

SIGNATURE:

REVISION LOG

1.0	03/30/2026
2.0	05/12/2026
3.0	05/13/2026
4.0	05/19/2026
5.0	06/02/2026
6.0	06/09/2026
7.0	06/16/2026
8.0	06/30/2026
9.0	07/06/2026
10.0	07/14/2026

DATE: 07/14/2026


REV: 9.0

DIMENSION: CM/INCH

DRAWN BY: KVA

T-K103


BUILT TO
DIMENSIONS

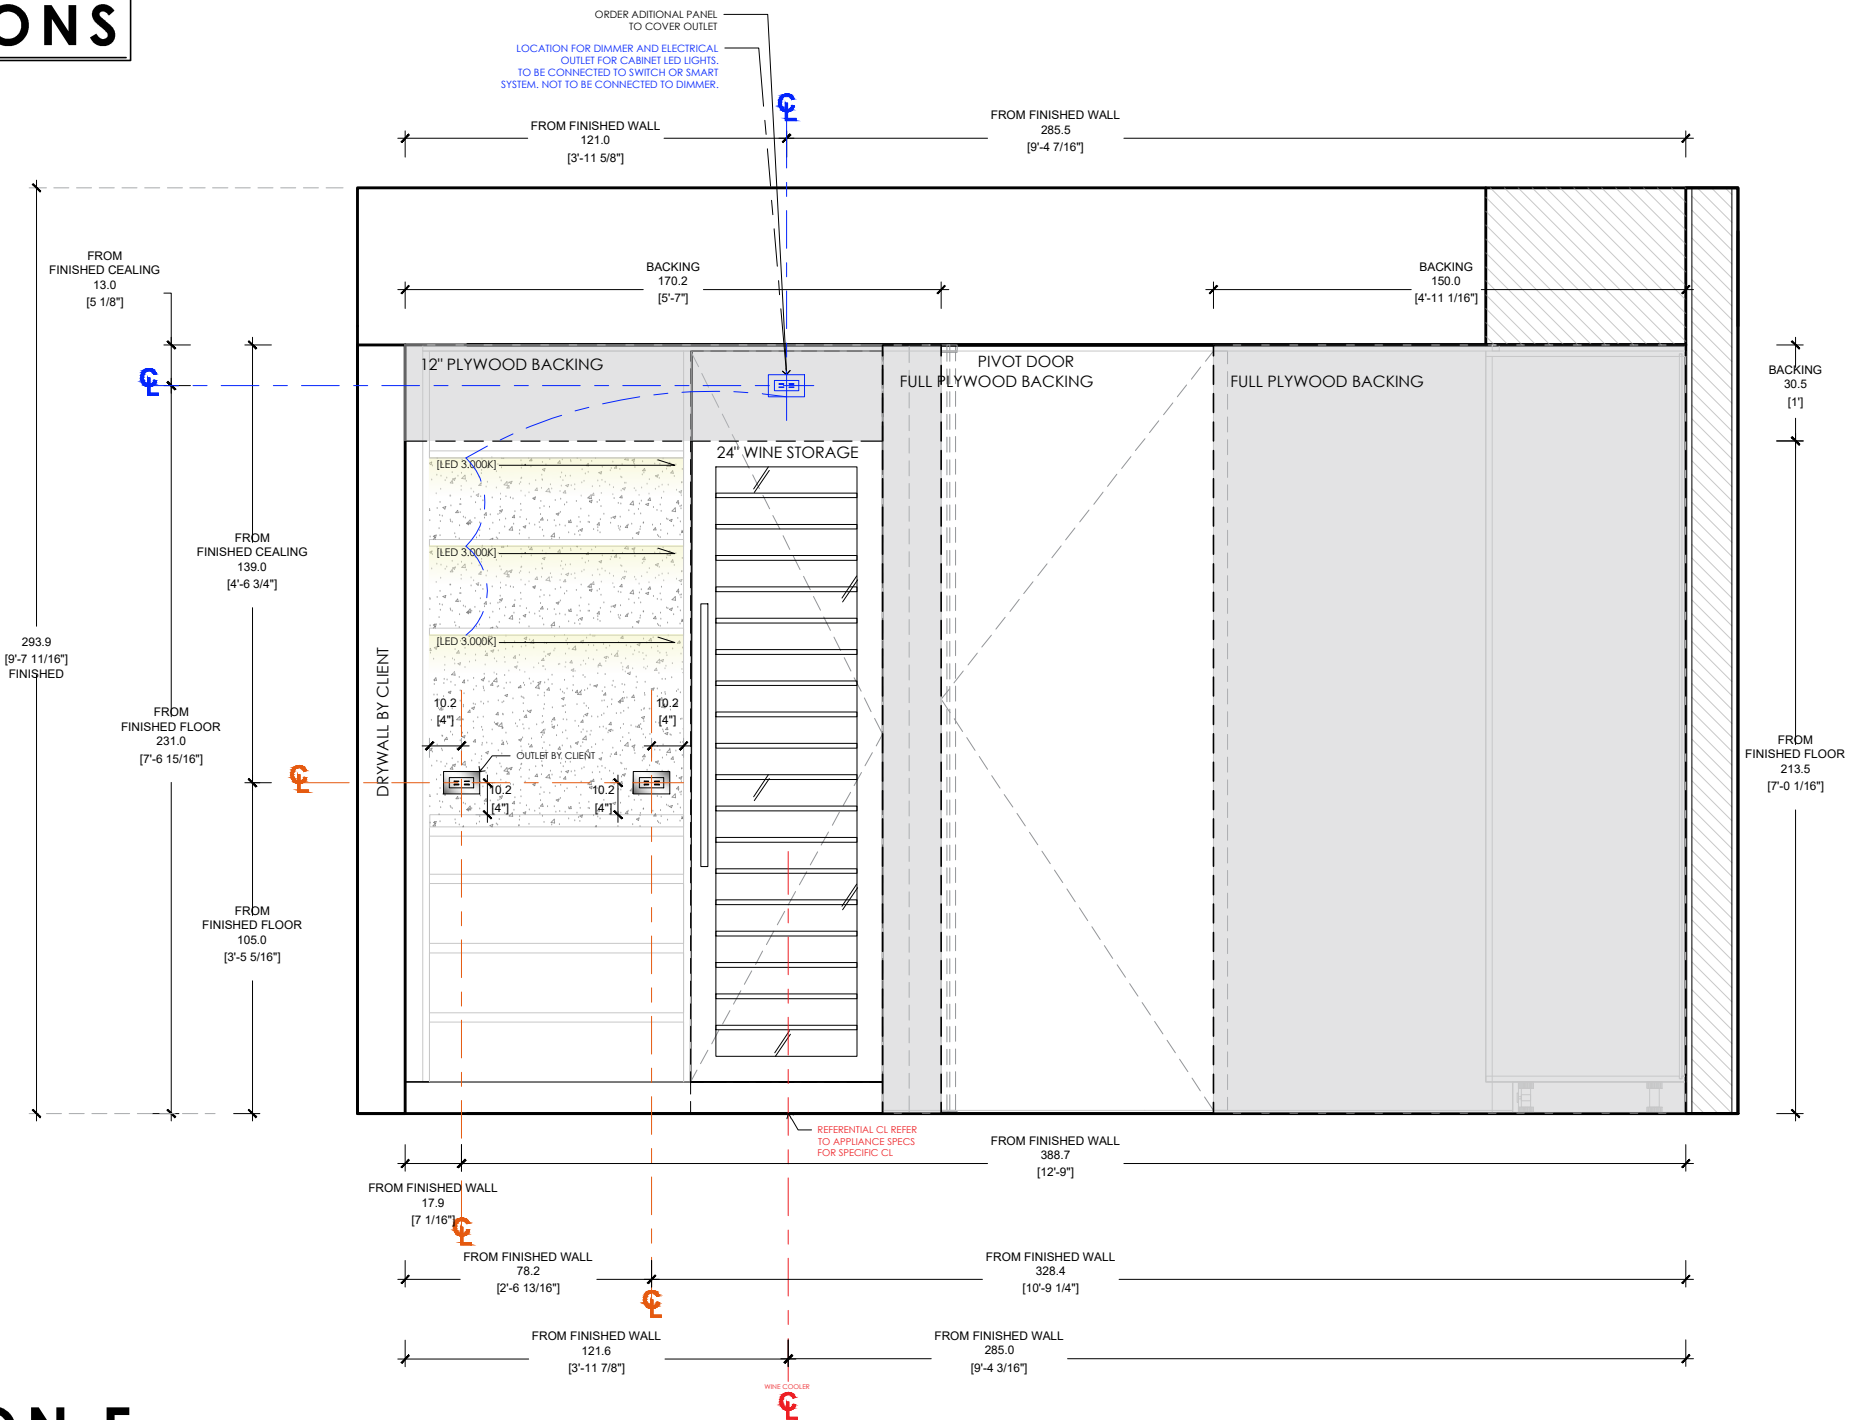

DETAIL REFERENCE

24" MIELE WINE PANEL READY

MODEL KWT2662VIS BY CLIENT

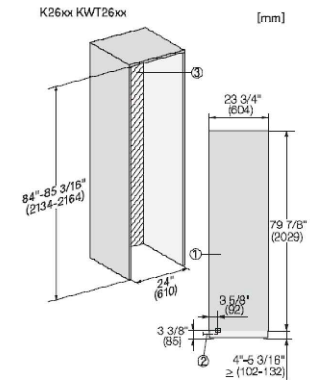

Installation, MasterCool, *footnote, installation drawings

1. View from the front, 2. Mains connection cable, L = 3000 mm (118 inch), 3. No water/ELT connections permitted in this area

ELEVATION E SCALE 1/2"=1'-0"

CONTINUUM NORTH UNIT 2901 / KITCHEN

NEW BACKING BY CONTRACTOR

ELECTRICAL OUTLET BY CONTRACTOR

DIMENSIONS FROM ESTIMATED F.F. HEIGHT

ITALKRAFT

KITCHENS | BATHS | CLOSETS

2900 NW 77TH CT. MIAMI FL. 33122

T. 305 406 1301 - F. 305 406 1302

PROJECT # 0000-000

CONTINUUM NORTH

KITCHEN - OFFICE - CLOSETS - VANITIES

NOTES:

CLIENT APPROVED

DRAWINGS ☐

NOTES ☐

DATE: _____

SIGNATURE: _____

REVISION LOG

1.0	03/30/2026
2.0	05/12/2026
3.0	05/13/2026
4.0	05/19/2026
5.0	06/02/2026
6.0	06/09/2026
7.0	06/16/2026
8.0	06/30/2026
9.0	07/06/2026
10.0	07/14/2026

DATE: 07/14/2026


REV: 9.0

DIMENSION: CM/INCH

DRAWN BY: KVA


T-K105

BUILT TO
DIMENSIONS

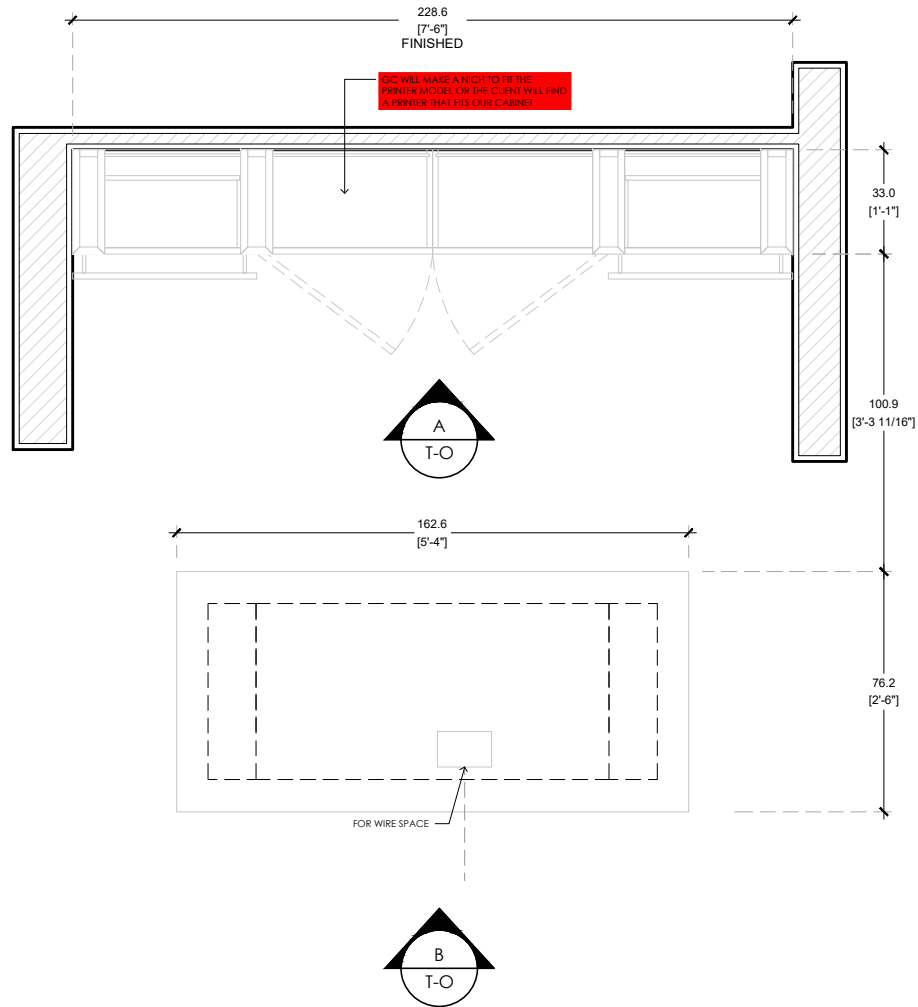

FLOOR PLAN SCALE 1/2"=1'-0"
CONTINUUM NORTH UNIT 2901 / OFFICE

NEW BACKING BY CONTRACTOR
ELECTRICAL OUTLET BY CONTRACTOR
DIMENSIONS FROM ESTIMATED F.F. HEIGHT

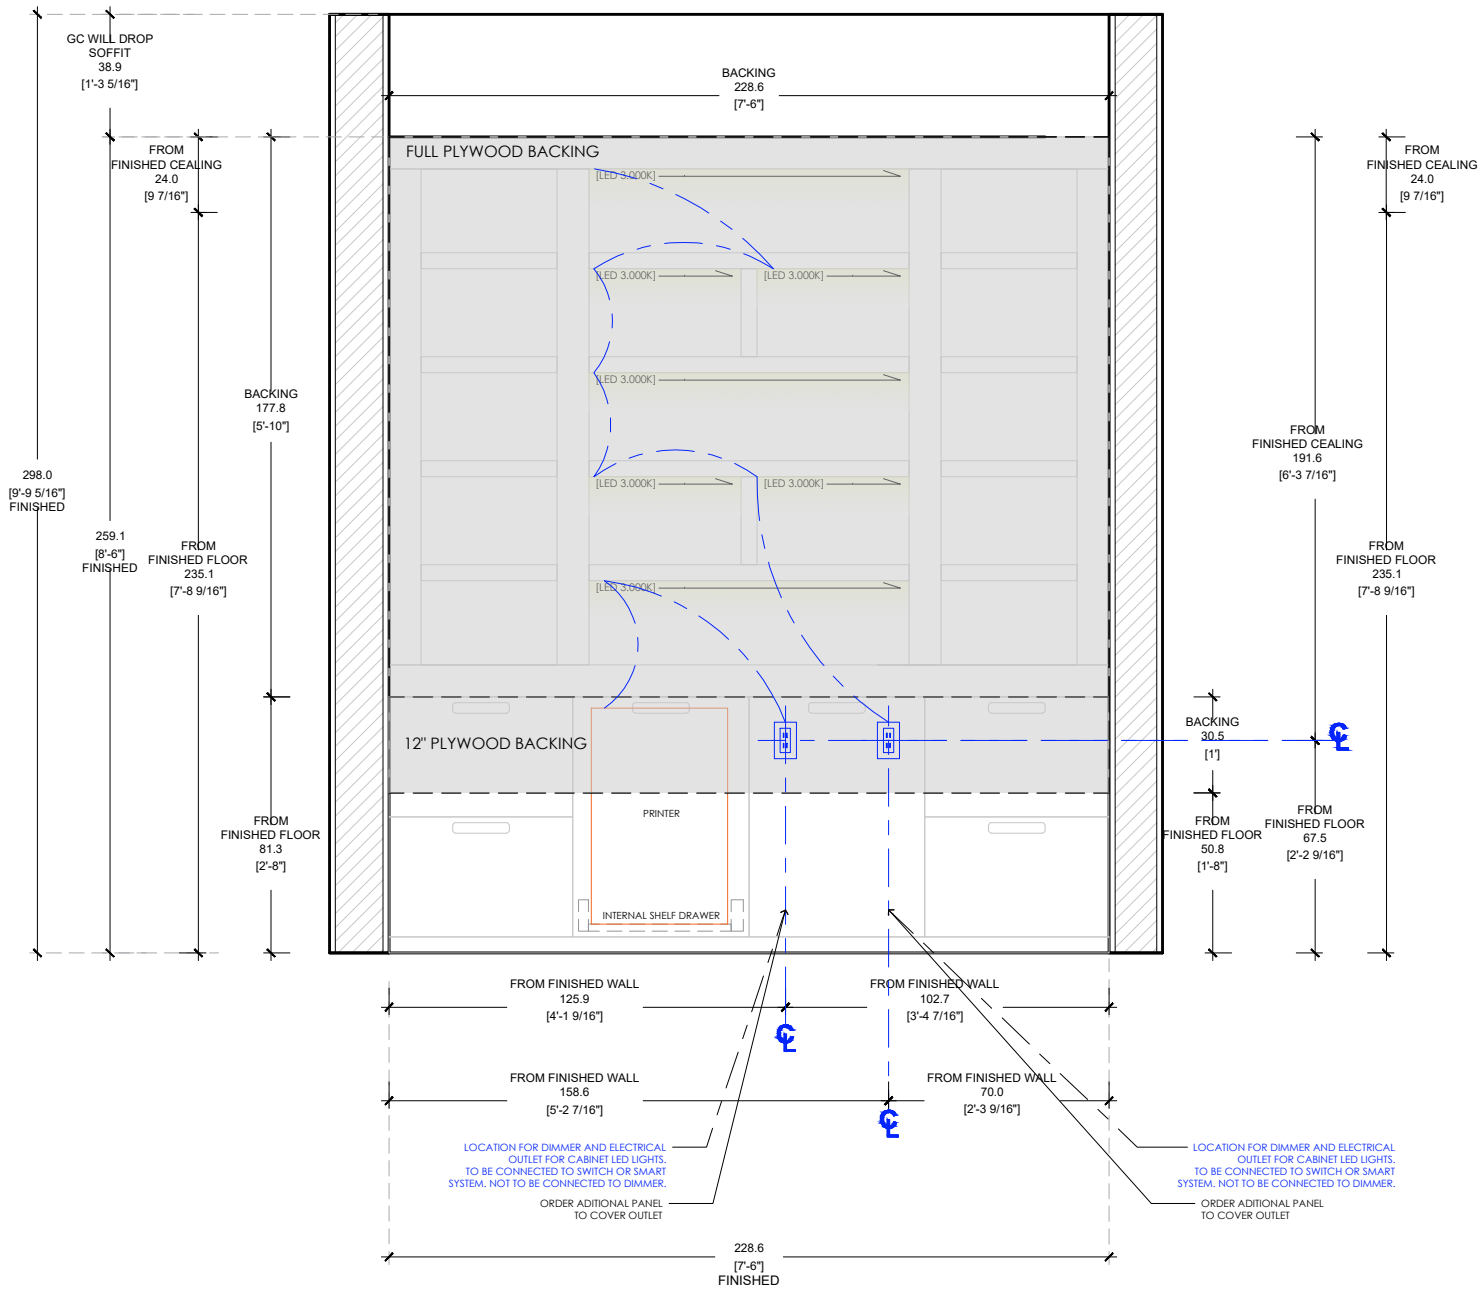

ELEVATION A SCALE 1/2"=1'-0"
CONTINUUM NORTH UNIT 2901 / OFFICE

ITALKRAFT

KITCHENS | BATHS | CLOSETS
2900 NW 77TH CT. MIAMI FL. 33122
T. 305 406 1301 - F. 305 406 1302

PROJECT # 0000-000
CONTINUUM NORTH
KITCHEN - OFFICE - CLOSETS - VANITIES

CLIENT APPROVED


DRAWINGS ☐
NOTES ☐
DATE:
SIGNATURE:

REVISION LOG	
1.0	03/30/2026
2.0	05/12/2026
3.0	05/13/2026
4.0	05/19/2026
5.0	06/02/2026
6.0	06/09/2026
7.0	06/16/2026
8.0	06/30/2026
9.0	07/06/2026
10.0	07/14/2026

DATE: 07/14/2026
REV: 9.0
DIMENSION: CM/INCH
DRAWN BY: KVA

T-O

BUILT TO
DIMENSIONS

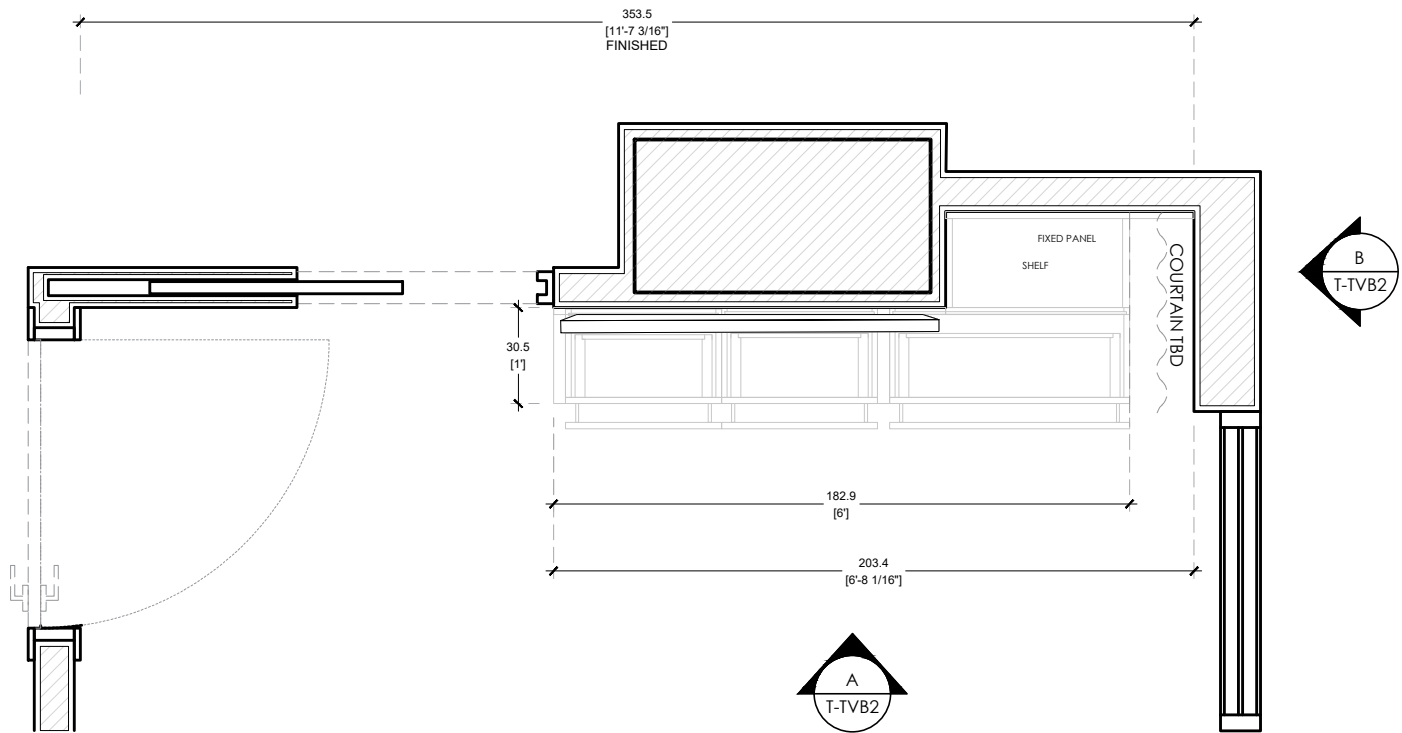

FLOOR PLAN SCALE 1/2"=1'-0"
CONTINUUM NORTH UNIT 2901 / TV UNIT BEDROOM 2

NEW BACKING BY CONTRACTOR
ELECTRICAL OUTLET BY CONTRACTOR
DIMENSIONS FROM ESTIMATED F.F. HEIGHT





PROJECT #	0000-000
CONTINUUM NORTH	
KITCHEN - OFFICE - CLOSETS - VANITIES	
NOTES:	

CLIENT APPROVED	
DRAWINGS	☐
NOTES	☐
DATE:	
SIGNATURE:	

REVISION LOG		
1.0	03/30/2026	
2.0	05/12/2026	
3.0	05/13/2026	
4.0	05/19/2026	
5.0	06/02/2026	
6.0	06/09/2026	
7.0	06/16/2026	
8.0	06/30/2026	
9.0	07/06/2026	
10.0	07/14/2026	

DATE: 07/14/2026
REV: 9.0
DIMENSION: CM/INCH
DRAWN BY: KVA



BUILT TO DIMENSIONS

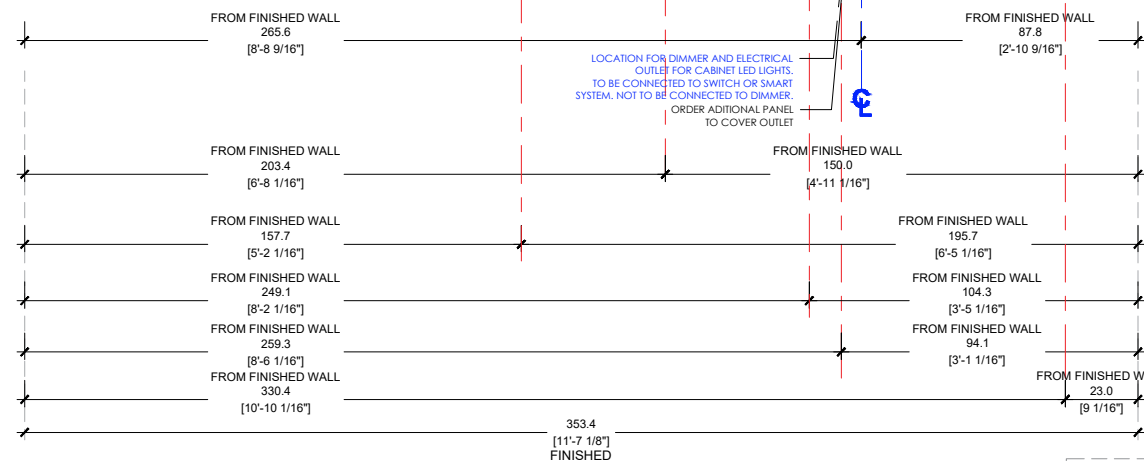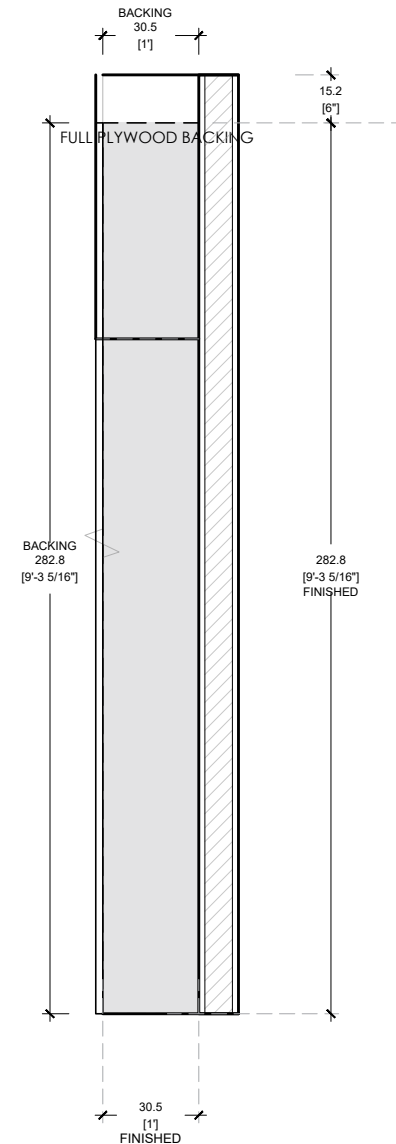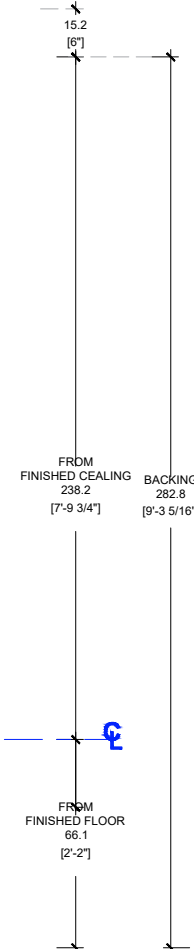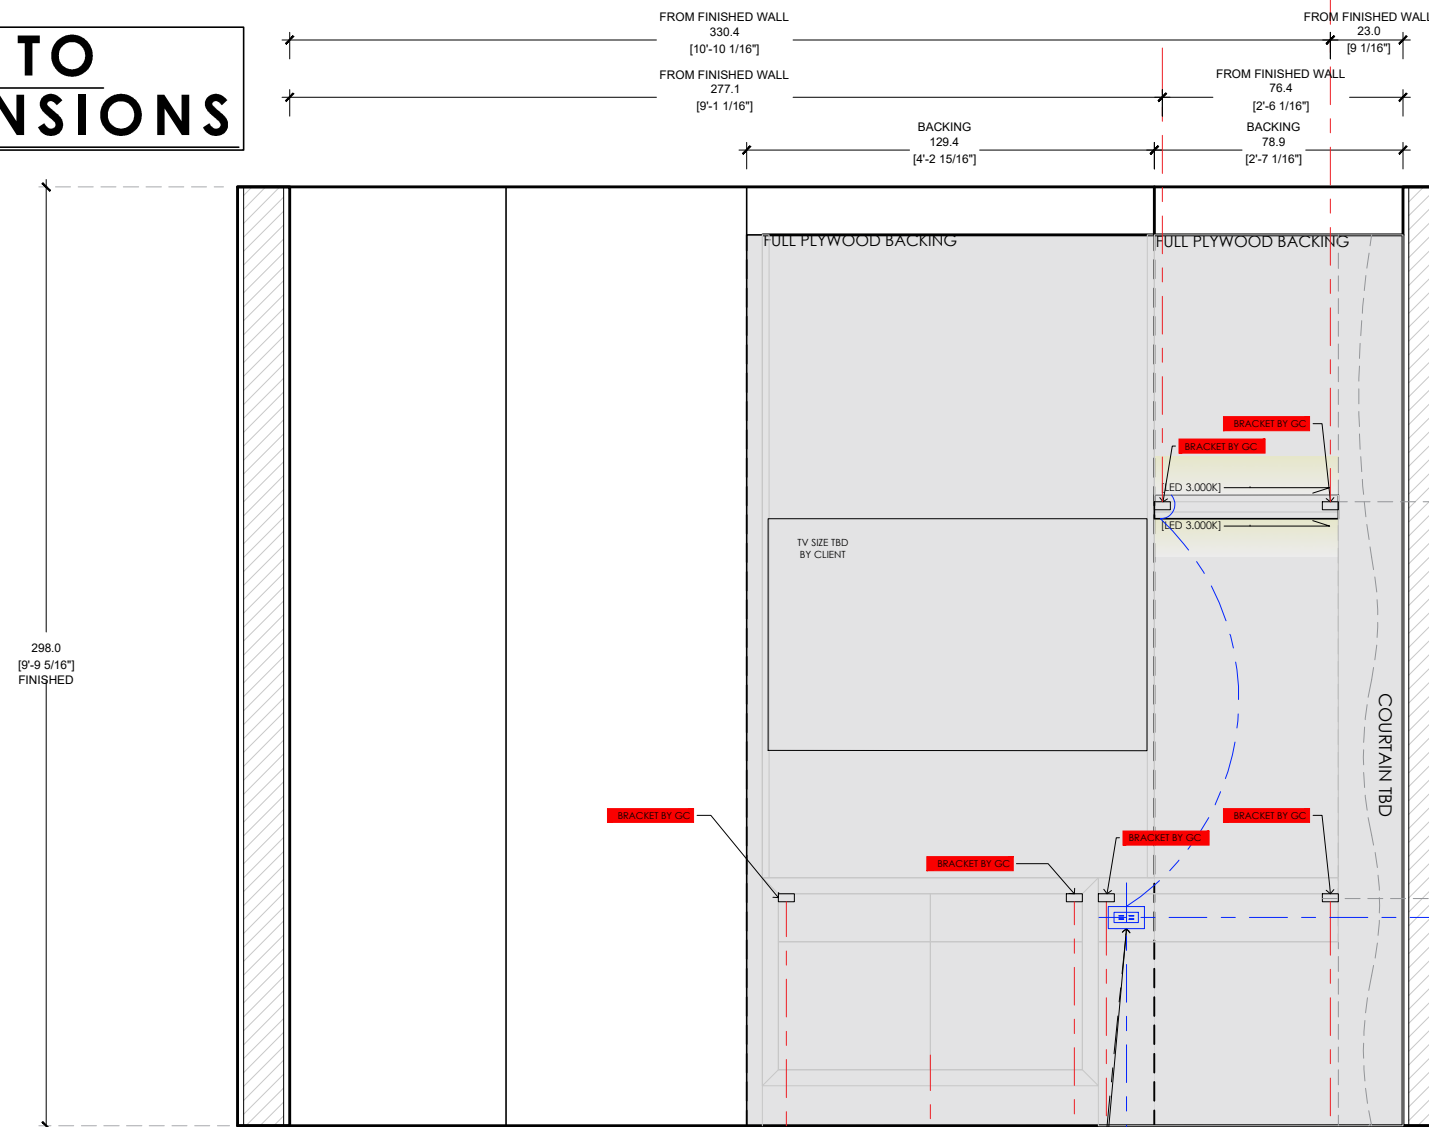

ELEVATION A SCALE 1/2"=1'-0"

CONTINUUM NORTH UNIT 2901 / TV UNIT BEDROOM 2

NEW BACKING BY CONTRACTOR
ELECTRICAL OUTLET BY CONTRACTOR
DIMENSIONS FROM ESTIMATED F.F. HEIGHT

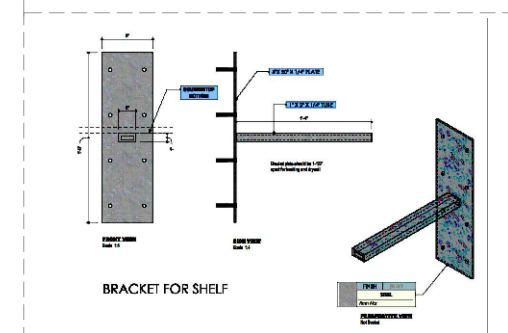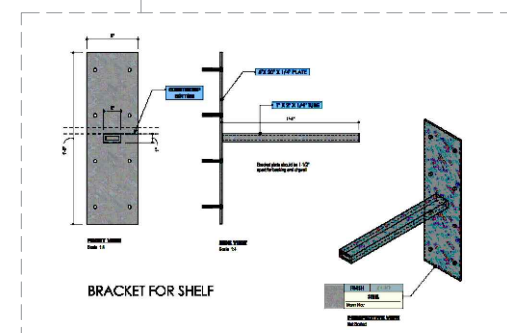

ITALKRAFT
KITCHENS | BATHS | CLOSETS

KITCHENS | BATHS | CLOSETS

2900 NW 77TH CT. MIAMI FL, 33122
T. 305 406 1301 - F. 305 406 1302

PROJECT # 0000-000

CONTINUUM NORTH

KITCHEN - OFFICE - CLOSETS - VANITIES

NOTES:

CLIENT APPROVED

DRAWINGS ☐

NOTES □

DATE: _____

SIGNATURE:

REVISION LOG

1.0	03/30/2026
-----	------------

2.0 05/12/2026

3.0 05/13/2026

4.0 05/19/2026

5.0 06/02/2026

6.0 06/09/2026

7.0 06/16/2026

8.0 06/30/2026

9.0 07/06/2026

10.0 07/14/2026

DATE: 07/14/2026


REV: 9.0

DIMENSION: CM/INCH

DRAWN BY: KVA

T-TVB2.1

BUILT TO
DIMENSIONS

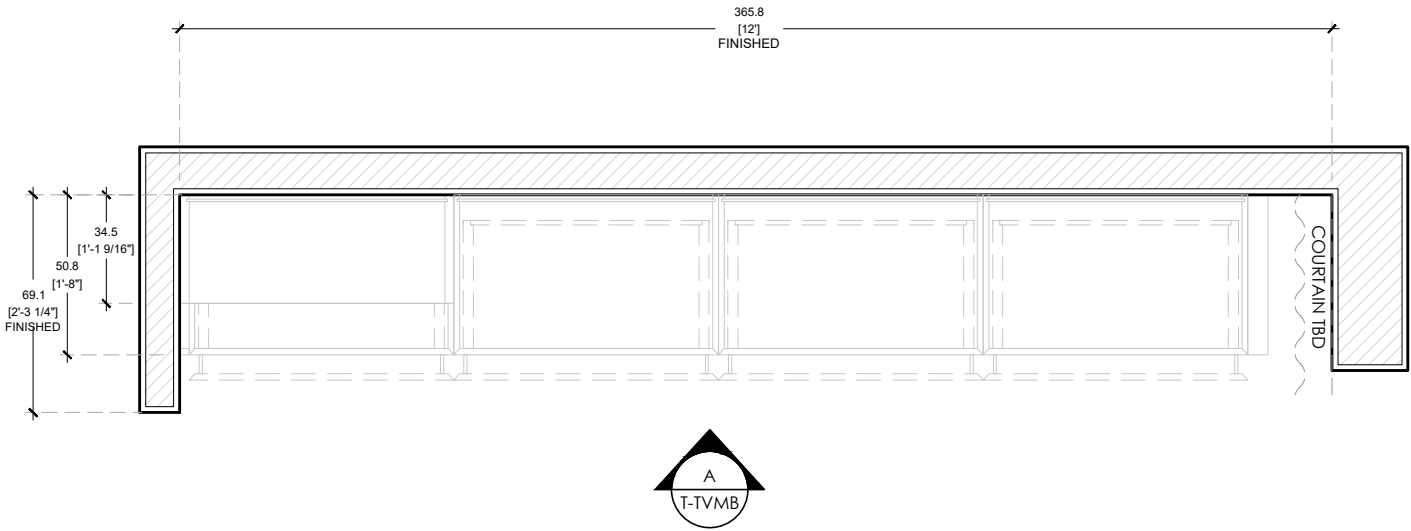

FLOOR PLAN SCALE 1/2"=1'-0"
CONTINUUM NORTH UNIT 2901 / TV UNIT MASTER BEDROOM

NEW BACKING BY CONTRACTOR
ELECTRICAL OUTLET BY CONTRACTOR
DIMENSIONS FROM ESTIMATED F.F. HEIGHT

PROJECT #	0000-000
CONTINUUM NORTH	
KITCHEN - OFFICE - CLOSETS - VANITIES	
NOTES:	


CLIENT APPROVED	
DRAWINGS	☐
NOTES	☐
DATE:	
SIGNATURE:	

REVISION LOG		
1.0	03/30/2026	
2.0	05/12/2026	
3.0	05/13/2026	
4.0	05/19/2026	
5.0	06/02/2026	
6.0	06/09/2026	
7.0	06/16/2026	
8.0	06/30/2026	
9.0	07/06/2026	
10.0	07/14/2026	

DATE:	07/14/2026
REV:	9.0
DIMENSION:	CM/INCH
DRAWN BY:	KVA

T-TVMB

BUILT TO
DIMENSIONS

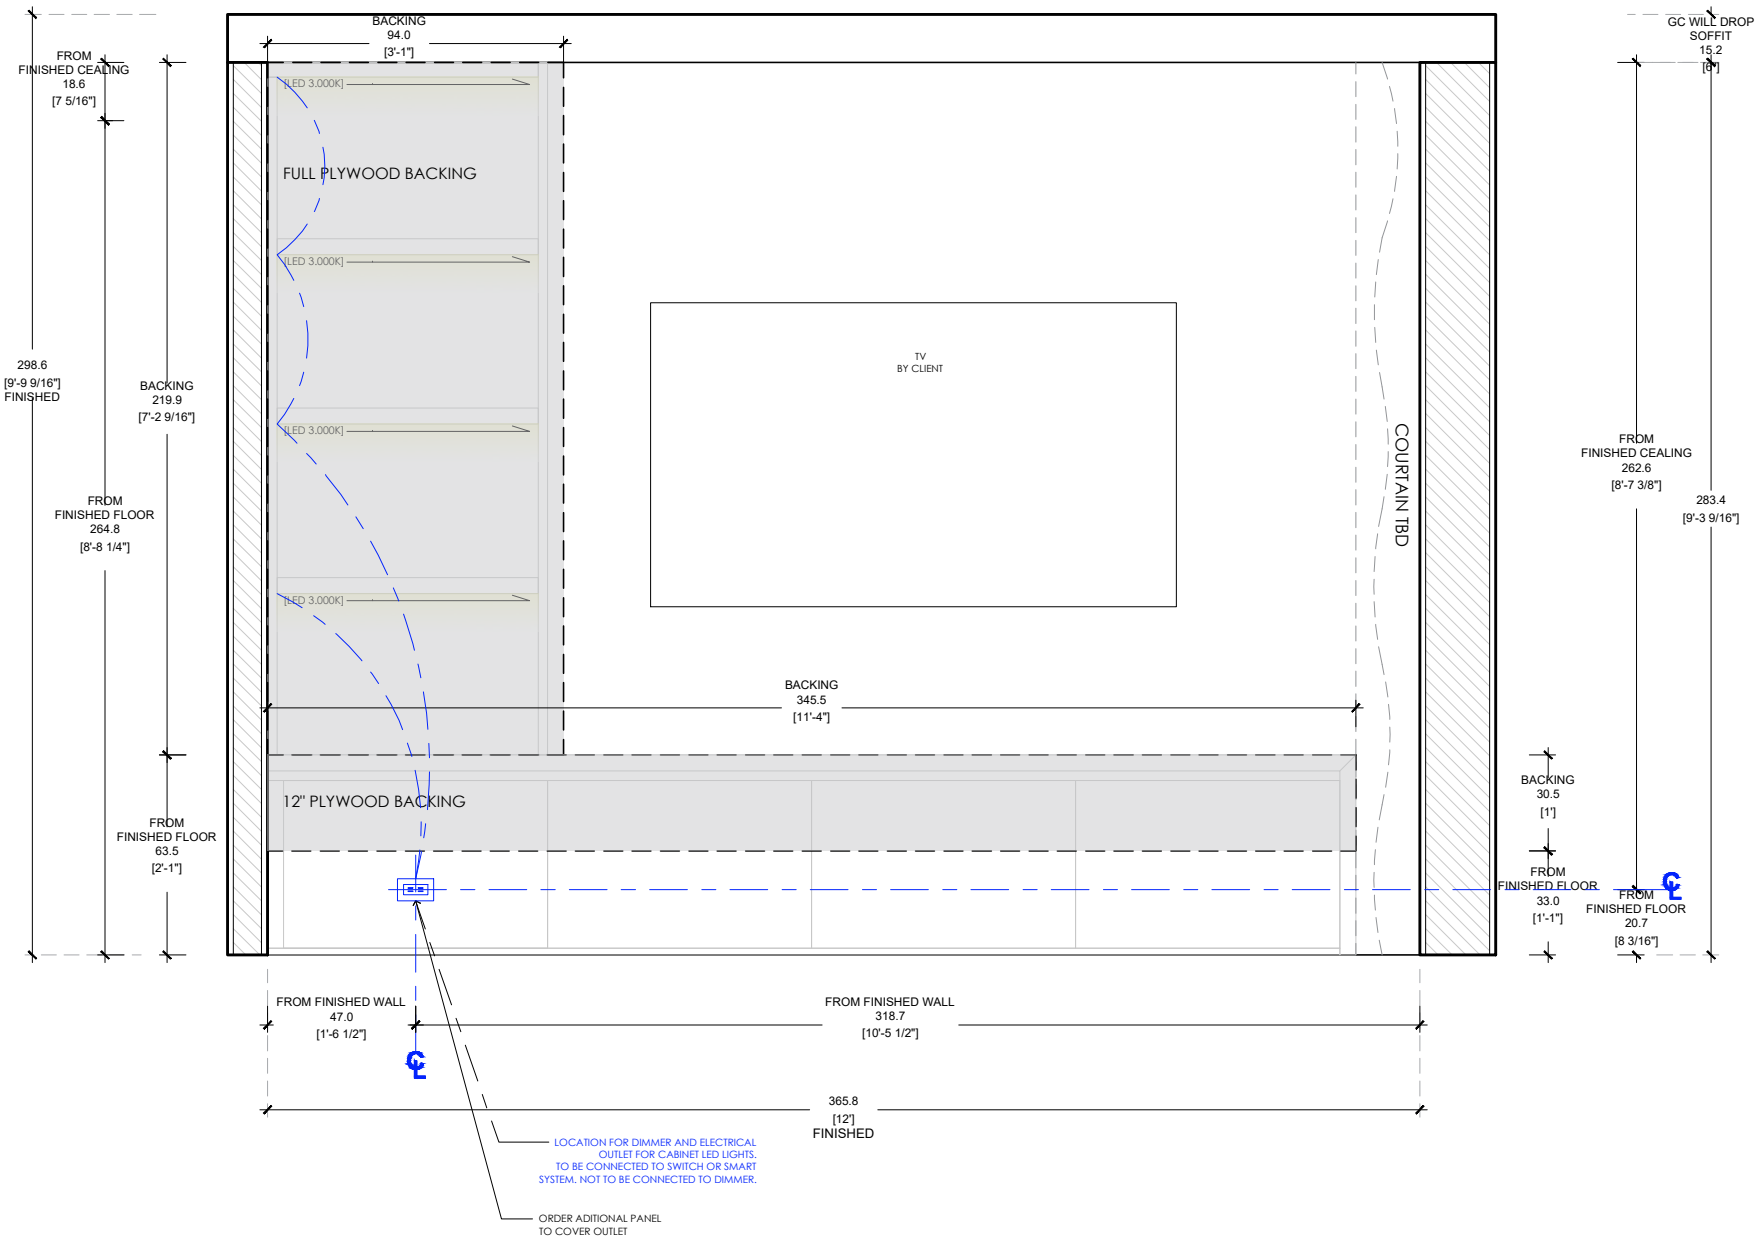

ELEVATION A SCALE 1/2"=1'-0"
CONTINUUM NORTH UNIT 2901 / TV UNIT MASTER BEDROOM

NEW BACKING BY CONTRACTOR
ELECTRICAL OUTLET BY CONTRACTOR
DIMENSIONS FROM ESTIMATED F.F. HEIGHT


PROJECT #	0000-000
CONTINUUM NORTH	
KITCHEN - OFFICE - CLOSETS - VANITIES	
NOTES:	

CLIENT APPROVED	
DRAWINGS	☐
NOTES	☐
DATE:	
SIGNATURE:	

REVISION LOG		
1.0	03/30/2026	
2.0	05/12/2026	
3.0	05/13/2026	
4.0	05/19/2026	
5.0	06/02/2026	
6.0	06/09/2026	
7.0	06/16/2026	
8.0	06/30/2026	
9.0	07/06/2026	
10.0	07/14/2026	


DATE:	07/14/2026
REV:	9.0
DIMENSION:	CM/INCH
DRAWN BY:	KVA

BUILT TO
DIMENSIONS

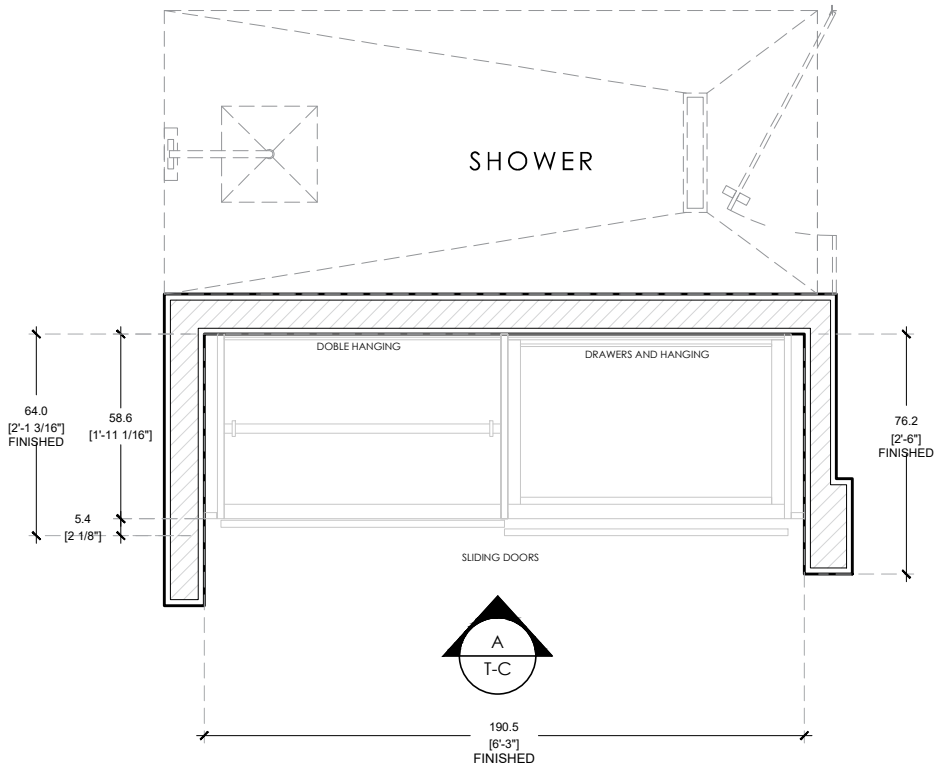

FLOOR PLAN SCALE 1/2"=1'-0"
CONTINUUM NORTH UNIT 2901 / BEDROOM 3 CLOSET

NEW BACKING BY CONTRACTOR
ELECTRICAL OUTLET BY CONTRACTOR
DIMENSIONS FROM ESTIMATED F.F. HEIGHT

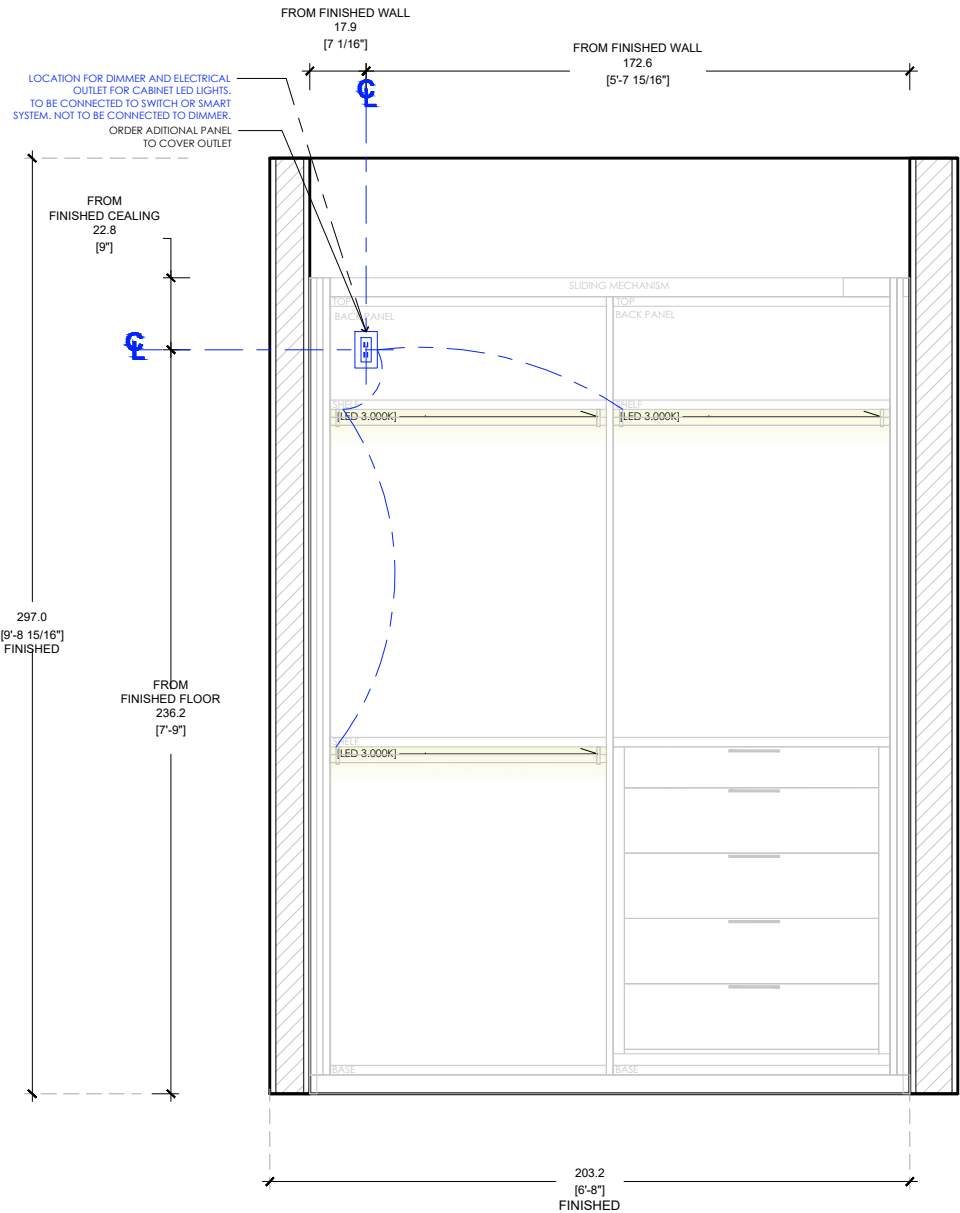

ELEVATION A SCALE 1/2"=1'-0"
CONTINUUM NORTH UNIT 2901 / BEDROOM 3 CLOSET

ITALKRAFT

KITCHENS | BATHS | CLOSETS
2900 NW 77TH CT. MIAMI FL. 33122
T. 305 406 1301 - F. 305 406 1302

PROJECT # 0000-000

CONTINUUM NORTH

KITCHEN - OFFICE - CLOSETS - VANITIES

NOTES:

CLIENT APPROVED

DRAWINGS ☐

NOTES ☐

DATE: _____

SIGNATURE: _____

REVISION LOG

1.0	03/30/2026
2.0	05/12/2026
3.0	05/13/2026
4.0	05/19/2026
5.0	06/02/2026
6.0	06/09/2026
7.0	06/16/2026
8.0	06/30/2026
9.0	07/06/2026
10.0	07/14/2026

DATE: 07/14/2026


REV: 9.0

DIMENSION: CM/INCH

DRAWN BY: KVA

T-C3

BUILT TO
DIMENSIONS

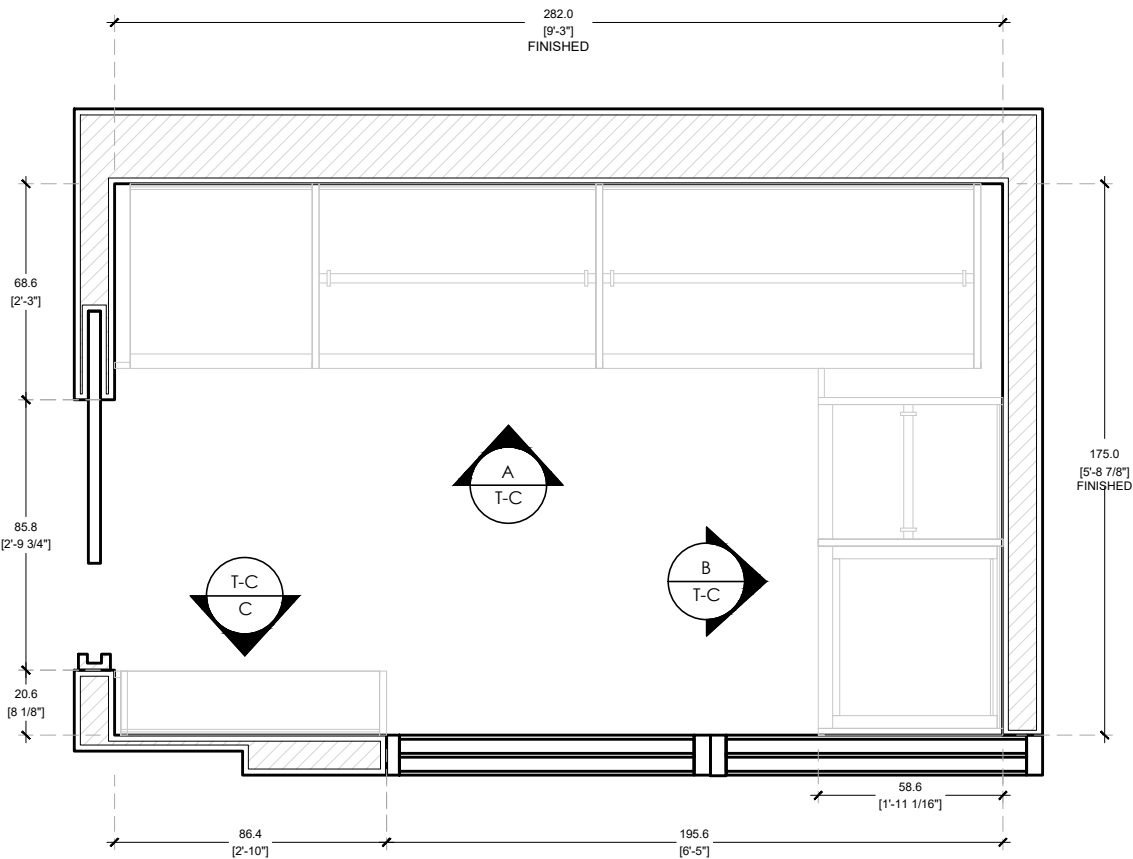

FLOOR PLAN SCALE 1/2"=1'-0"
CONTINUUM NORTH UNIT 2901 / BEDROOM 2 CLOSET

NEW BACKING BY CONTRACTOR
ELECTRICAL OUTLET BY CONTRACTOR
DIMENSIONS FROM ESTIMATED F.F. HEIGHT


PROJECT #	0000-000
CONTINUUM NORTH	
KITCHEN - OFFICE - CLOSETS - VANITIES	
NOTES:	

CLIENT APPROVED	
DRAWINGS	☐
NOTES	☐
DATE:	
SIGNATURE:	

REVISION LOG	
1.0	03/30/2026
2.0	05/12/2026
3.0	05/13/2026
4.0	05/19/2026
5.0	06/02/2026
6.0	06/09/2026
7.0	06/16/2026
8.0	06/30/2026
9.0	07/06/2026
10.0	07/14/2026


DATE:	07/14/2026
REV:	9.0
DIMENSION:	CM/INCH
DRAWN BY:	KVA

BUILT TO
DIMENSIONS

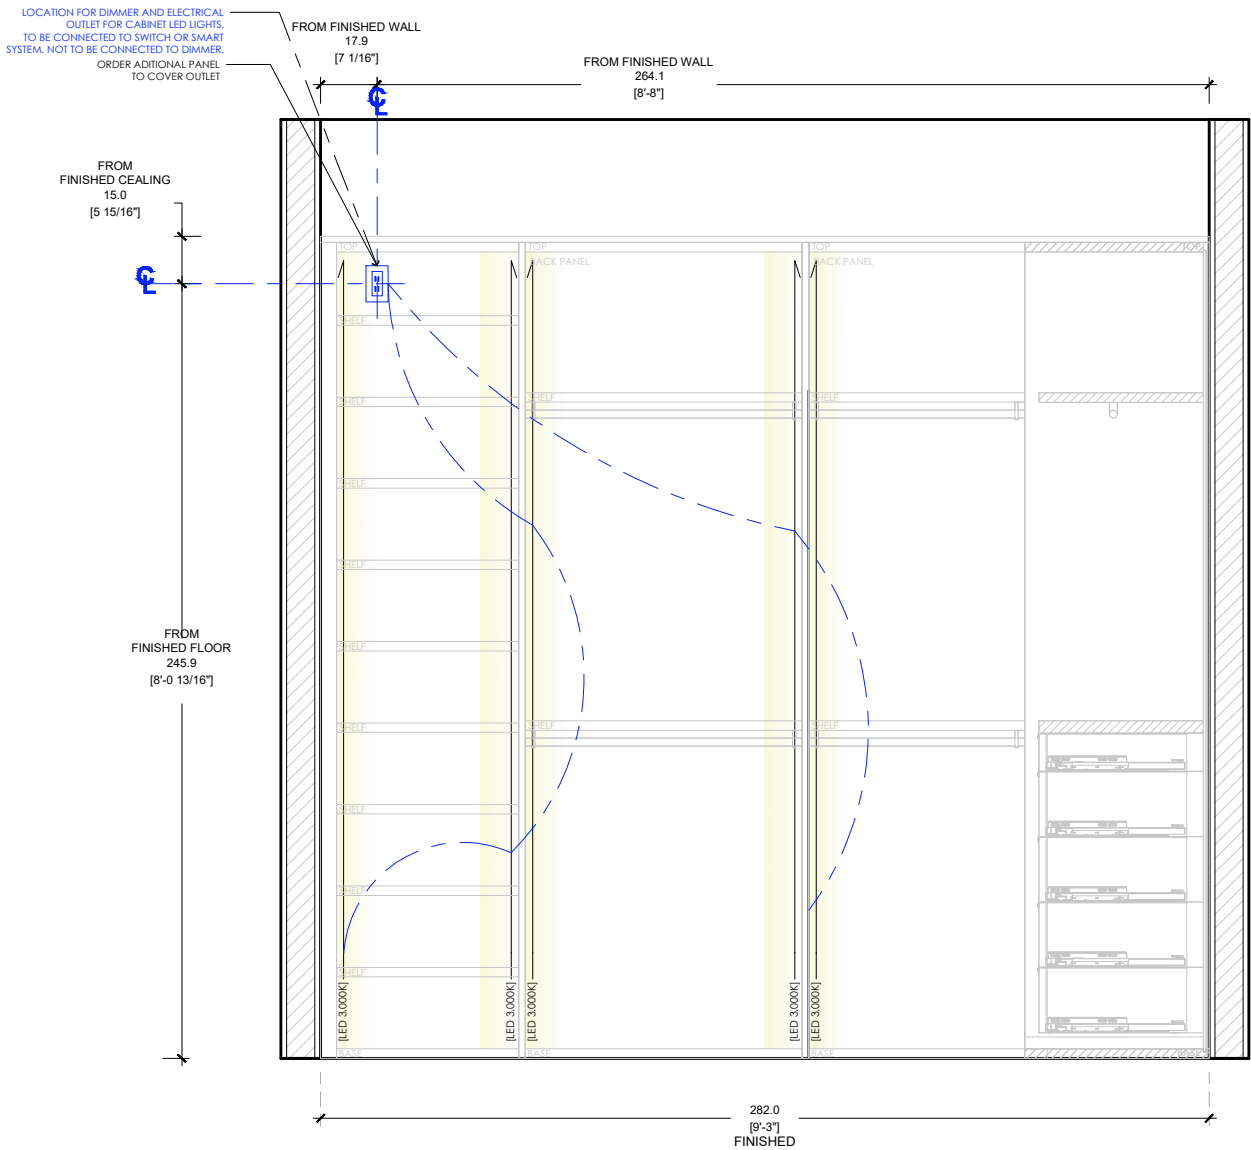


ELEVATION A SCALE 1/2"=1'-0"
CONTINUUM NORTH UNIT 2901 / BEDROOM 2 CLOSET

NEW BACKING BY CONTRACTOR
ELECTRICAL OUTLET BY CONTRACTOR
DIMENSIONS FROM ESTIMATED F.F. HEIGHT

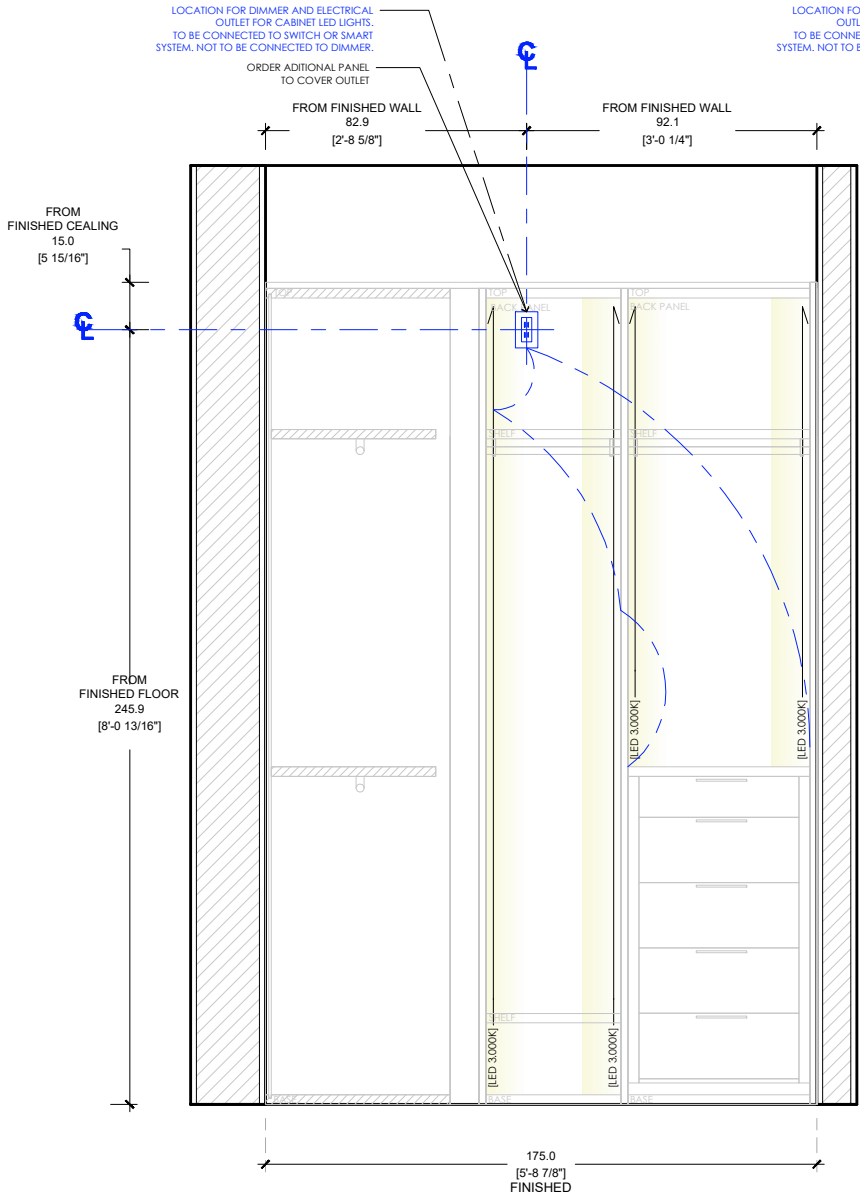

ELEVATION B SCALE 1/2"=1'-0"
CONTINUUM NORTH UNIT 2901 / BEDROOM 2 CLOSET

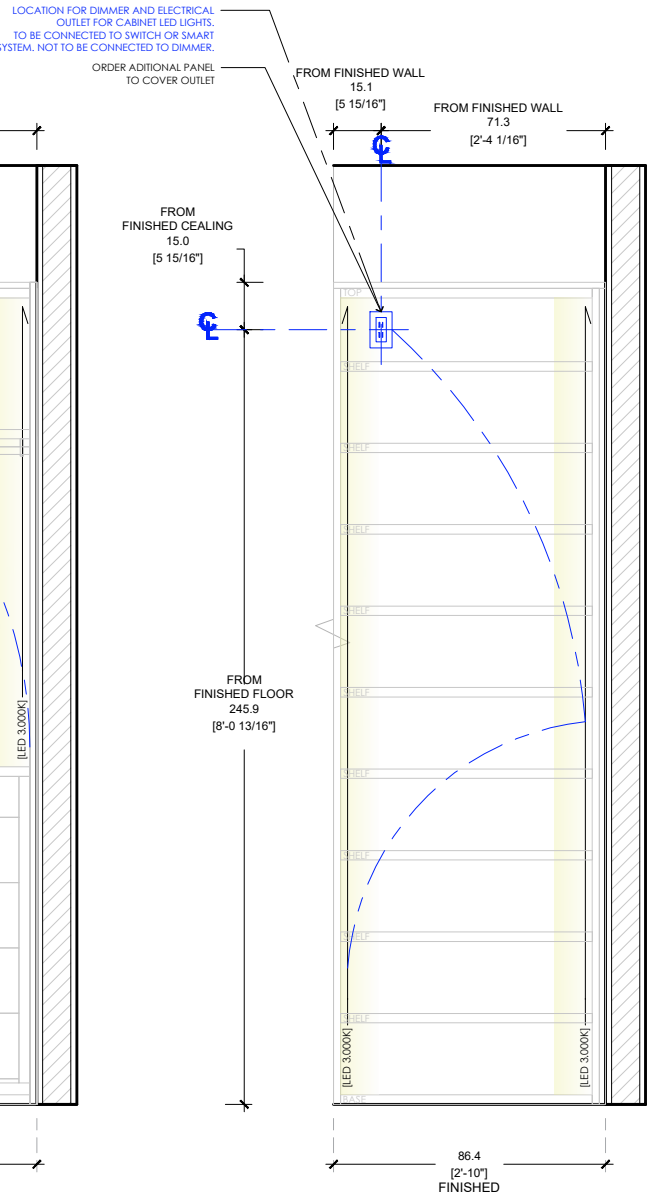

ELEVATION C SCALE 1/2"=1'-0"
CONTINUUM NORTH UNIT 2901 / BEDROOM 2 CLOSET

PROJECT # 0000-000
CONTINUUM NORTH
KITCHEN - OFFICE - CLOSETS - VANITIES
NOTES:

CLIENT APPROVED

DRAWINGS ☐

NOTES ☐


DATE: _____

SIGNATURE: _____

REVISION LOG		
1.0	03/30/2026	
2.0	05/12/2026	
3.0	05/13/2026	
4.0	05/19/2026	
5.0	06/02/2026	
6.0	06/09/2026	
7.0	06/16/2026	
8.0	06/30/2026	
9.0	07/06/2026	
10.0	07/14/2026	

DATE: 07/14/2026
REV: 9.0
DIMENSION: CM/INCH
DRAWN BY: KVA

BUILT TO
DIMENSIONS

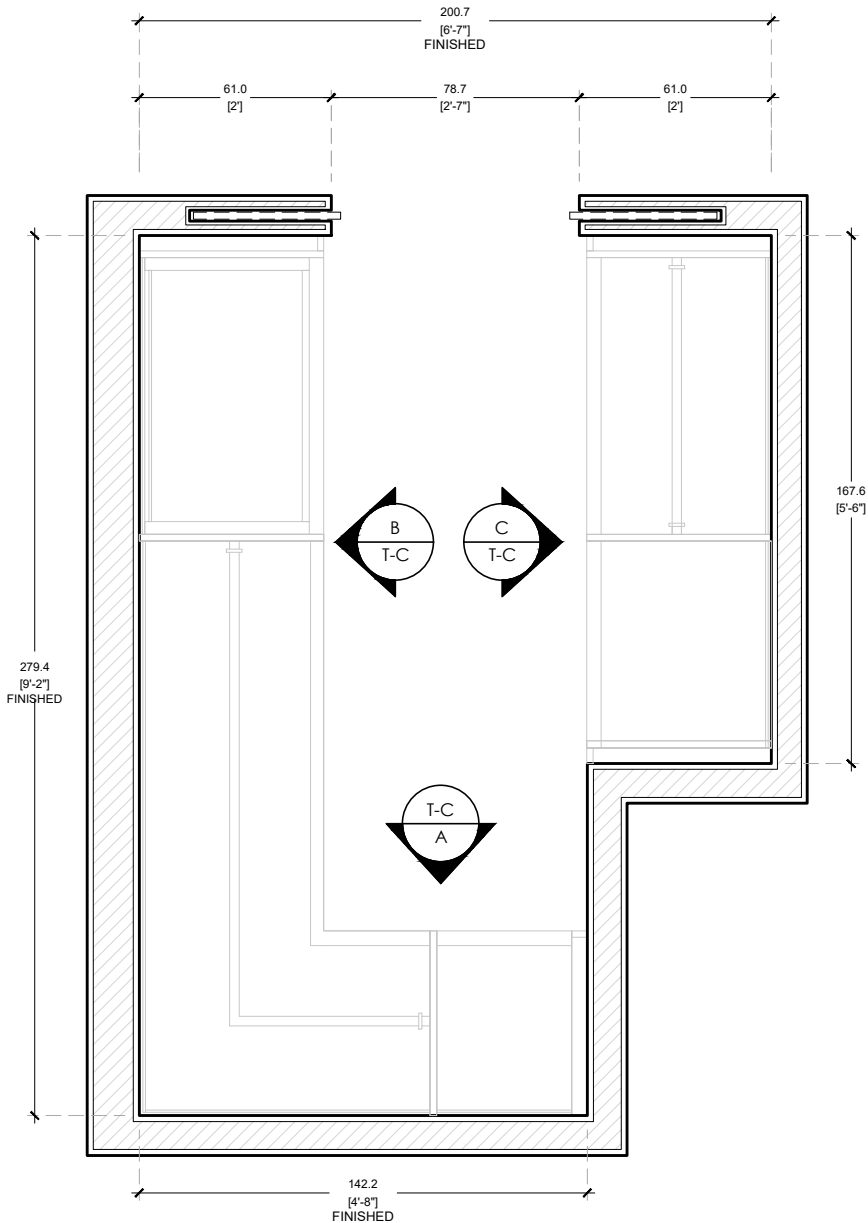

FLOOR PLAN SCALE 1/2"=1'-0"
CONTINUUM NORTH UNIT 2901 / HIS CLOSET

NEW BACKING BY CONTRACTOR
ELECTRICAL OUTLET BY CONTRACTOR
DIMENSIONS FROM ESTIMATED F.F. HEIGHT

PROJECT #	0000-000
CONTINUUM NORTH	
KITCHEN - OFFICE - CLOSETS - VANITIES	
NOTES:	

CLIENT APPROVED

DRAWINGS ☐

NOTES ☐


DATE: _____

SIGNATURE: _____

REVISION LOG	
1.0	03/30/2026
2.0	05/12/2026
3.0	05/13/2026
4.0	05/19/2026
5.0	06/02/2026
6.0	06/09/2026
7.0	06/16/2026
8.0	06/30/2026
9.0	07/06/2026
10.0	07/14/2026

DATE: 07/14/2026
REV: 9.0
DIMENSION: CM/INCH
DRAWN BY: KVA

BUILT TO
DIMENSIONS

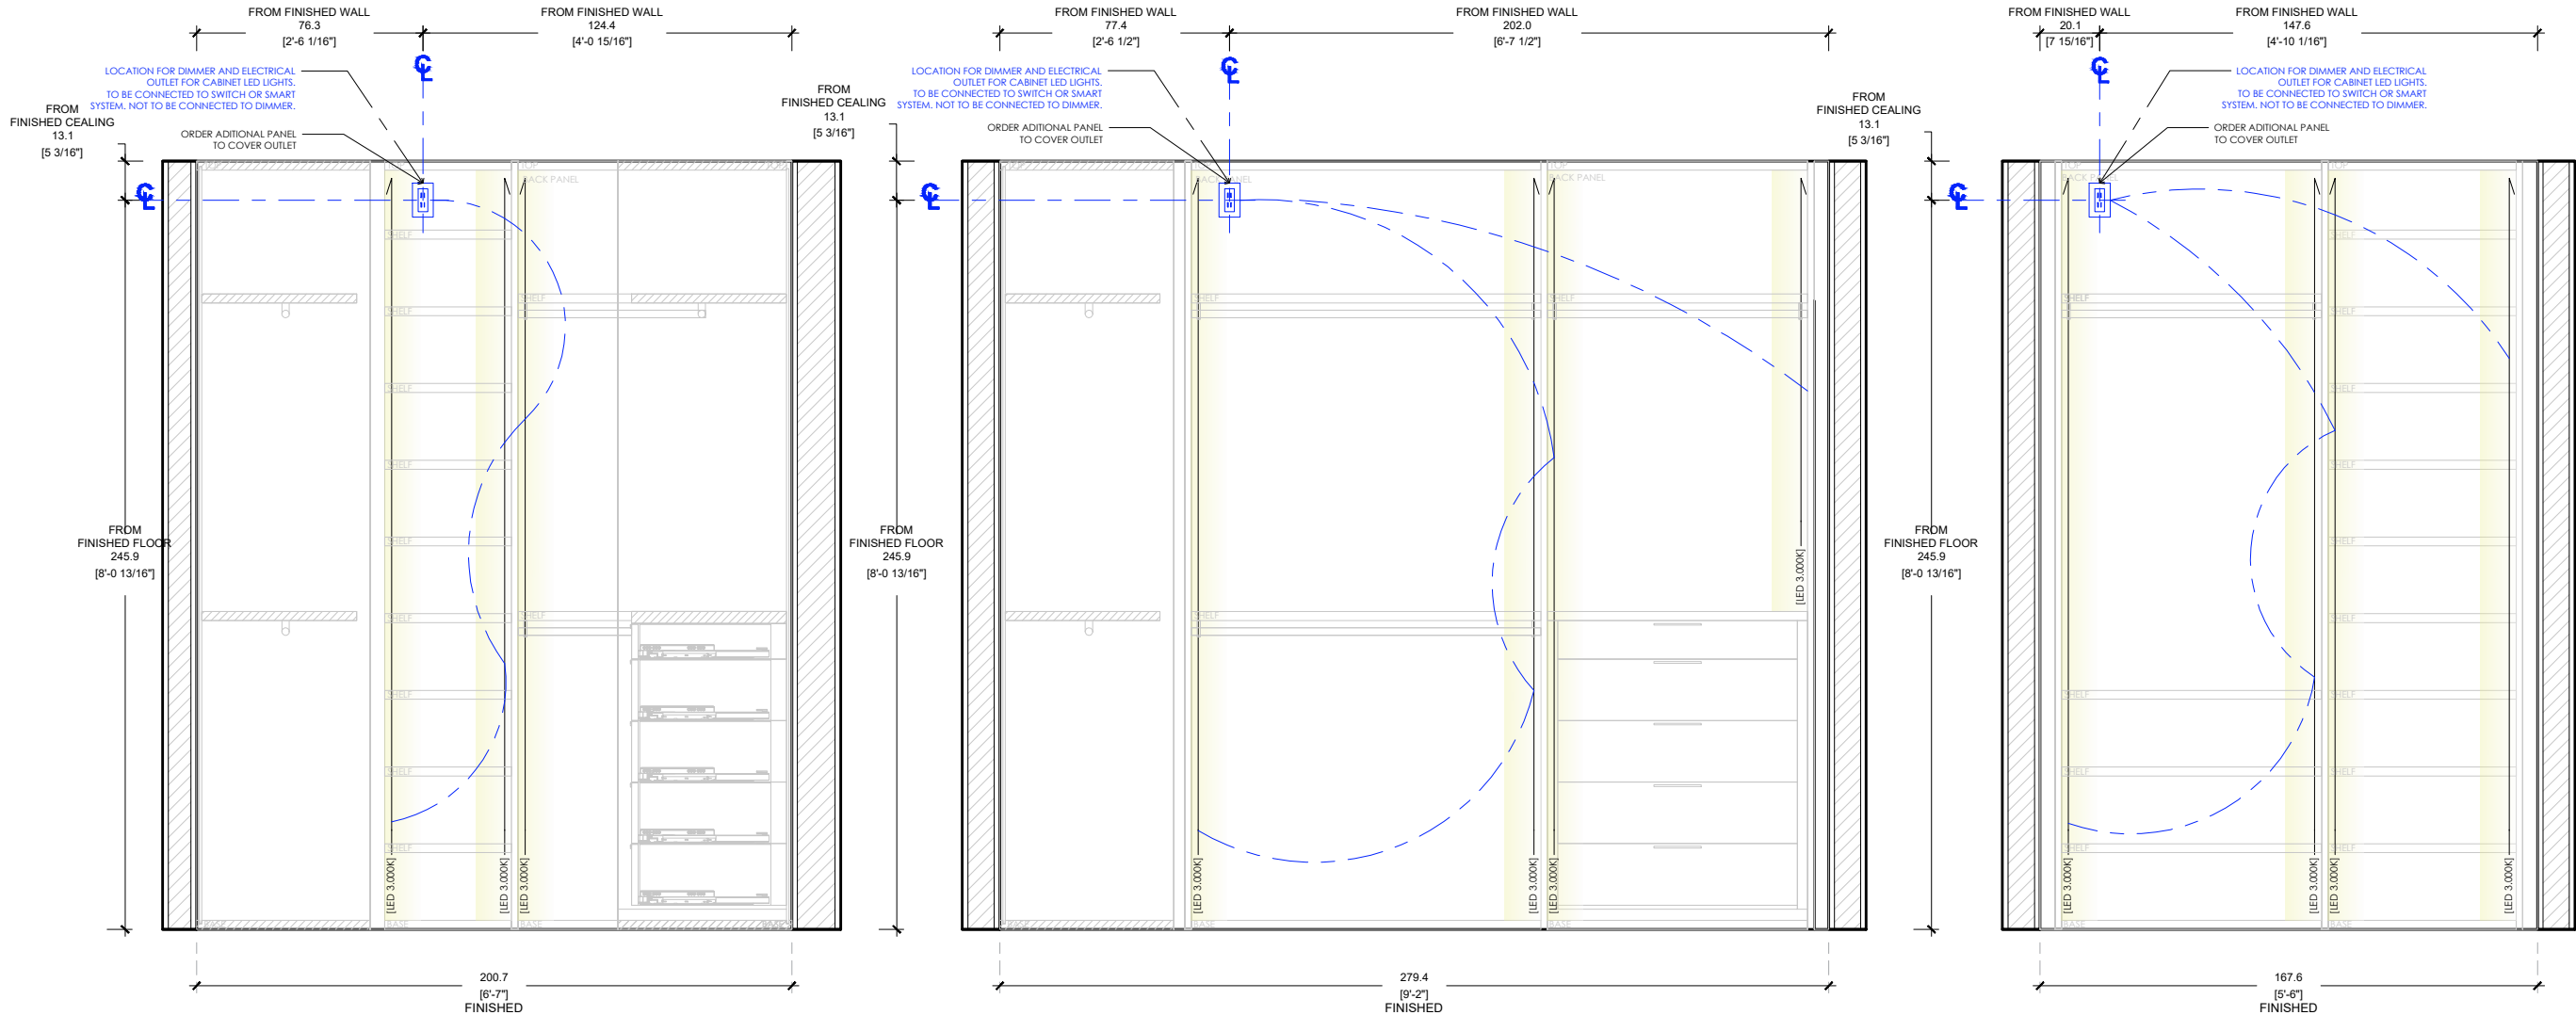

ELEVATION A SCALE 1/2"=1'-0"
CONTINUUM NORTH UNIT 2901 / HIS CLOSET

ELEVATION B SCALE 1/2"=1'-0"
CONTINUUM NORTH UNIT 2901 / HIS CLOSET

ELEVATION C SCALE 1/2"=1'-0"
CONTINUUM NORTH UNIT 2901 / HIS CLOSET

NEW BACKING BY CONTRACTOR
ELECTRICAL OUTLET BY CONTRACTOR
DIMENSIONS FROM ESTIMATED F.F. HEIGHT

ITALKRAFT

KITCHENS | BATHS | CLOSETS
2900 NW 77TH CT. MIAMI FL. 33122
T. 305 406 1301 - F. 305 406 1302

PROJECT # 0000-000
CONTINUUM NORTH
KITCHEN - OFFICE - CLOSETS - VANITIES
NOTES:

CLIENT APPROVED


DRAWINGS ☐
NOTES ☐
DATE:
SIGNATURE:

REVISION LOG

1.0	03/30/2026
2.0	05/12/2026
3.0	05/13/2026
4.0	05/19/2026
5.0	06/02/2026
6.0	06/09/2026
7.0	06/16/2026
8.0	06/30/2026
9.0	07/06/2026
10.0	07/14/2026

DATE: 07/14/2026
REV: 9.0
DIMENSION: CM/INCH
DRAWN BY: KVA

BUILT TO
DIMENSIONS

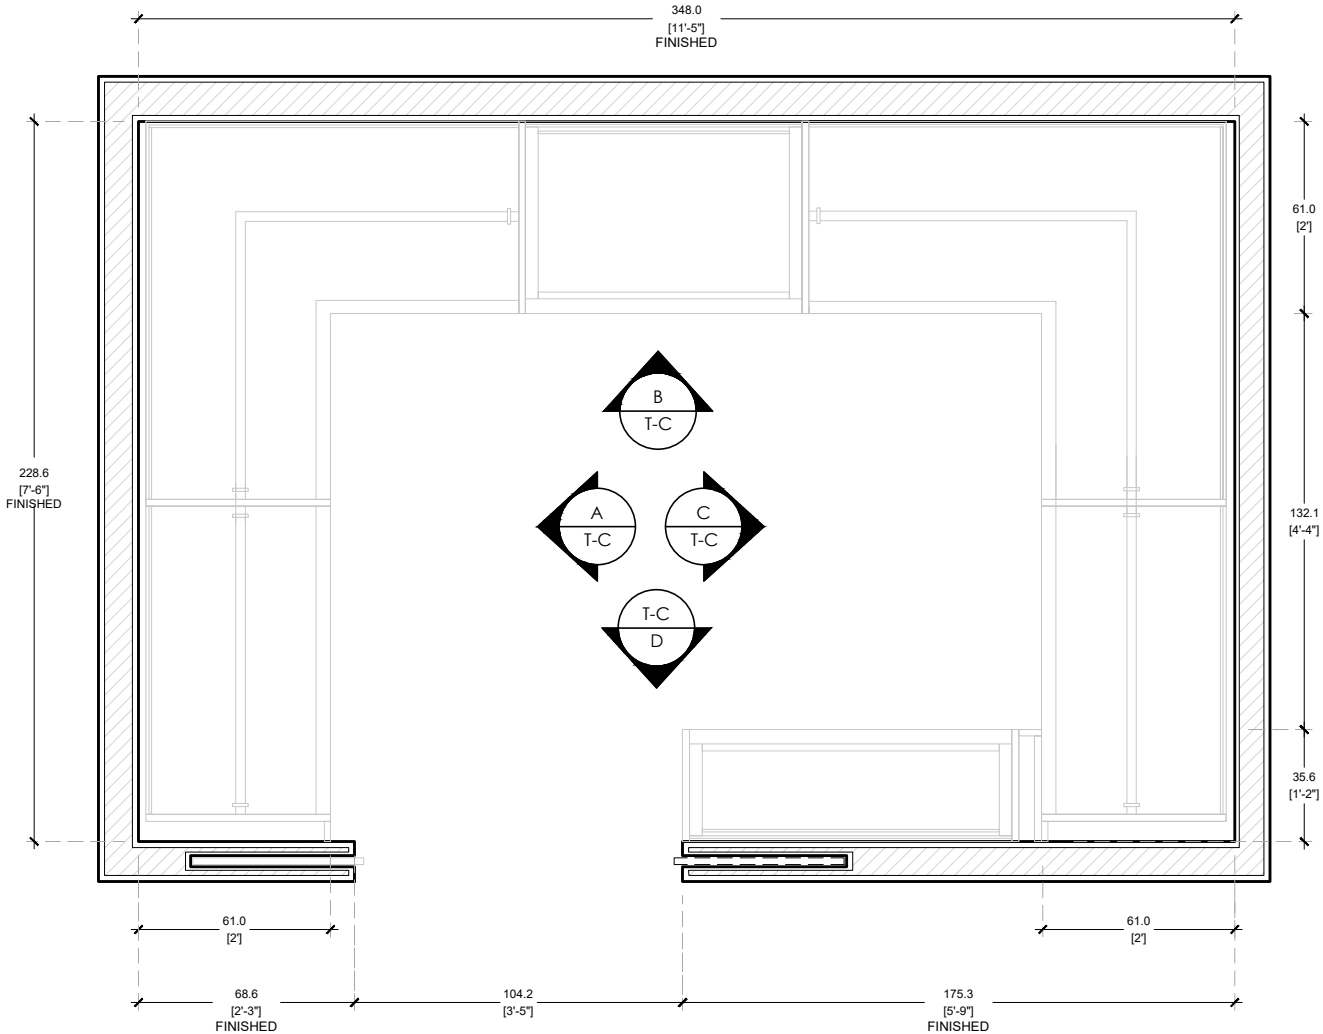

FLOOR PLAN SCALE 1/2"=1'-0"
CONTINUUM NORTH UNIT 2901 / HER CLOSET

NEW BACKING BY CONTRACTOR
ELECTRICAL OUTLET BY CONTRACTOR
DIMENSIONS FROM ESTIMATED F.F. HEIGHT


PROJECT #	0000-000
CONTINUUM NORTH	
KITCHEN - OFFICE - CLOSETS - VANITIES	
NOTES:	

CLIENT APPROVED	
DRAWINGS	☐
NOTES	☐
DATE:	
SIGNATURE:	

REVISION LOG	
1.0	03/30/2026
2.0	05/12/2026
3.0	05/13/2026
4.0	05/19/2026
5.0	06/02/2026
6.0	06/09/2026
7.0	06/16/2026
8.0	06/30/2026
9.0	07/06/2026
10.0	07/14/2026


DATE:	07/14/2026
REV:	9.0
DIMENSION:	CM/INCH
DRAWN BY:	KVA

BUILT TO
DIMENSIONS

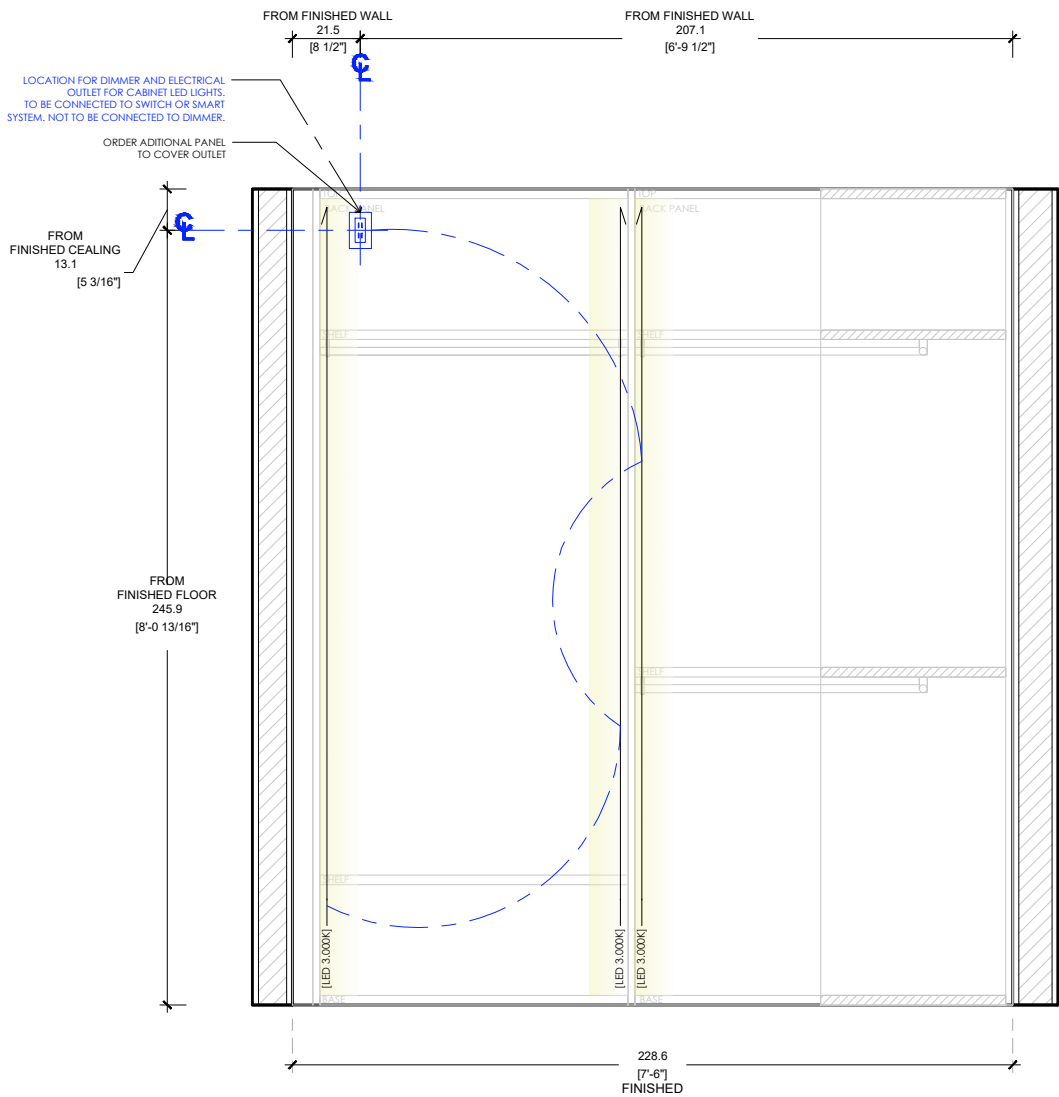

ELEVATION A SCALE 1/2"=1'-0"
CONTINUUM NORTH UNIT 2901 / HER CLOSET

NEW BACKING BY CONTRACTOR
ELECTRICAL OUTLET BY CONTRACTOR
DIMENSIONS FROM ESTIMATED F.F. HEIGHT

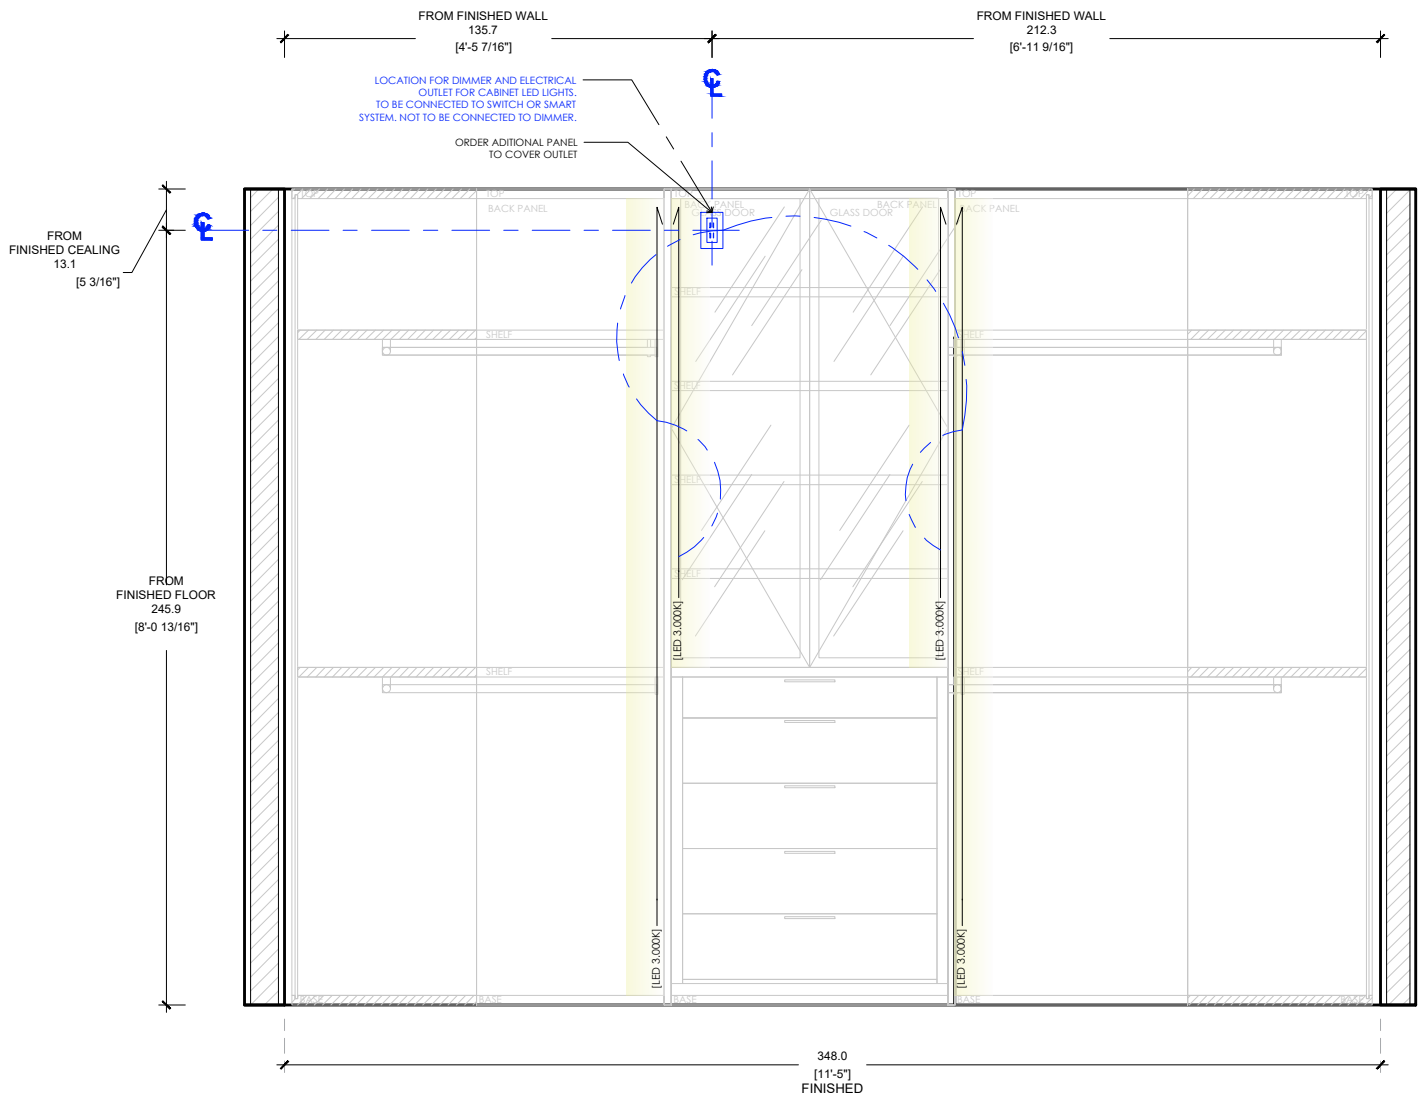

ELEVATION B SCALE 1/2"=1'-0"
CONTINUUM NORTH UNIT 2901 / HER CLOSET

CLIENT APPROVED

DRAWINGS ☐

NOTES ☐

DATE: _____

SIGNATURE: _____

REVISION LOG		
1.0	03/30/2026	
2.0	05/12/2026	
3.0	05/13/2026	
4.0	05/19/2026	
5.0	06/02/2026	
6.0	06/09/2026	
7.0	06/16/2026	
8.0	06/30/2026	
9.0	07/06/2026	
10.0	07/14/2026	


DATE: 07/14/2026

REV: 9.0

DIMENSION: CM/INCH


DRAWN BY: KVA

BUILT TO
DIMENSIONS

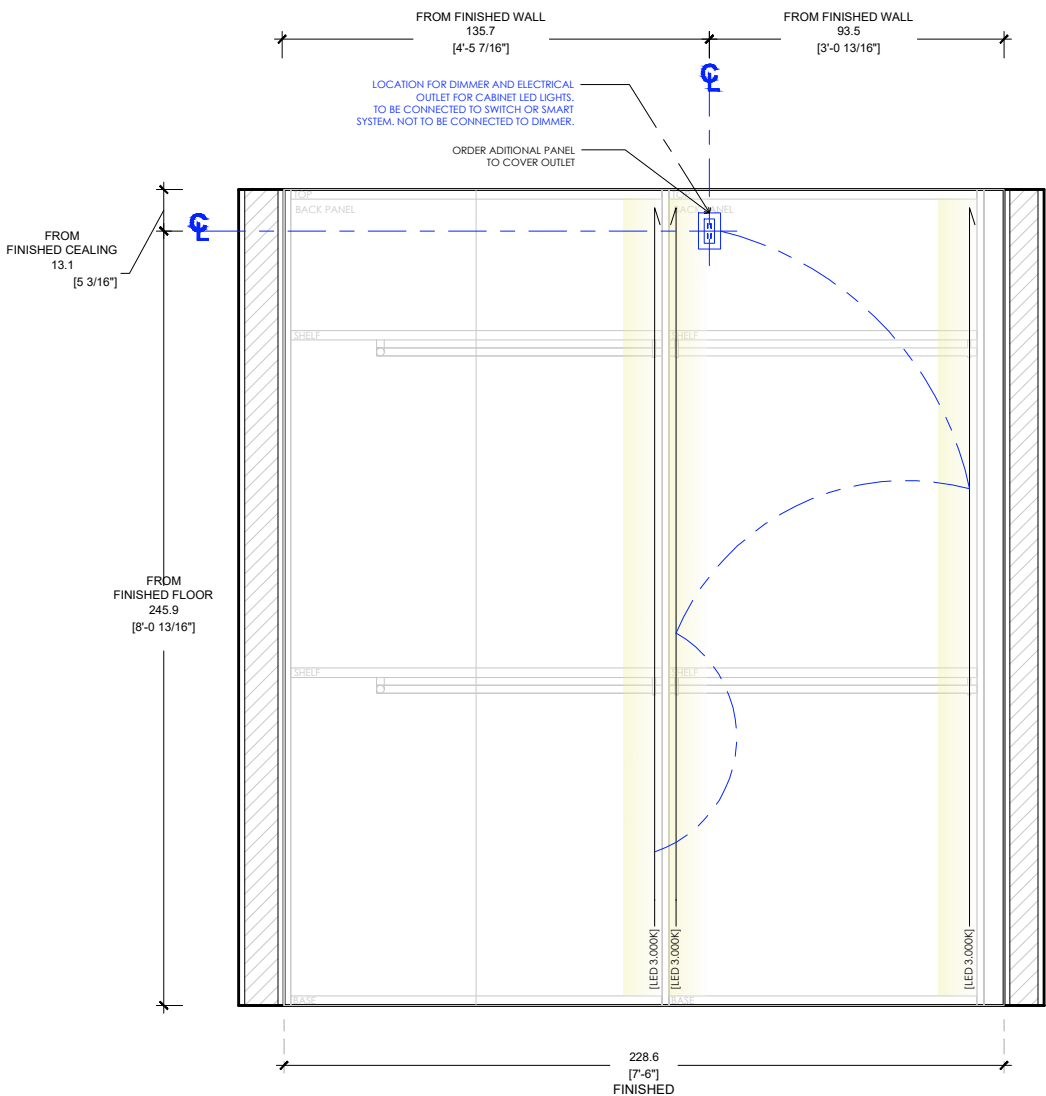

ELEVATION C SCALE 1/2"=1'-0"
CONTINUUM NORTH UNIT 2901 / HER CLOSET

NEW BACKING BY CONTRACTOR
ELECTRICAL OUTLET BY CONTRACTOR
DIMENSIONS FROM ESTIMATED F.F. HEIGHT

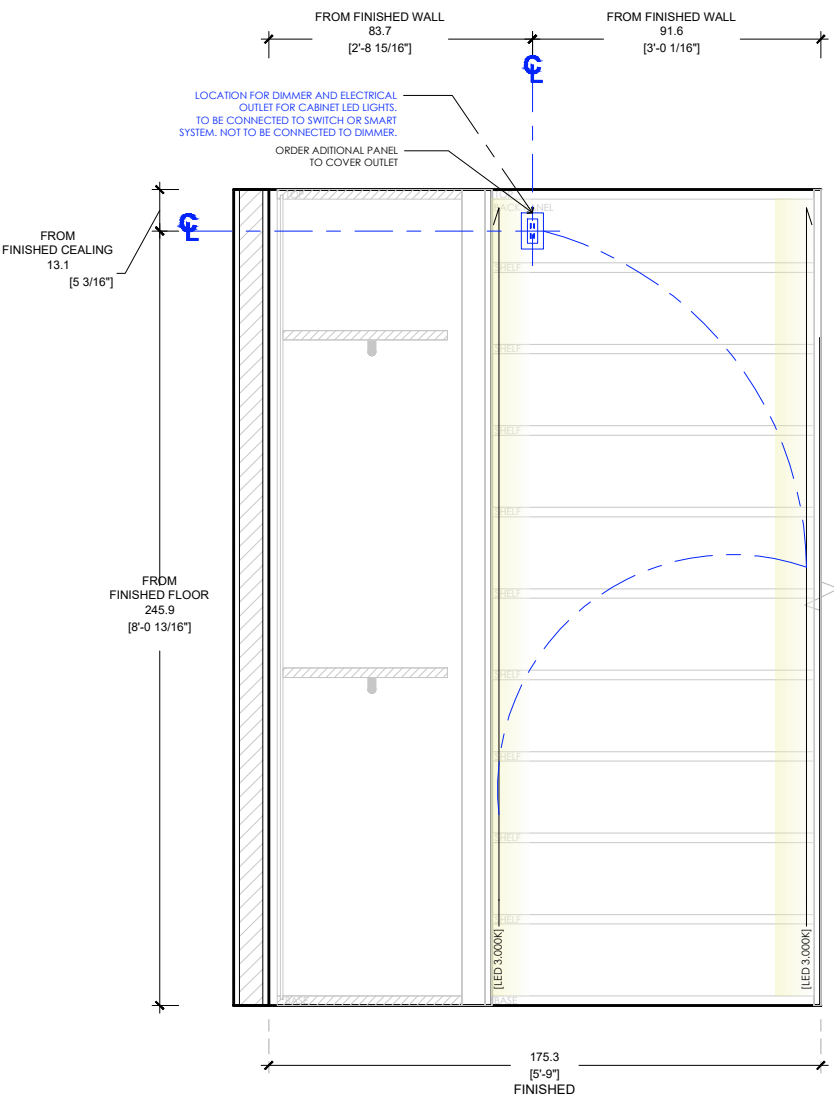

ELEVATION D SCALE 1/2"=1'-0"
CONTINUUM NORTH UNIT 2901 / HER CLOSET


PROJECT #	0000-000
CONTINUUM NORTH	
KITCHEN - OFFICE - CLOSETS - VANITIES	
NOTES:	

CLIENT APPROVED	
DRAWINGS	☐
NOTES	☐
DATE:	
SIGNATURE:	

REVISION LOG	
1.0	03/30/2026
2.0	05/12/2026
3.0	05/13/2026
4.0	05/19/2026
5.0	06/02/2026
6.0	06/09/2026
7.0	06/16/2026
8.0	06/30/2026
9.0	07/06/2026
10.0	07/14/2026


DATE:	07/14/2026
REV:	9.0
DIMENSION:	CM/INCH
DRAWN BY:	KVA

BUILT TO
DIMENSIONS

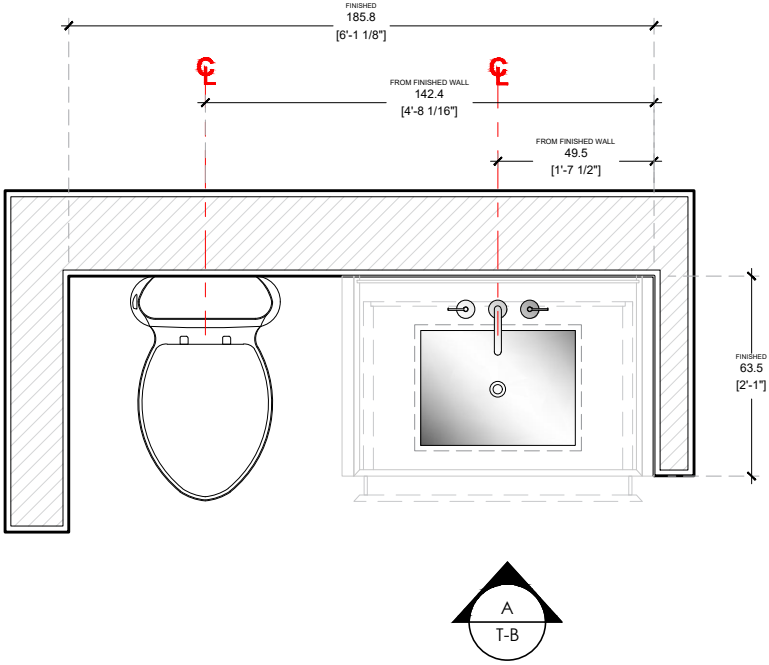


FLOOR PLAN SCALE 1/2"=1'-0"
CONTINUUM NORTH UNIT 2901 / BEDROOM 3 BATHROOM

NEW BACKING BY CONTRACTOR
ELECTRICAL OUTLET BY CONTRACTOR
DIMENSIONS FROM ESTIMATED F.F. HEIGHT

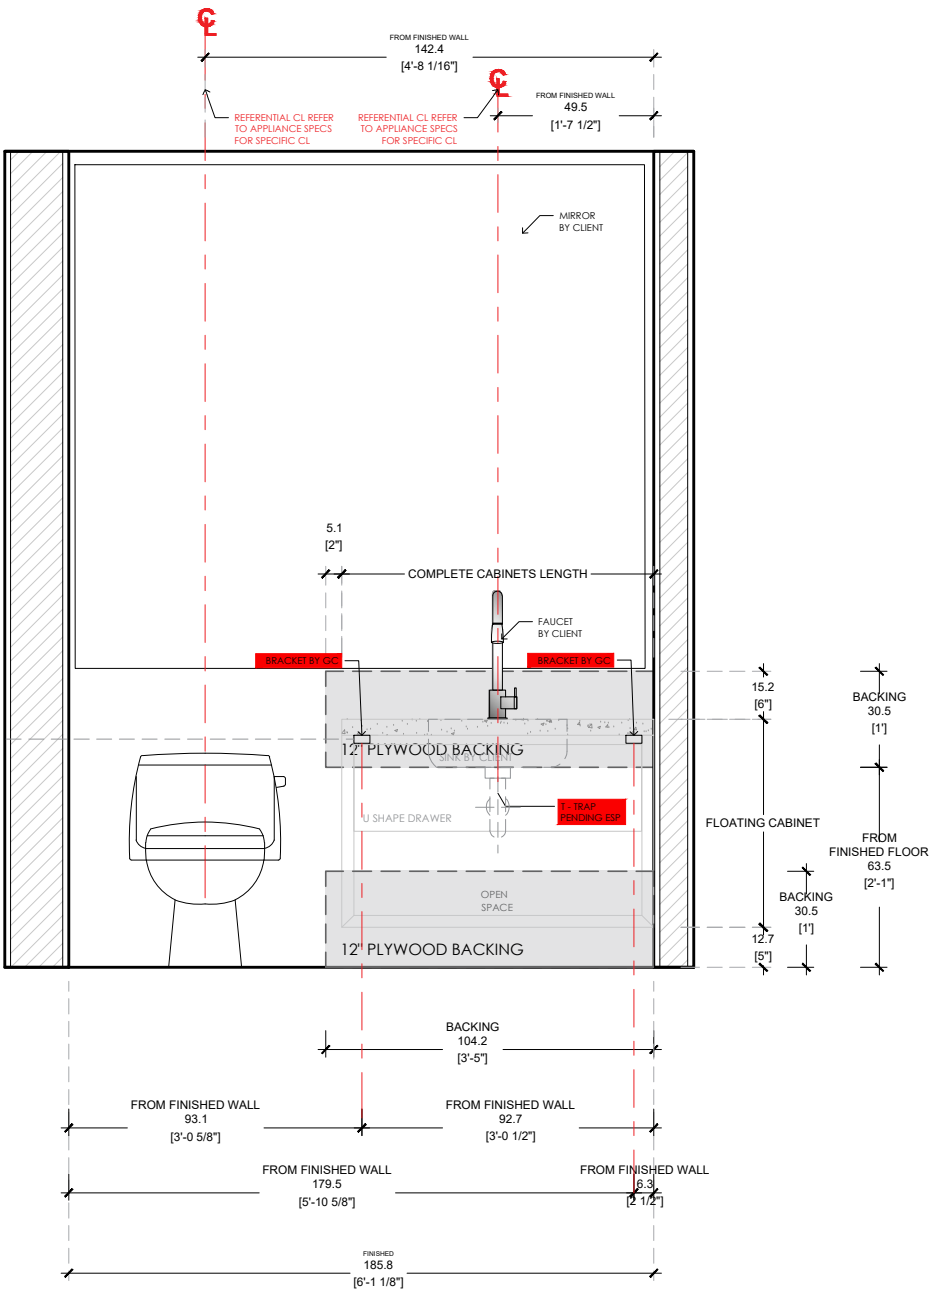

ELEVATION A SCALE 1/2"=1'-0"
CONTINUUM NORTH UNIT 2901 / BEDROOM 3 BATHROOM

DETAIL PICTURE
BRACKET BY GC

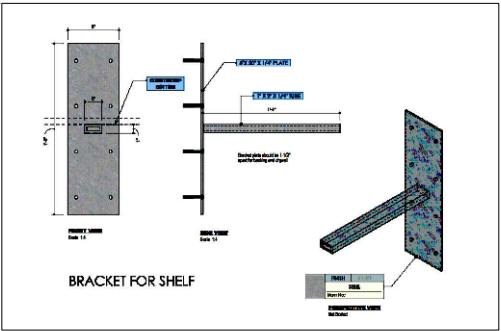

ITALKRAFT
KITCHENS | BATHS | CLOSETS
2900 NW 77TH CT. MIAMI FL, 33122
T. 305 406 1301 - F. 305 406 1302

PROJECT # 0000-000

CONTINUUM NORTH

KITCHEN - OFFICE - CLOSETS - VANITIES

NOTES:

CLIENT APPROVED

DRAWINGS ☐

NOTES ☐

DATE: _____

SIGNATURE: _____


REVISION LOG

1.0	03/30/2026
2.0	05/12/2026
3.0	05/13/2026
4.0	05/19/2026
5.0	06/02/2026
6.0	06/09/2026
7.0	06/16/2026
8.0	06/30/2026
9.0	07/06/2026
10.0	07/14/2026

DATE: 07/14/2026
REV: 9.0
DIMENSION: CM/INCH
DRAWN BY: KVA


T-B3

2900 NW 77TH CT. MIAMI FL, 33122
T. 305 406 1301 - F. 305 406 1302

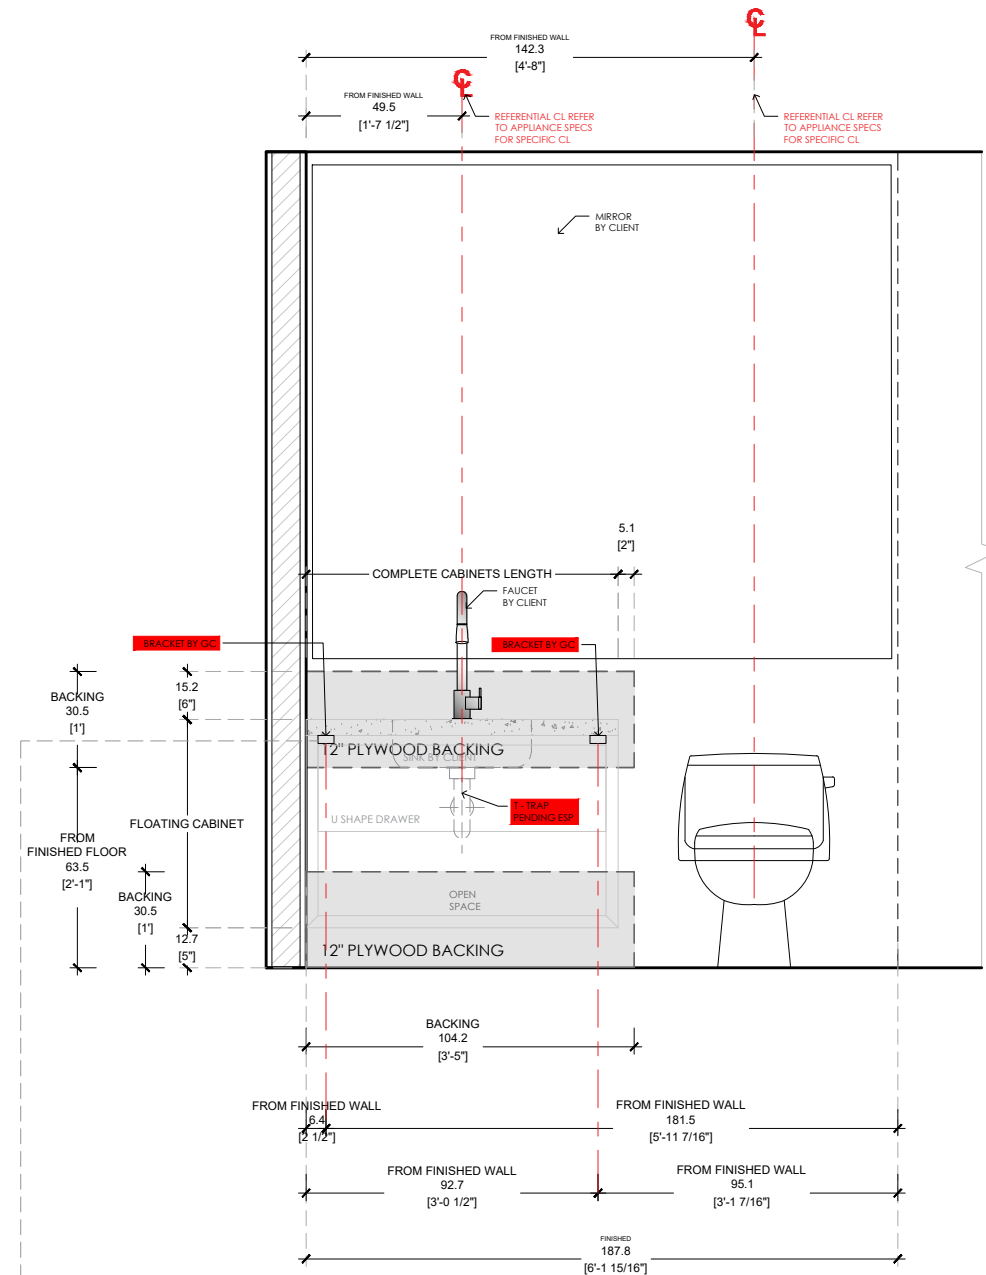

ELEVATION A SCALE 1/2"=1'-0"
CONTINUUM NORTH UNIT 2901 / BEDROOM 2 BATHROOM

DETAIL PICTURE
BRACKET BY GC

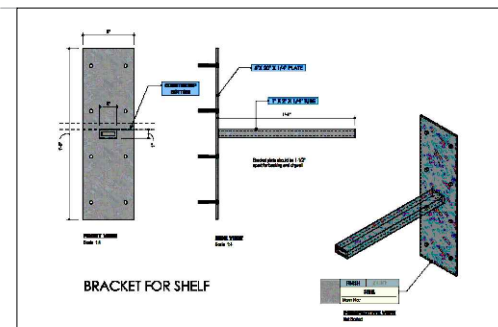


NOTES:

SIGNATURE:

1.0	03/30/2026
2.0	05/12/2026
3.0	05/13/2026
4.0	05/19/2026
5.0	06/02/2026
6.0	06/09/2026
7.0	06/16/2026
8.0	06/30/2026
9.0	07/06/2026
10.0	07/14/2026

DRAWN BY: KVA

BUILT TO
DIMENSIONS

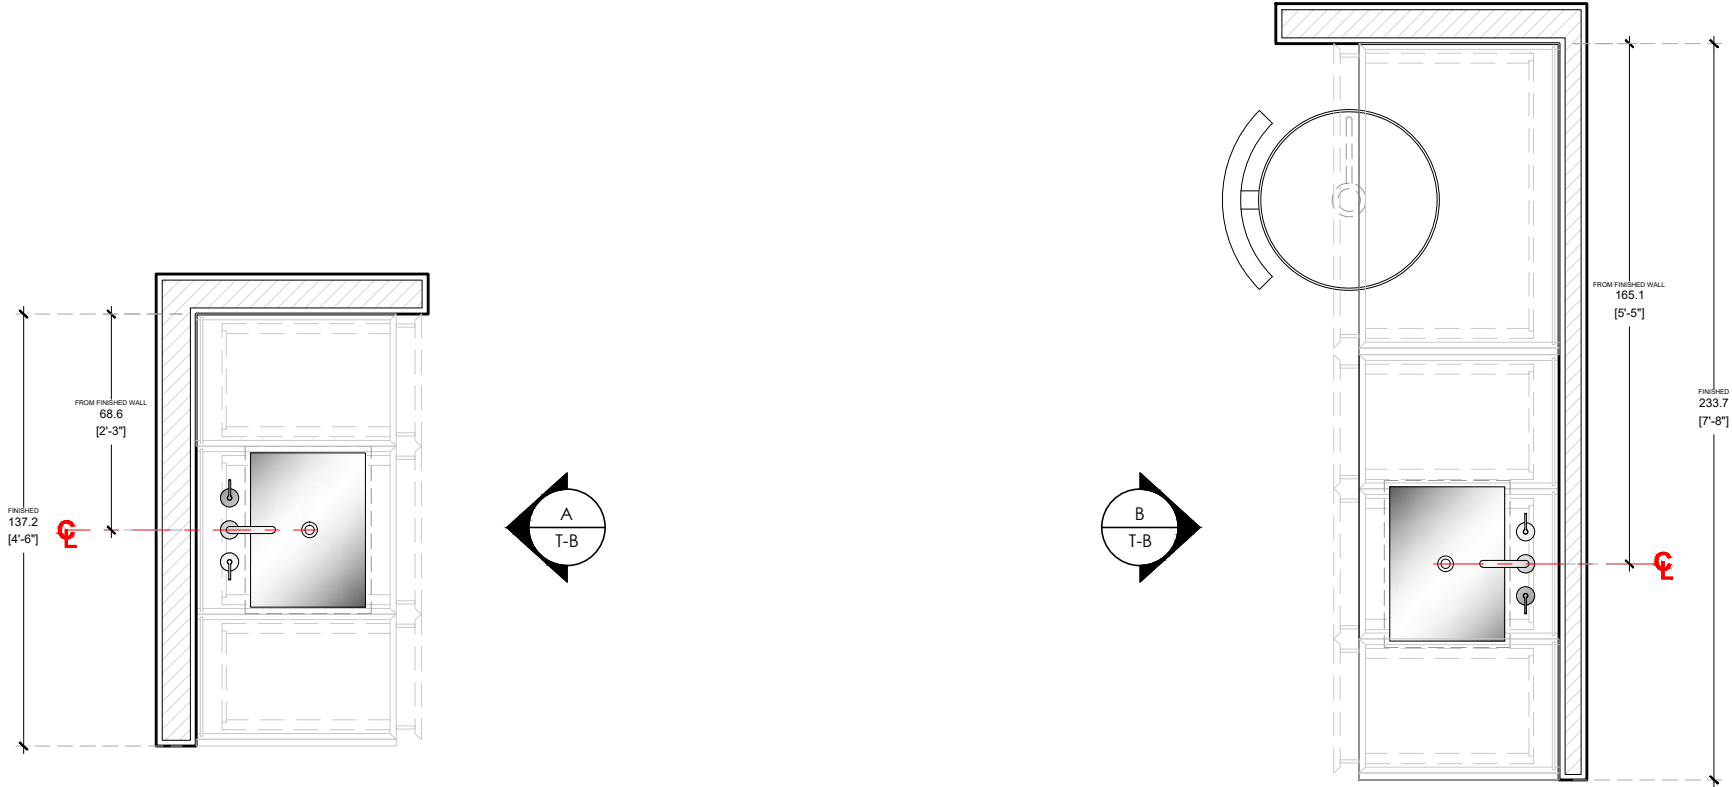

FLOOR PLAN SCALE 1/2"=1'-0"
CONTINUUM NORTH UNIT 2901 / MASTER BATHROOM

NEW BACKING BY CONTRACTOR
ELECTRICAL OUTLET BY CONTRACTOR
DIMENSIONS FROM ESTIMATED F.F. HEIGHT


PROJECT #	0000-000
CONTINUUM NORTH	
KITCHEN - OFFICE - CLOSETS - VANITIES	
NOTES:	

CLIENT APPROVED	
DRAWINGS	☐
NOTES	☐
DATE:	
SIGNATURE:	

REVISION LOG	
1.0	03/30/2026
2.0	05/12/2026
3.0	05/13/2026
4.0	05/19/2026
5.0	06/02/2026
6.0	06/09/2026
7.0	06/16/2026
8.0	06/30/2026
9.0	07/06/2026
10.0	07/14/2026


DATE:	07/14/2026
REV:	9.0
DIMENSION:	CM/INCH
DRAWN BY:	KVA

BUILT TO
DIMENSIONS

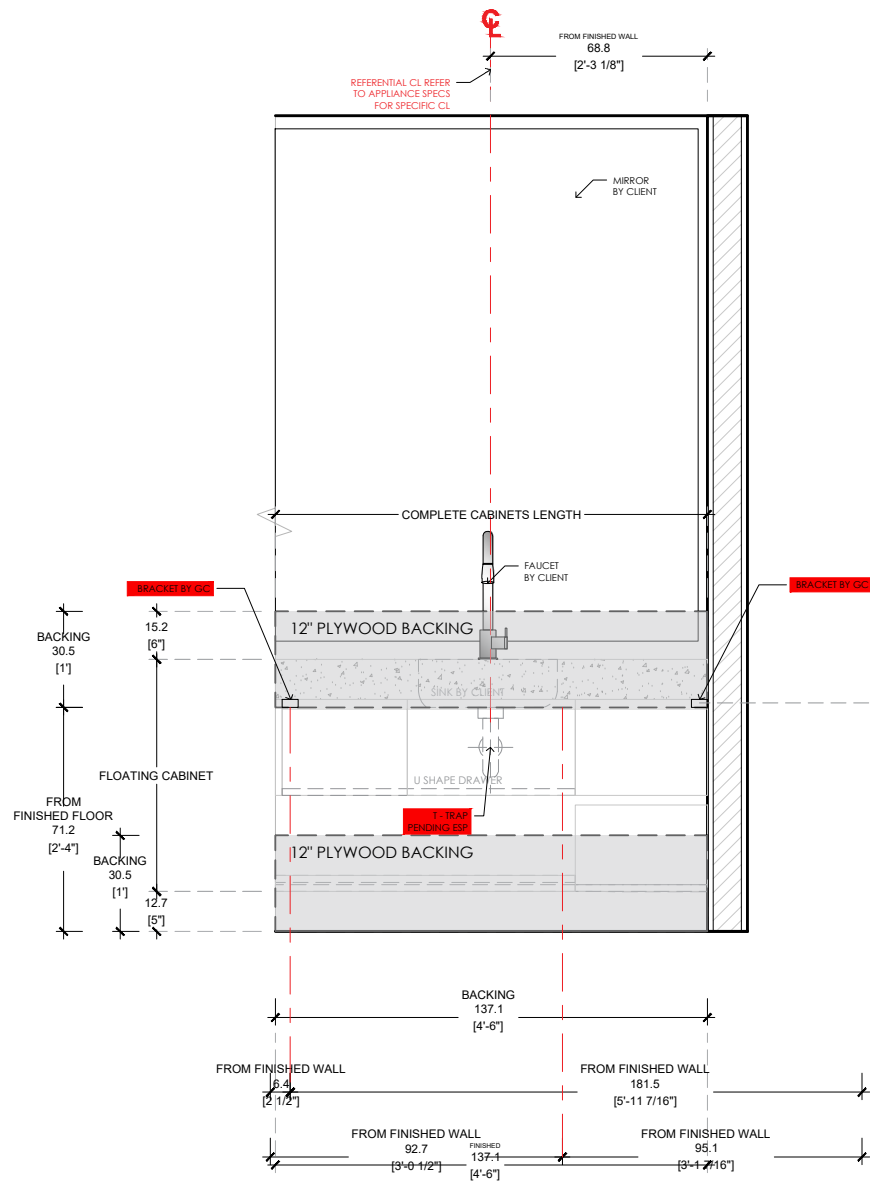


ELEVATION A SCALE 1/2"=1'-0"
CONTINUUM NORTH UNIT 2901 / BEDROOM 3 CLOSET

NEW BACKING BY CONTRACTOR
ELECTRICAL OUTLET BY CONTRACTOR
DIMENSIONS FROM ESTIMATED F.F. HEIGHT

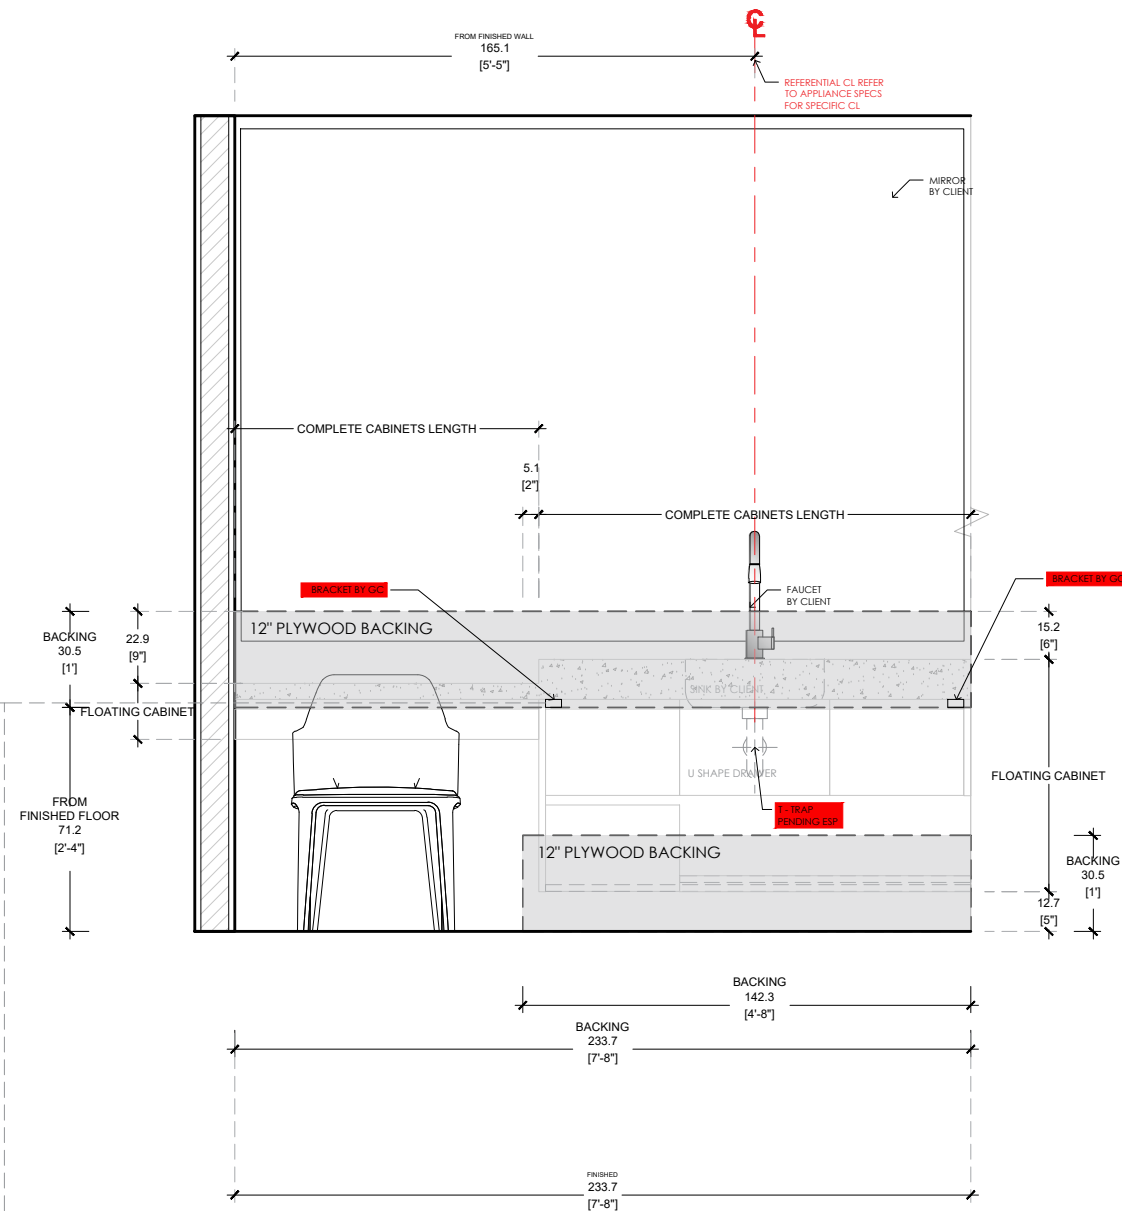

ELEVATION B SCALE 1/2"=1'-0"
CONTINUUM NORTH UNIT 2901 / BEDROOM 3 CLOSET

DETAIL PICTURE
BRACKET BY GC

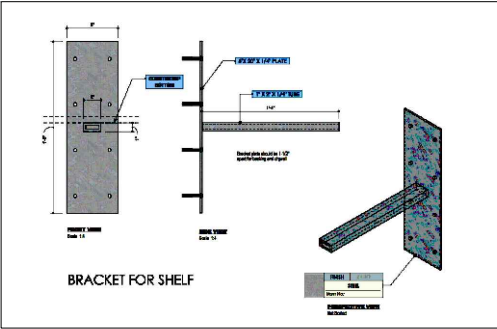

PROJECT #	0000-000
CONTINUUM NORTH	
KITCHEN - OFFICE - CLOSETS - VANITIES	
NOTES:	

CLIENT APPROVED	
DRAWINGS	☐
NOTES	☐
DATE:	
SIGNATURE:	

REVISION LOG	
1.0	03/30/2026
2.0	05/12/2026
3.0	05/13/2026
4.0	05/19/2026
5.0	06/02/2026
6.0	06/09/2026
7.0	06/16/2026
8.0	06/30/2026
9.0	07/06/2026
10.0	07/14/2026

DATE:	07/14/2026
REV:	9.0
DIMENSION:	CM/INCH
DRAWN BY:	KVA