

# ELECTRICAL NOTES

N1: New switched elec. outlets at ceiling, provide "remodel" J BOX elec. outlet with min. 5' slack. These are for LED, low voltage non-dimable, plug and play lights with integrated Poliform transformers. Switch location to be determined by client / architect.


N2: New convenience elec. outlets at dimensioned heights. Provide "remodel" J BOX elec. outlet with min. 5' slack; to be trimmed upon cabinetry install. Position of in-cabinetry convenience elec. outlets is approximate.

N3: New elec. outlets height at ceiling. These are for LED, low voltage non-dimable, plug and play lights with integrated Poliform transformers, controlled by a motion sensor.

## BEDROOM 2

### FINISHES - unless noted otherwise:

- Structure / Interior : OLMO ELM
- Door / Exterior : Mat Lacquer CANAPA
- Metal Accent : CHAMPAGNE

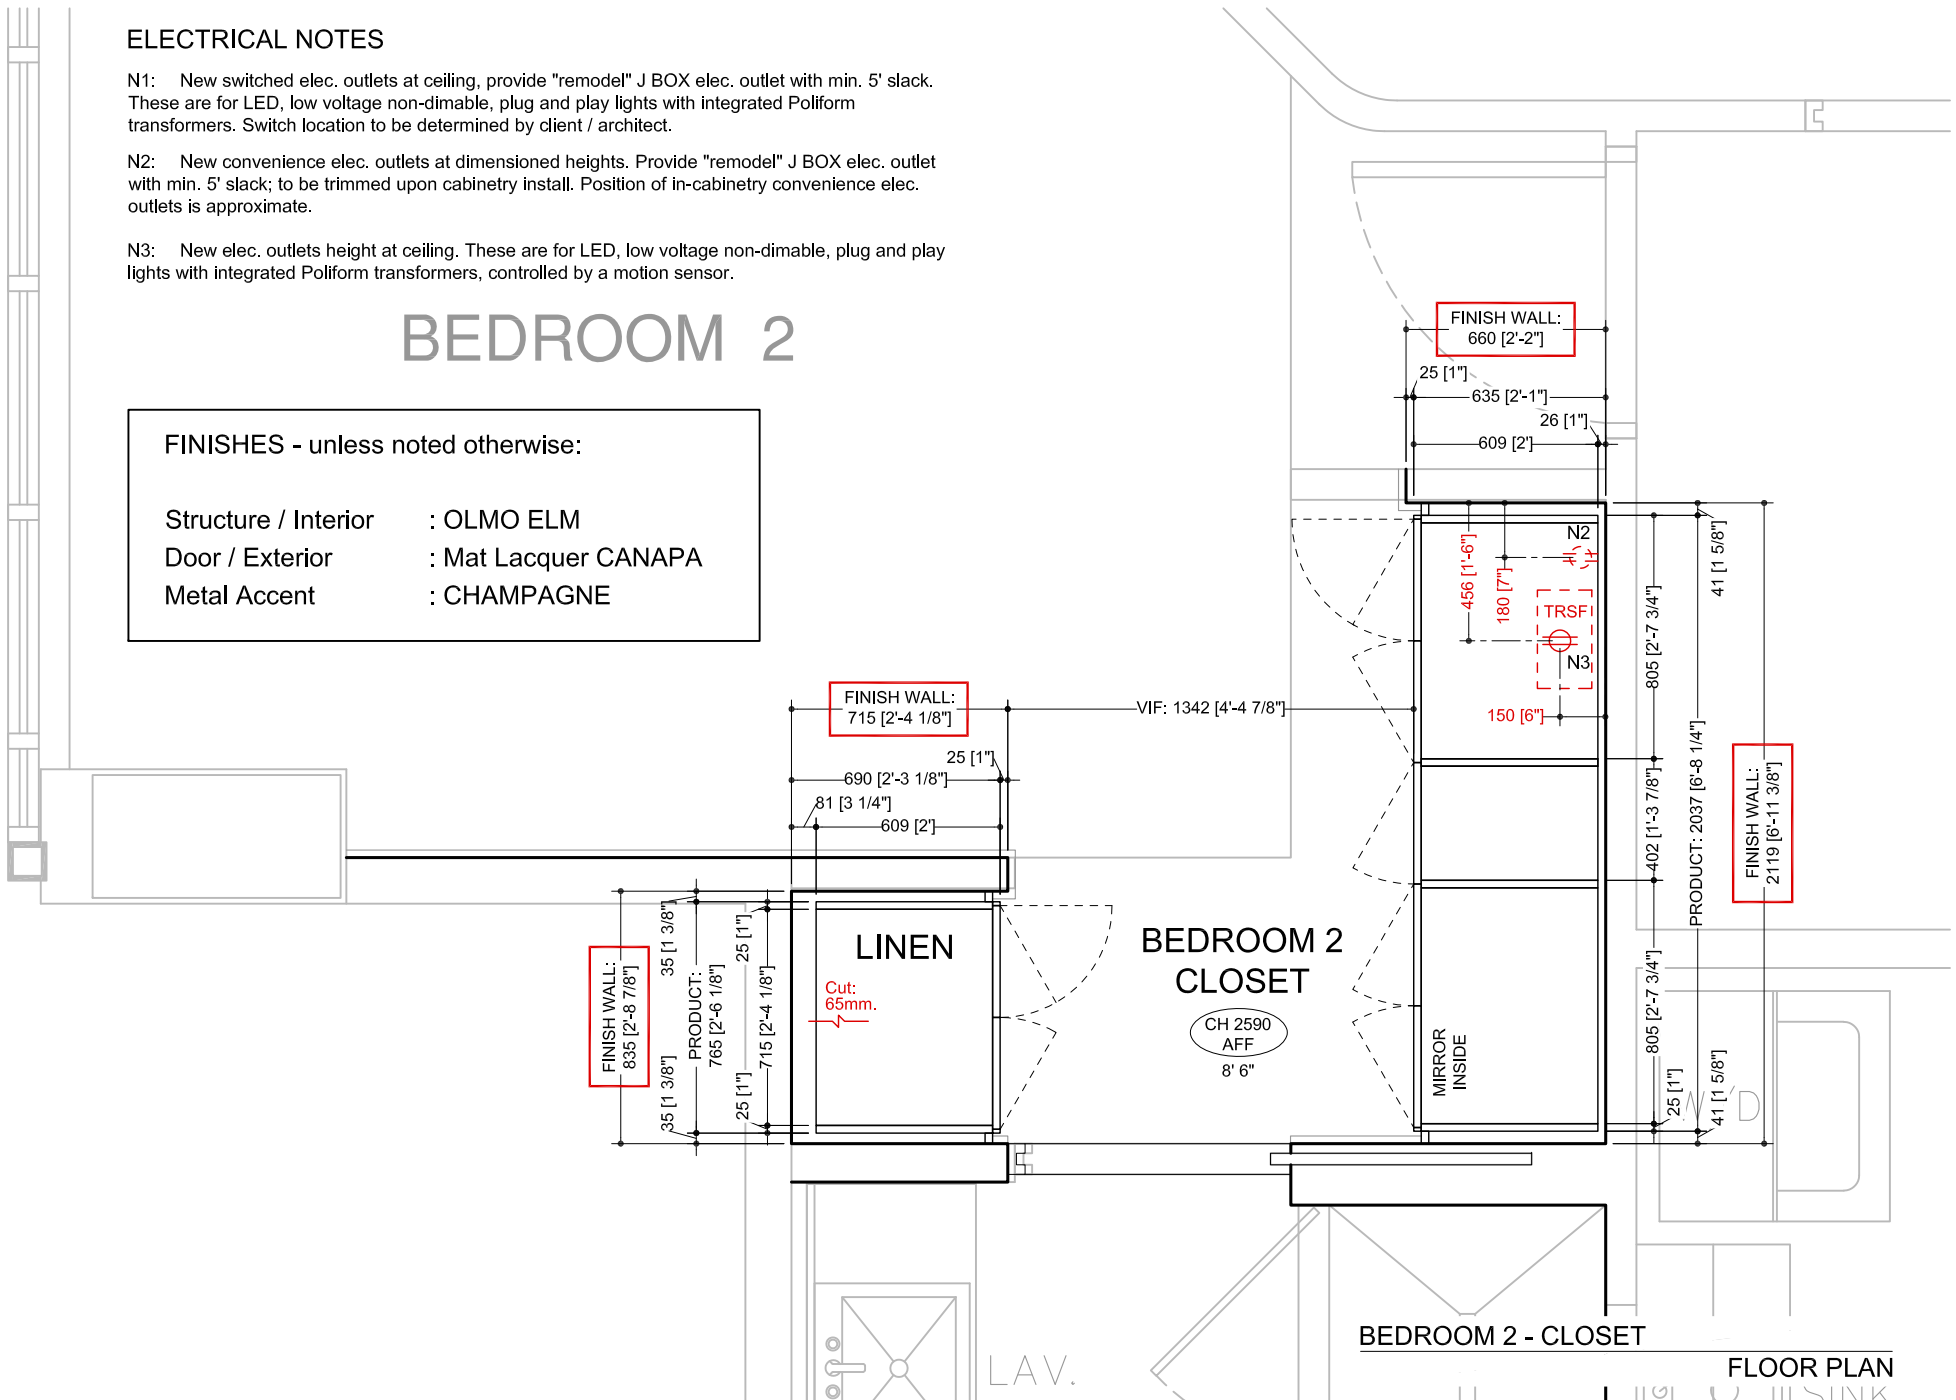



# ELECTRICAL NOTES

N1: New switched elec. outlets at ceiling, provide "remodel" J BOX elec. outlet with min. 5' slack. These are for LED, low voltage non-dimable, plug and play lights with integrated Poliform transformers. Switch location to be determined by client / architect.

N2: New convenience elec. outlets at dimensioned heights. Provide "remodel" J BOX elec. outlet with min. 5' slack; to be trimmed upon cabinetry install. Position of in-cabinetry convenience elec. outlets is approximate.

N3: New elec. outlets height at ceiling. These are for LED, low voltage non-dimable, plug and play lights with integrated Poliform transformers, controlled by a motion sensor.

INSIDE

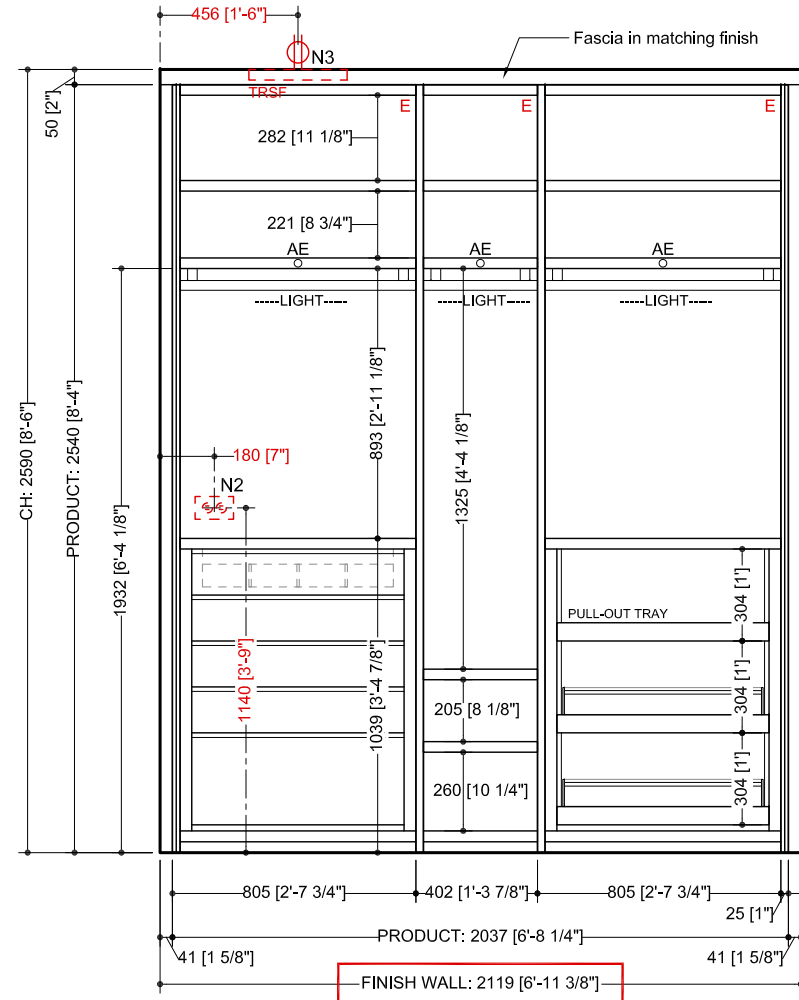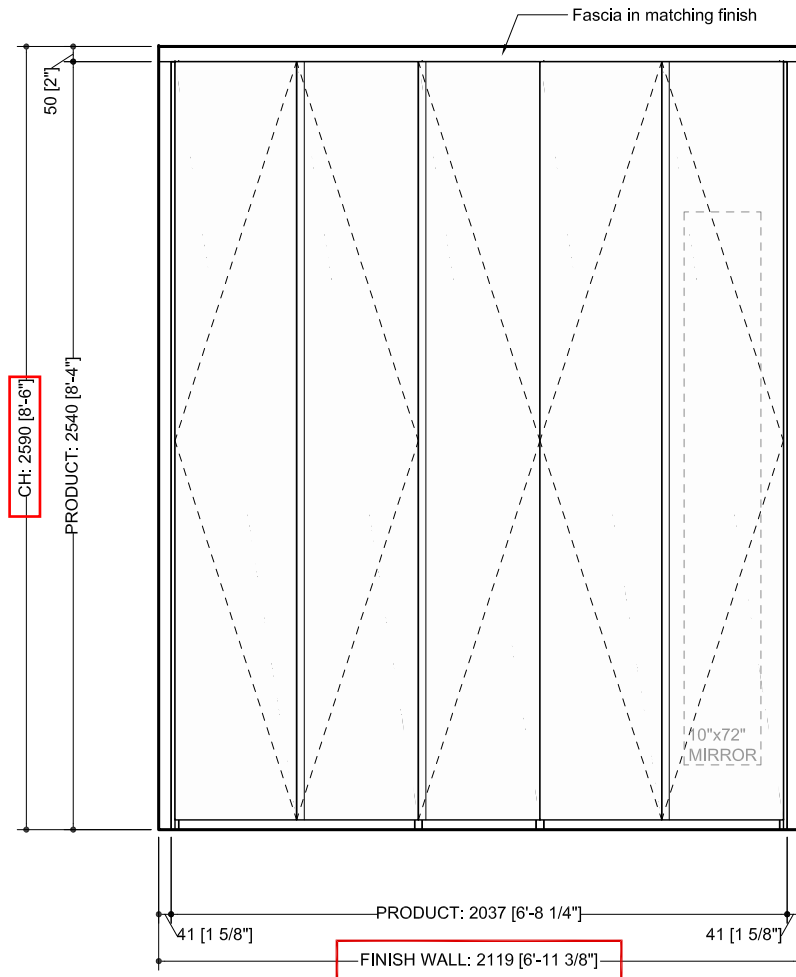

BEDROOM 2 - CLOSET

ELEVATION



Poliform | sagartstudio  
 2611 P St NW  
 Washington, DC 20007  
 202.554.8658  
 www.poliformdc.com

Client: HERTRICH Residence

Date: 2022.03.30



Street: 1908-09 Continuum South

Scale: 1:25

City: Miami State: FL


Drawn by: SKP

Page:

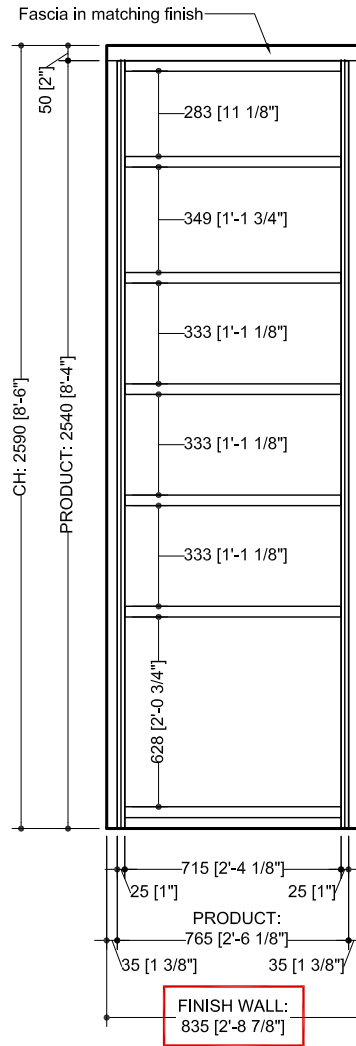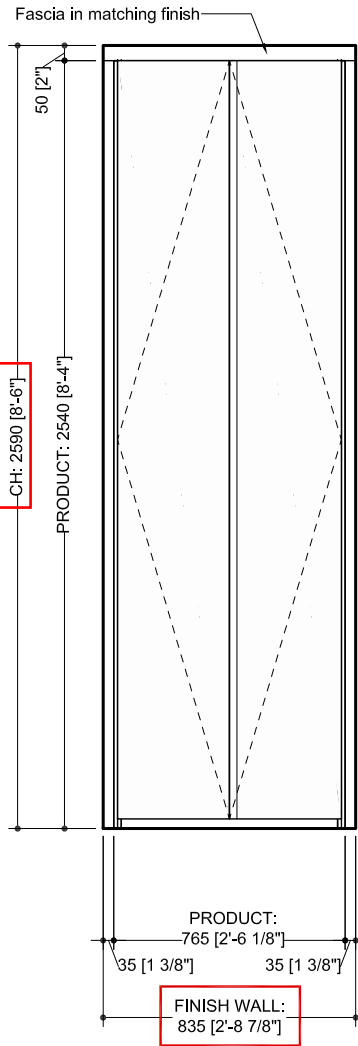

BEDROOM 2 - LINEN CLOSET  
ELEVATION

V 4

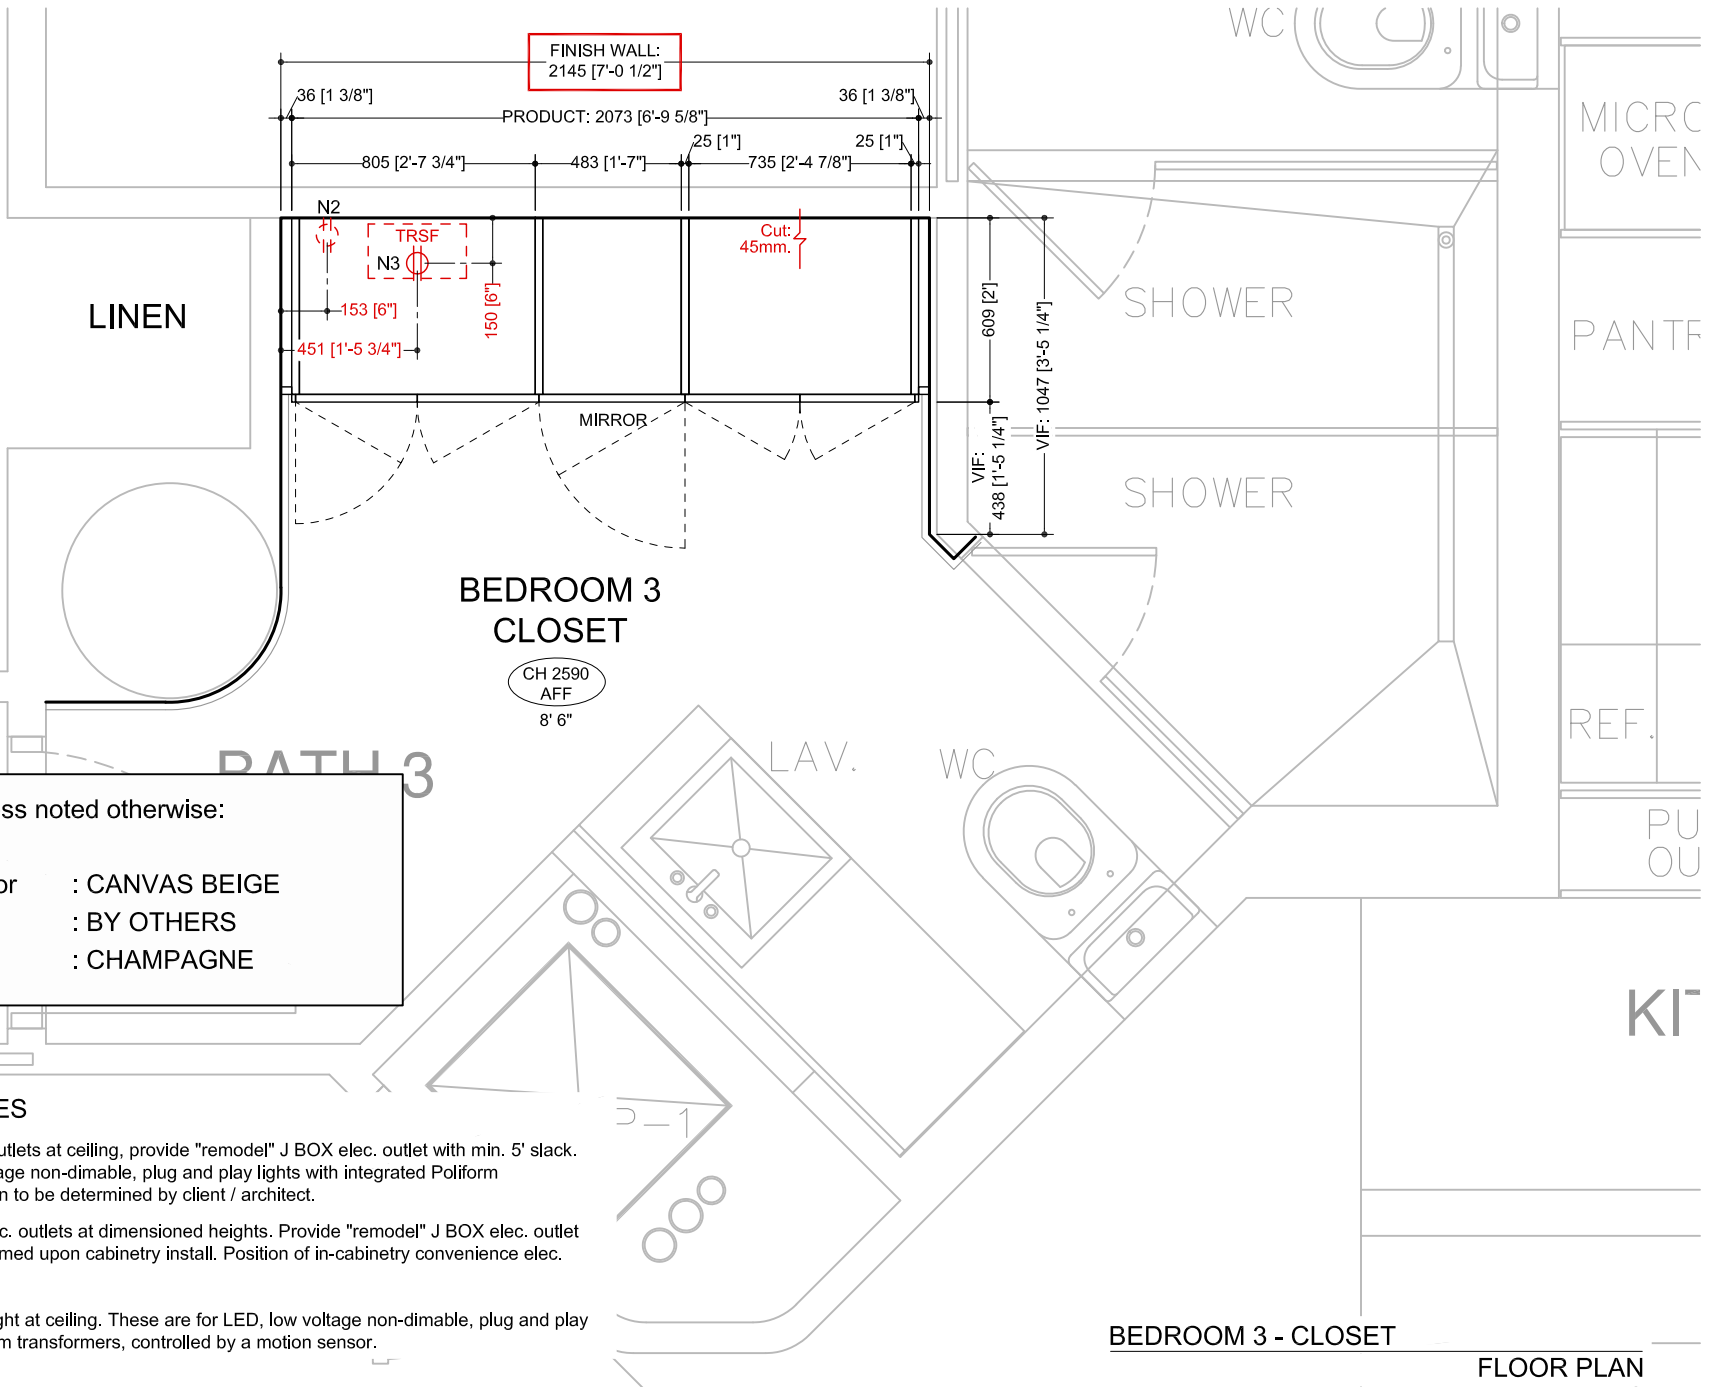

LINEN

BEDROOM 3  
CLOSET

CH 2590  
AFF  
8' 6"

BATH 3

LAV.

WC

MICRO  
OVEN

PANTRY

REF.

PU  
OU

KIT

SHOWER

SHOWER

**FINISHES - unless noted otherwise:**

- Structure / Interior : CANVAS BEIGE
- Door / Exterior : BY OTHERS
- Metal Accent : CHAMPAGNE

**ELECTRICAL NOTES**

- N1: New switched elec. outlets at ceiling, provide "remodel" J BOX elec. outlet with min. 5' slack. These are for LED, low voltage non-dimable, plug and play lights with integrated Poliform transformers. Switch location to be determined by client / architect.
- N2: New convenience elec. outlets at dimensioned heights. Provide "remodel" J BOX elec. outlet with min. 5' slack; to be trimmed upon cabinetry install. Position of in-cabinetry convenience elec. outlets is approximate.
- N3: New elec. outlets height at ceiling. These are for LED, low voltage non-dimable, plug and play lights with integrated Poliform transformers, controlled by a motion sensor.

BEDROOM 3 - CLOSET

FLOOR PLAN



Poliform | sagartstudio  
2611 P St NW  
Washington, DC 20007  
202.554.8658  
www.poliformdc.com



Client: HERTRICH Residence	Date: 2022.03.30
Street: 1908-09 Continuum South	Scale: 1:25
City: Miami State: FL	Drawn by: SKP
Page:	

# ELECTRICAL NOTES

N1: New switched elec. outlets at ceiling, provide "remodel" J BOX elec. outlet with min. 5' slack. These are for LED, low voltage non-dimable, plug and play lights with integrated Poliform transformers. Switch location to be determined by client / architect.

N2: New convenience elec. outlets at dimensioned heights. Provide "remodel" J BOX elec. outlet with min. 5' slack; to be trimmed upon cabinetry install. Position of in-cabinetry convenience elec. outlets is approximate.

N3: New elec. outlets height at ceiling. These are for LED, low voltage non-dimable, plug and play lights with integrated Poliform transformers, controlled by a motion sensor.

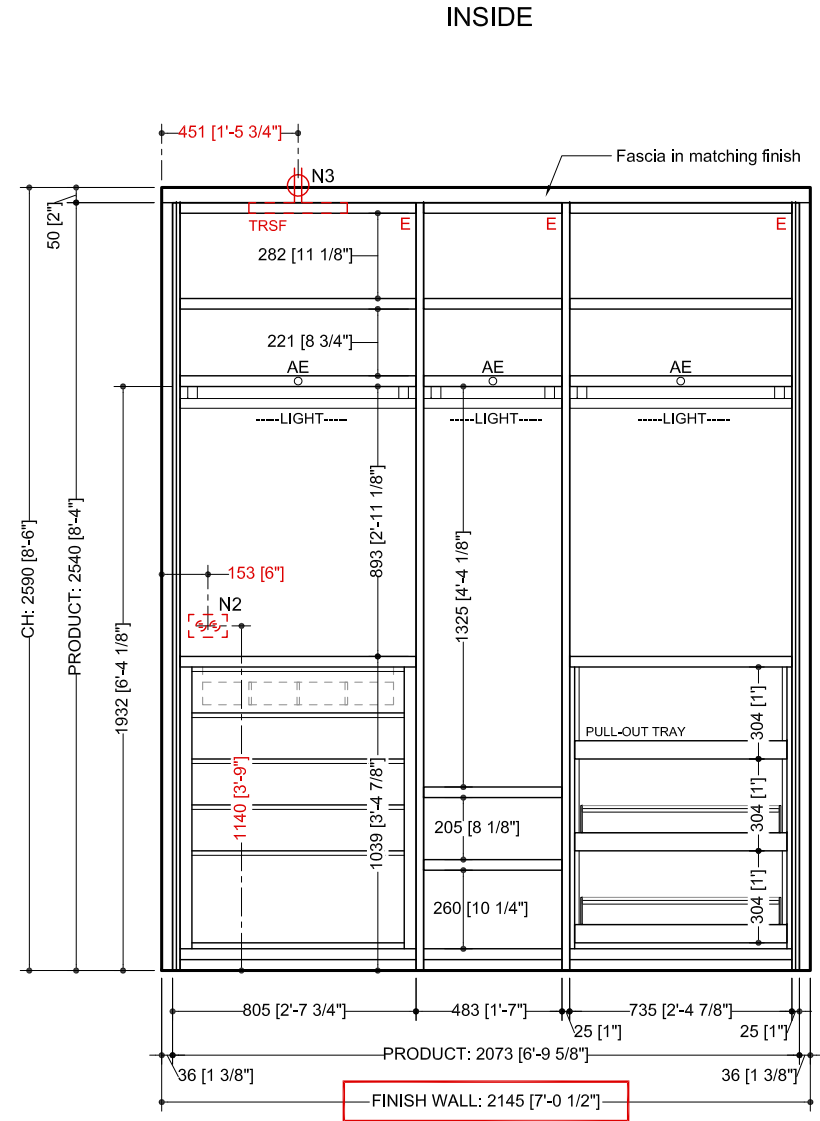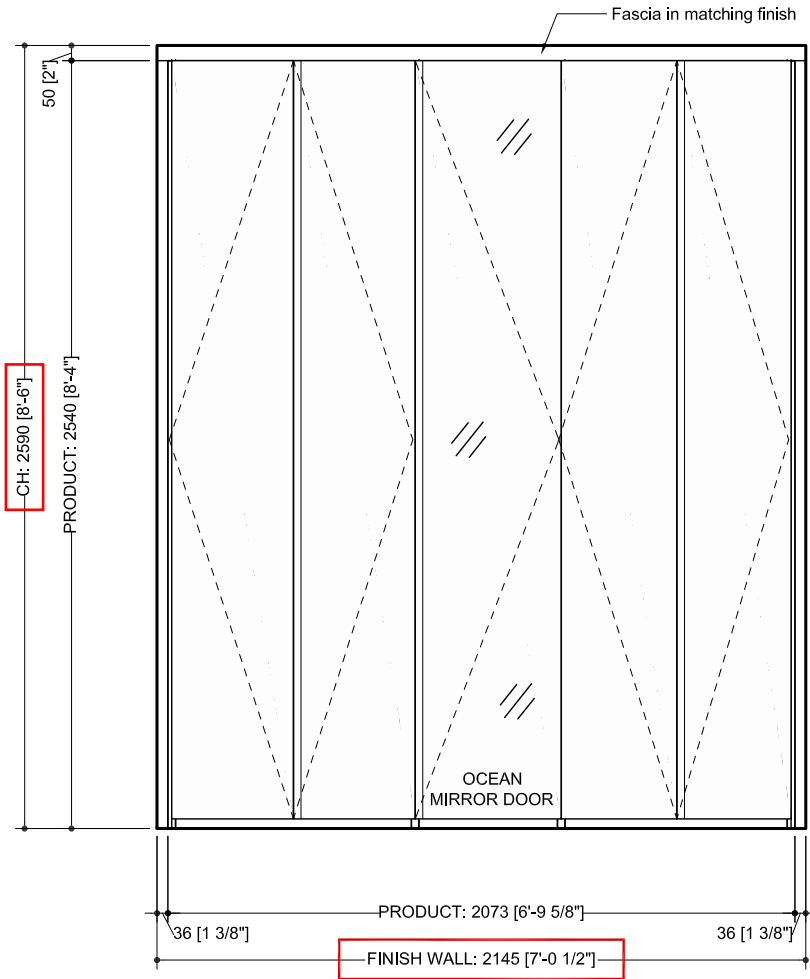

**BEDROOM 3 - CLOSET**  
ELEVATION



Poliform | sagartstudio  
2611 P St NW  
Washington, DC 20007  
202.554.8658  
www.poliformdc.com

Client: HERTRICH Residence

Date: 2022.03.30

Street: 1908-09 Continuum South

Scale: 1:25

City: Miami State: FL

Drawn by: SKP

Page:

# ELECTRICAL NOTES


N1: New switched elec. outlets at ceiling, provide "remodel" J BOX elec. outlet with min. 5' slack. These are for LED, low voltage non-dimable, plug and play lights with integrated Poliform transformers. Switch location to be determined by client / architect.

N2: New convenience elec. outlets at dimensioned heights. Provide "remodel" J BOX elec. outlet with min. 5' slack; to be trimmed upon cabinetry install. Position of in-cabinetry convenience elec. outlets is approximate.

N3: New elec. outlets height at ceiling. These are for LED, low voltage non-dimable, plug and play lights with integrated Poliform transformers, controlled by a motion sensor.

## FINISHES - unless noted otherwise:

Structure / Interior : OLMO ELM  
 Door / Exterior : Mat Lacquer GHIACCIO  
 Metal Accent : CHAMPAGNE

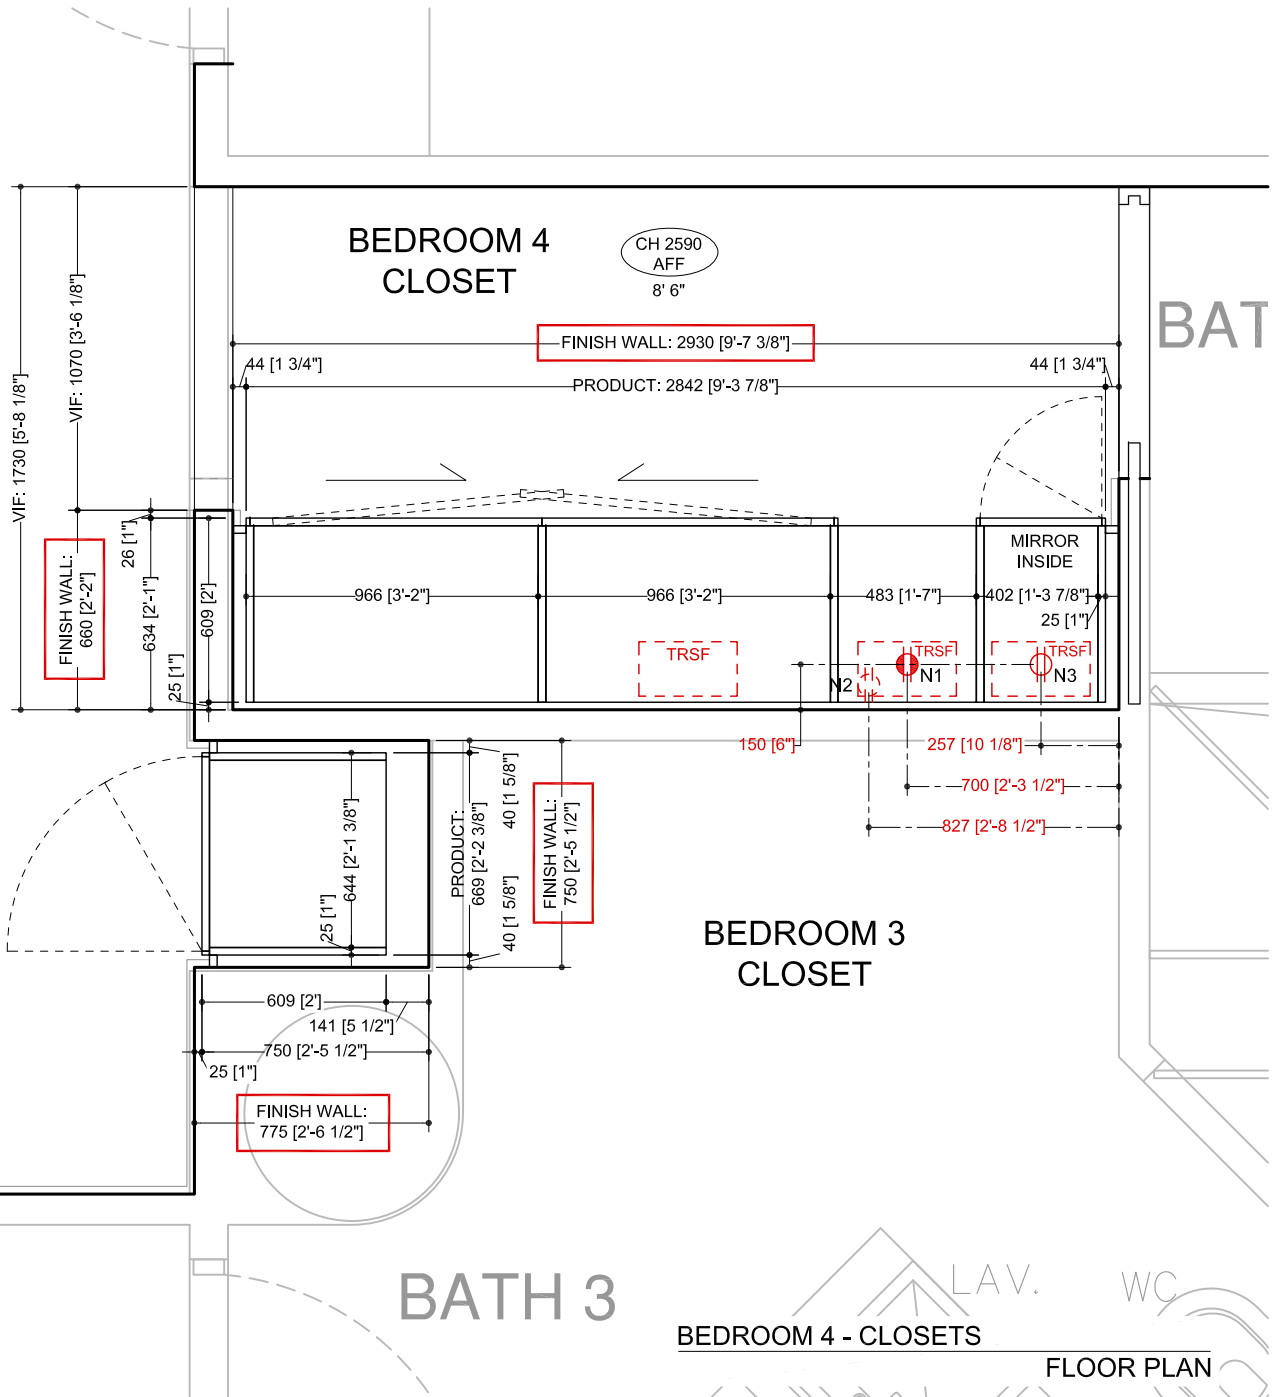

BEDROOM 4 - CLOSETS FLOOR PLAN




Poliform | sagartstudio  
 2611 P St NW  
 Washington, DC 20007  
 202.554.8658  
 www.poliformdc.com

Client: HERTRICH Residence  
 Street: 1908-09 Continuum South  
 City: Miami State: FL

Date: 2022.03.30  
 Scale: 1:25  
 Drawn by: SKP

Page:

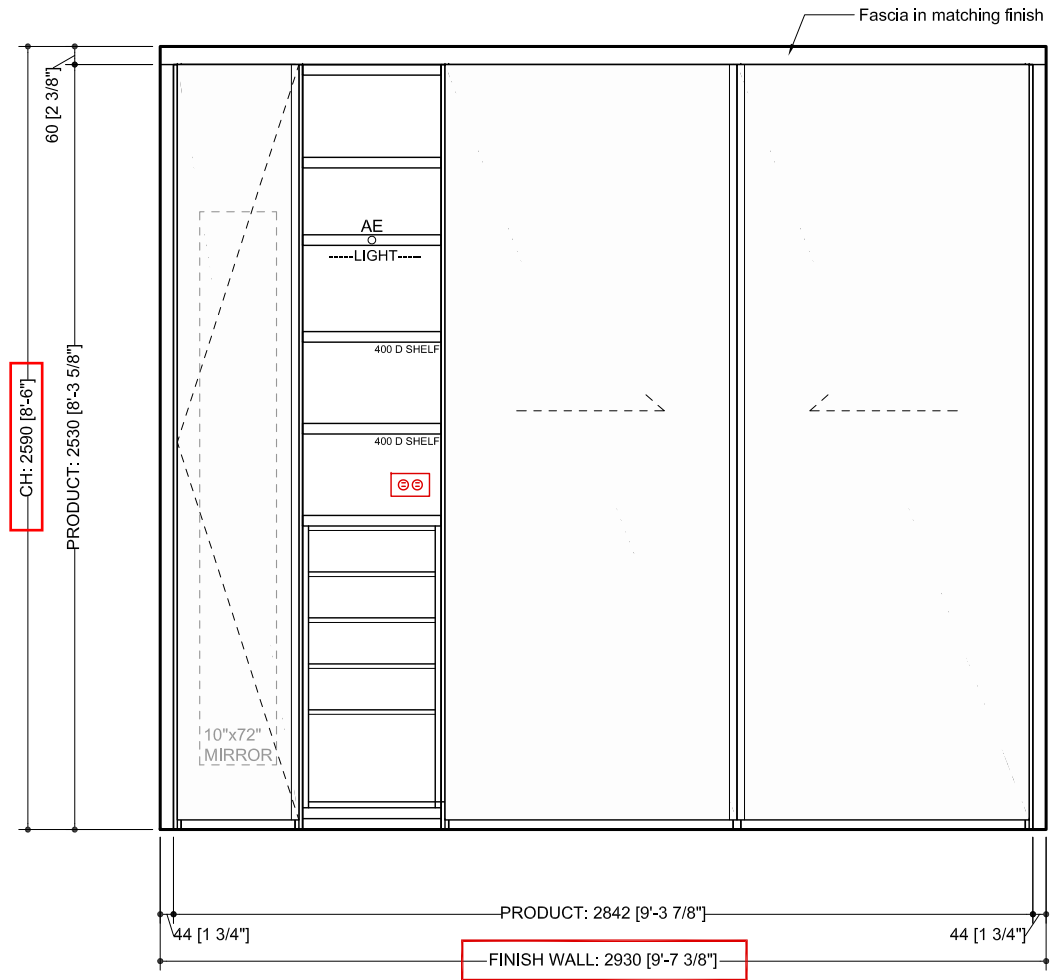

BEDROOM 4 - CLOSETS

ELEVATION




# ELECTRICAL NOTES

N1: New switched elec. outlets at ceiling, provide "remodel" J BOX elec. outlet with min. 5' slack. These are for LED, low voltage non-dimable, plug and play lights with integrated Poliform transformers. Switch location to be determined by client / architect.

N2: New convenience elec. outlets at dimensioned heights. Provide "remodel" J BOX elec. outlet with min. 5' slack; to be trimmed upon cabinetry install. Position of in-cabinetry convenience elec. outlets is approximate.

N3: New elec. outlets height at ceiling. These are for LED, low voltage non-dimable, plug and play lights with integrated Poliform transformers, controlled by a motion sensor.

INSIDE

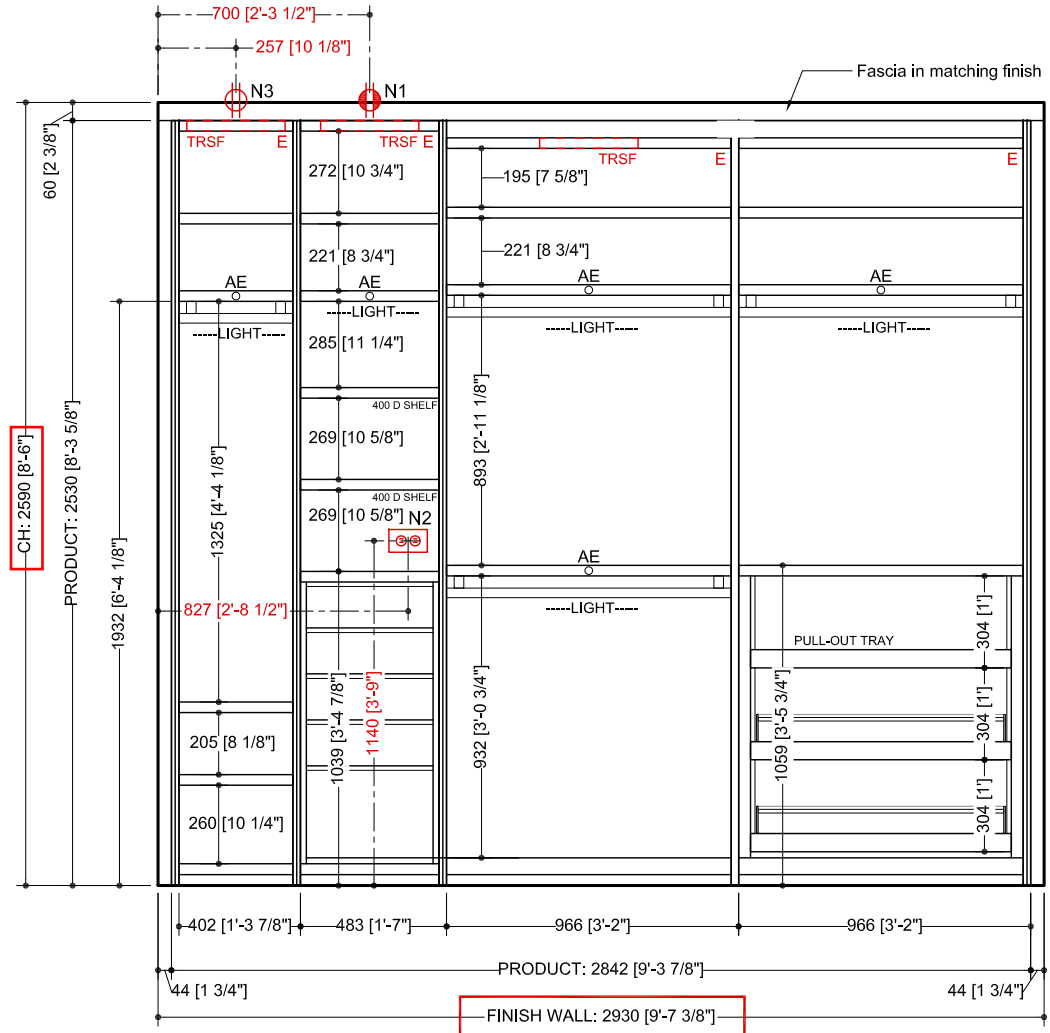

BEDROOM 4 - CLOSETS

ELEVATION



Poliform | sagartstudio  
 2611 P St NW  
 Washington, DC 20007  
 202.554.8658  
 www.poliformdc.com

| Client: HERTRICH Residence

| Date: 2022.03.30



| Street: 1908-09 Continuum South

| Scale: 1:25


| City: Miami State: FL


| Drawn by: SKP

| Page:

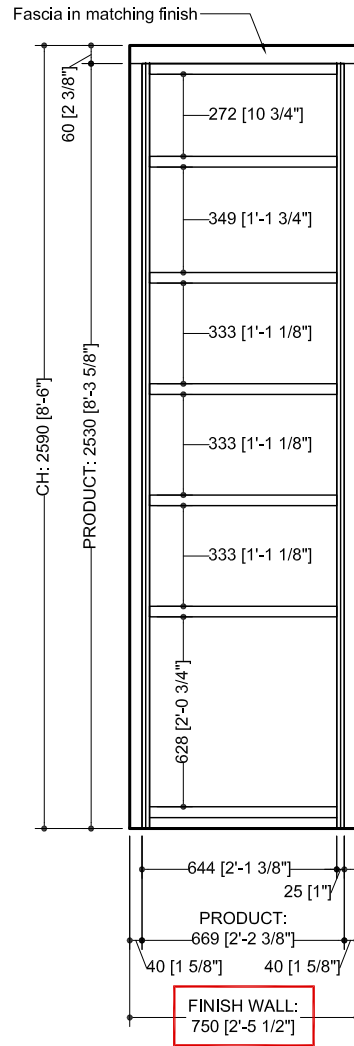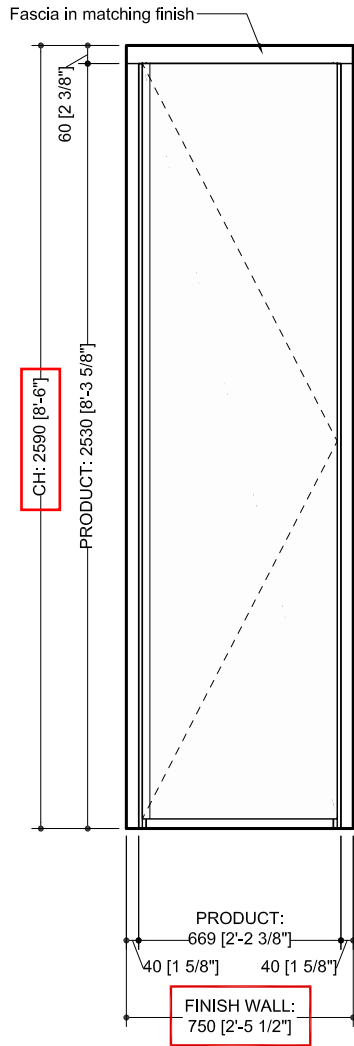

BEDROOM 4 - LINEN CLOSET  
ELEVATION

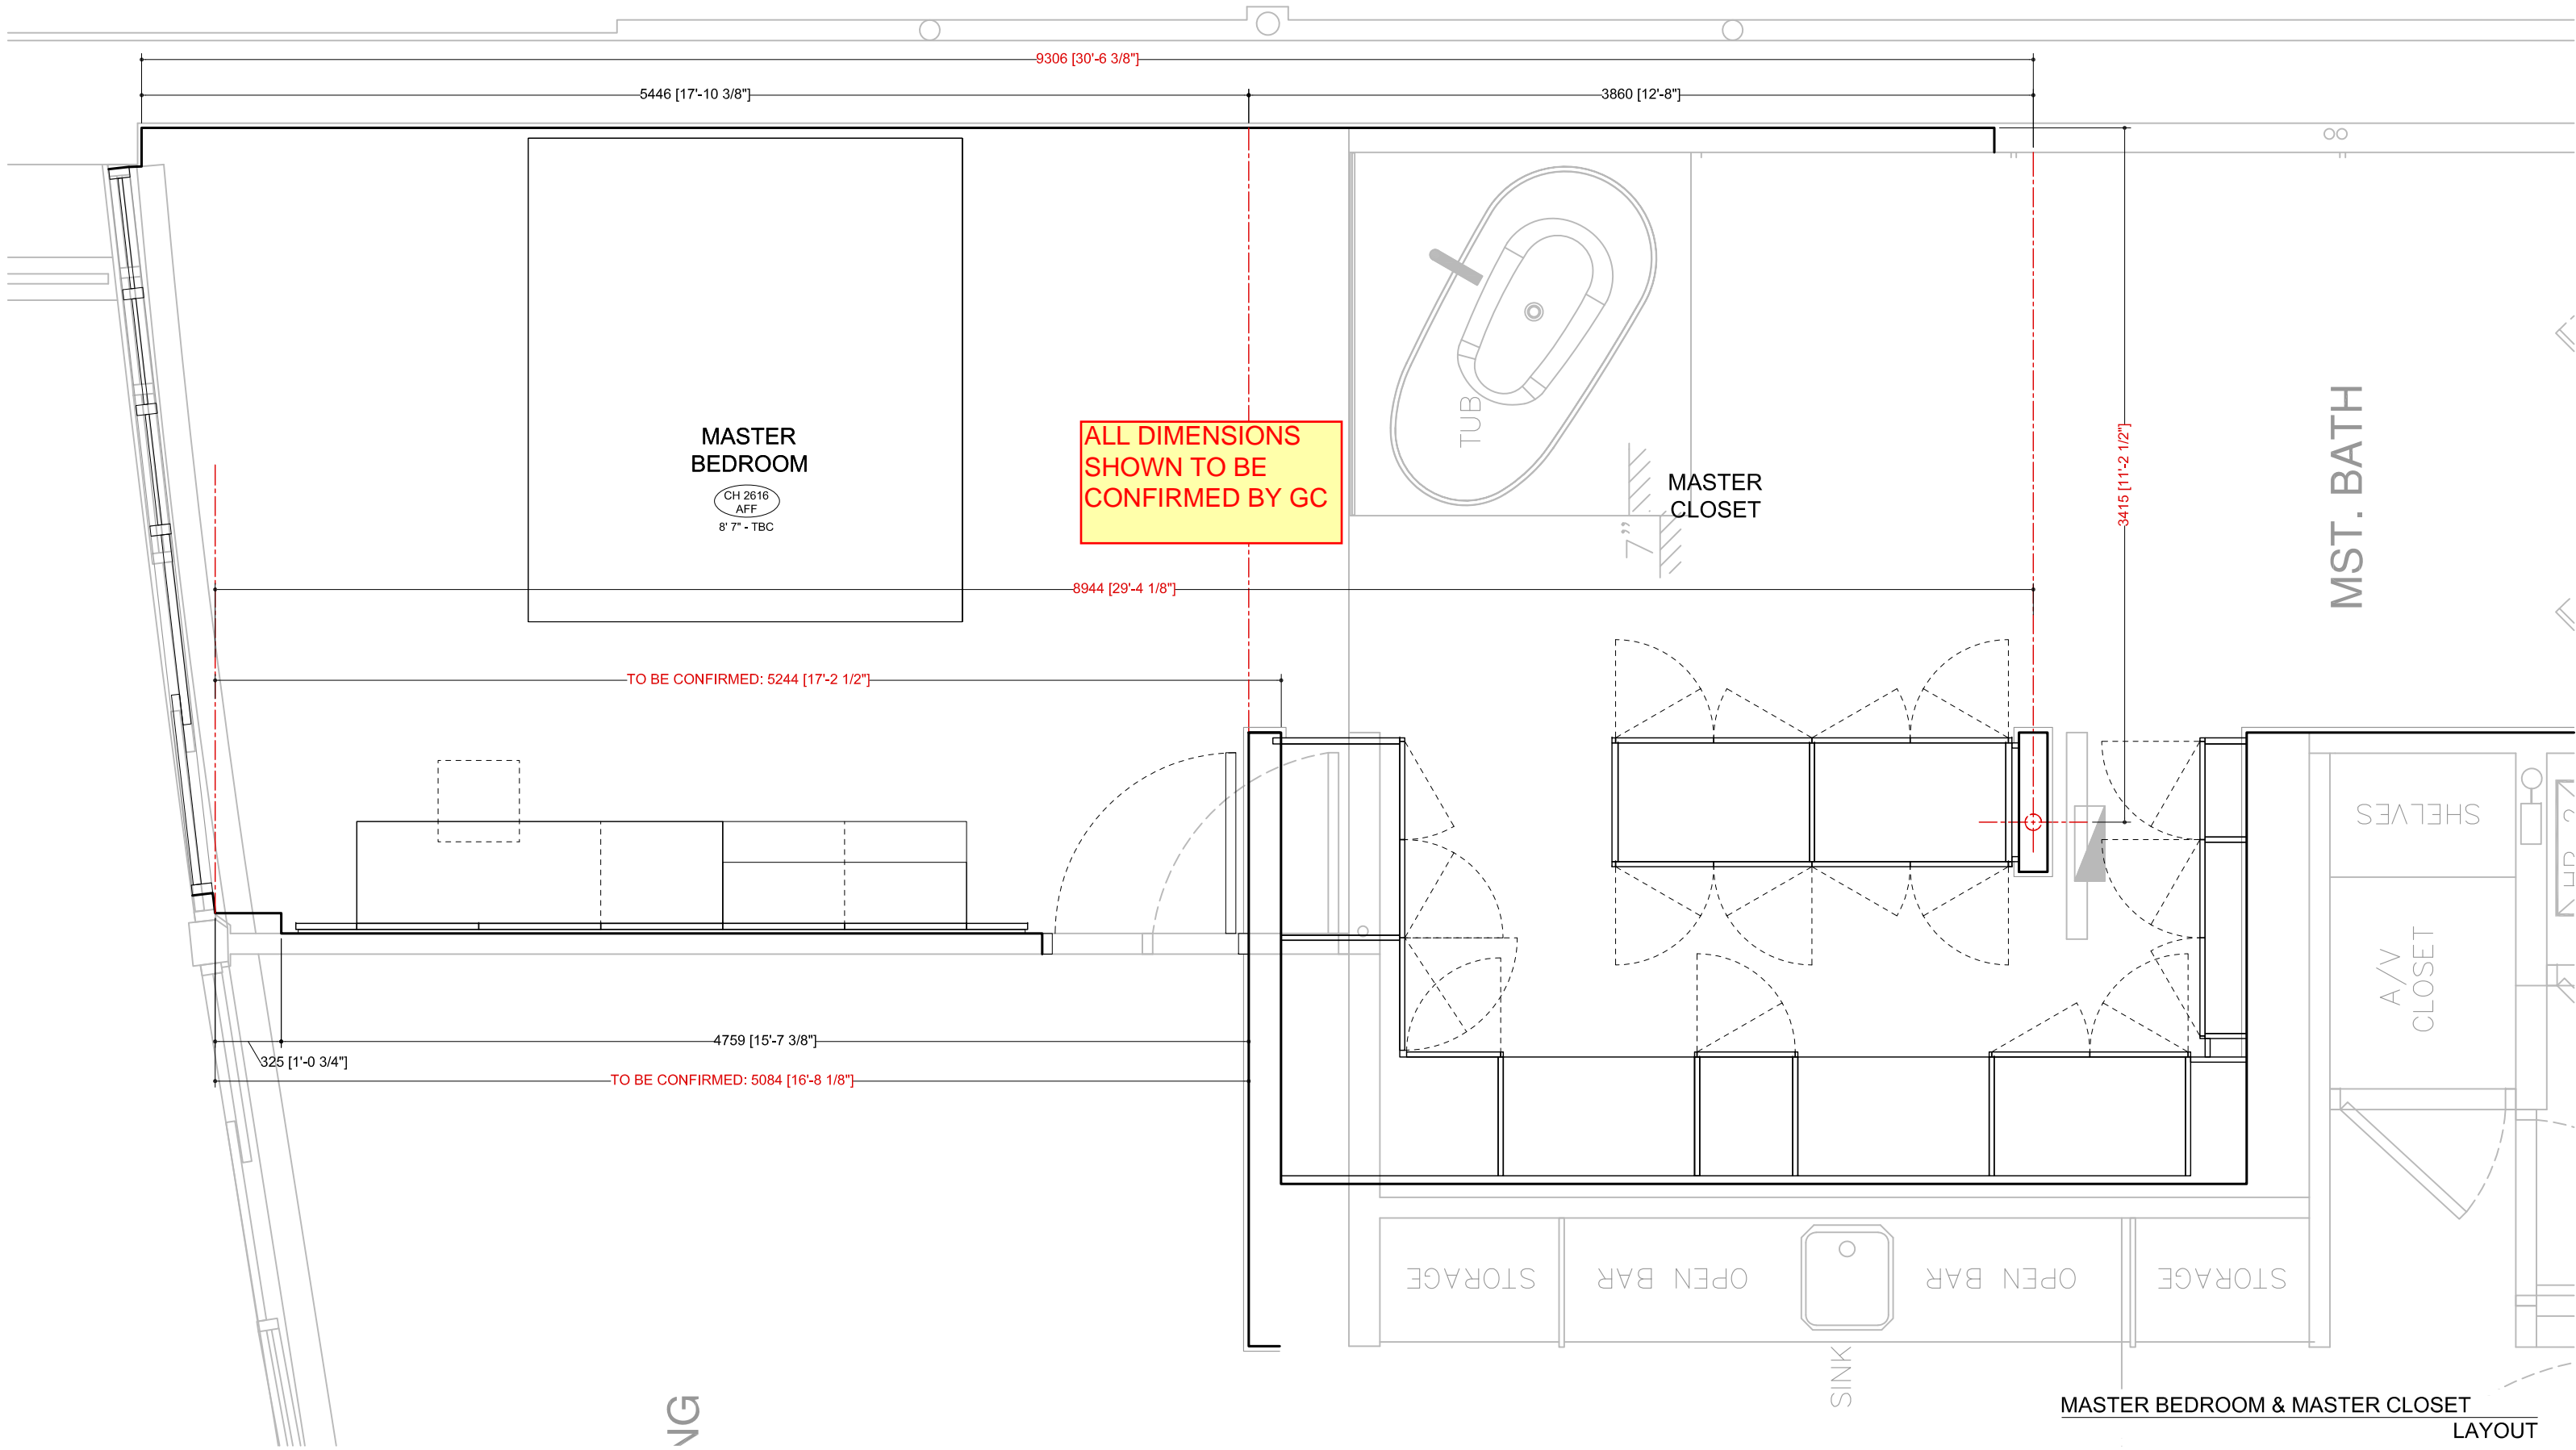

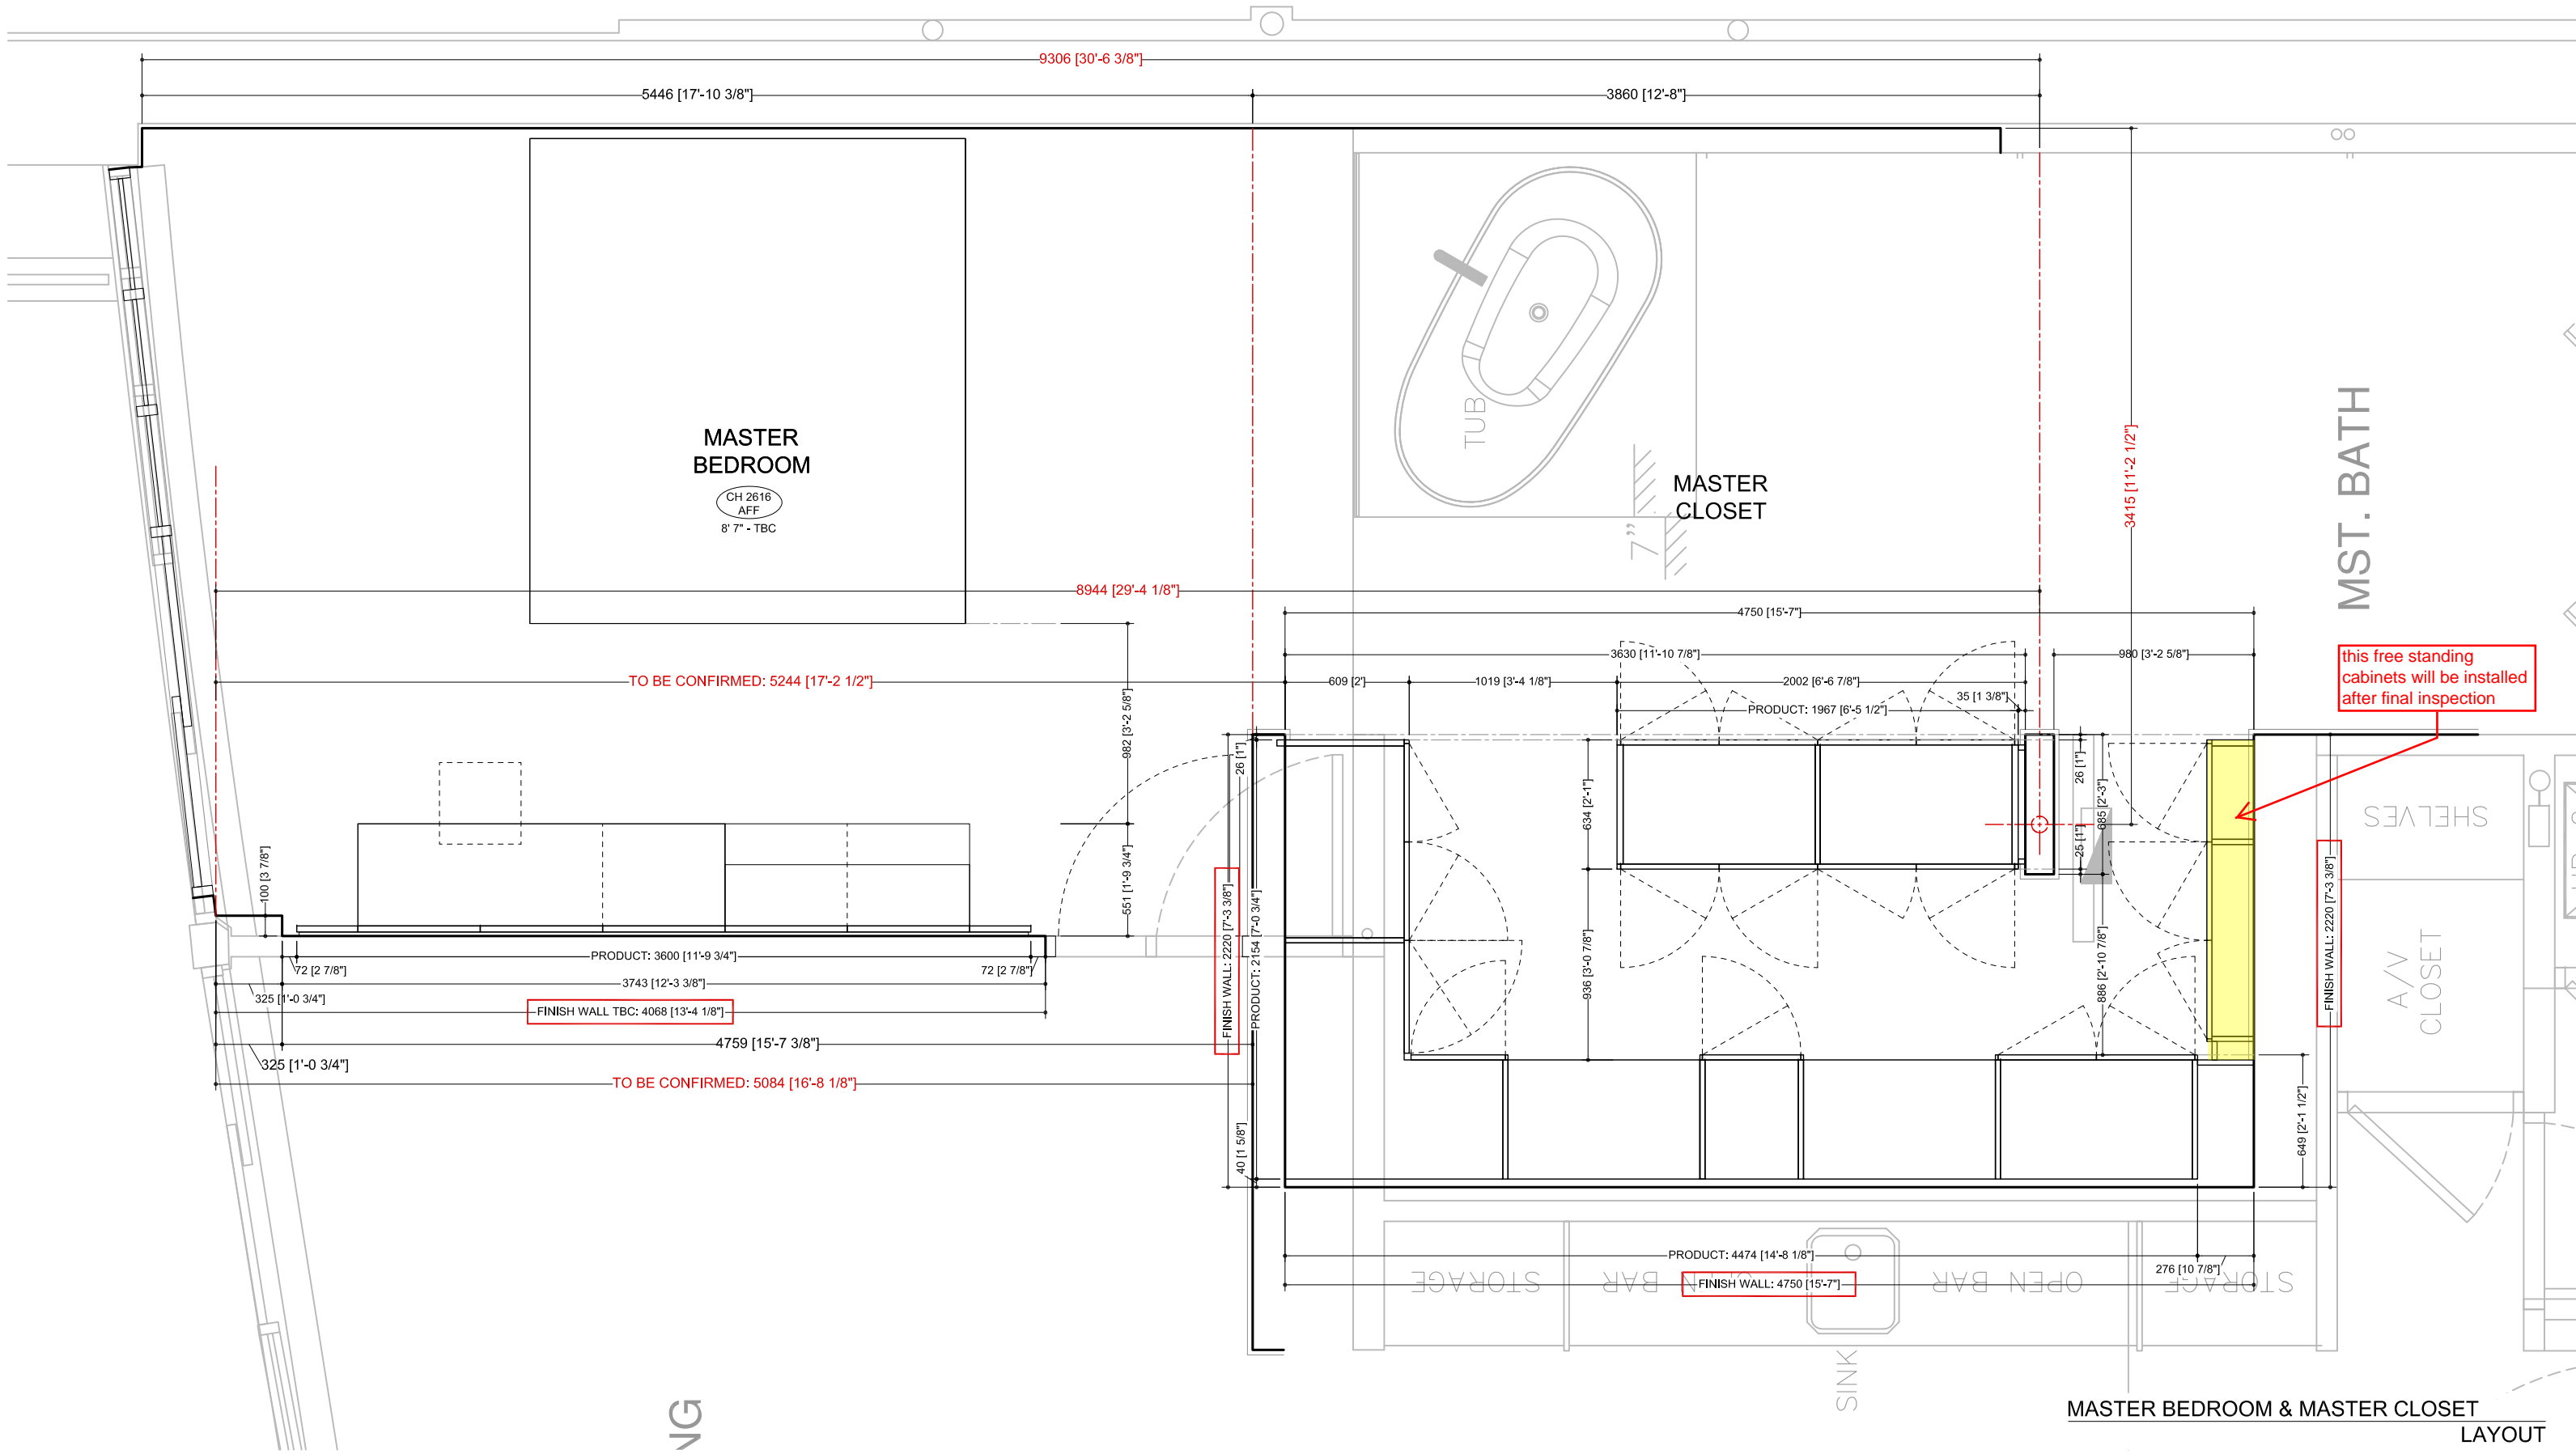


this free standing cabinets will be installed after final inspection

# MASTER CLOSET

CH 2616  
AFF  
8' 7"



\* = LATERAL SIDE IN FINISH  
MATCHING CABINET DOOR

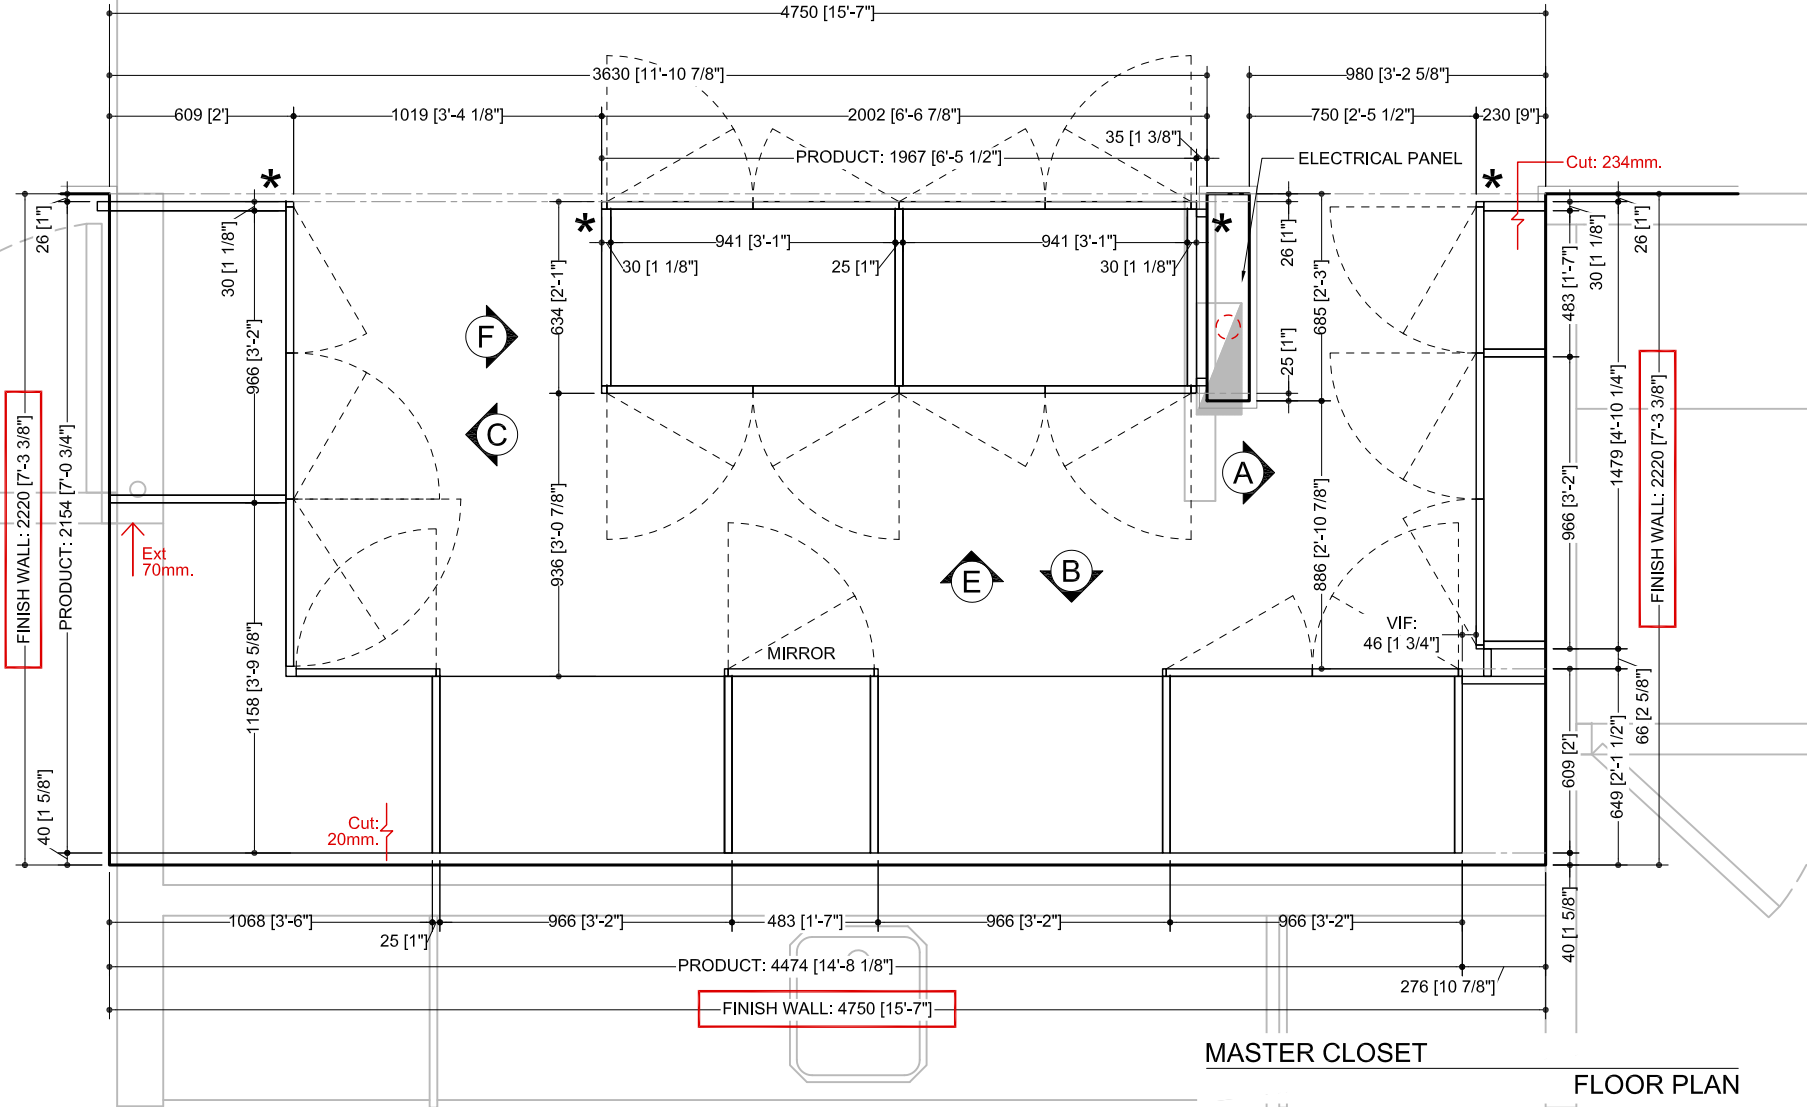

MASTER CLOSET

FLOOR PLAN

# Poliform

Poliform | sagartstudio  
2611 P St NW  
Washington, DC 20007  
202.554.8658  
www.poliformdc.com

| Client: HERTRICH Residence

| Date: 2022.03.30

| Street: 1908-09 Continuum South

| Scale: 1:25


| City: Miami State: FL

| Drawn by: SKP

| Page:

\* = LATERAL SIDE IN FINISH  
MATCHING CABINET DOOR

**MASTER CLOSET** CH 2616 AFF 8' 7" **D**

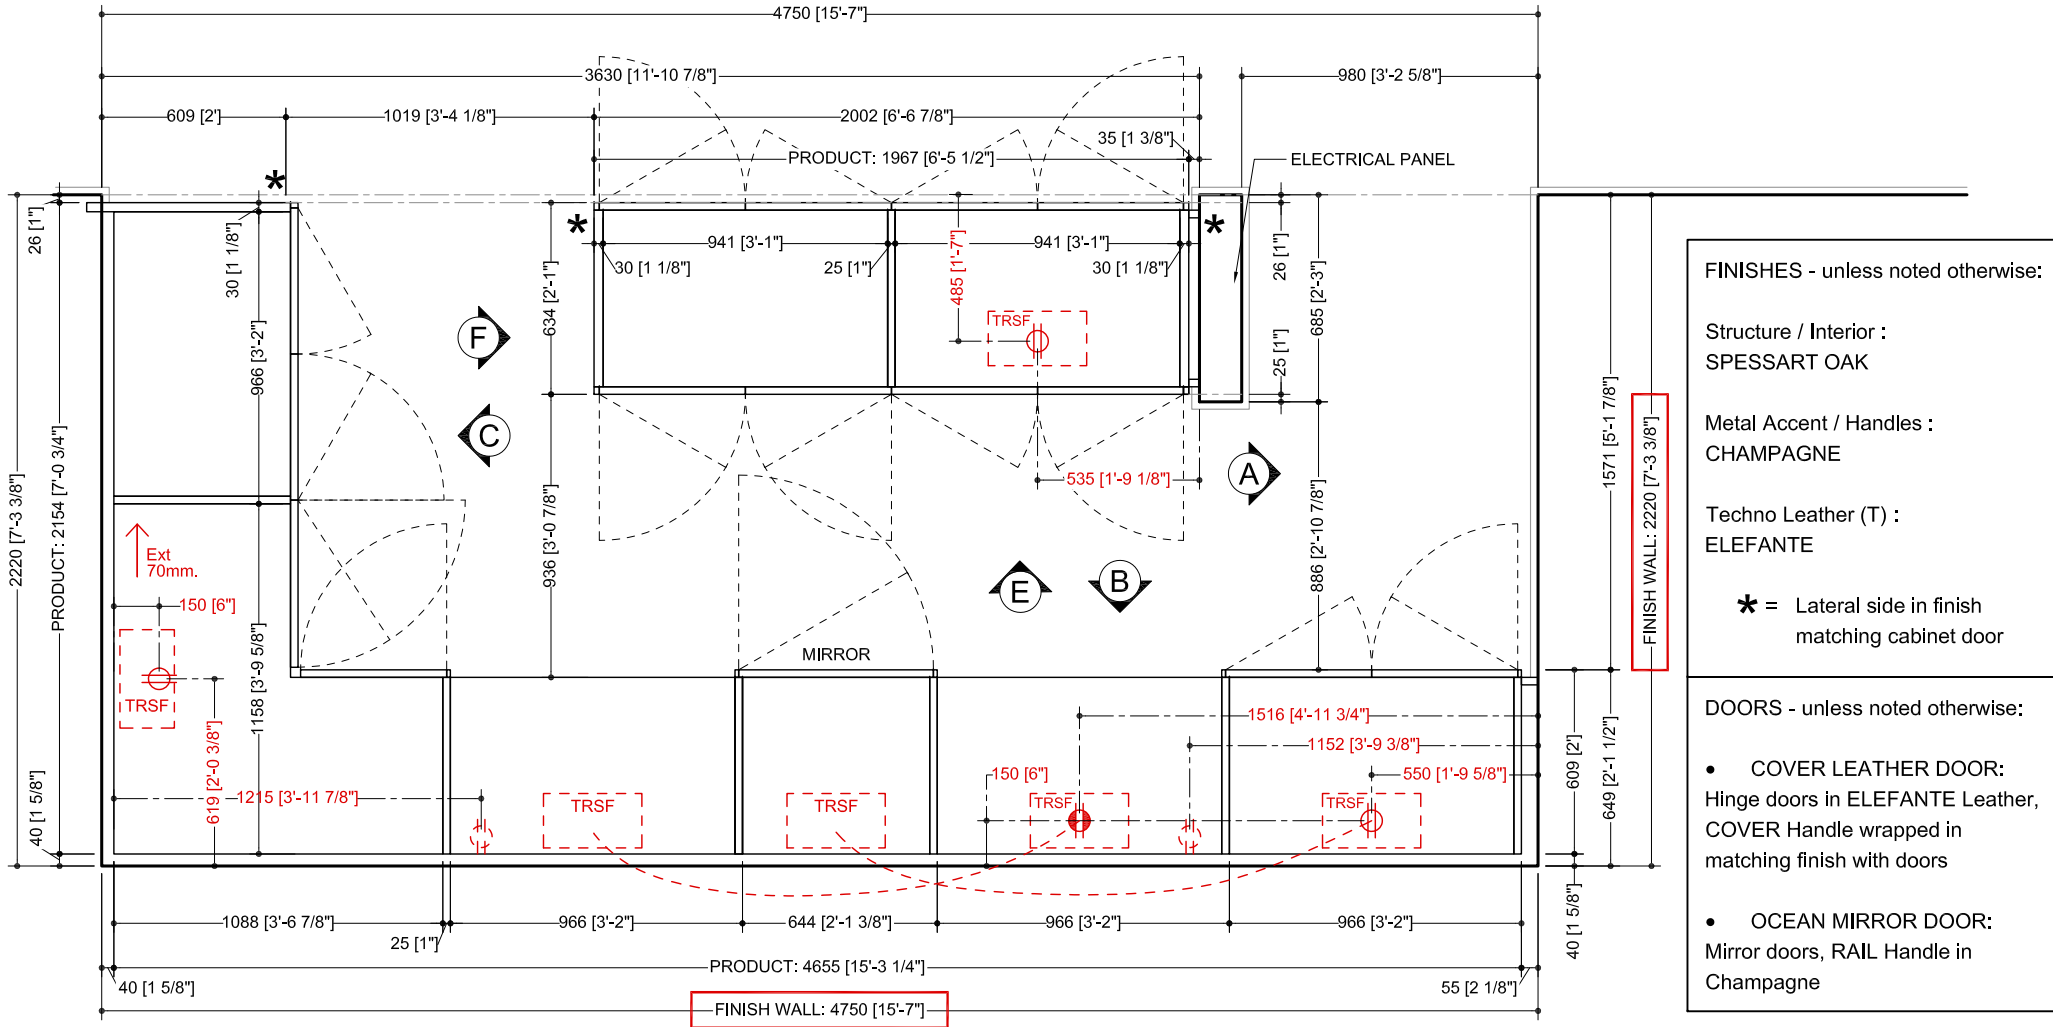

- FINISHES - unless noted otherwise:**
- Structure / Interior : SPESSART OAK
  - Metal Accent / Handles : CHAMPAGNE
  - Techno Leather (T) : ELEFANTE
- \* = Lateral side in finish matching cabinet door
- DOORS - unless noted otherwise:**
- COVER LEATHER DOOR: Hinge doors in ELEFANTE Leather, COVER Handle wrapped in matching finish with doors
  - OCEAN MIRROR DOOR: Mirror doors, RAIL Handle in Champagne

MASTER CLOSET

FLOOR PLAN



Poliform | sagartstudio  
2611 P St NW  
Washington, DC 20007  
202.554.8658  
www.poliformdc.com

Client: HERTRICH Residence

Date: 2022.03.30

Street: 1908-09 Continuum South

Scale: 1:25

City: Miami State: FL

Drawn by: SKP

Page:


# ELECTRICAL NOTES

 N1: New switched elec. outlets at ceiling, provide "remodel" J BOX elec. outlet with min. 5' slack. These are for LED, low voltage non-dimable, plug and play lights with integrated Poliform transformers. Switch location to be determined by client / architect.


N2: New convenience elec. outlets at dimensioned heights. Provide "remodel" J BOX elec. outlet with min. 5' slack; to be trimmed upon cabinetry install. Position of in-cabinetry convenience elec. outlets is approximate.

N3: New elec. outlets height at ceiling. These are for LED, low voltage non-dimable, plug and play lights with integrated Poliform transformers, controlled by a motion sensor.

## MASTER CLOSET



\* = LATERAL SIDE IN FINISH MATCHING CABINET DOOR

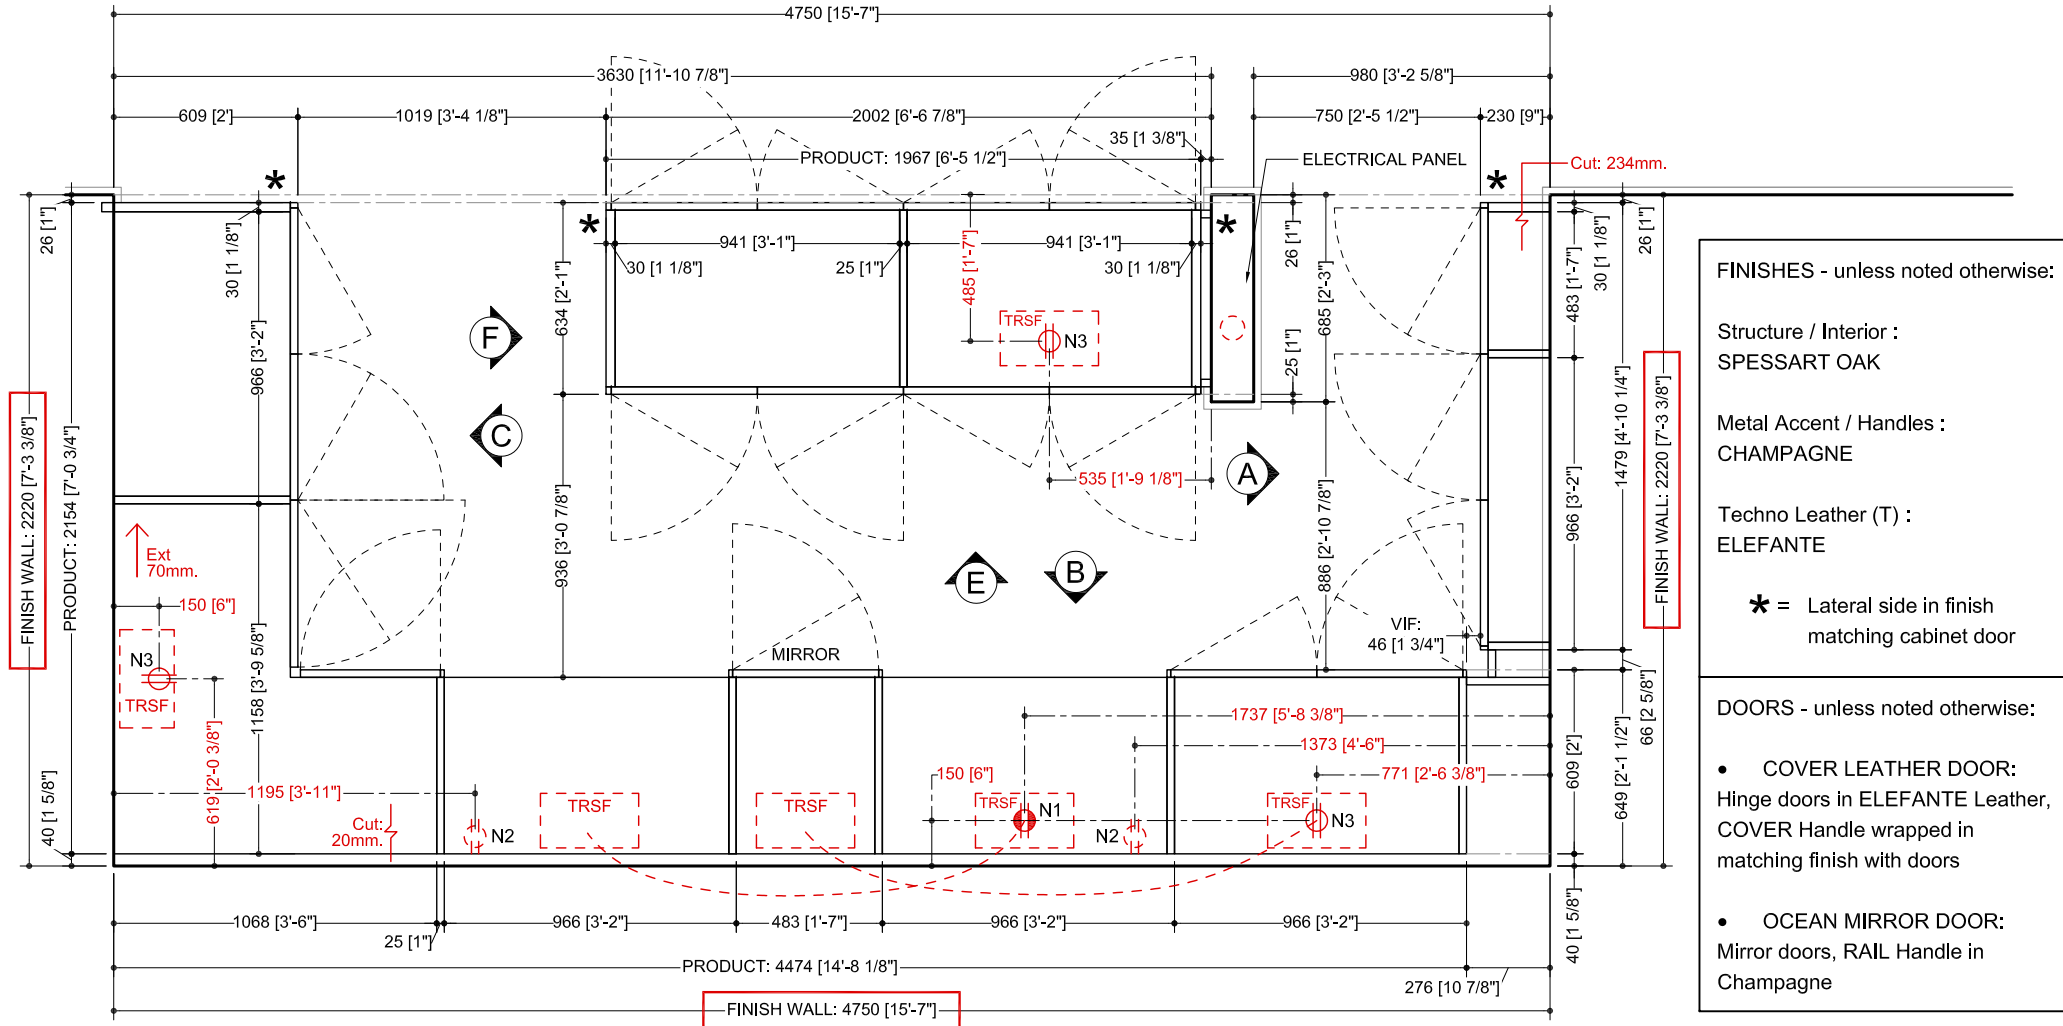

**FINISHES - unless noted otherwise:**

Structure / Interior :  
SPESSART OAK

Metal Accent / Handles :  
CHAMPAGNE

Techno Leather (T) :  
ELEFANTE

\* = Lateral side in finish matching cabinet door

**DOORS - unless noted otherwise:**

- COVER LEATHER DOOR: Hinge doors in ELEFANTE Leather, COVER Handle wrapped in matching finish with doors
- OCEAN MIRROR DOOR: Mirror doors, RAIL Handle in Champagne

MASTER CLOSET

FLOOR PLAN



Poliform | sagartstudio  
2611 P St NW  
Washington, DC 20007  
202.554.8658  
www.poliformdc.com



Client: HERTRICH Residence  
Street: 1908-09 Continuum South  
City: Miami State: FL

Date: 2022.03.30  
Scale: 1:25  
Drawn by: SKP

Page:

INSIDE


\* = LATERAL SIDE IN FINISH  
MATCHING CABINET DOOR

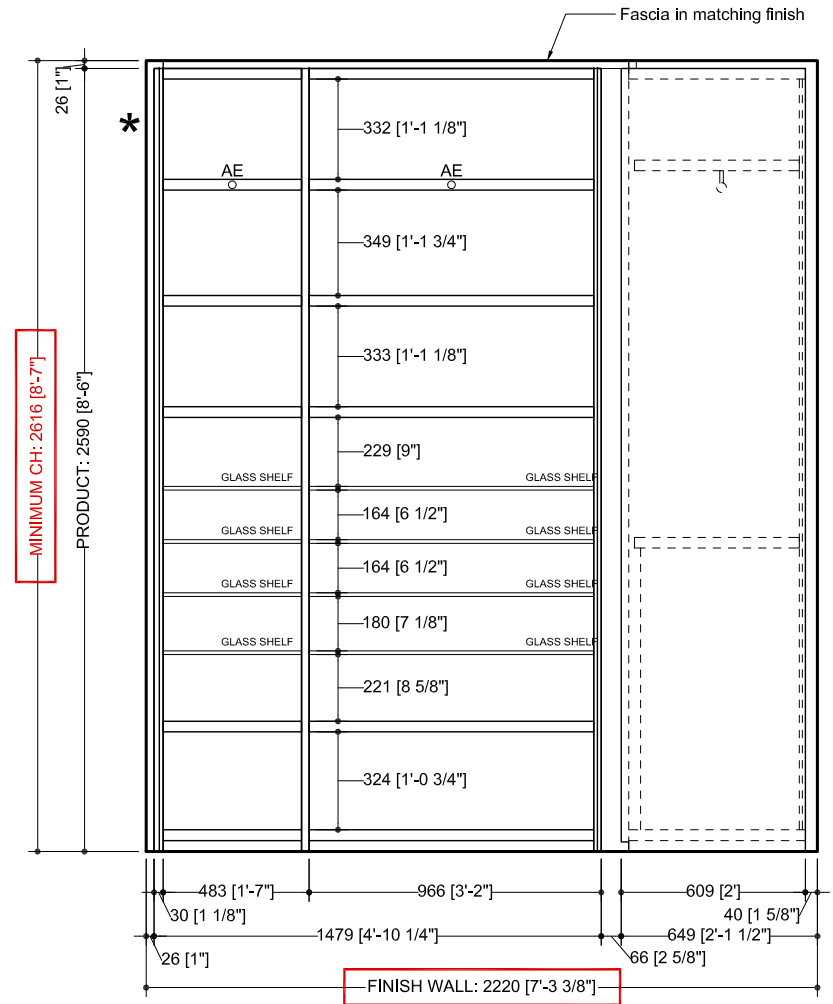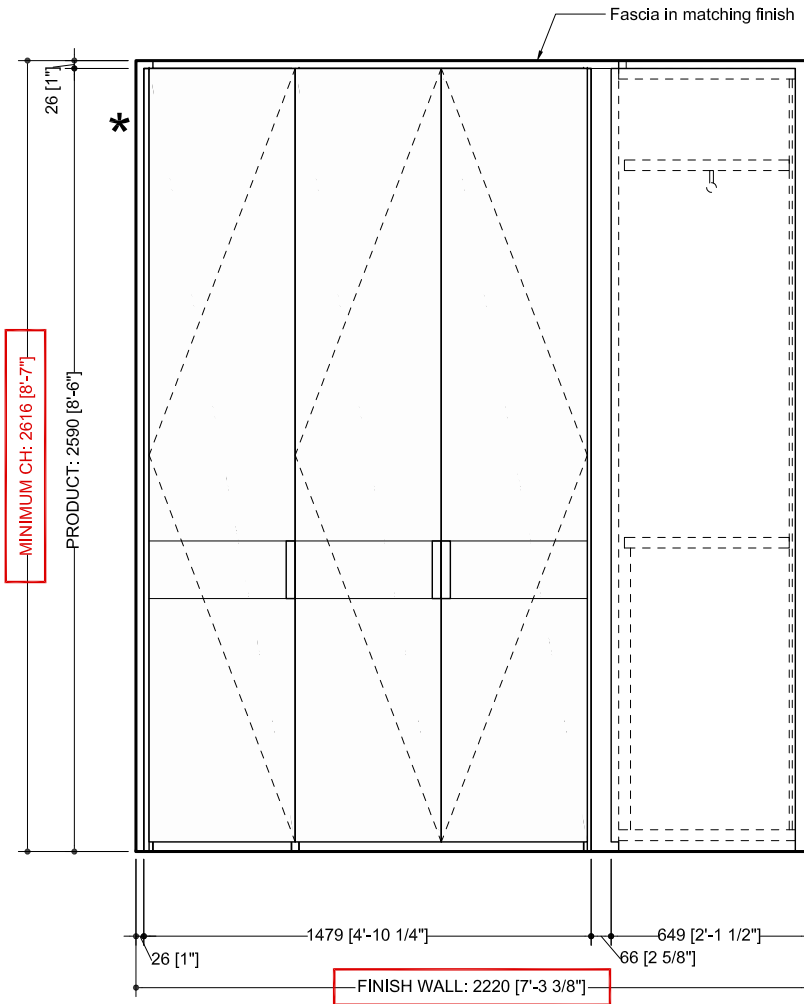

MASTER CLOSET

ELEVATION A



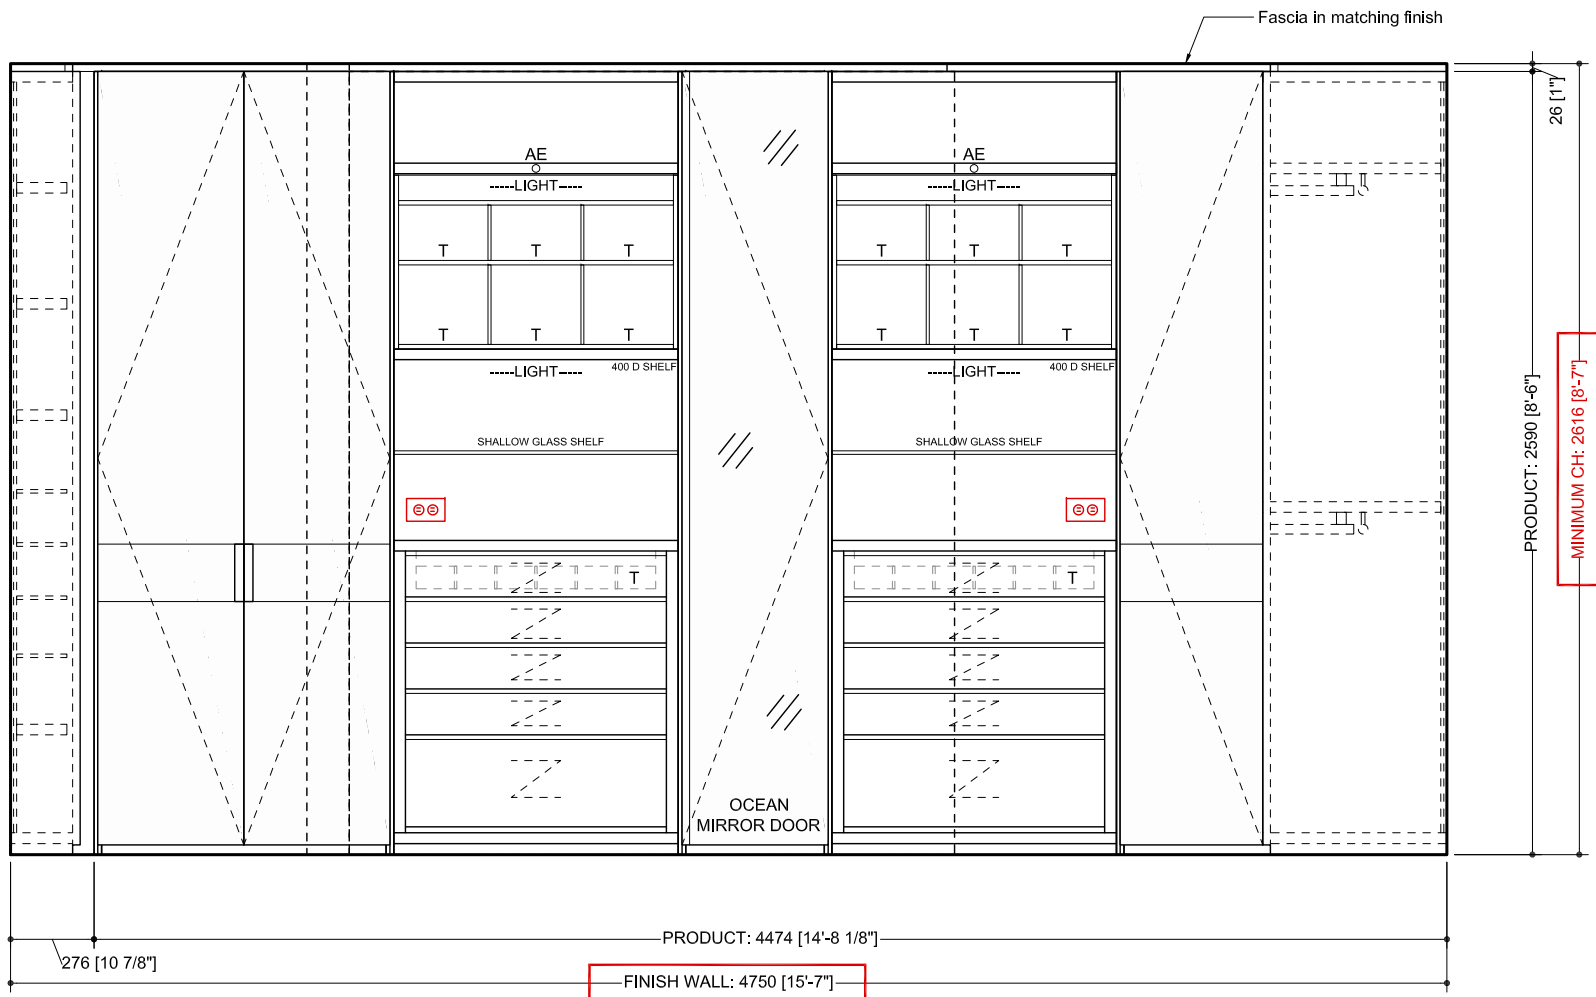

MASTER CLOSET


ELEVATION B

# ELECTRICAL NOTES

N1: New switched elec. outlets at ceiling, provide "remodel" J BOX elec. outlet with min. 5' slack. These are for LED, low voltage non-dimable, plug and play lights with integrated Poliform transformers. Switch location to be determined by client / architect.

N2: New convenience elec. outlets at dimensioned heights. Provide "remodel" J BOX elec. outlet with min. 5' slack; to be trimmed upon cabinetry install. Position of in-cabinetry convenience elec. outlets is approximate.

N3: New elec. outlets height at ceiling. These are for LED, low voltage non-dimable, plug and play lights with integrated Poliform transformers, controlled by a motion sensor.

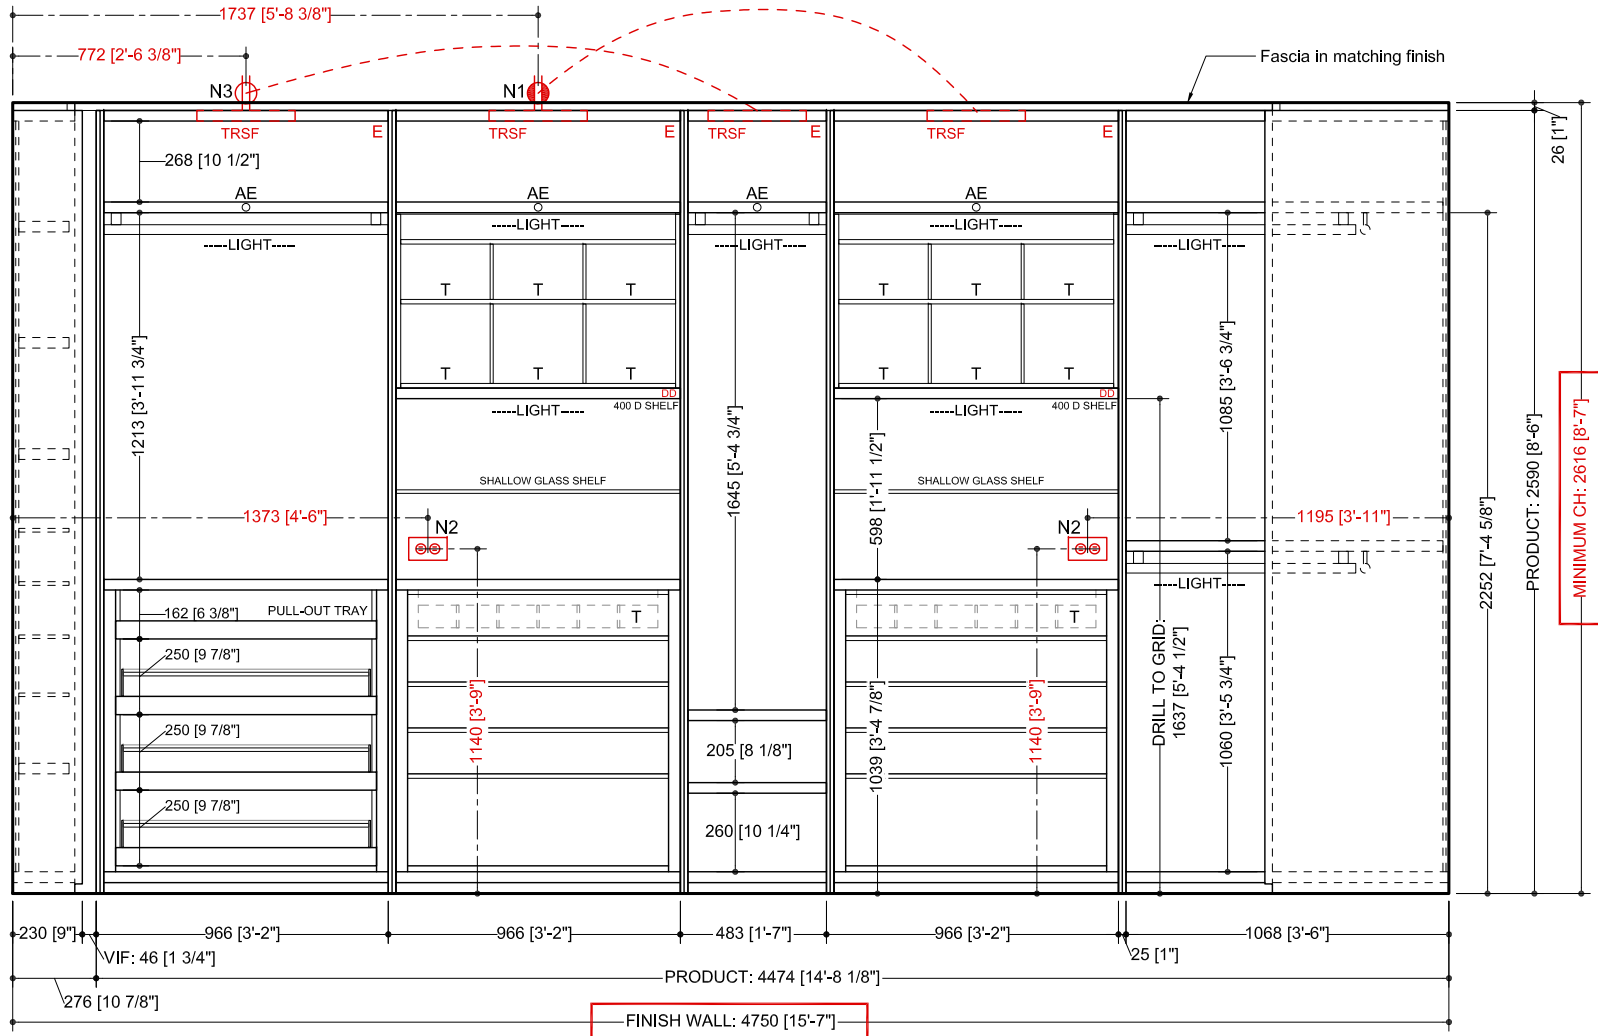

MASTER CLOSET

ELEVATION B - INSIDE



Poliform | sagartstudio  
 2611 P St NW  
 Washington, DC 20007  
 202.554.8658  
 www.poliformdc.com

Client: HERTRICH Residence  
 Street: 1908-09 Continuum South  
 City: Miami State: FL

Date: 2022.03.30  
 Scale: 1:25  
 Drawn by: SKP

Page:

# ELECTRICAL NOTES



N1: New switched elec. outlets at ceiling, provide "remodel" J BOX elec. outlet with min. 5' slack. These are for LED, low voltage non-dimable, plug and play lights with integrated Poliform transformers. Switch location to be determined by client / architect.

N2: New convenience elec. outlets at dimensioned heights. Provide "remodel" J BOX elec. outlet with min. 5' slack; to be trimmed upon cabinetry install. Position of in-cabinetry convenience elec. outlets is approximate.

N3: New elec. outlets height at ceiling. These are for LED, low voltage non-dimable, plug and play lights with integrated Poliform transformers, controlled by a motion sensor.

INSIDE

\* = LATERAL SIDE IN FINISH MATCHING CABINET DOOR

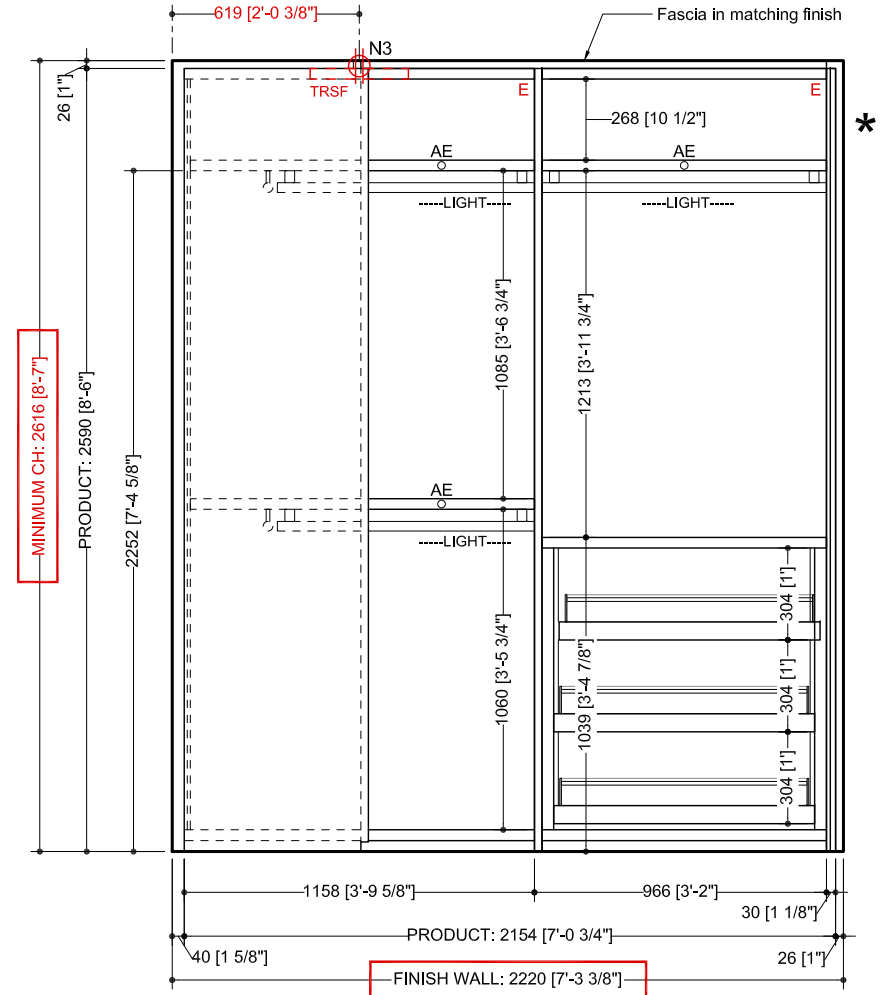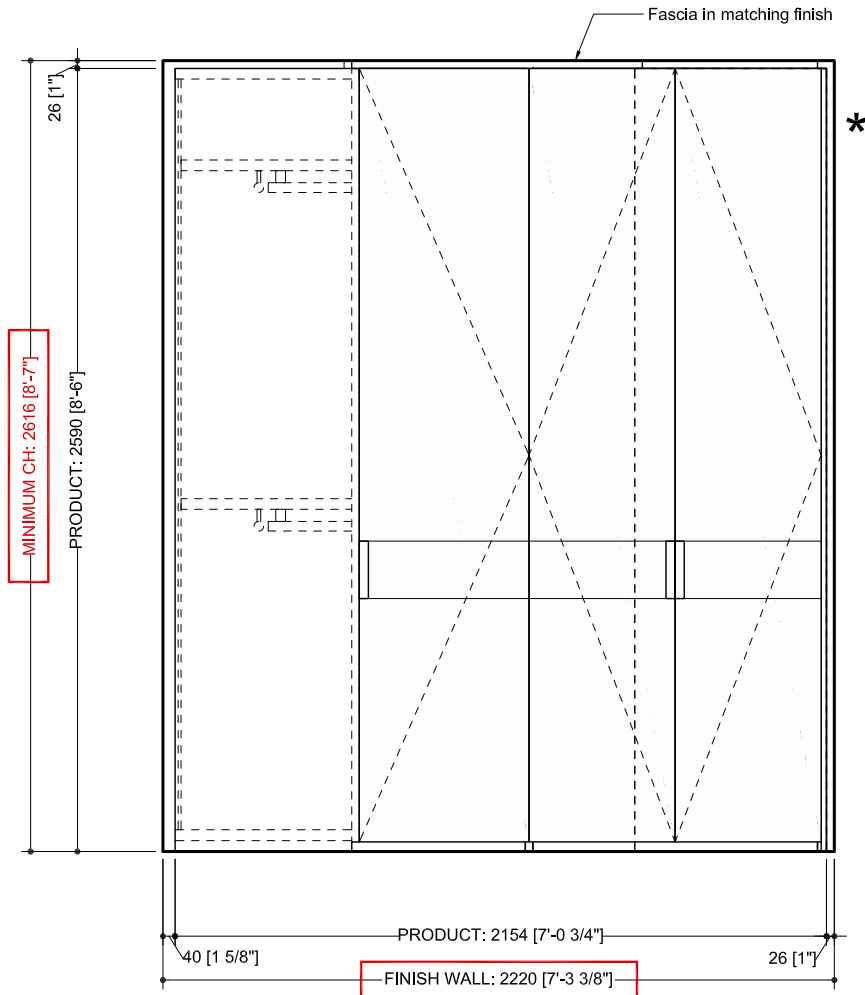

MASTER CLOSET

ELEVATION C



Poliform | sagartstudio  
 2611 P St NW  
 Washington, DC 20007  
 202.554.8658  
 www.poliformdc.com

Client: HERTRICH Residence

Date: 2022.03.30

Street: 1908-09 Continuum South

Scale: 1:25


City: Miami State: FL

Drawn by: SKP

Page:

\* = LATERAL SIDE IN FINISH  
MATCHING CABINET DOOR

Fascia in matching finish

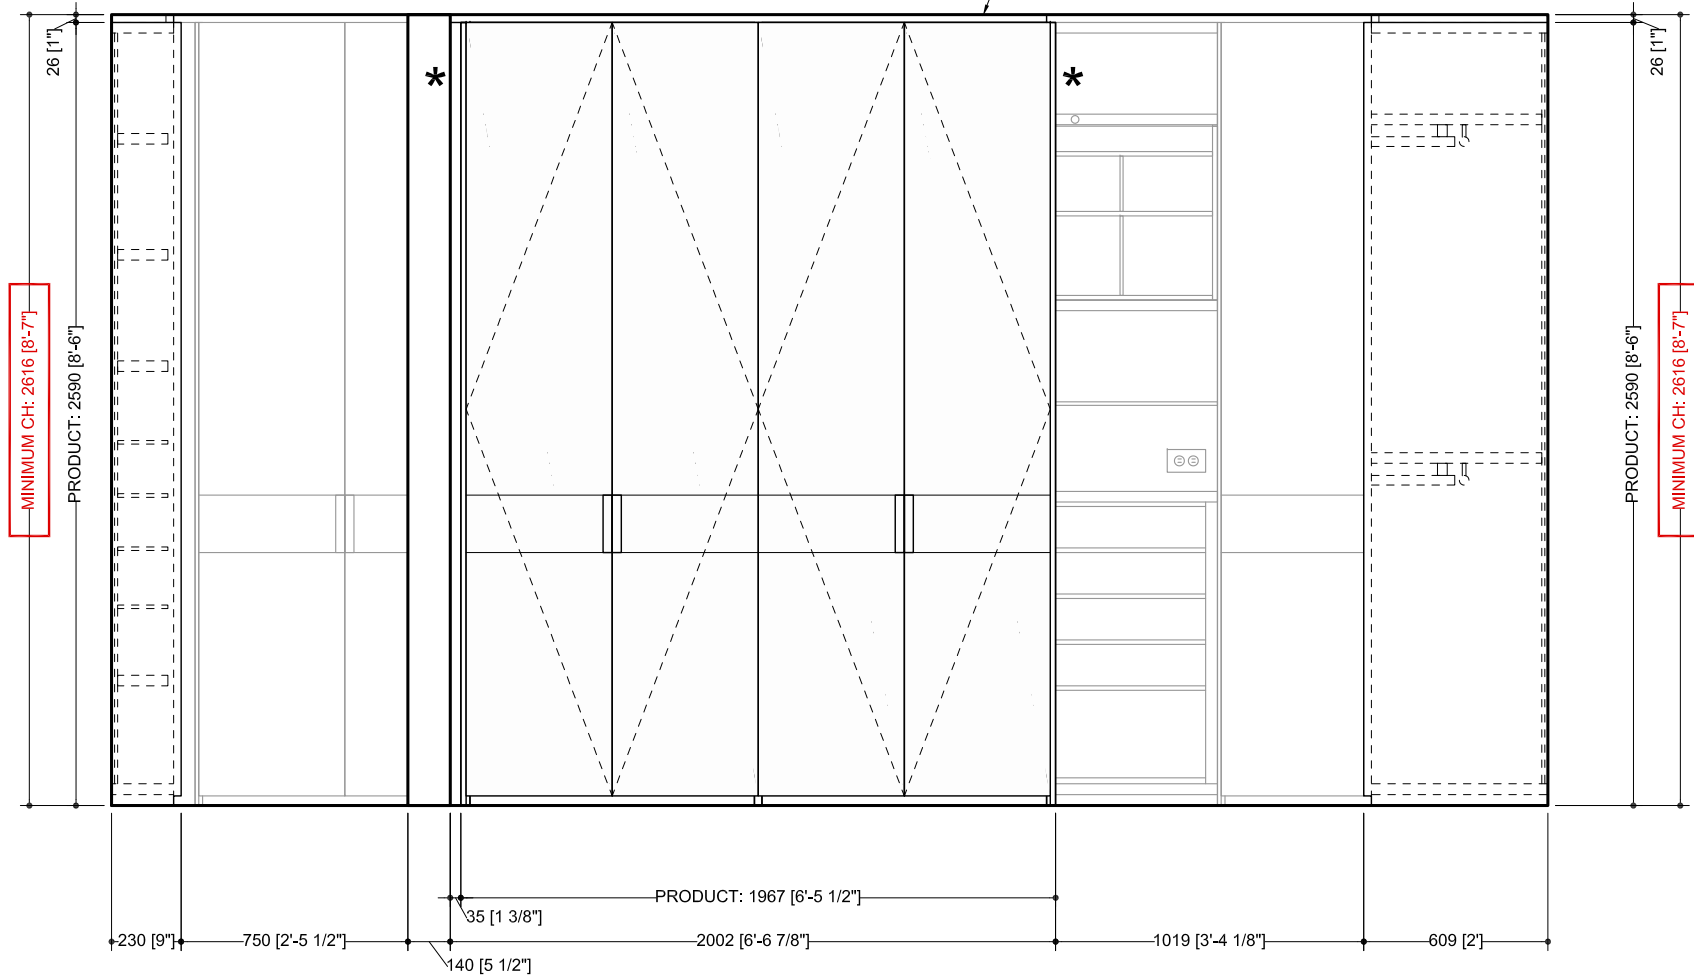

MASTER CLOSET

ELEVATION D & E

**Poliform**

Poliform | sagartstudio  
2611 P St NW  
Washington, DC 20007  
202.554.8658  
www.poliformdc.com

| Client: HERTRICH Residence

| Date: 2022.03.30

| Street: 1908-09 Continuum South

| Scale: 1:25

| City: Miami State: FL

| Drawn by: SKP

Page:


# ELECTRICAL NOTES

N1: New switched elec. outlets at ceiling, provide "remodel" J BOX elec. outlet with min. 5' slack. These are for LED, low voltage non-dimable, plug and play lights with integrated Poliform transformers. Switch location to be determined by client / architect.

N2: New convenience elec. outlets at dimensioned heights. Provide "remodel" J BOX elec. outlet with min. 5' slack; to be trimmed upon cabinetry install. Position of in-cabinetry convenience elec. outlets is approximate.

N3: New elec. outlets height at ceiling. These are for LED, low voltage non-dimable, plug and play lights with integrated Poliform transformers, controlled by a motion sensor.

\* = LATERAL SIDE IN FINISH MATCHING CABINET DOOR

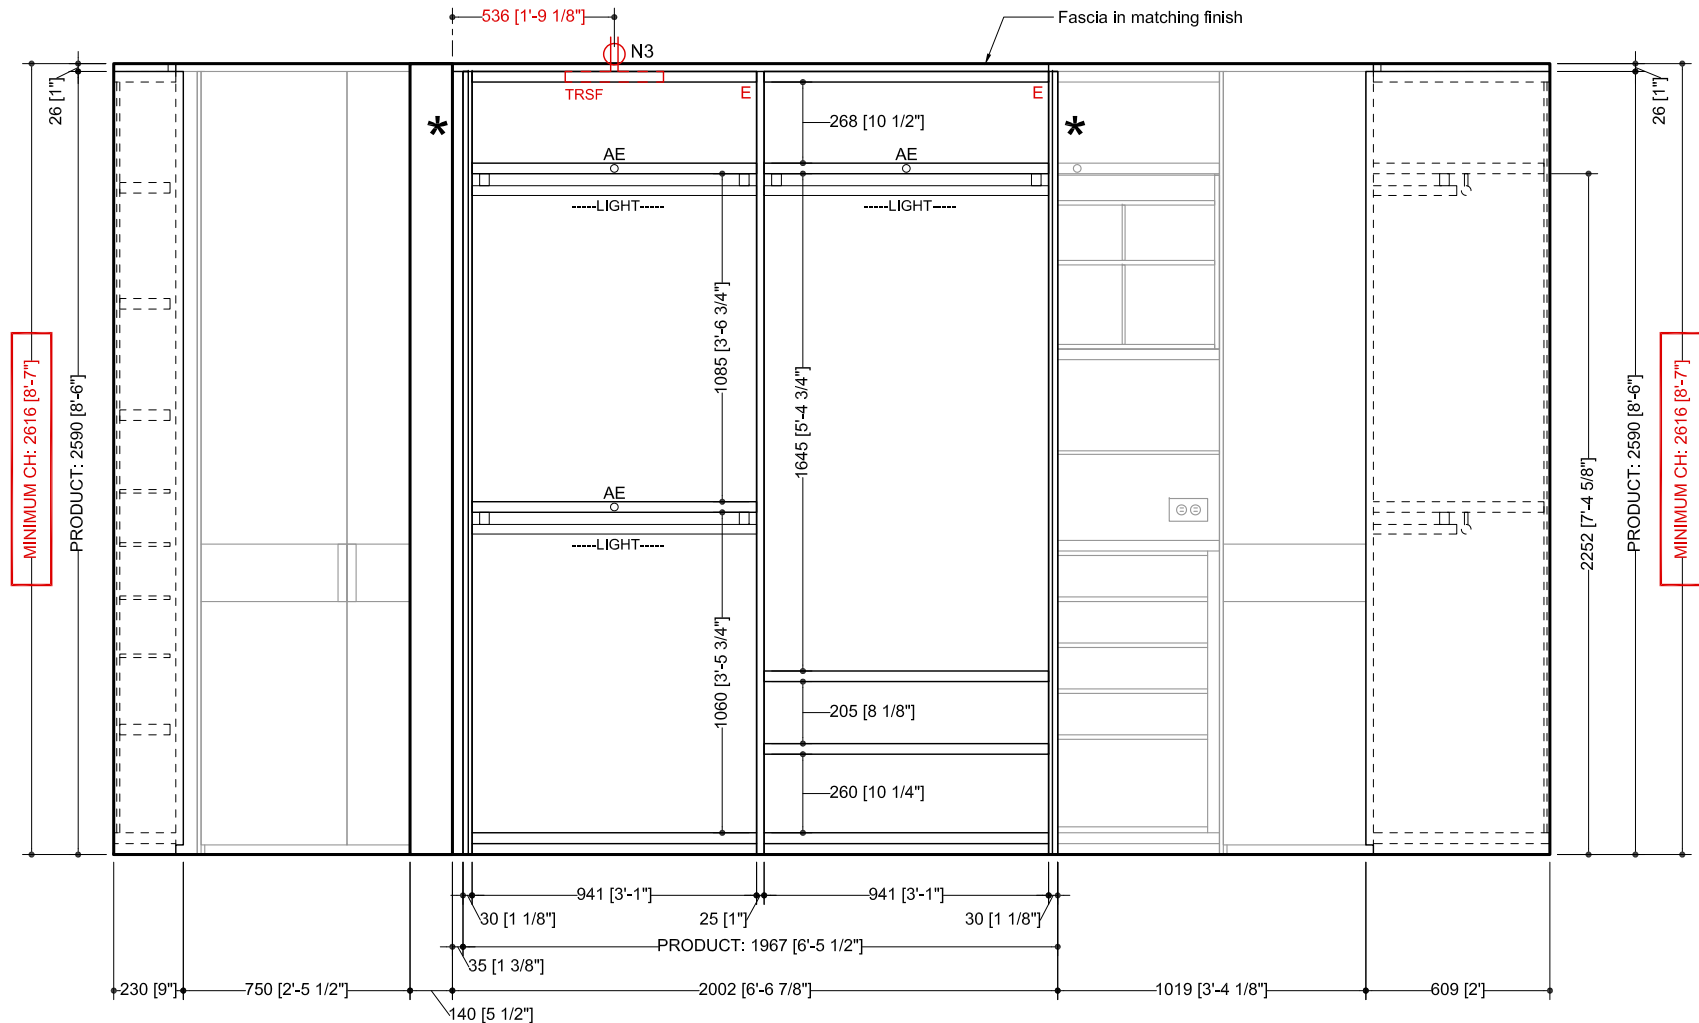

MASTER CLOSET

ELEVATION D - INSIDE



Poliform | sagartstudio  
 2611 P St NW  
 Washington, DC 20007  
 202.554.8658  
 www.poliformdc.com

Client: HERTRICH Residence

Date: 2022.03.30


Street: 1908-09 Continuum South

Scale: 1:25

City: Miami State: FL

Drawn by: SKP

Page:

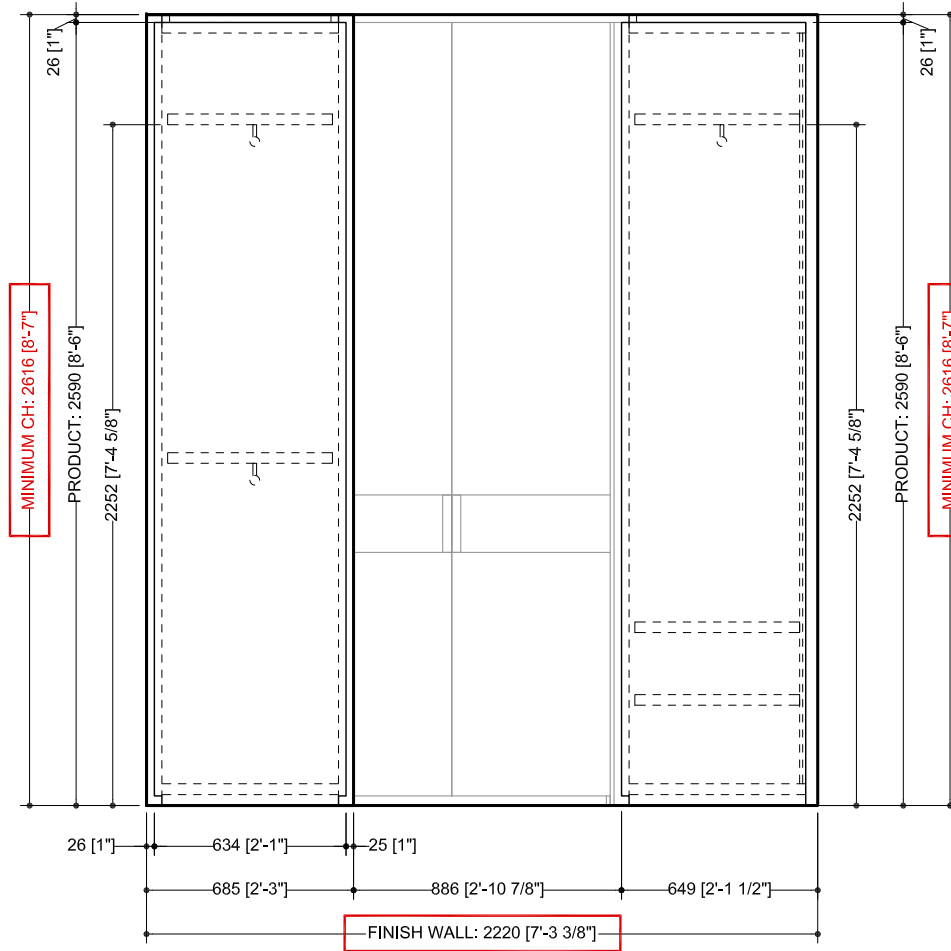

MASTER CLOSET  
ELEVATION F (SECTION)