

ST-1 NATURALI STONE, PIETRA CANICO

1 PLAN  
101.1 SCALE 1/2"=1'-0"

FOR CONSTRUCTION  
JULY 25, 2022

REVISIONS:  
MAY 20 UPDATE OF THE SCOPE OF RENOVATION, DELETE MILLWORK THAT WILL NOT BE CONSIDER  
JULY 22 MOVING KITCHEN ISLAND 4" TOWARDS THE WALL AND CHANGE BACKPLAS OF KITCHEN, CHANGE PANEL TO NEW HEIGHT

All site measurements must be verified by the contractor.  
Any substitutes in materials, finishes or otherwise specified items are not acceptable without written approval of the designer.  
This document and all associated documents are prepared for a specific site and event, and incorporate calculations and measurements available from the client at the time of drafting.  
The contents of this document are not to be reproduced or copied in whole or part without the written permission of Fleur-de-Lis Interior Design Inc.  
It is the responsibility of the contractor to build in compliance to and abide by all pertainable building codes.  
Copyright © 2015

 



Fleur-de-lis  
interior design inc.  
294 Eglinton Ave W  
Toronto, ON M4R 1B2  
Voice: (416) 929-8599  
Fax: (416) 929.8535  
www.fleurdelis.ca  
consults@fleurdelis.ca


PROJECT NAME:  
50 SOUTH POINT DRIVE, UNIT #613  
SHEET TITLE:  
KITCHEN / LIVING ROOM PLAN  
SCALE:  
1/2"=1'-0"  
LAST DRAWN  
JUNE 10, 2022

101.1  
ID

DRAWN BY:  
PM

 - LEGEND:
-  NEW BULK-HEAD TO 112" LEVEL
-  PANEL BELOW BULK-HEAD 97"
-  EXISTING BULK-HEAD


-  WALL SWITCH, SINGLE
-  WALL SWITCH, DOUBLE
-  WALL SWITCH, TRIPLE
-  PENDANT LIGHT
-  LIGHTS TRACK
-  LIGHTS TRACK FOR ARTWORK
-  LED STRIP LIGHT

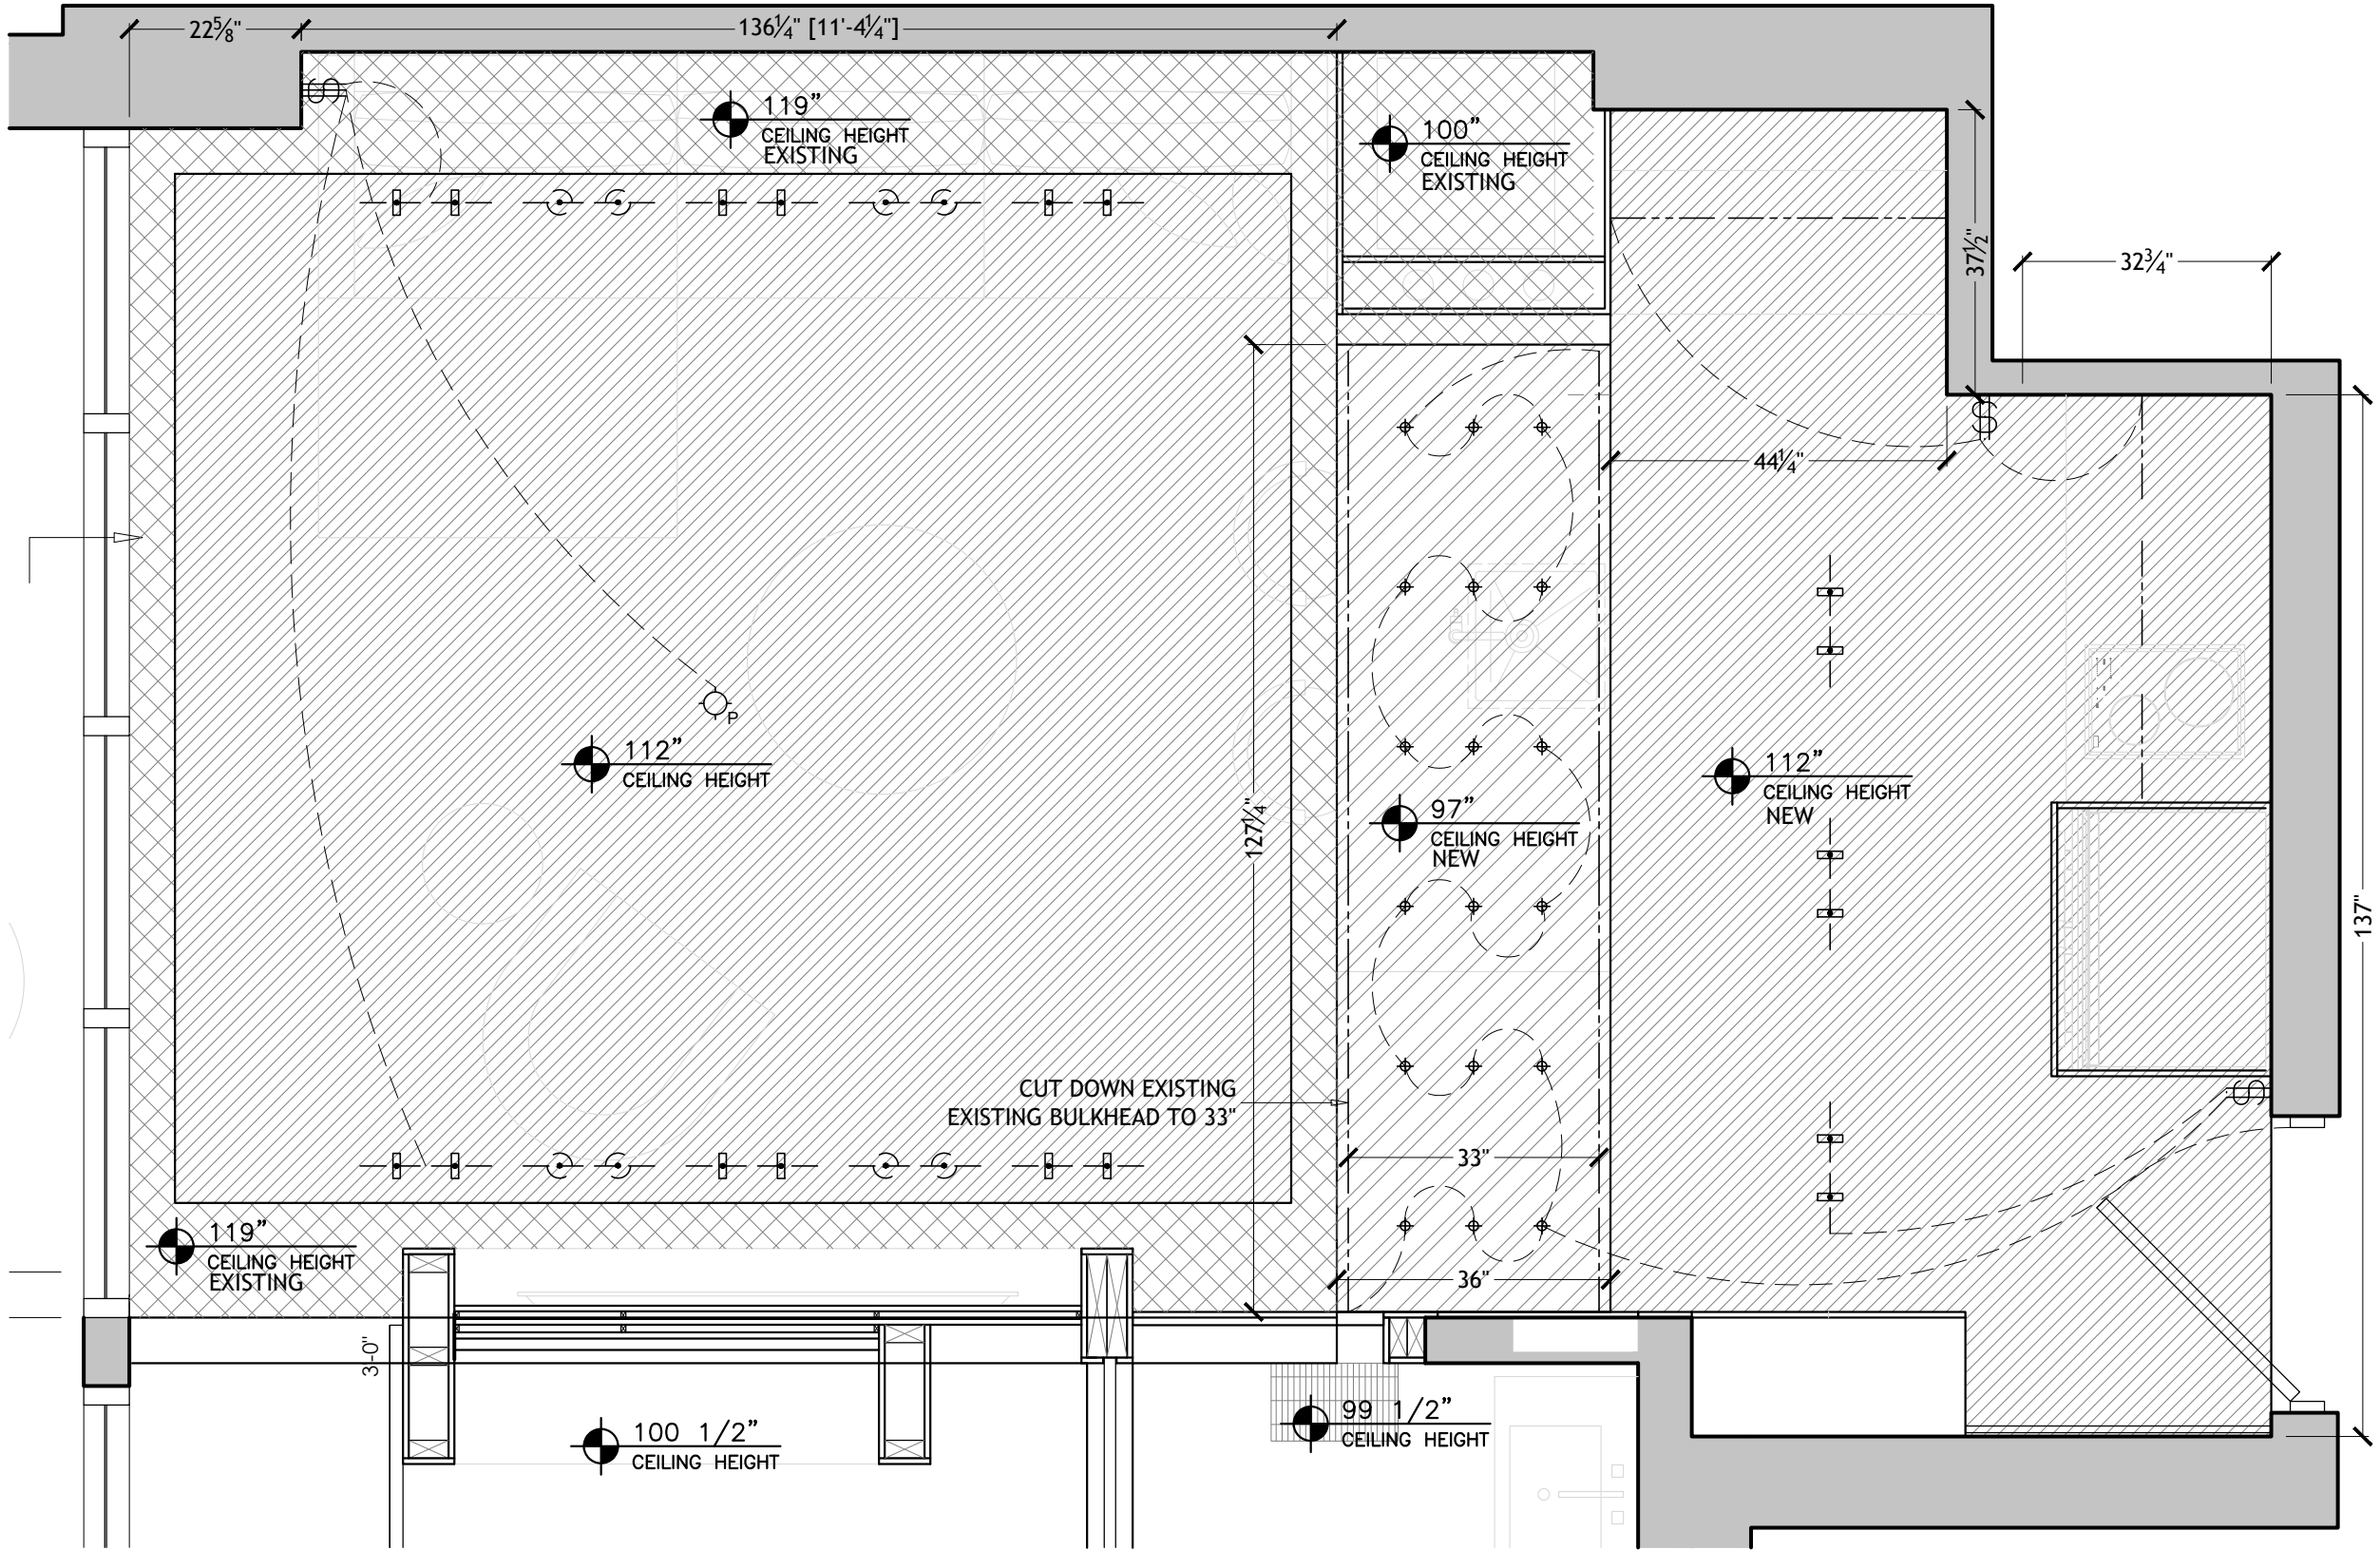

1 LIGHTING PLAN  
101.2 SCALE 1/2"=1'-0"

|                                                                                                                                   |                                                                   |                                                                                                                                                                                                                                                                                                                                                                                                                                                                                                                                                                                                                                                                                            |                                                                                                                                                                                                                                                                                          |                                                              |                 |
|-----------------------------------------------------------------------------------------------------------------------------------|-------------------------------------------------------------------|--------------------------------------------------------------------------------------------------------------------------------------------------------------------------------------------------------------------------------------------------------------------------------------------------------------------------------------------------------------------------------------------------------------------------------------------------------------------------------------------------------------------------------------------------------------------------------------------------------------------------------------------------------------------------------------------|------------------------------------------------------------------------------------------------------------------------------------------------------------------------------------------------------------------------------------------------------------------------------------------|--------------------------------------------------------------|-----------------|
|  <div>FOR CONSTRUCTION<br/>JULY 25, 2022</div> | REVISIONS:<br>JULY 21 CEILING DROPS 7" IN LIVING ROOM AND KITCHEN | All site measurements must be verified by the contractor.<br>Any substitutes in materials, finishes or otherwise specified items are not acceptable without written approval of the designer.<br>This document and all associated documents are prepared for a specific site and event, and incorporate calculations and measurements available from the client at the time of drafting.<br>The contents of this document are not to be reproduced or copied in whole or part without the written permission of Fleur-de-Lis Interior Design Inc.<br>It is the responsibility of the contractor to build in compliance to and abide by all pertainable building codes.<br>Copyright © 2015 |  <div>Fleur-de-lis<br/>interior design inc.<br/>294 Eglinton Ave W<br/>Toronto, ON M4R 1B2<br/>Voice: (416) 929-8599<br/>Fax: (416) 929-8535<br/>www.fleurdelis.ca<br/>consults@fleurdelis.ca</div> | PROJECT NAME:<br>50 SOUTH POINT DRIVE, UNIT #613             | 101.2<br>ID     |
|                                                                                                                                   |                                                                   |                                                                                                                                                                                                                                                                                                                                                                                                                                                                                                                                                                                                                                                                                            |                                                                                                                                                                                                                                                                                          | SHEET TITLE:<br>KITCHEN / LIVING ROOM<br>RCP & LIGHTING PLAN |                 |
|                                                                                                                                   |                                                                   |                                                                                                                                                                                                                                                                                                                                                                                                                                                                                                                                                                                                                                                                                            |                                                                                                                                                                                                                                                                                          | SCALE:<br>1/2"=1'-0"                                         | DRAWN BY:<br>PM |


- LEGEND - ELECTRICAL
- DUPLEX RECEPTACLE
  - THERMOSTAT

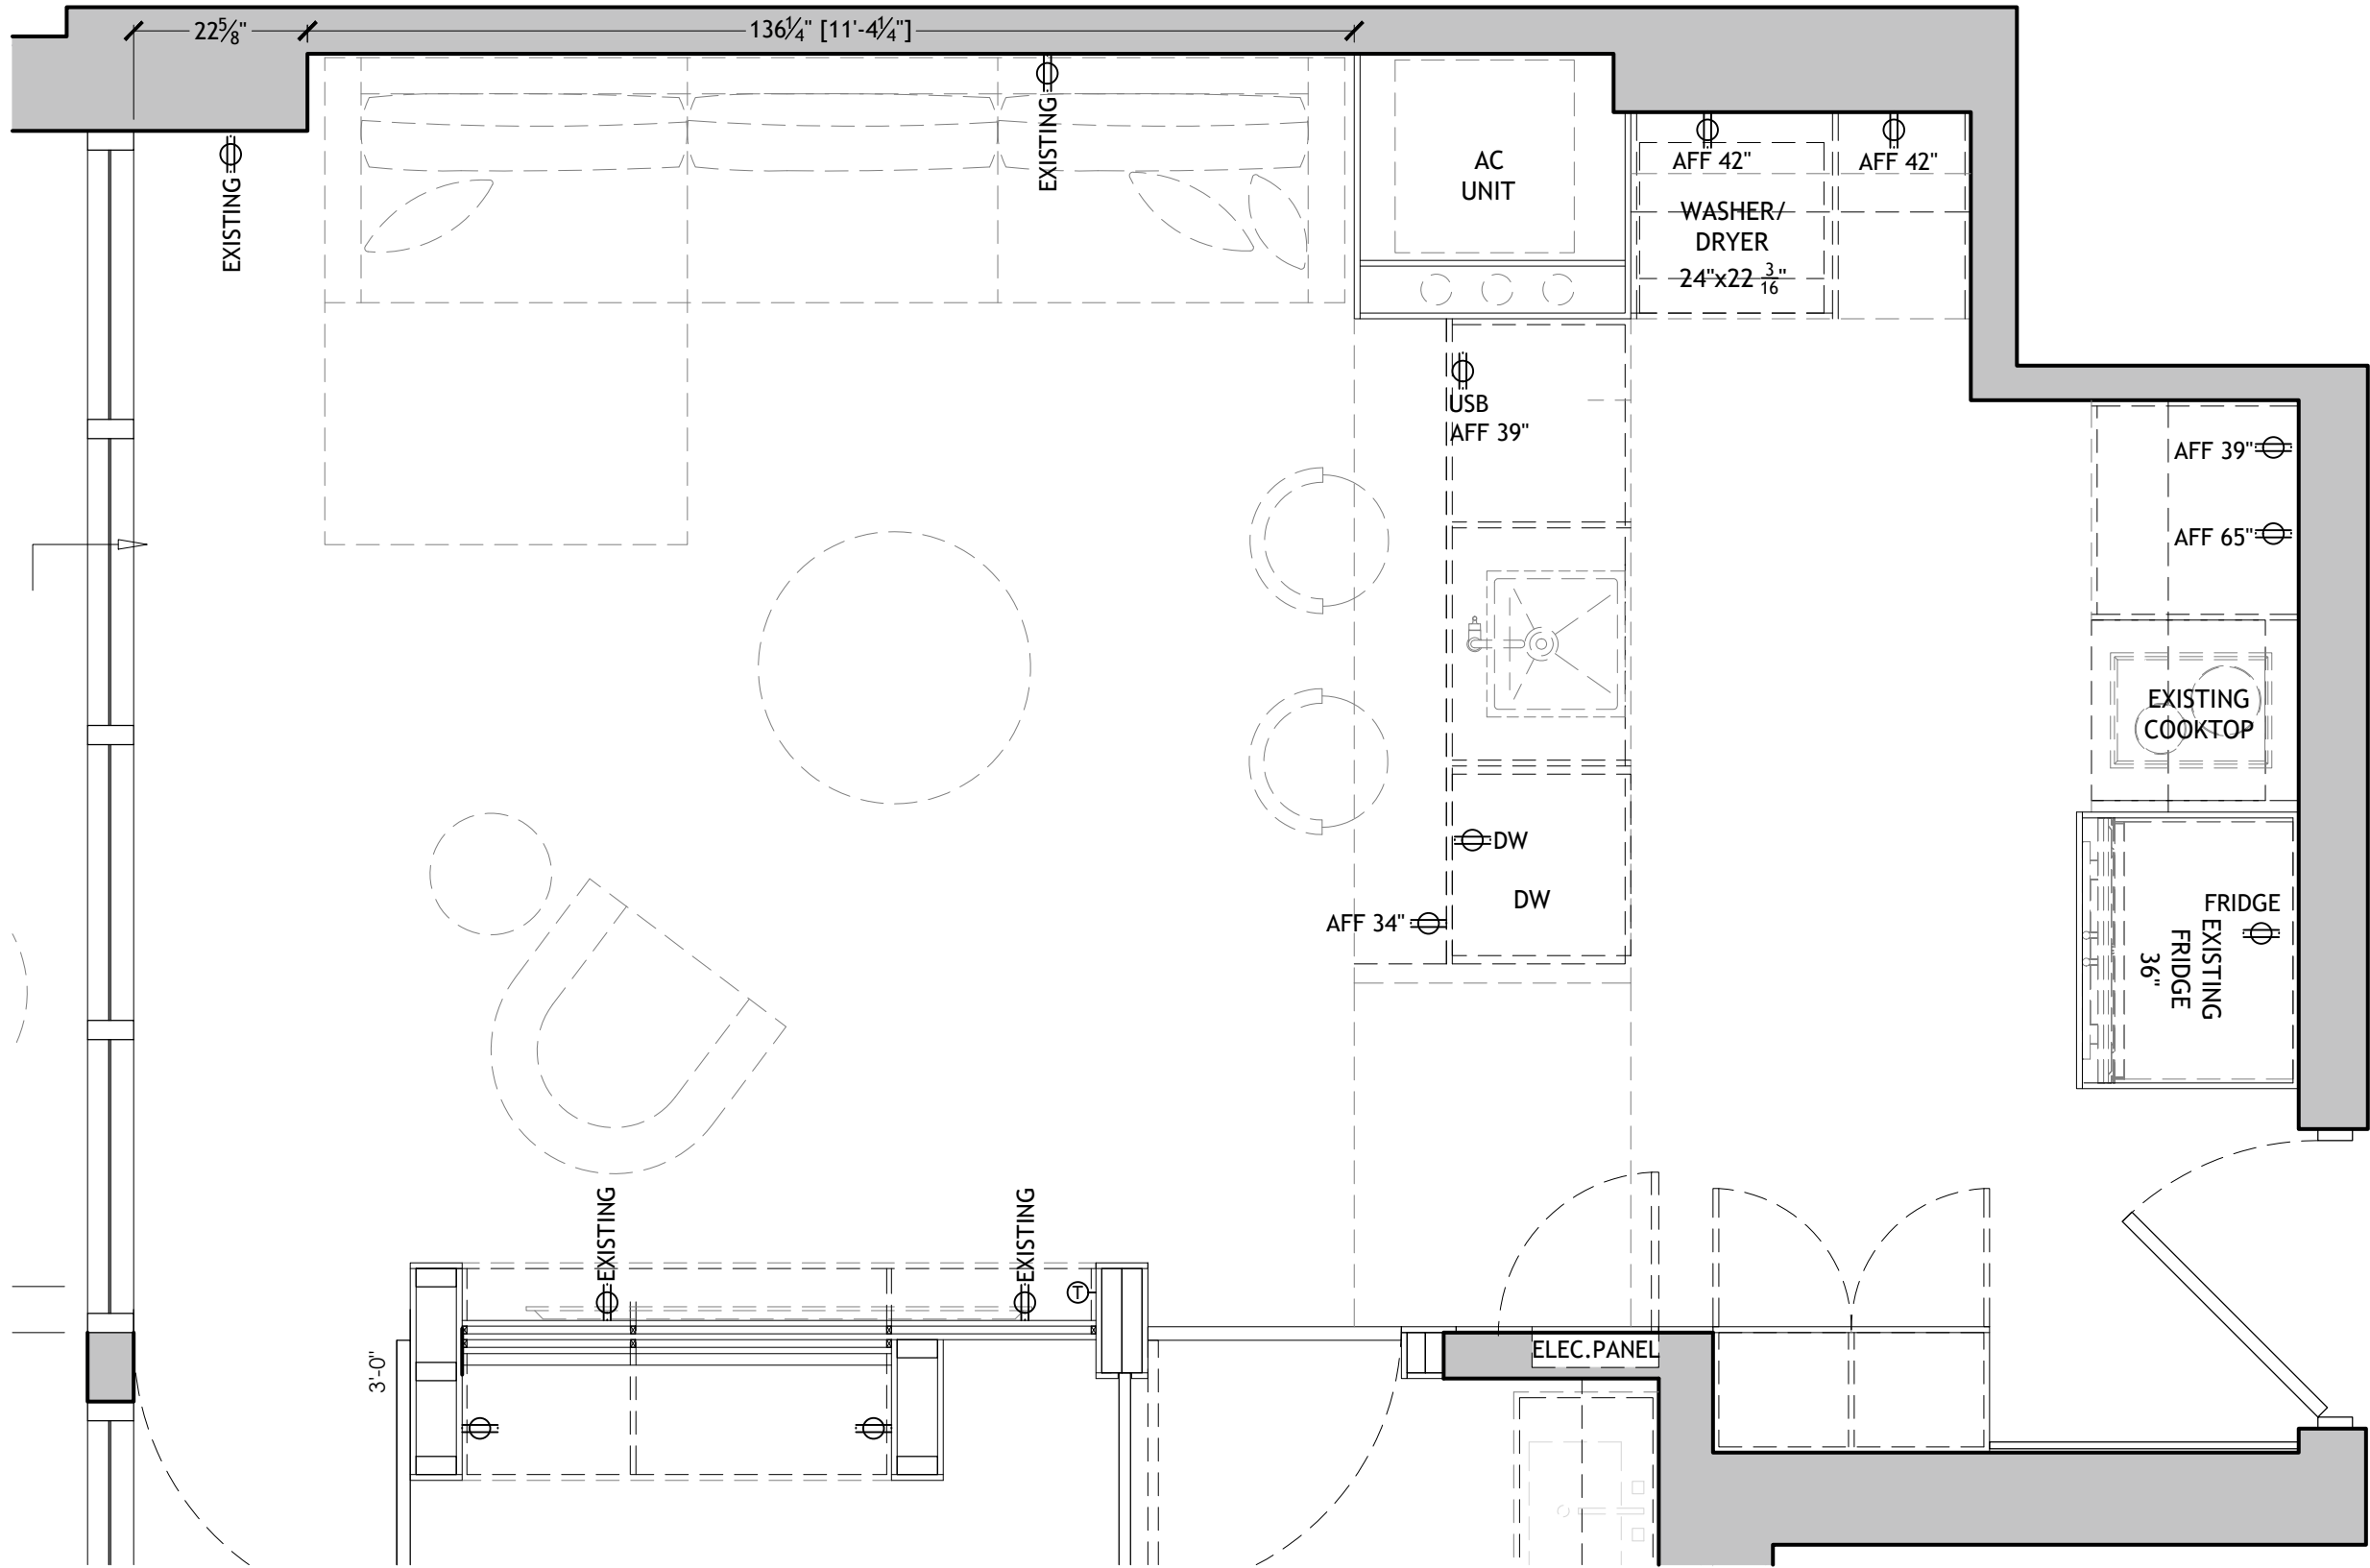

1 PLAN  
101 SCALE 1/2"=1'-0"

|                                                                                                                                                     |            |                                                                                                                                                                                                                                                                                                                                                                                                                                                                                                                                                                                                                                                                                                         |                                                                                                                                                                                                                                                                                                                          |                                                                  |                               |
|-----------------------------------------------------------------------------------------------------------------------------------------------------|------------|---------------------------------------------------------------------------------------------------------------------------------------------------------------------------------------------------------------------------------------------------------------------------------------------------------------------------------------------------------------------------------------------------------------------------------------------------------------------------------------------------------------------------------------------------------------------------------------------------------------------------------------------------------------------------------------------------------|--------------------------------------------------------------------------------------------------------------------------------------------------------------------------------------------------------------------------------------------------------------------------------------------------------------------------|------------------------------------------------------------------|-------------------------------|
| <div></div> <div>FOR CONSTRUCTION</div> <div>JULY 25, 2022</div> | REVISIONS: | <p>All site measurements must be verified by the contractor.<br/>Any substitutes in materials, finishes or otherwise specified items are not acceptable without written approval of the designer.<br/>This document and all associated documents are prepared for a specific site and event, and incorporate calculations and measurements available from the client at the time of drafting.<br/>The contents of this document are not to be reproduced or copied in whole or part without the written permission of Fleur-de-Lis Interior Design Inc.<br/>It is the responsibility of the contractor to build in compliance to and abide by all perttainable building codes.<br/>Copyright © 2015</p> | <div></div> <div><b>Fleur-de-lis</b><br/>interior design inc.</div> <div>294 Eglinton Ave W<br/>Toronto, ON M4R 1B2</div> <div>Voice: (416) 929-8599<br/>Fax: (416) 929.8535<br/>www.fleurdelis.ca<br/>consults@fleurdelis.ca</div> | PROJECT NAME:<br><b>50 SOUTH POINT DRIVE, UNIT #613</b>          | <b>101.3</b><br><br><b>ID</b> |
|                                                                                                                                                     |            |                                                                                                                                                                                                                                                                                                                                                                                                                                                                                                                                                                                                                                                                                                         |                                                                                                                                                                                                                                                                                                                          | SHEET TITLE:<br><b>KITCHEN / LIVING ROOM<br/>ELECTRICAL PLAN</b> |                               |
|                                                                                                                                                     |            |                                                                                                                                                                                                                                                                                                                                                                                                                                                                                                                                                                                                                                                                                                         |                                                                                                                                                                                                                                                                                                                          | SCALE:<br>1/2"=1'-0"                                             | LAST DRAWN<br>MAY 24, 2022    |



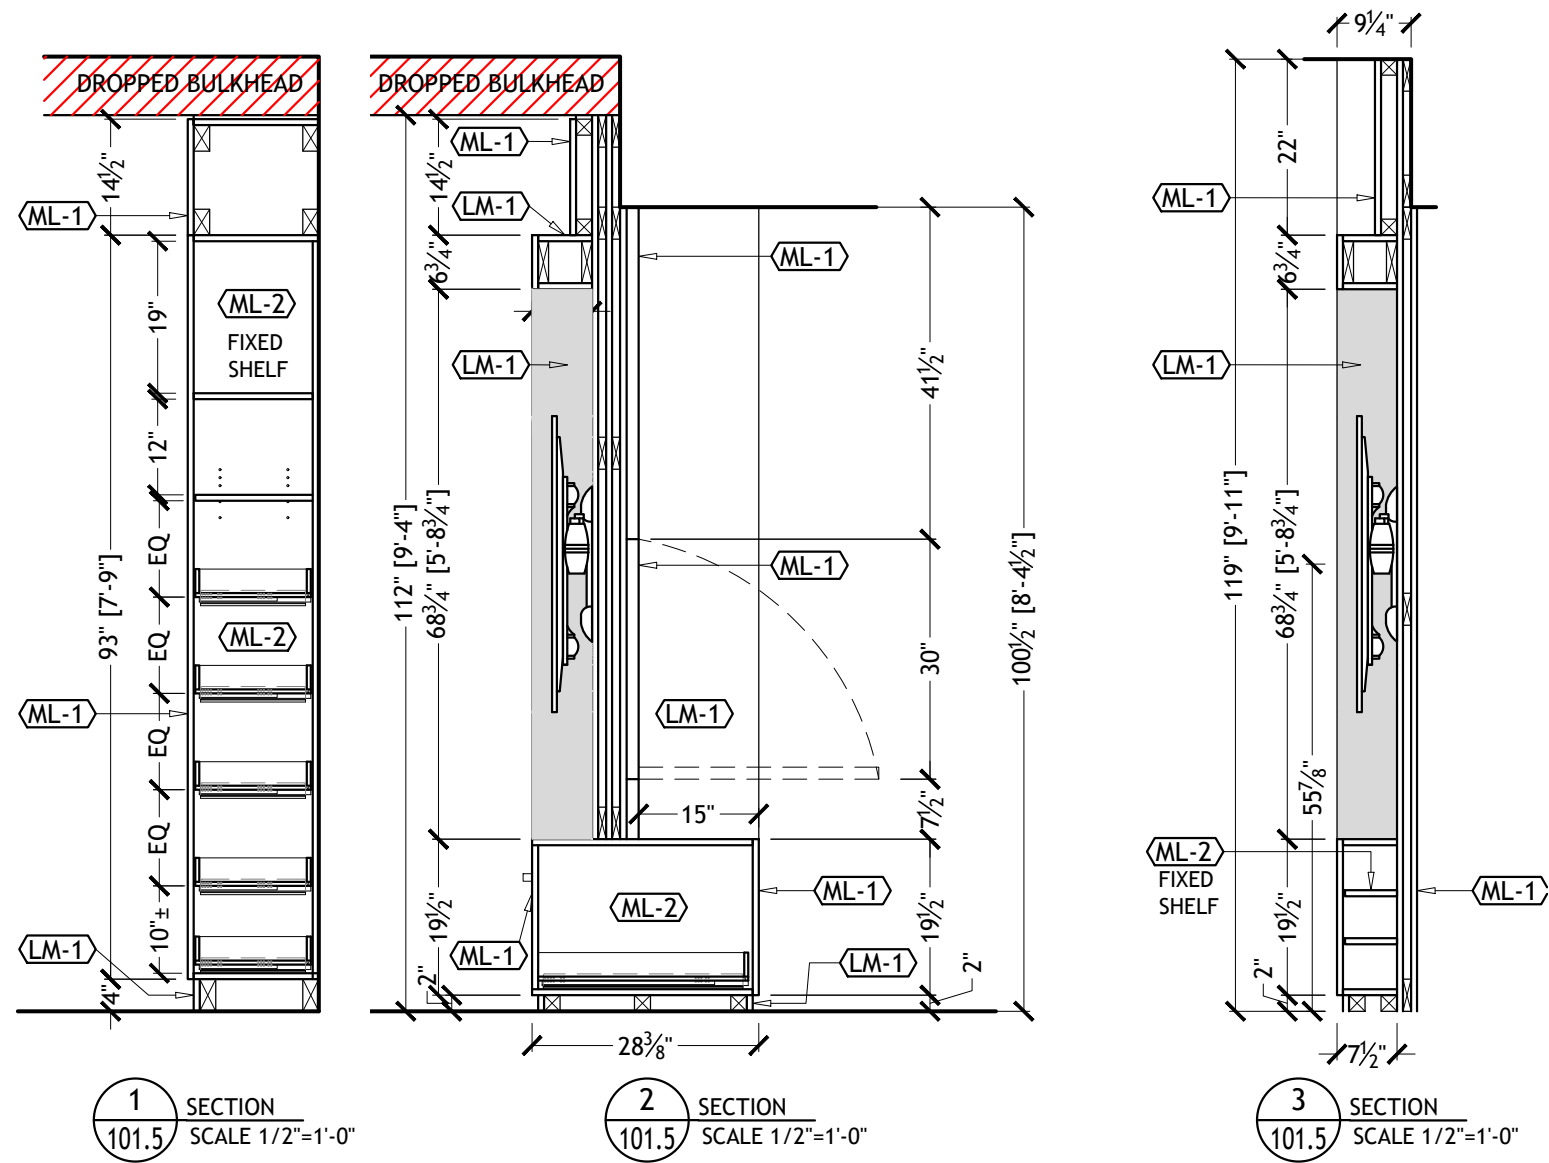

- ML-1** UNIBOARD, K62 FEATHER WHITE, NOBELLA FINISH
- LM-1** OCTOLUX #15-STAINLESS STEEL ALUMINUM
- ML-1** UNIBOARD K62 FEATHER WHITE, NOBELLA FINISH

|                                                                           |            |                                                                                                                                                                                                                                                                                                                                                                                                                                                                                                                                                                                                                                                                                                                       |                                                                                                                                                                                                                                                           |                      |  |                                 |             |
|---------------------------------------------------------------------------|------------|-----------------------------------------------------------------------------------------------------------------------------------------------------------------------------------------------------------------------------------------------------------------------------------------------------------------------------------------------------------------------------------------------------------------------------------------------------------------------------------------------------------------------------------------------------------------------------------------------------------------------------------------------------------------------------------------------------------------------|-----------------------------------------------------------------------------------------------------------------------------------------------------------------------------------------------------------------------------------------------------------|----------------------|--|---------------------------------|-------------|
| <div><div></div><div>FOR CONSTRUCTION</div><div>JULY 25, 2022</div></div> | REVISIONS: | <p>All site measurements must be verified by the contractor.</p> <p>Any substitutes in materials, finishes or otherwise specified items are not acceptable without written approval of the designer.</p> <p>This document and all associated documents are prepared for a specific site and event, and incorporate calculations and measurements available from the client at the time of drafting.</p> <p>The contents of this document are not to be reproduced or copied in whole or part without the written permission of Fleur-de-Lis Interior Design Inc.</p> <p>It is the responsibility of the contractor to build in compliance to and abide by all pertainable building codes.</p> <p>Copyright © 2015</p> | <div><div>Fleur-de-lis</div><div>interior design inc.</div><div>294 Eglinton Ave W</div><div>Toronto, ON M4R 1B2</div><div>Voice: (416) 929-8599</div><div>Fax: (416) 929.8535</div><div>www.fleurdellis.ca</div><div>consults@fleurdellis.ca</div></div> | PROJECT NAME:        |  | 50 SOUTH POINT DRIVE, UNIT #613 | 101.5<br>ID |
|                                                                           |            |                                                                                                                                                                                                                                                                                                                                                                                                                                                                                                                                                                                                                                                                                                                       |                                                                                                                                                                                                                                                           | SHEET TITLE:         |  |                                 |             |
|                                                                           |            |                                                                                                                                                                                                                                                                                                                                                                                                                                                                                                                                                                                                                                                                                                                       |                                                                                                                                                                                                                                                           | KITCHEN ELEVATIONS   |  |                                 |             |
|                                                                           |            |                                                                                                                                                                                                                                                                                                                                                                                                                                                                                                                                                                                                                                                                                                                       |                                                                                                                                                                                                                                                           | SCALE:<br>1/2"=1'-0" |  | LAST DRAWN<br>MAY 6, 2022       |             |



AVENTOS Lift Mechanism HL


Because AVENTOS HL opens parallel to the cabinet, it can be used in wall cabinets or in the upper half of tall units. In between, it can be adapted to conceal small appliances.

\*\* Please consult product information to choose the right mechanism for the height and weight of your door.

Product № 20L2700N5


Door Height 300 to 580 mm

Capacity 4.25 to 20 kg

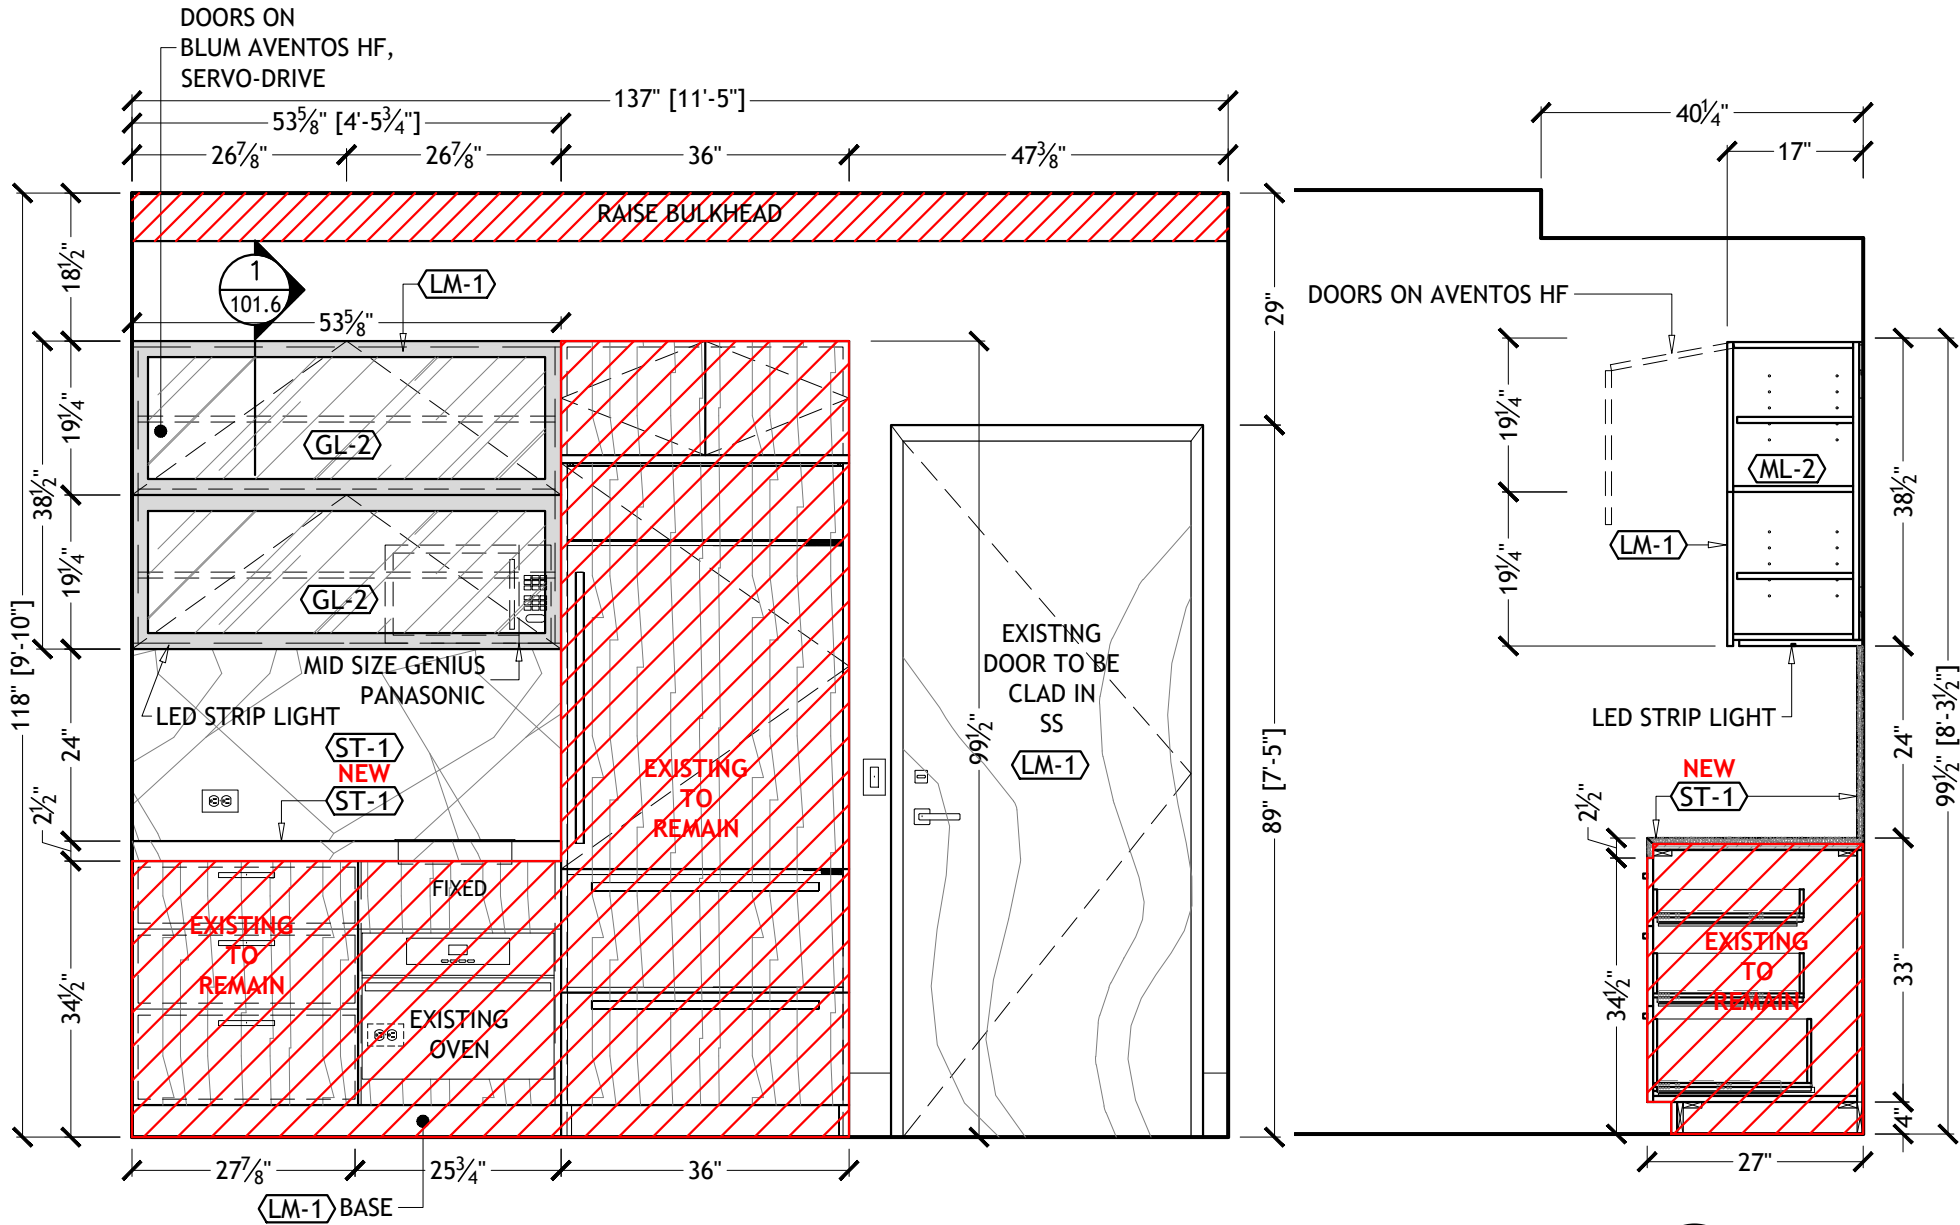



2 ELEVATION  
101.6 SCALE 1/2"=1'-0"

1 SECTION  
101.6 SCALE 1/2"=1'-0"

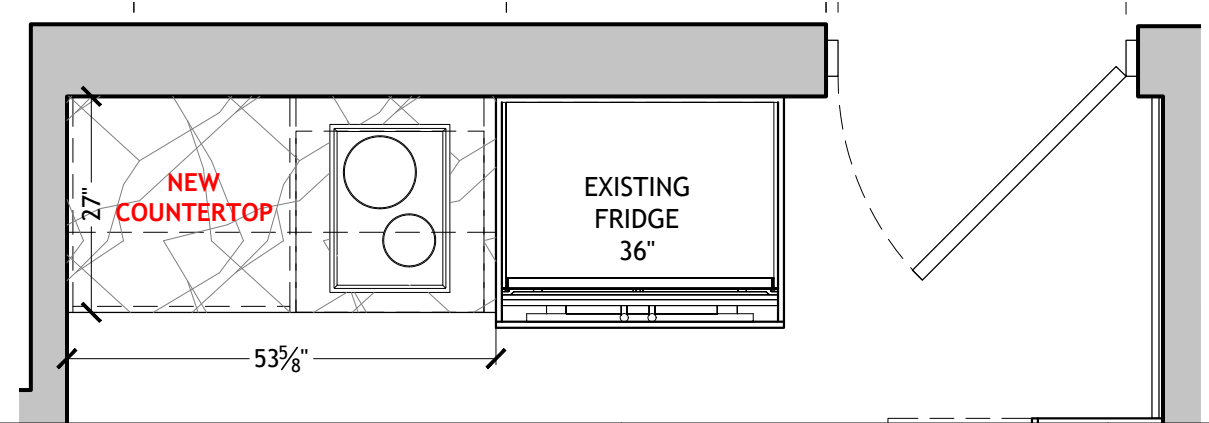

- (ST-1) NATURALI STONE, PIETRA CANICO
- (LM-1) OCTOLUX #15-STAINLESS STEEL ALUMINUM
- (ML-1) UNIBOARD K62 FEATHER WHITE, NOBELLA FINISH
- (ML-2) UNIBOARD 123, CHARCOAL (INTERIOR)
- (GL-2) GLASS WITH FROSTED FILM

|                                                      |                                                                                          |                                                                                                                                                                                                                                                                                                                                                                                                                                                                                                                                                                                                                                                                                                                                               |                                                                                                                                                                                                                                                                                                                   |               |                                 |            |
|------------------------------------------------------|------------------------------------------------------------------------------------------|-----------------------------------------------------------------------------------------------------------------------------------------------------------------------------------------------------------------------------------------------------------------------------------------------------------------------------------------------------------------------------------------------------------------------------------------------------------------------------------------------------------------------------------------------------------------------------------------------------------------------------------------------------------------------------------------------------------------------------------------------|-------------------------------------------------------------------------------------------------------------------------------------------------------------------------------------------------------------------------------------------------------------------------------------------------------------------|---------------|---------------------------------|------------|
| <div>FOR CONSTRUCTION</div> <div>JULY 25, 2022</div> | <div>REVISIONS:</div> <div>MAY 24 ONLY UPPER CABINETS AND COUNTER TOPS WILL BE NEW</div> | <div>All site measurements must be verified by the contractor.</div> <div>Any substitutes in materials, finishes or otherwise specified items are not acceptable without written approval of the designer.</div> <div>This document and all associated documents are prepared for a specific site and event, and incorporate calculations and measurements available from the client at the time of drafting.</div> <div>The contents of this document are not to be reproduced or copied in whole or part without the written permission of Fleur-de-Lis Interior Design Inc.</div> <div>It is the responsibility of the contractor to build in compliance to and abide by all pertainable building codes.</div> <div>Copyright © 2015</div> | <div></div> <div>Fleur-de-lis<br/>interior design inc.</div> <div>294 Eglinton Ave W<br/>Toronto, ON M4R 1B2</div> <div>Voice: (416) 929-8599<br/>Fax: (416) 929.8535<br/>www.fleurdelis.ca<br/>consults@fleurdelis.ca</div> | PROJECT NAME: | 50 SOUTH POINT DRIVE, UNIT #613 | 101.6      |
|                                                      |                                                                                          |                                                                                                                                                                                                                                                                                                                                                                                                                                                                                                                                                                                                                                                                                                                                               |                                                                                                                                                                                                                                                                                                                   | SHEET TITLE:  |                                 |            |
|                                                      |                                                                                          |                                                                                                                                                                                                                                                                                                                                                                                                                                                                                                                                                                                                                                                                                                                                               |                                                                                                                                                                                                                                                                                                                   | SCALE:        |                                 | LAST DRAWN |
| 1/2"=1'-0"                                           |                                                                                          | JUNE 10, 2022                                                                                                                                                                                                                                                                                                                                                                                                                                                                                                                                                                                                                                                                                                                                 |                                                                                                                                                                                                                                                                                                                   | PM            |                                 |            |

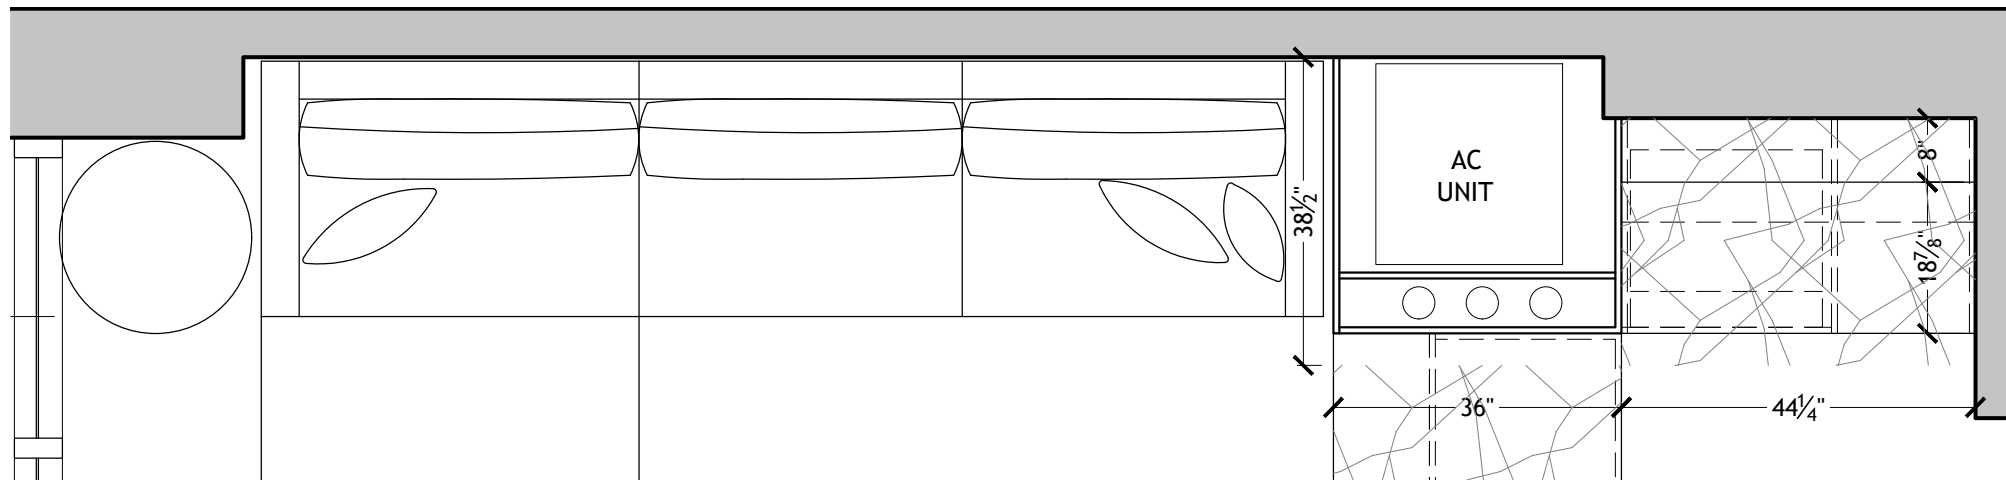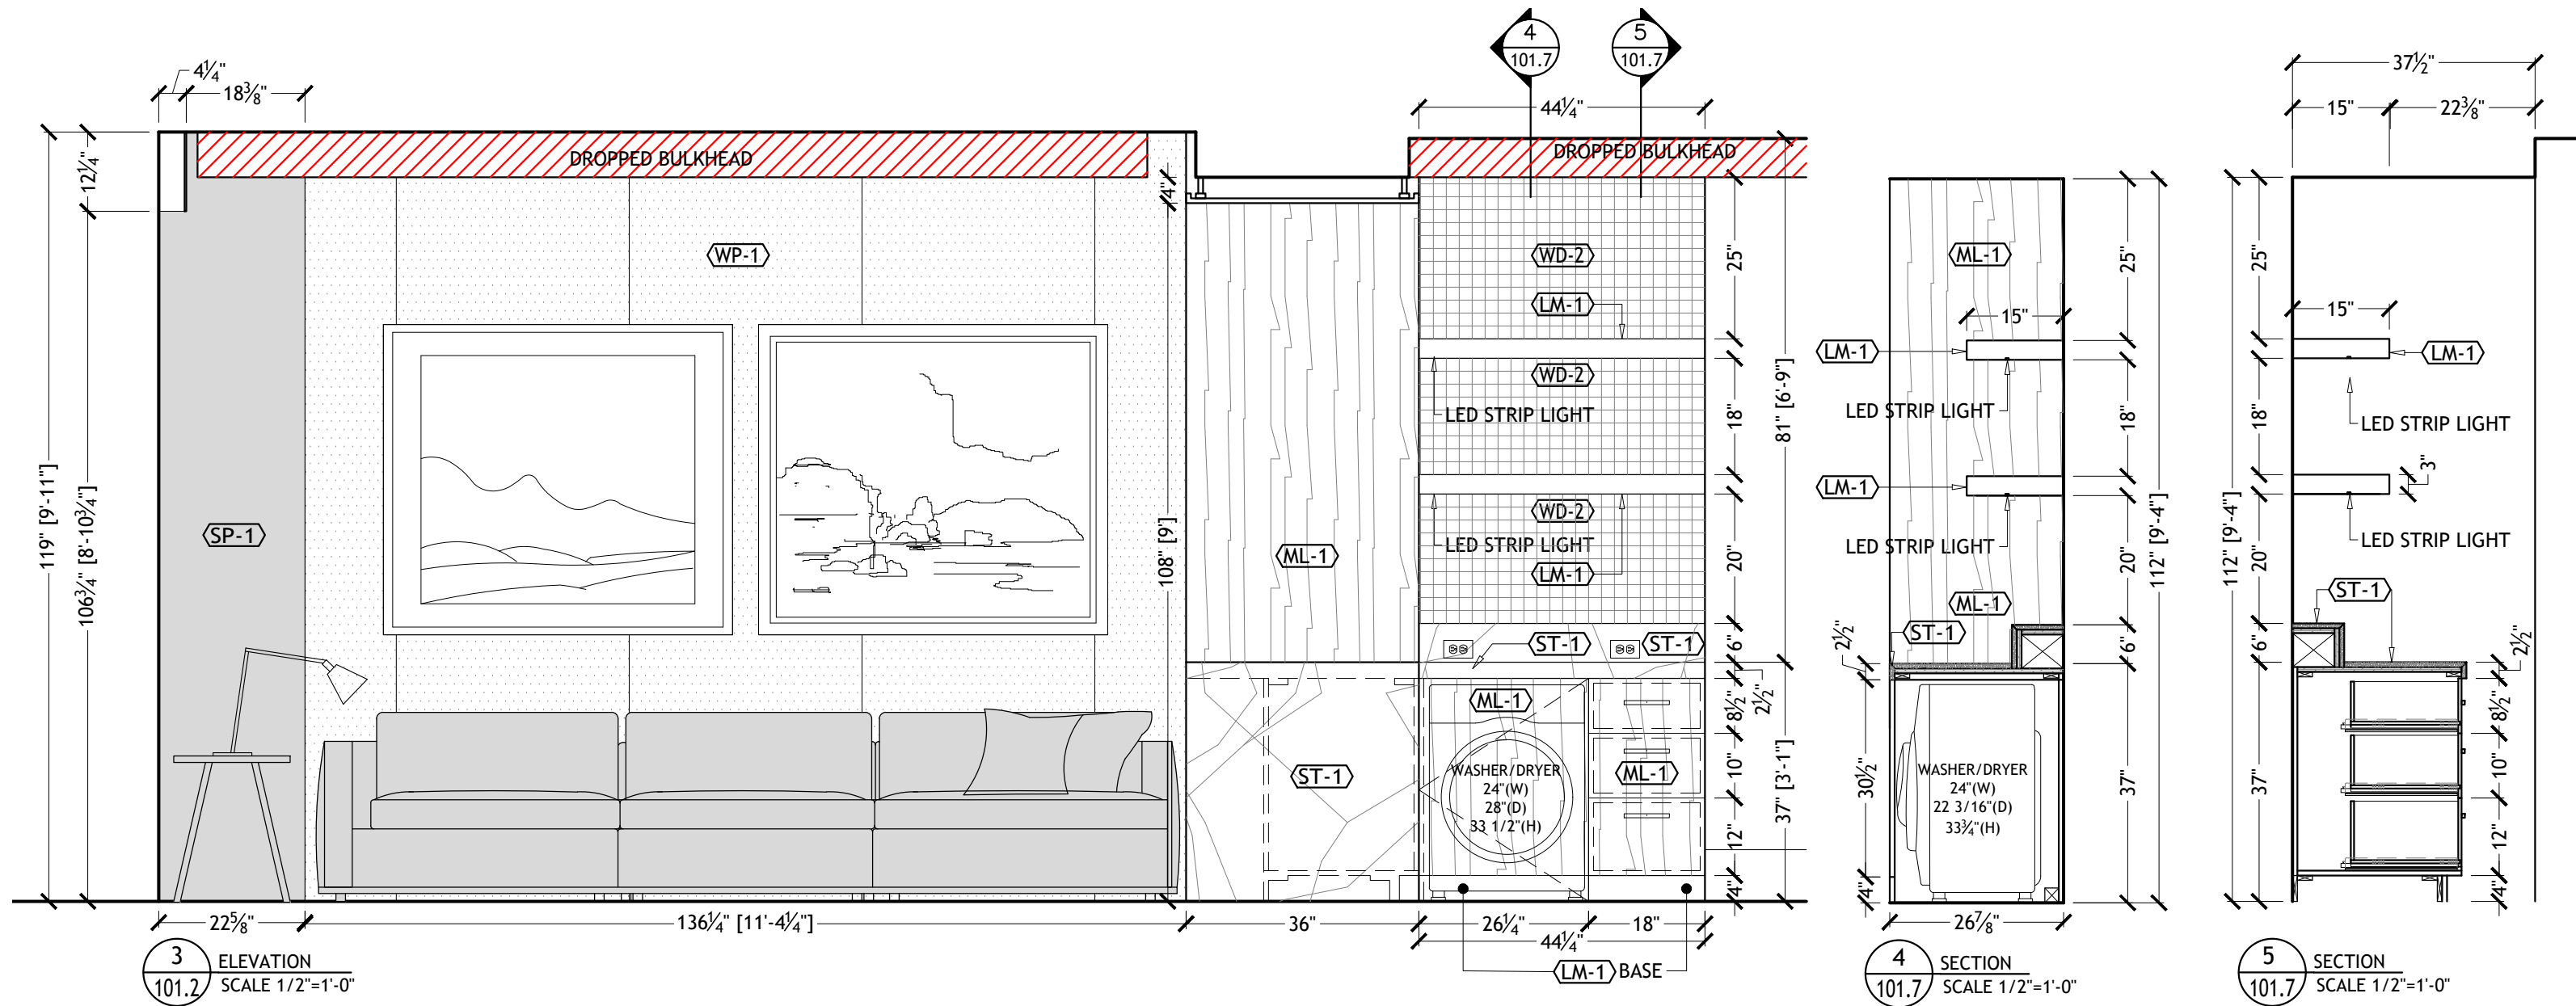

- (ST-1) NATURALI STONE, PIETRA CANICO  
(WD-2) ODYSSEY WALLCOVERINGS, DOLCE - POPLAR, 16"x60"  
(LM-1) OCTOLUX #15-STAINLESS STEEL ALUMINUM  
(ML-1) UNIBOARD K62 FEATHER WHITE, NOBELLA FINISH  
(ML-2) UNIBOARD 123, CHARCOAL (INTERIOR)  
(WP-1) MAYA ROMANOFF, WALLMICA, DIVAN MR-SK-1400  
(SP-1) EXPOSED CONCRETE

- ST-1

NATURALI STONE, PIETRA CANICO
- ML-1

UNIBOARD, K62 FEATHER WHITE, NOBELLA FINISH
- LM-1

OCTOLUX #15-STAINLESS STEEL ALUMINUM

