


SCALE: $\frac{1}{2}" = 1'-0"$


CONTINUUM MIAMI
ENTRY SCIONCE ELEVATION

WEETH HOME

A2

SCALE: $\frac{1}{2}'' = 1'-0''$

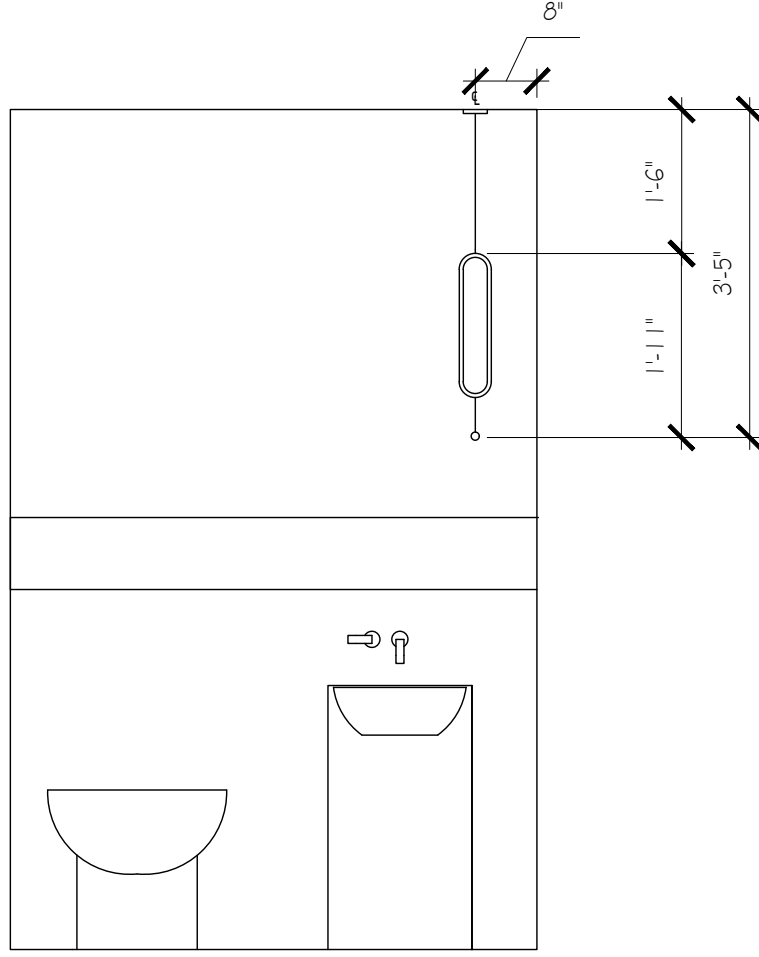

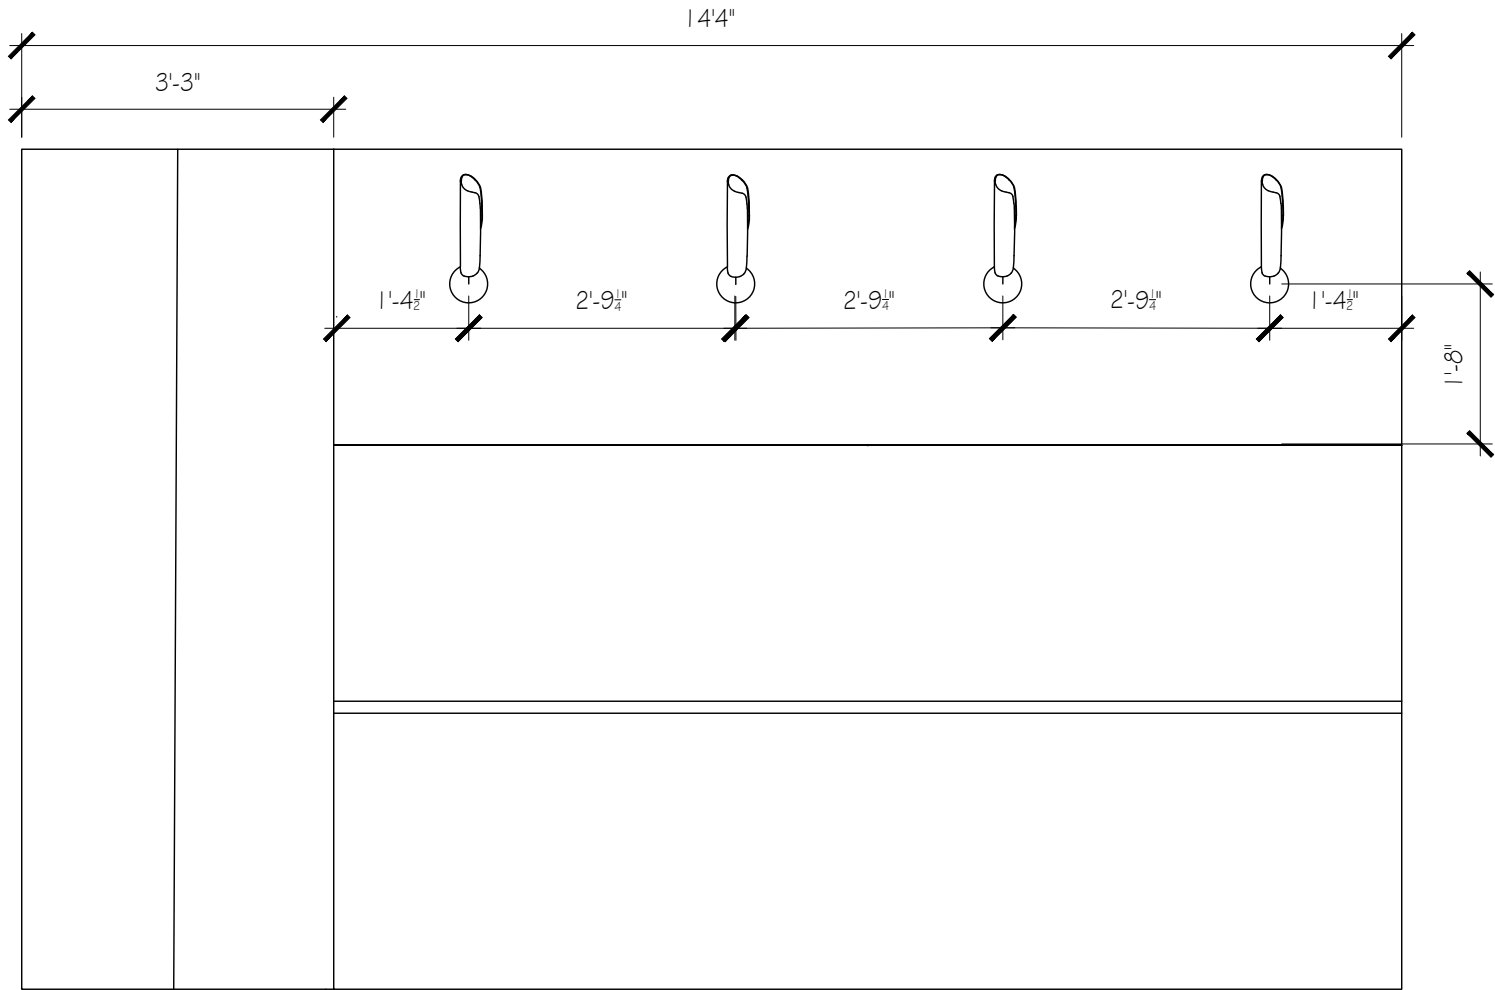


SCALE: $\frac{1}{2}$ " = 1'-0"

CONTINUUM MIAMI
KITCHEN SCONCE ELEVATION

WEETH HOME

A2

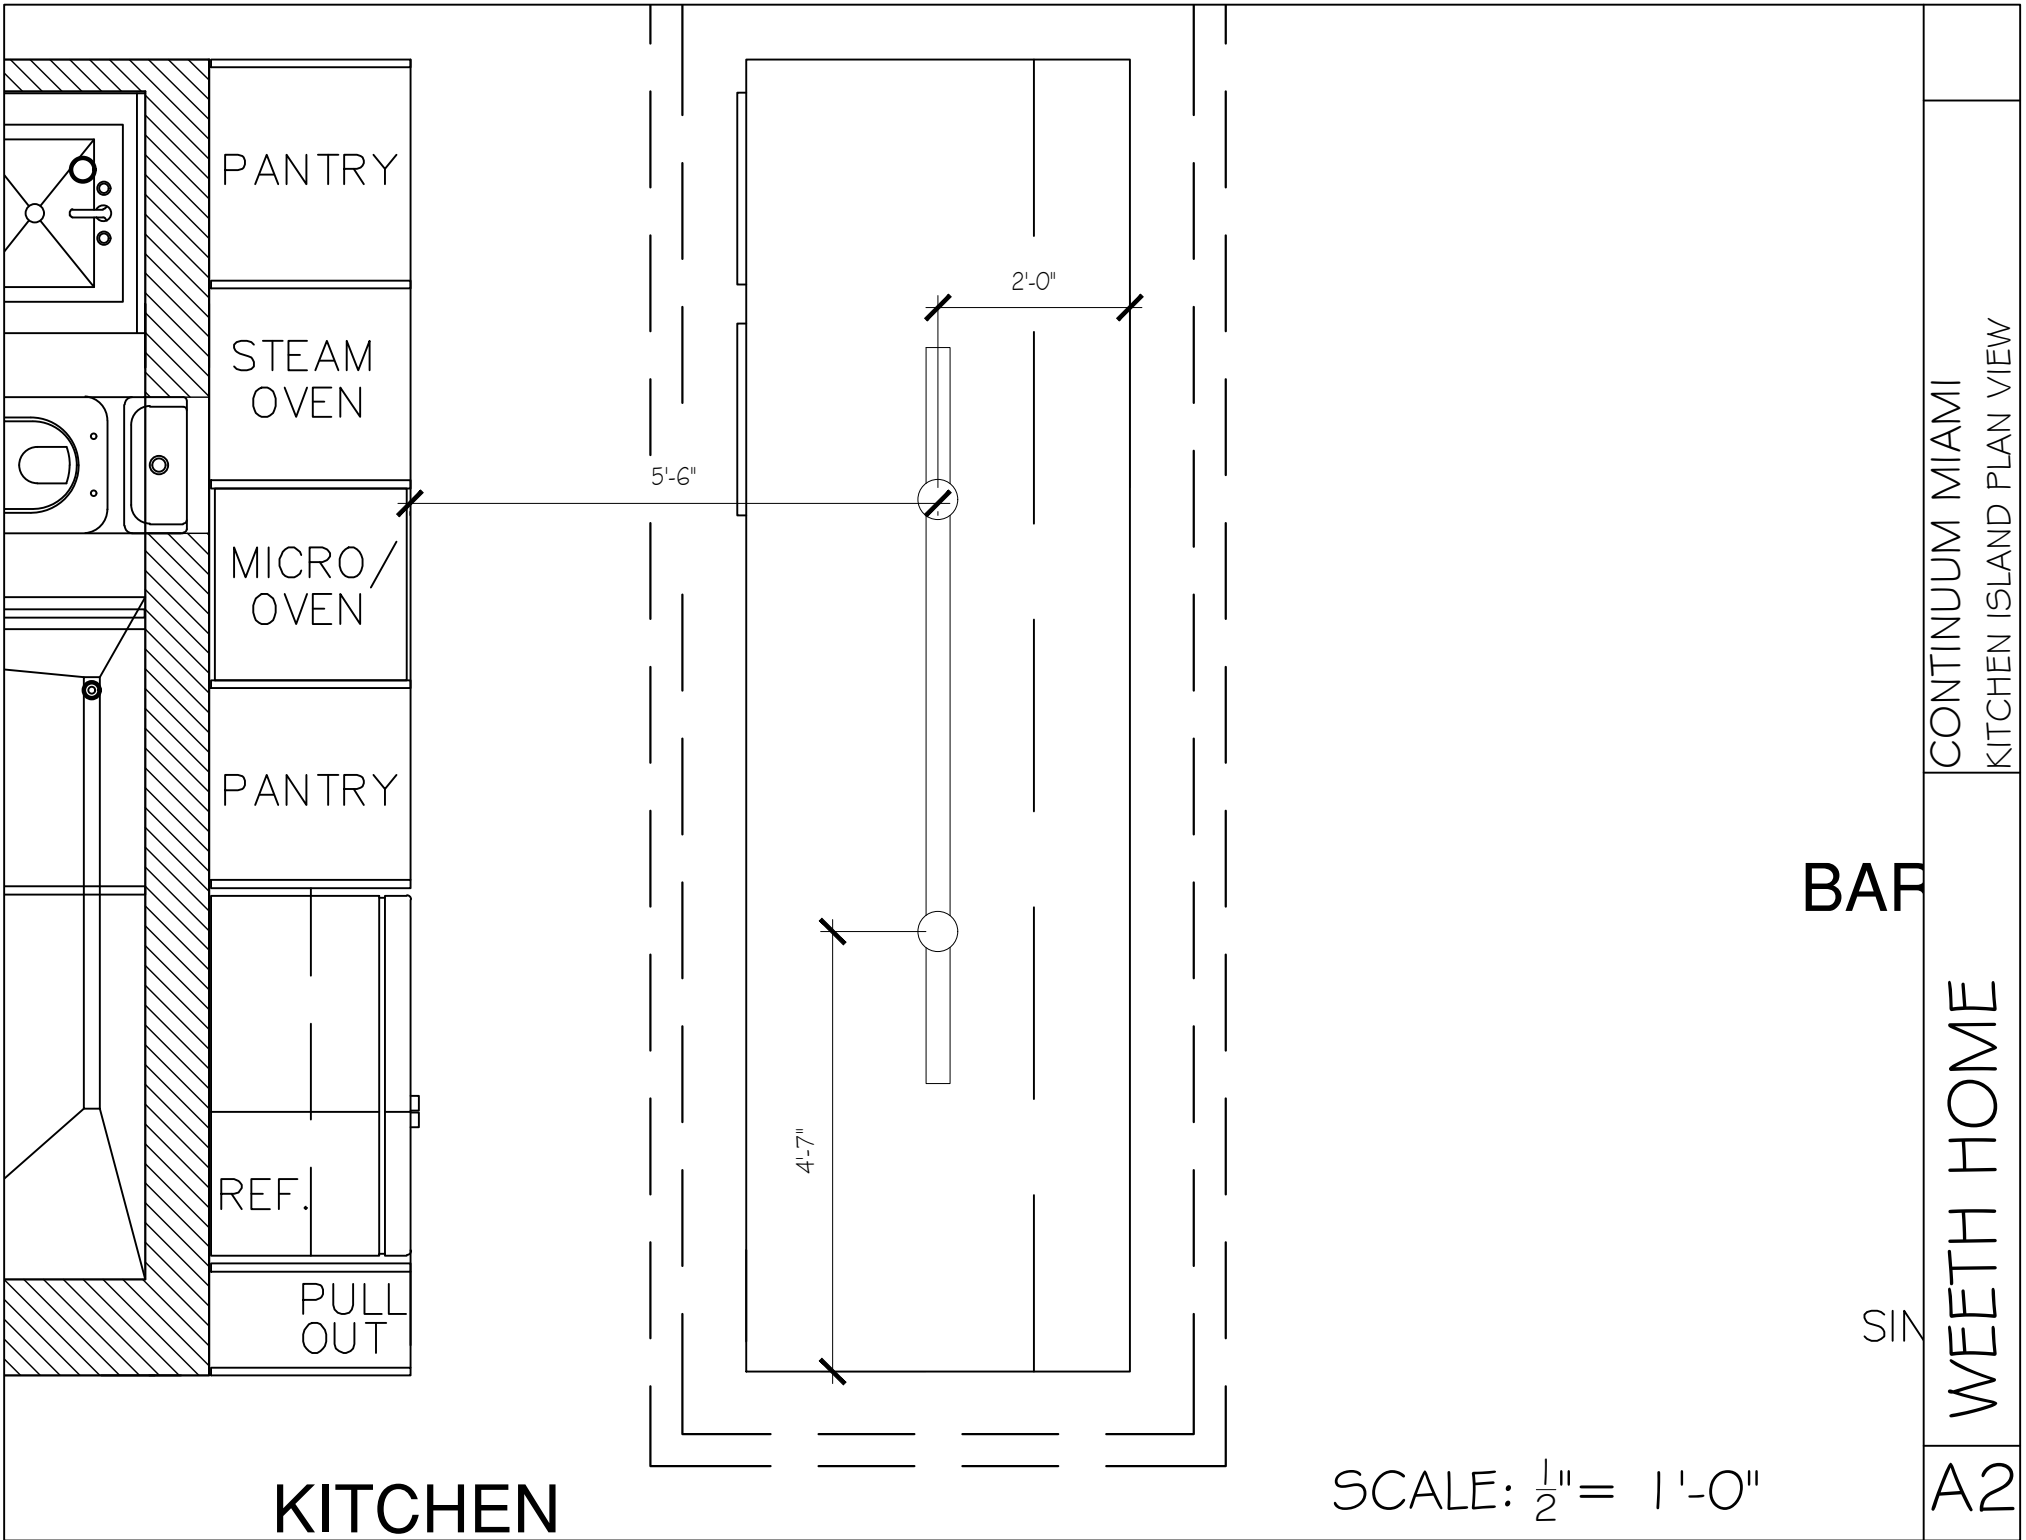

KITCHEN


SCALE: 1/2" = 1'-0"

CONTINUUM MIAMI
KITCHEN ISLAND PLAN VIEW

BAR

WEETH HOME

A2

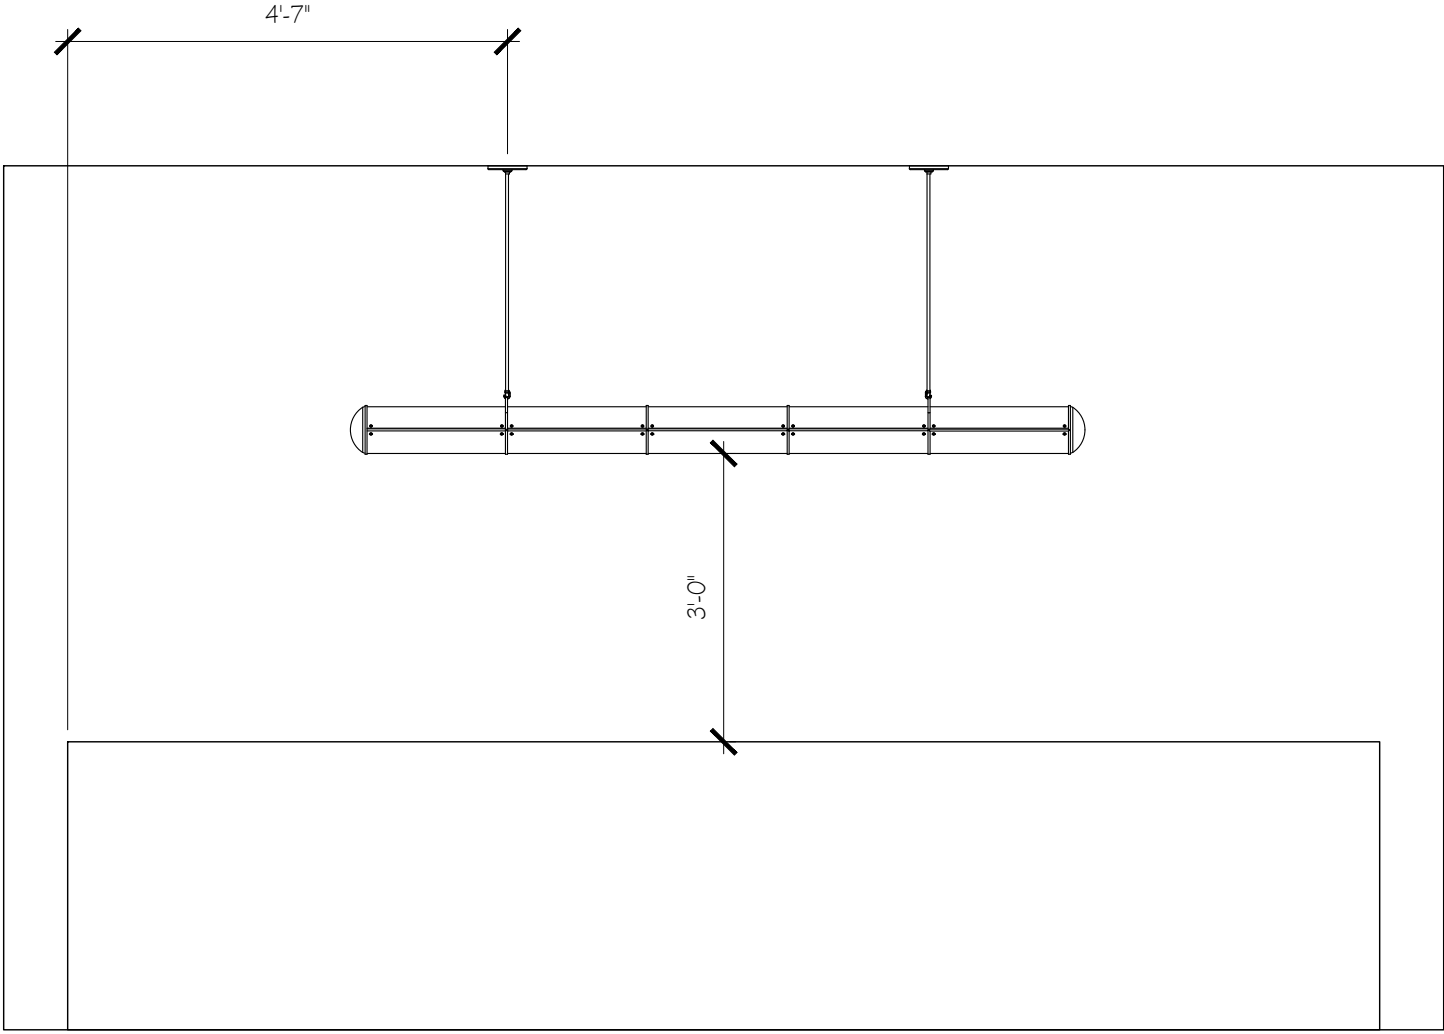


SCALE: $\frac{1}{2}'' = 1'-0''$

CONTINUUM MIAMI
KITCHEN ISLAND ELEVATION

WEETH HOME

A2

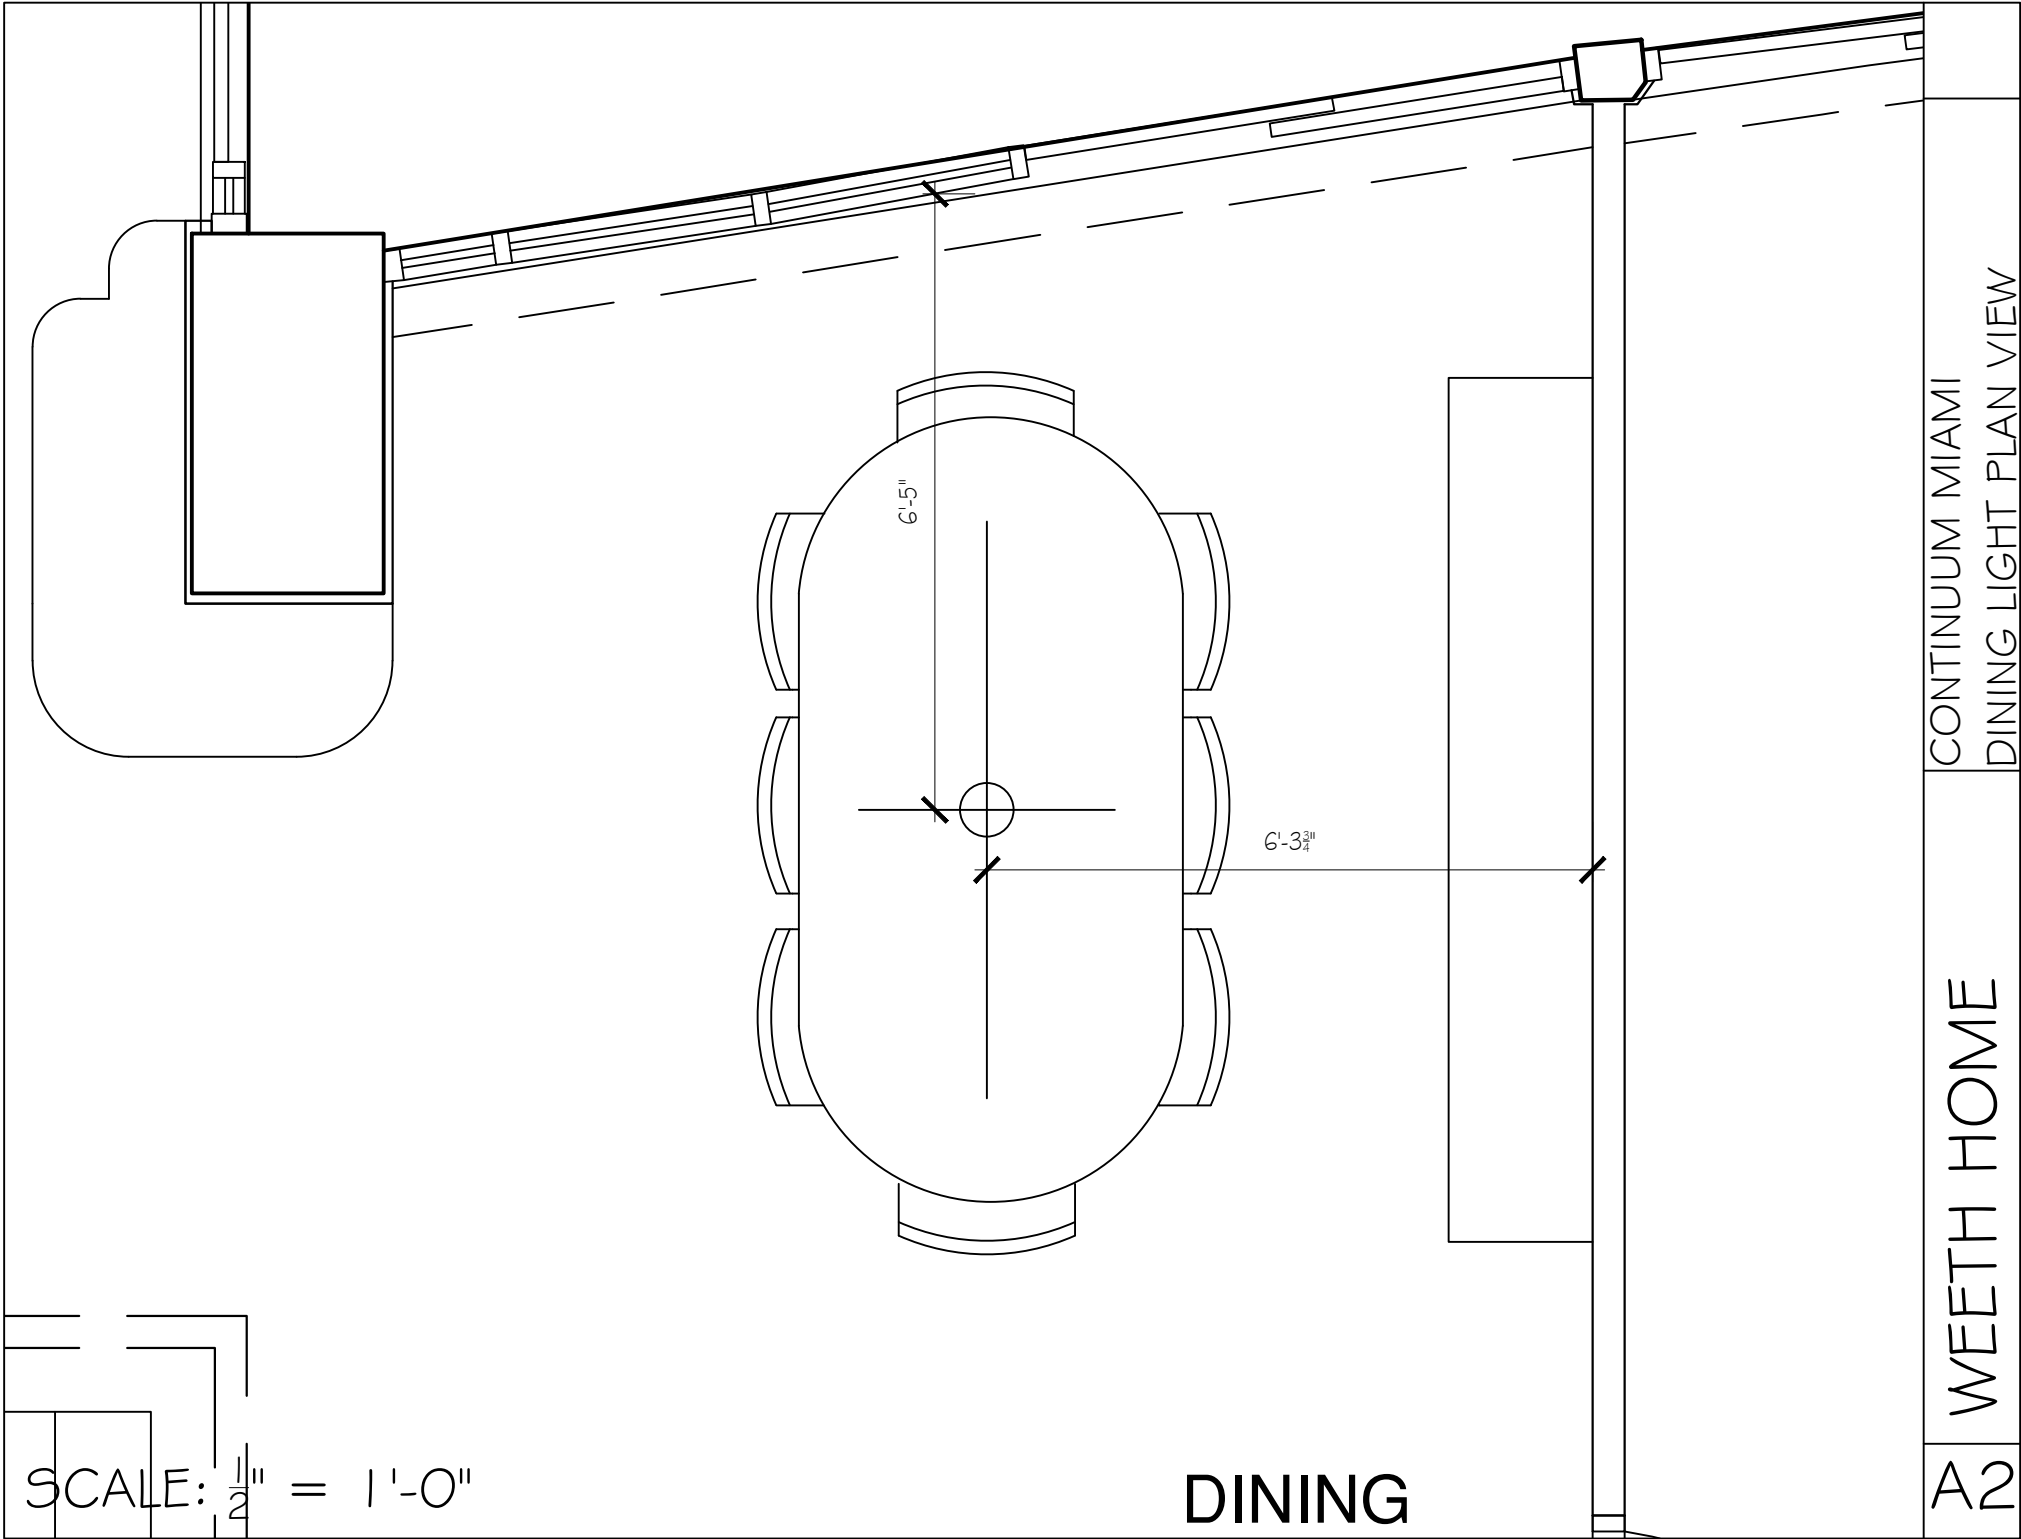

SCALE: 1/2" = 1'-0"


DINING

CONTINUUM MIAMI
DINING LIGHT PLAN VIEW

WEETH HOME

A2


SCALE: $\frac{1}{2}'' = 1'-0''$

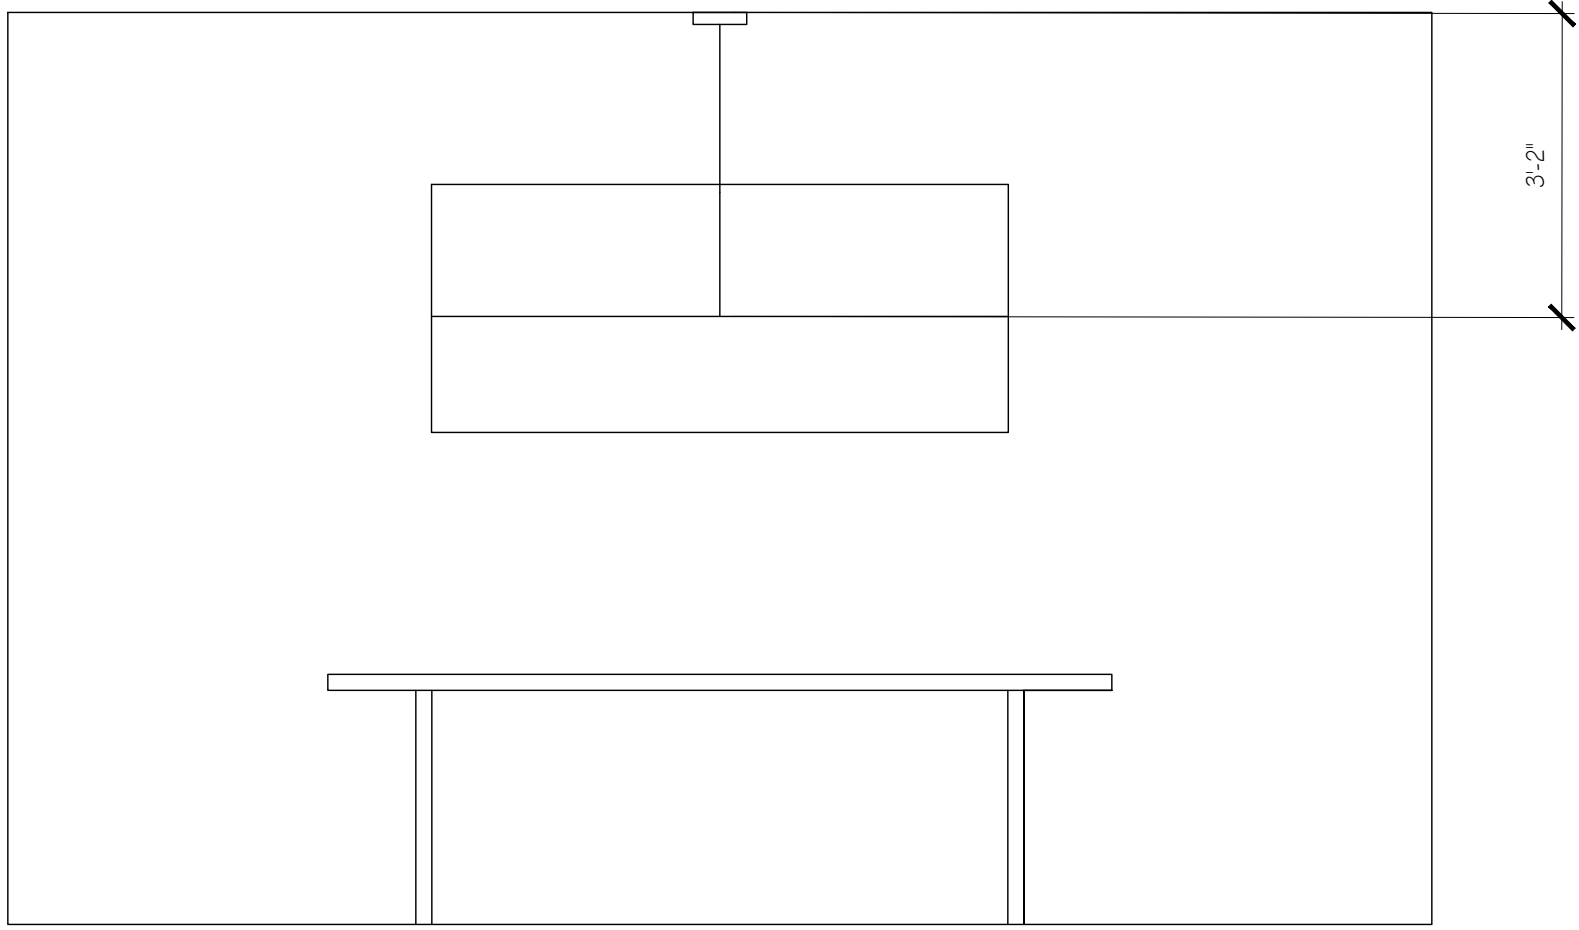

A2

WEETH HOME

CONTINUUM MIAMI
DINING LIGHT ELEVATION

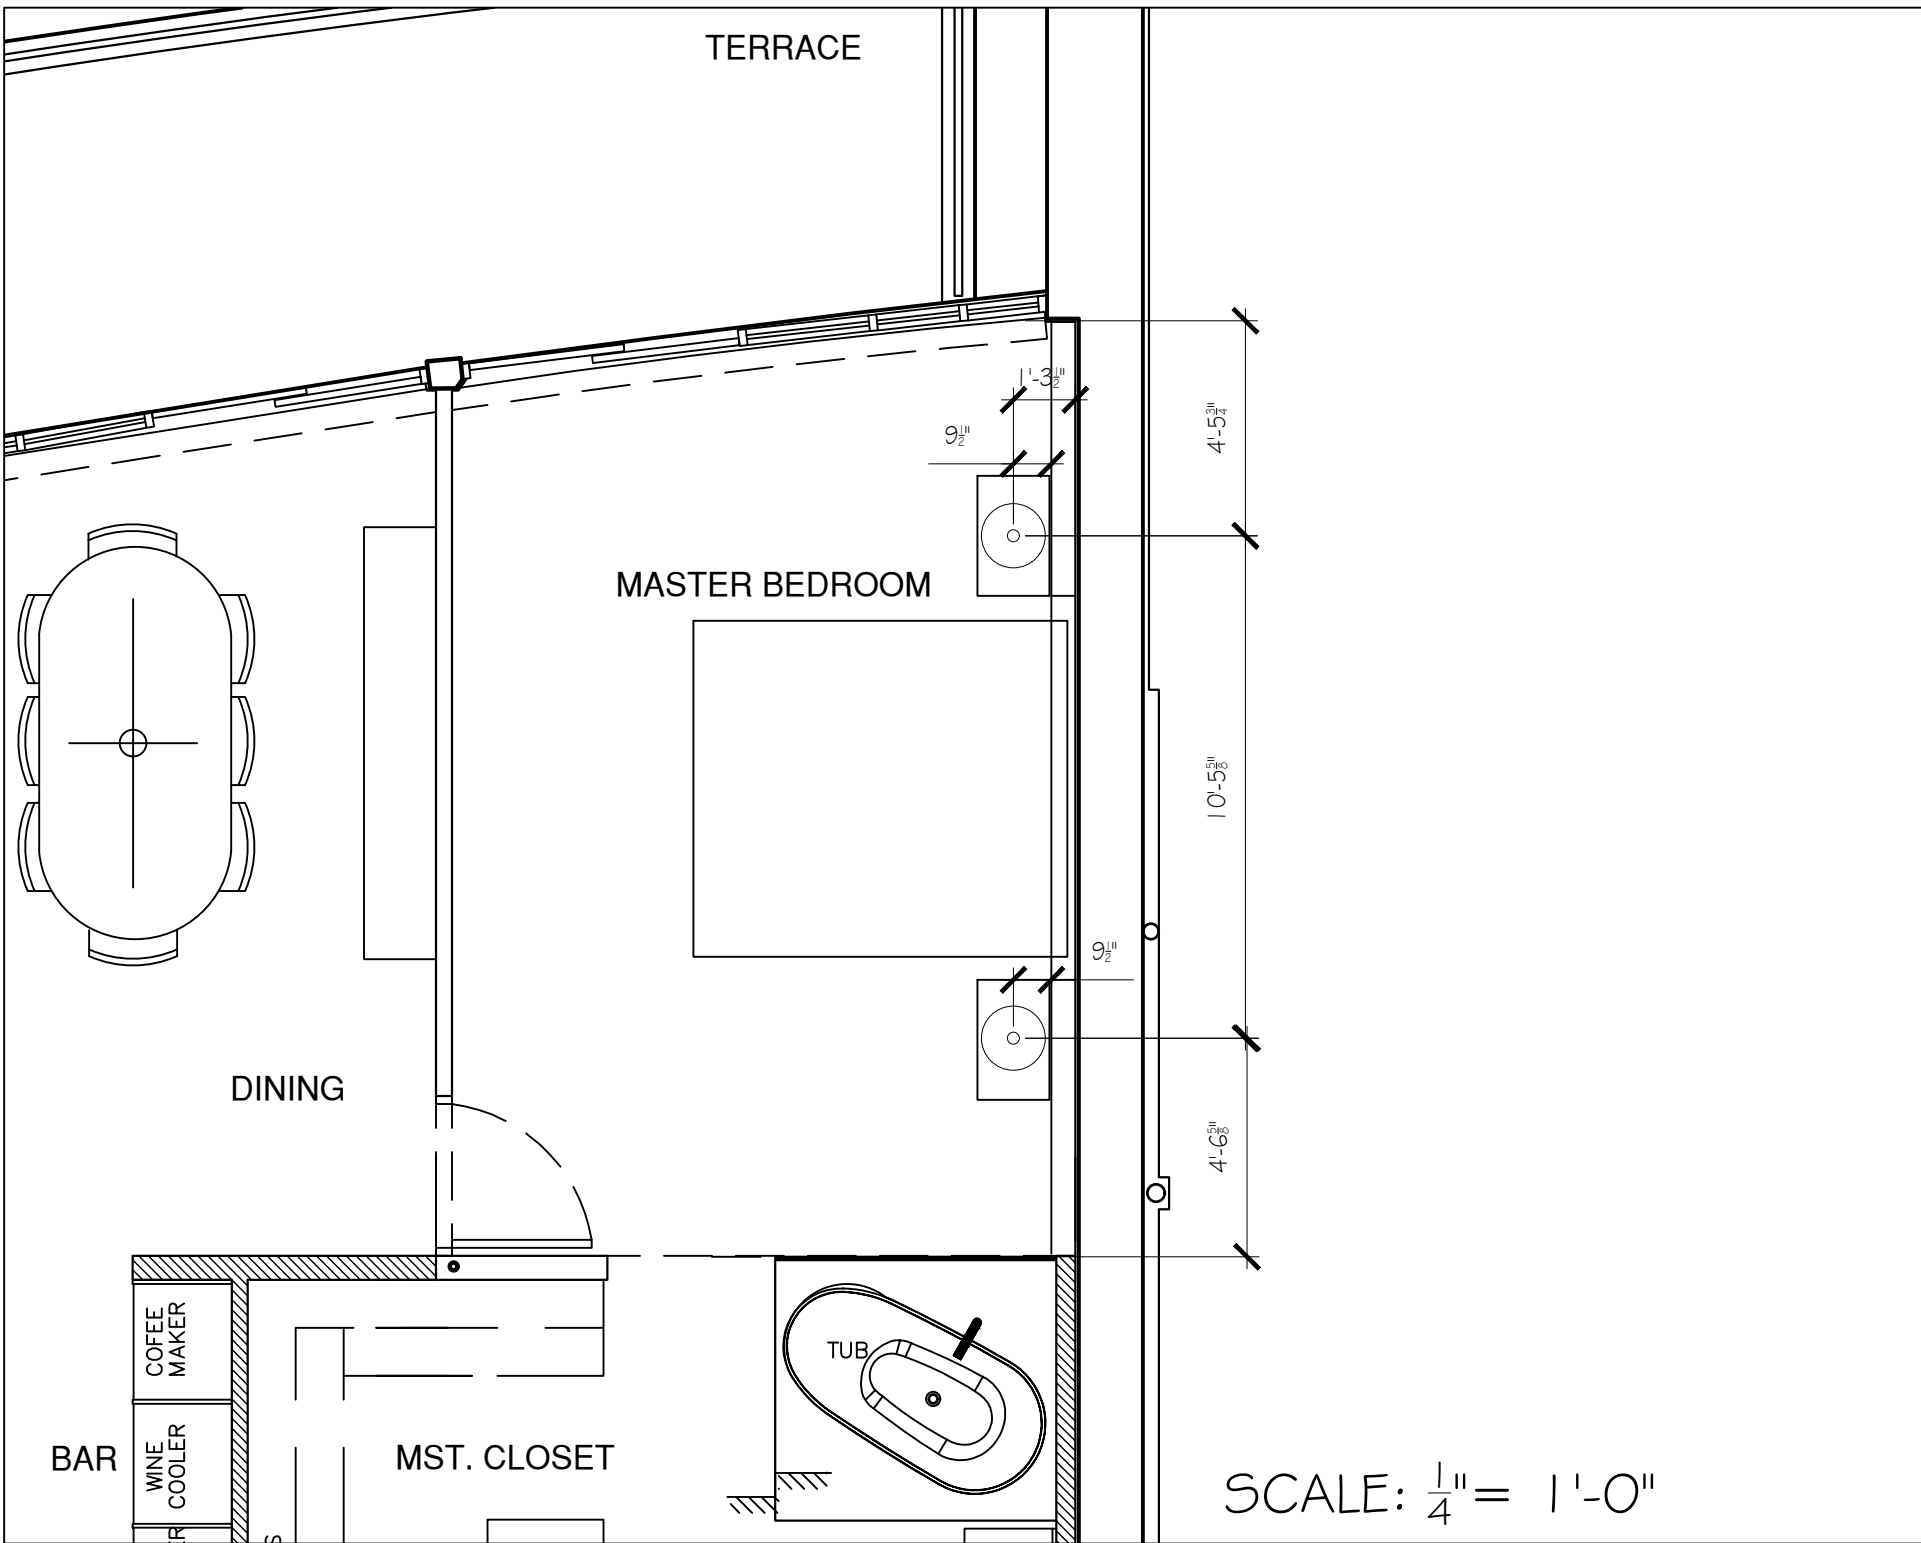

TERRACE

MASTER BEDROOM

DINING

BAR

WINE COOLER
COFFEE MAKER

MST. CLOSET

TUB


SCALE: 1/4" = 1'-0"


CONTINUUM MIAMI
MASTER BEDROOM LIGHTING PLAN VIEW

WEETH HOME

A2

SCALE: $\frac{1}{2}$ " = 1'-0"

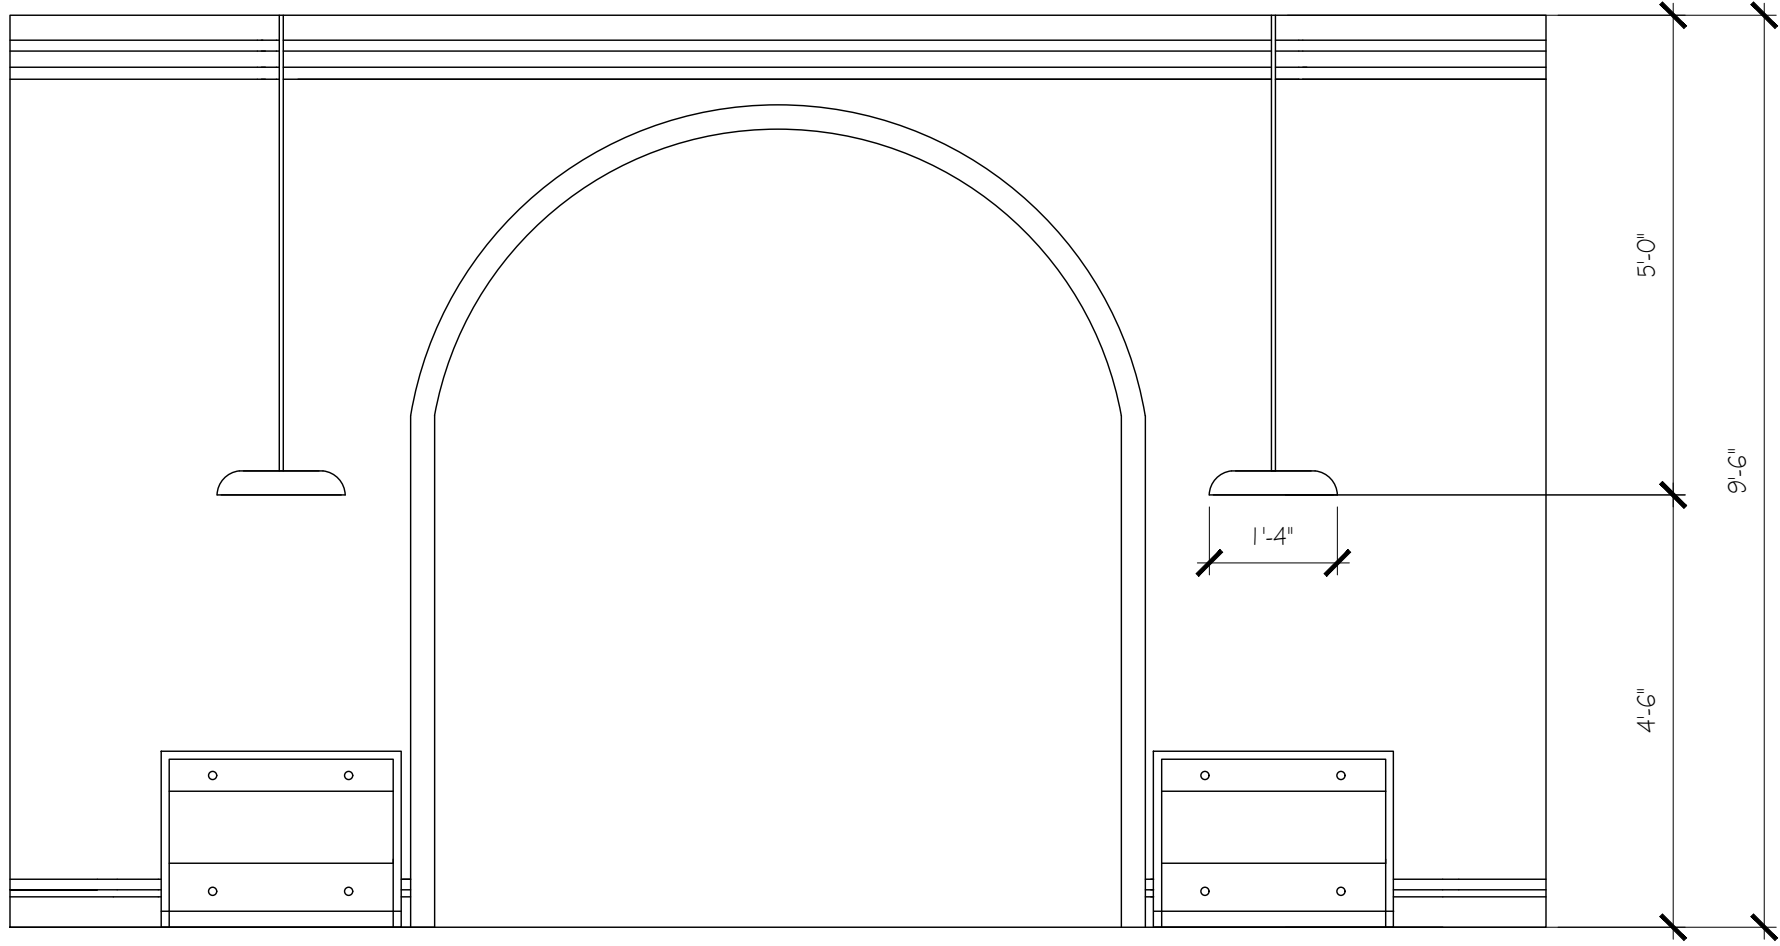

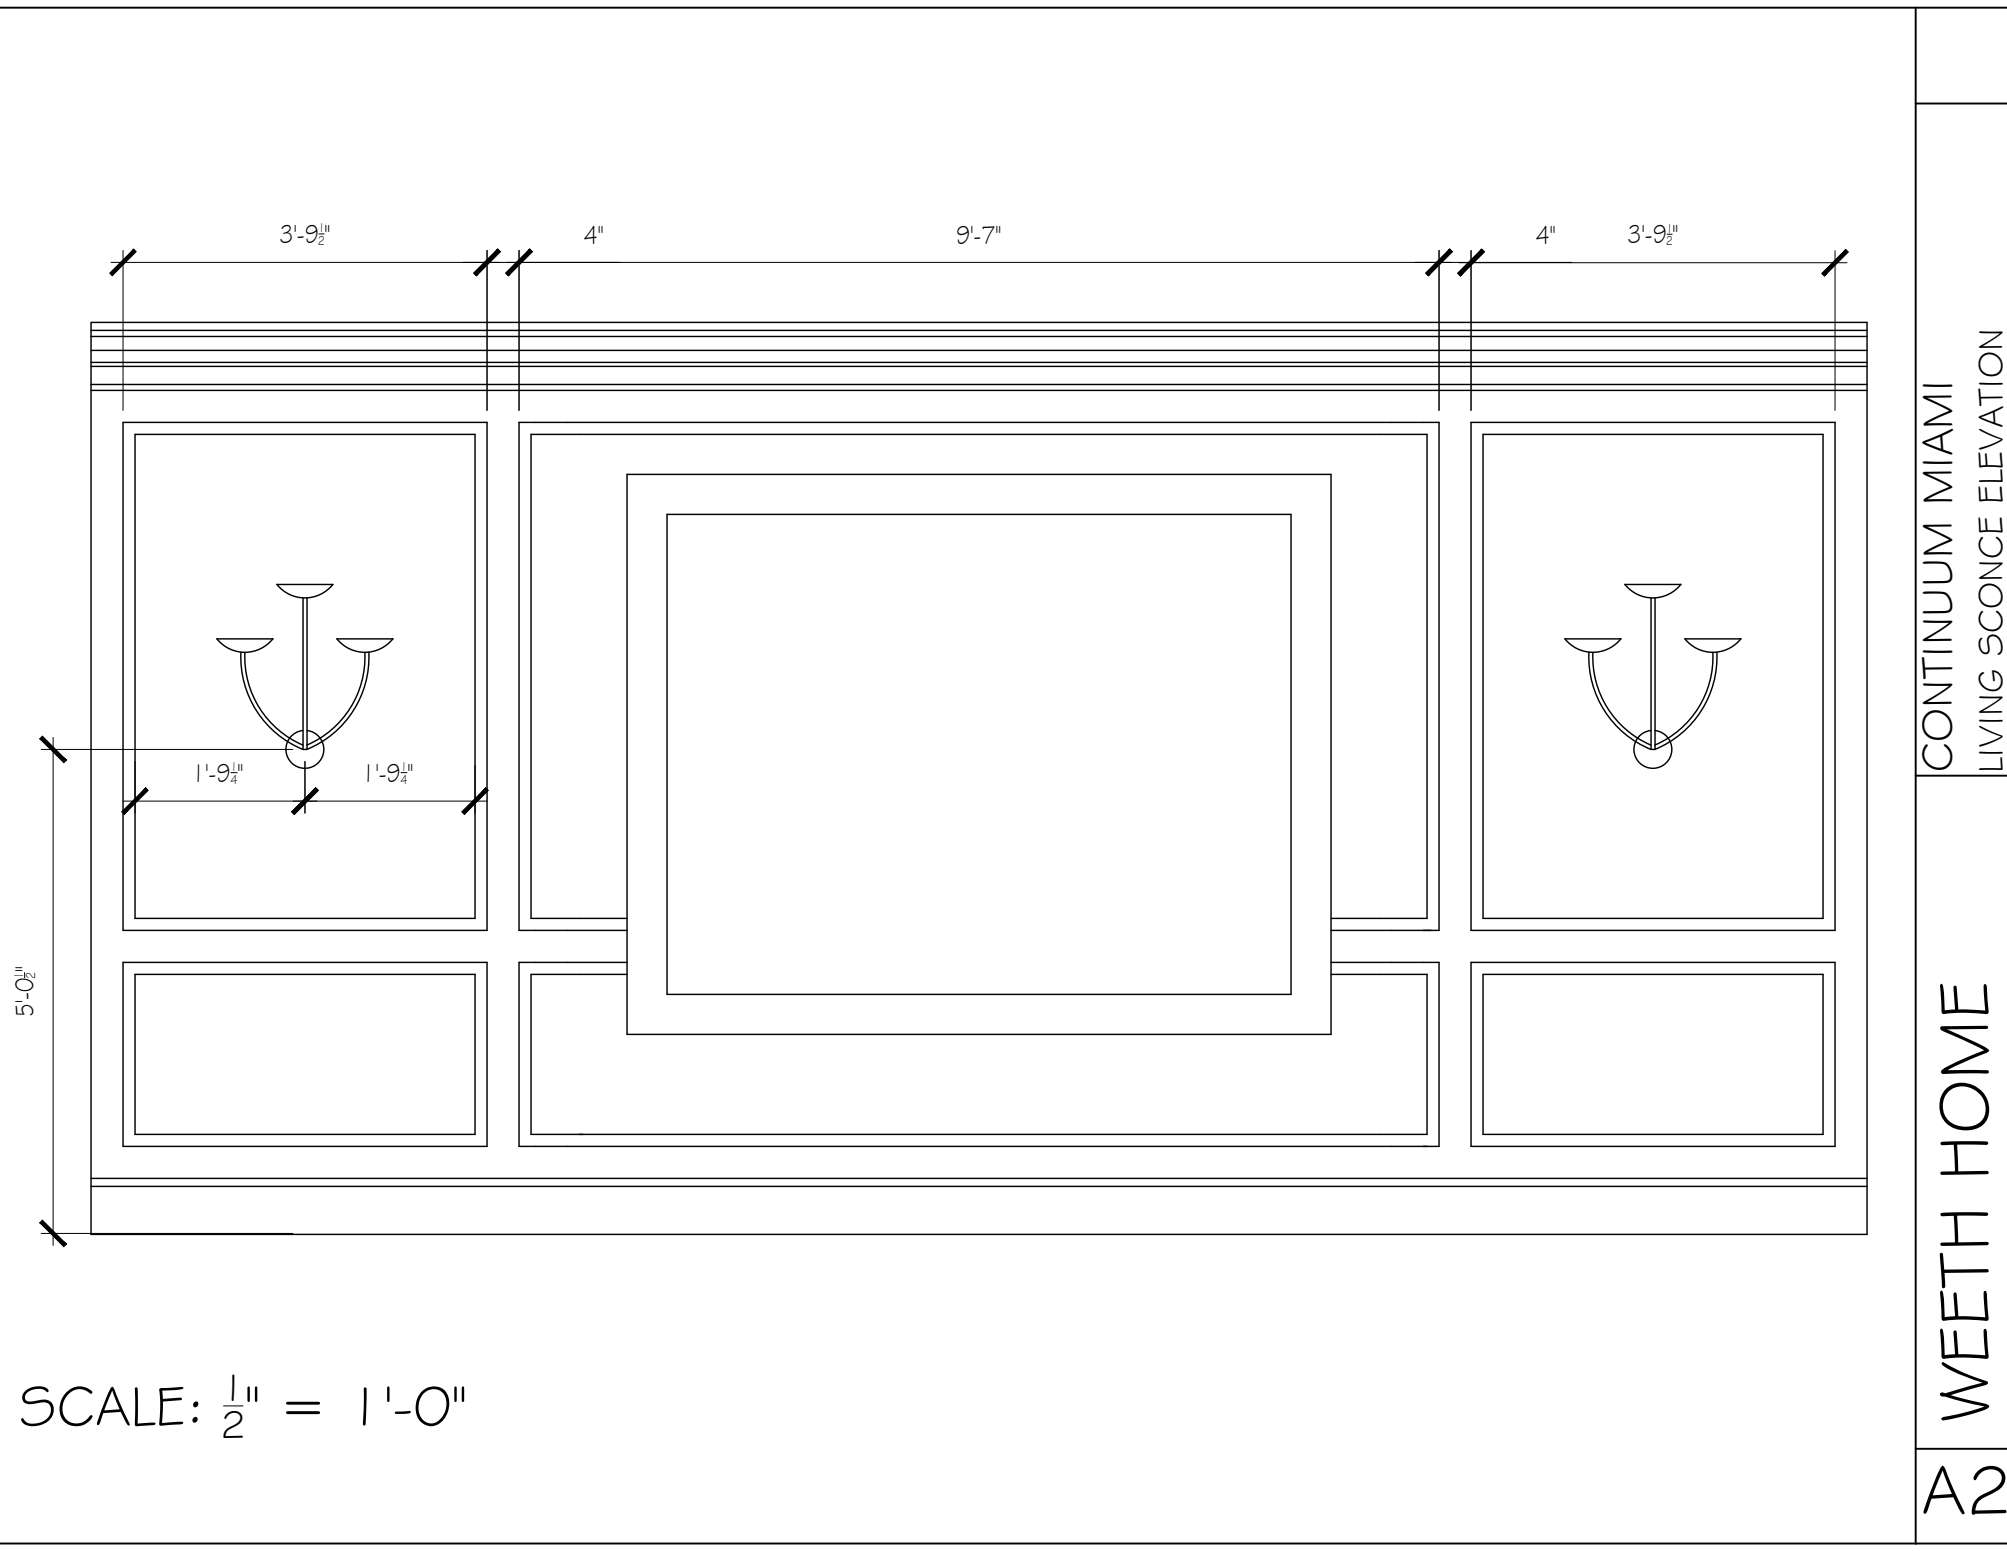


CONTINUUM MIAMI
LIVING SCENCE ELEVATION

WEETH HOME

A2


SCALE: 1/4" = 1'-0"

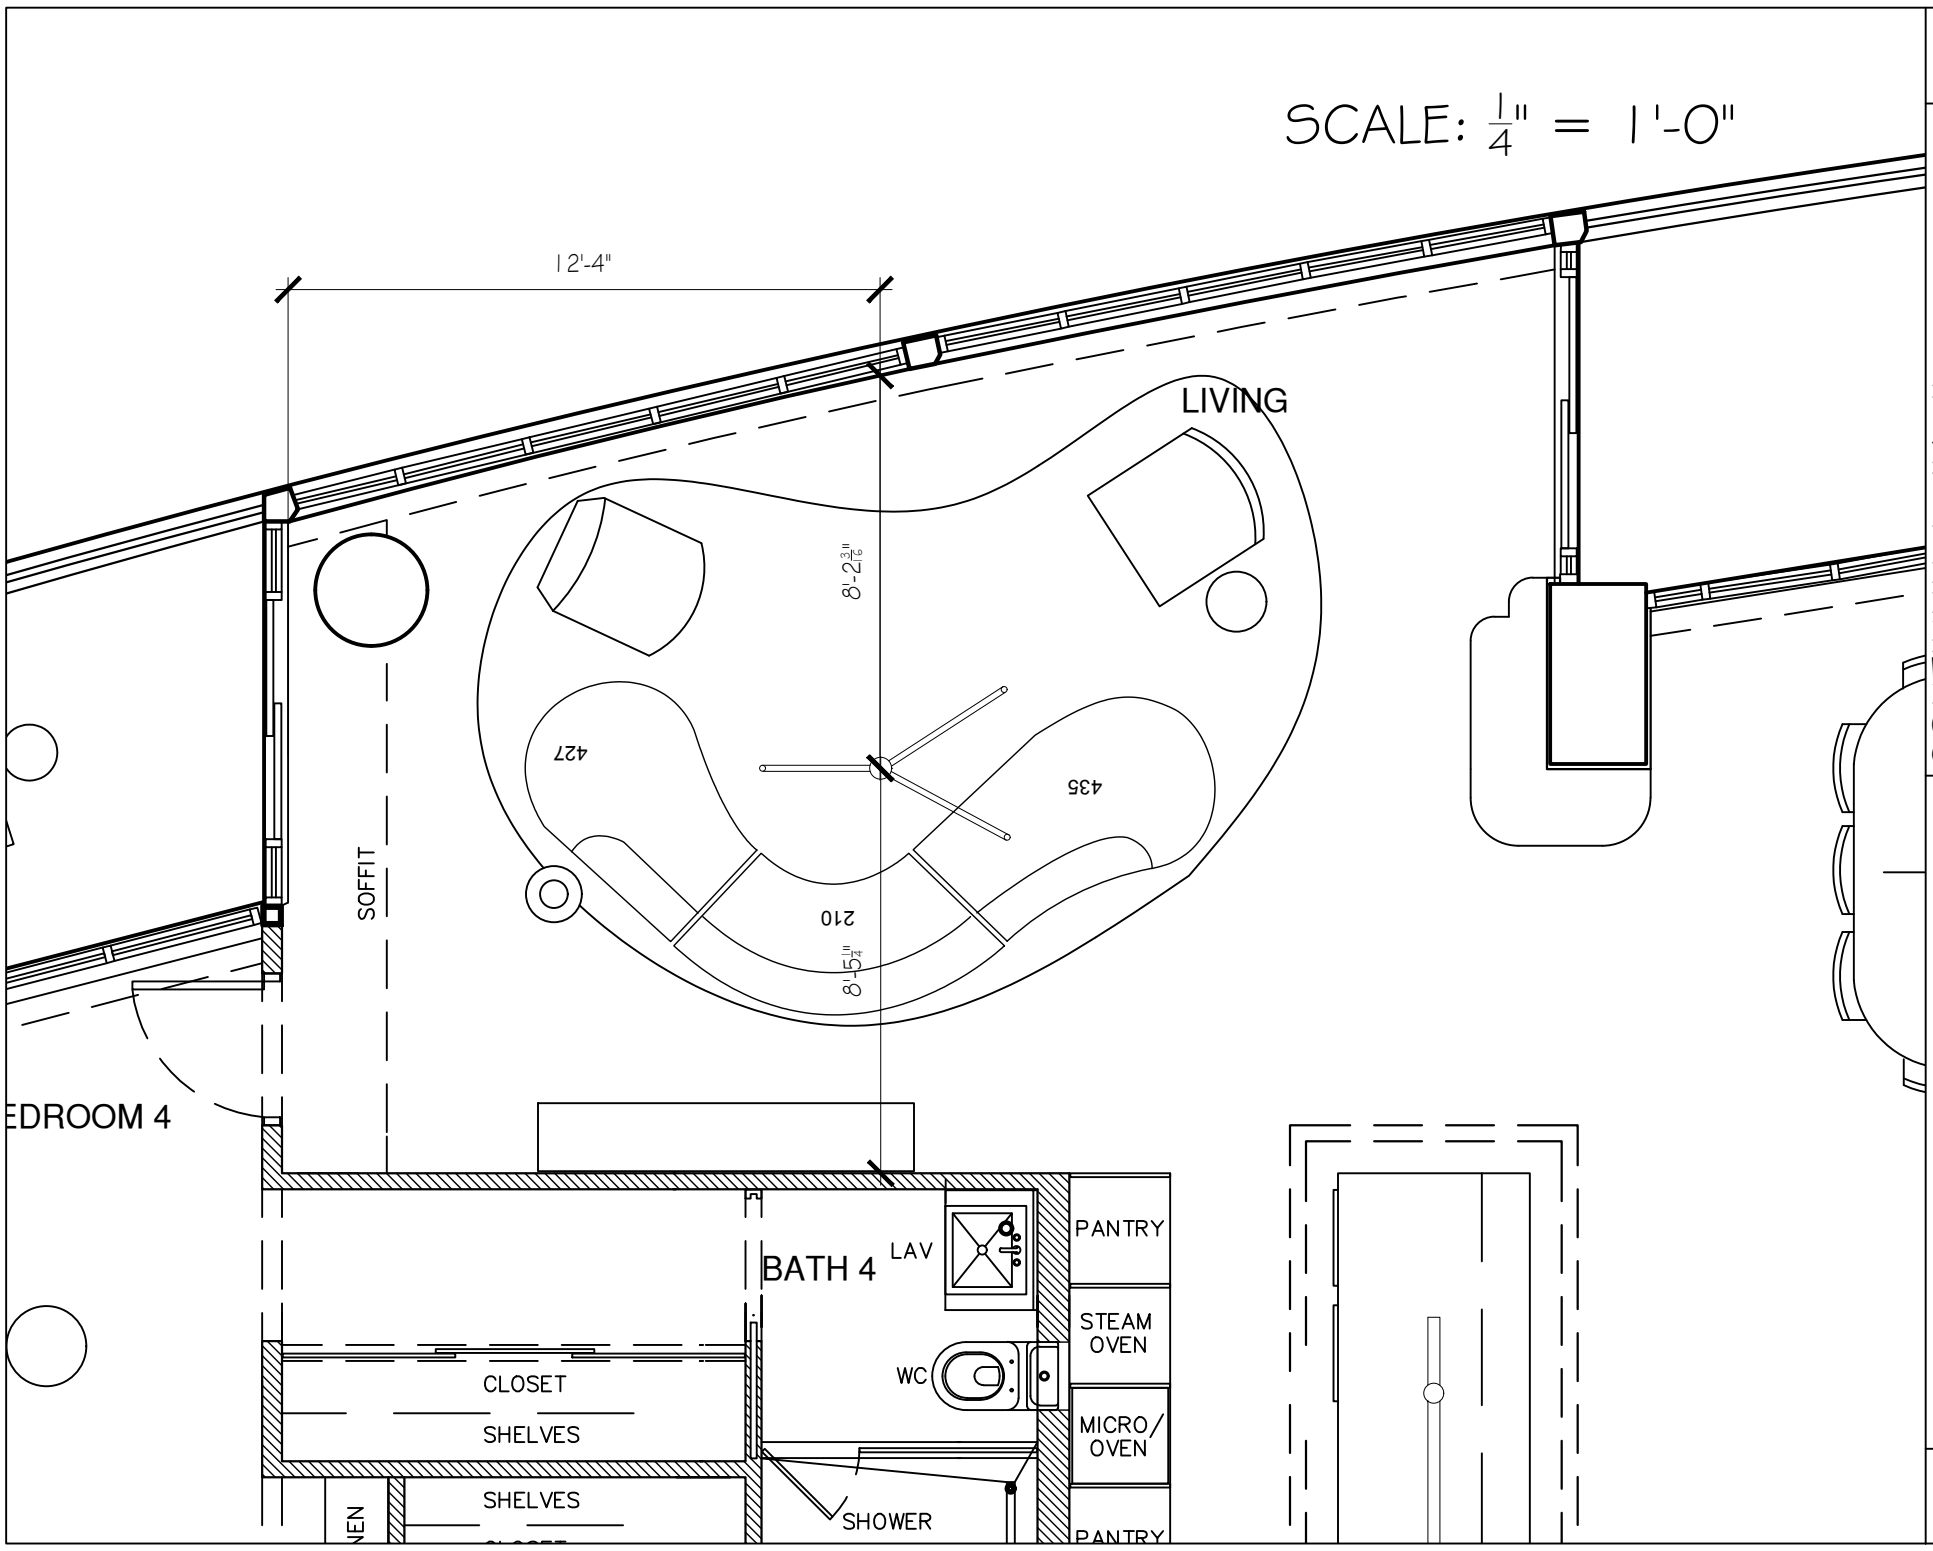

CONTINUUM MIAMI
LIVING CHANDELIER PLAN VIEW

WEETH HOME

A2


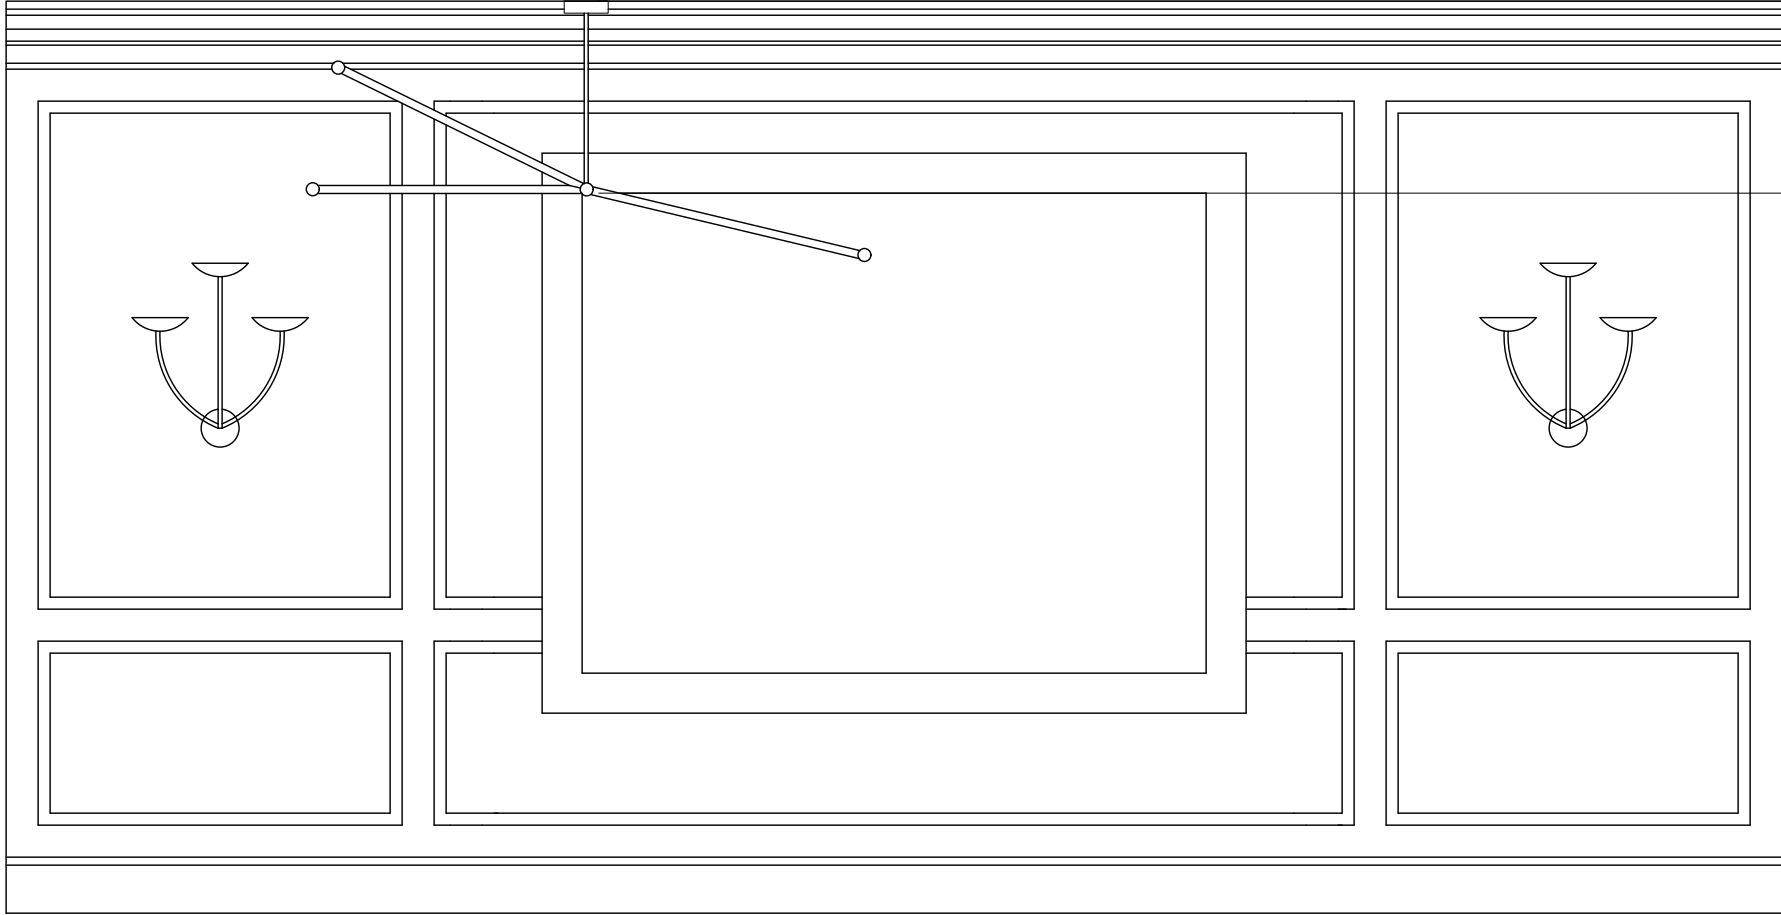


SCALE: $\frac{1}{2}$ " = 1'-0"

CONTINUUM MIAMI
LIVING CHANDELIER ELEVATION

WEETH HOME

A2

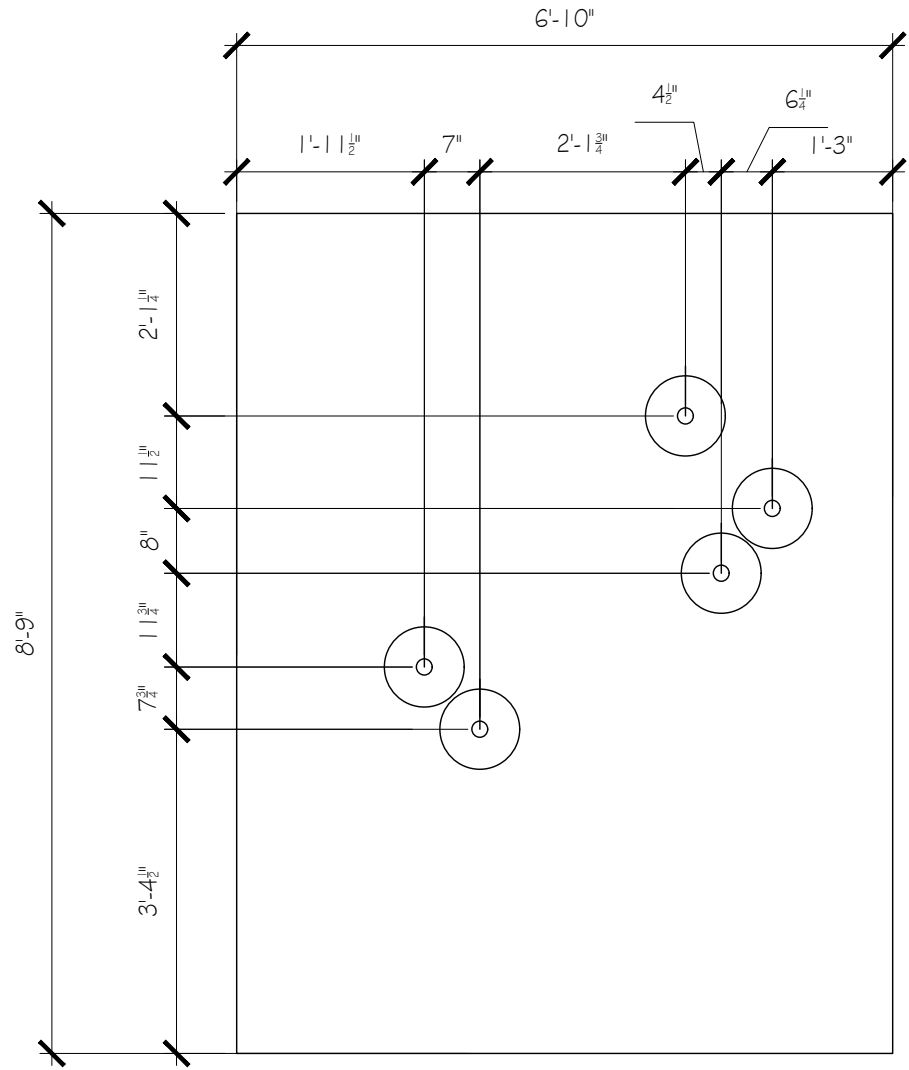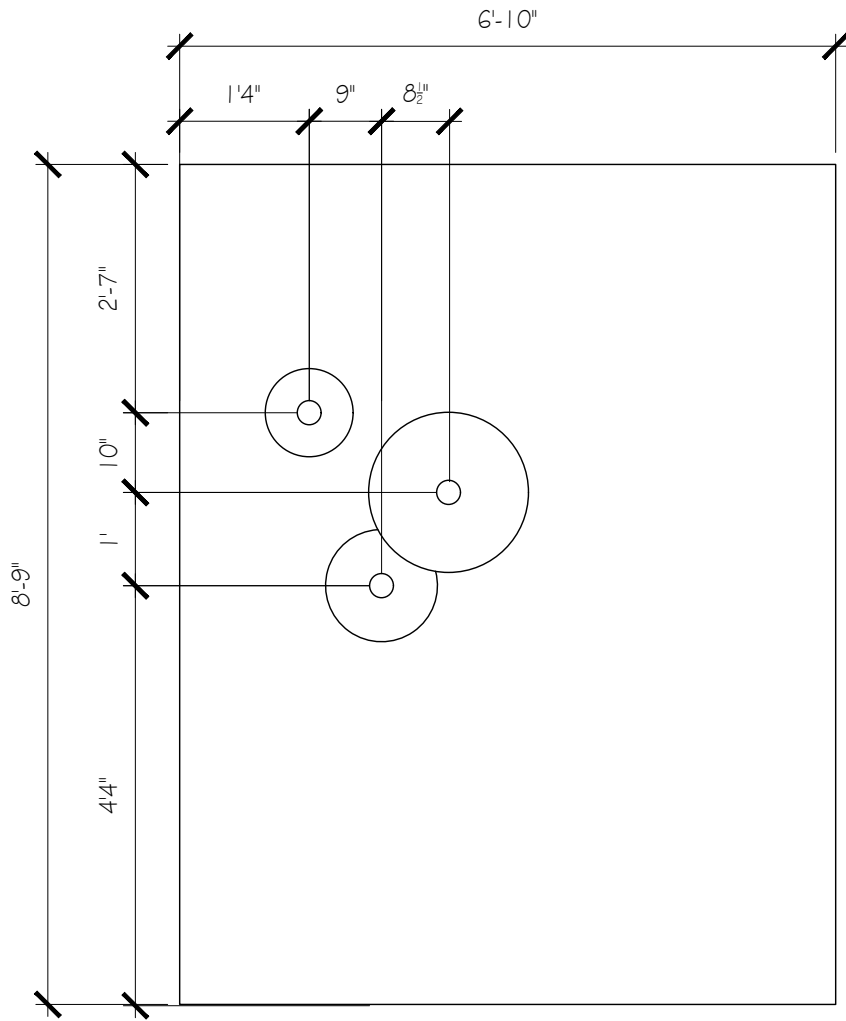


SCALE: $\frac{1}{2}'' = 1'-0''$


CONTINUUM MIAMI
KITCHEN/DEN HALL SCENCE ELEVATION

WEETH HOME

A2

SCALE: $\frac{1}{2}$ " = 1'-0"

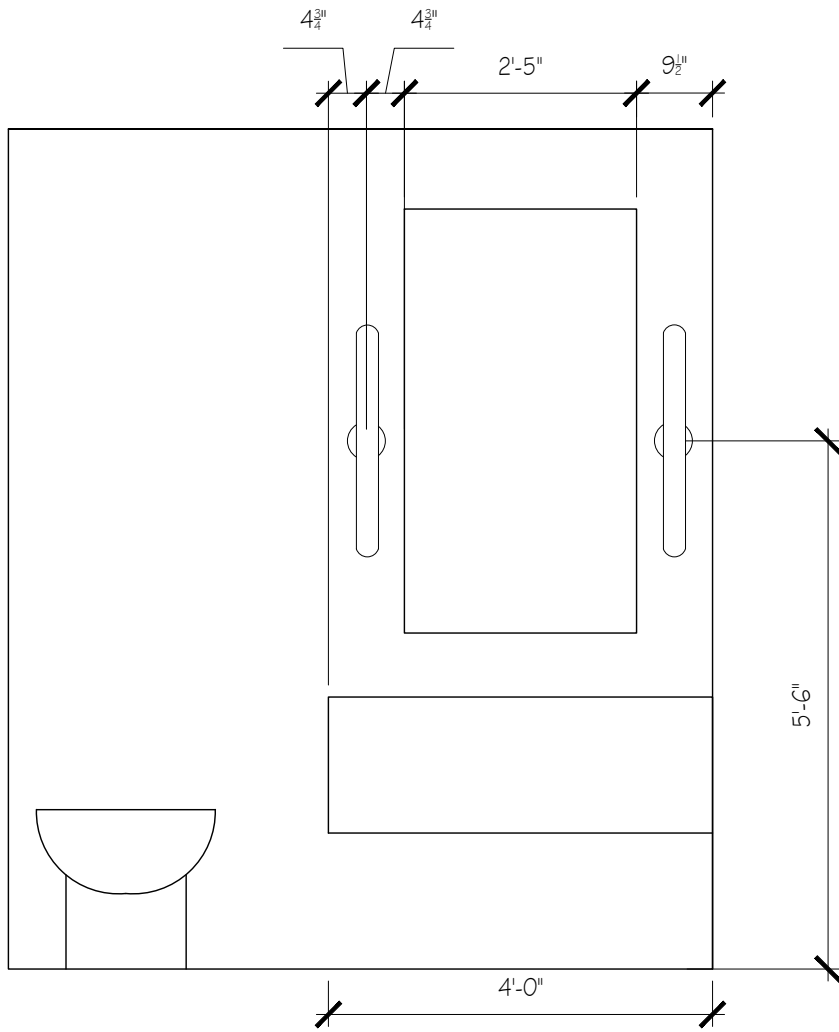

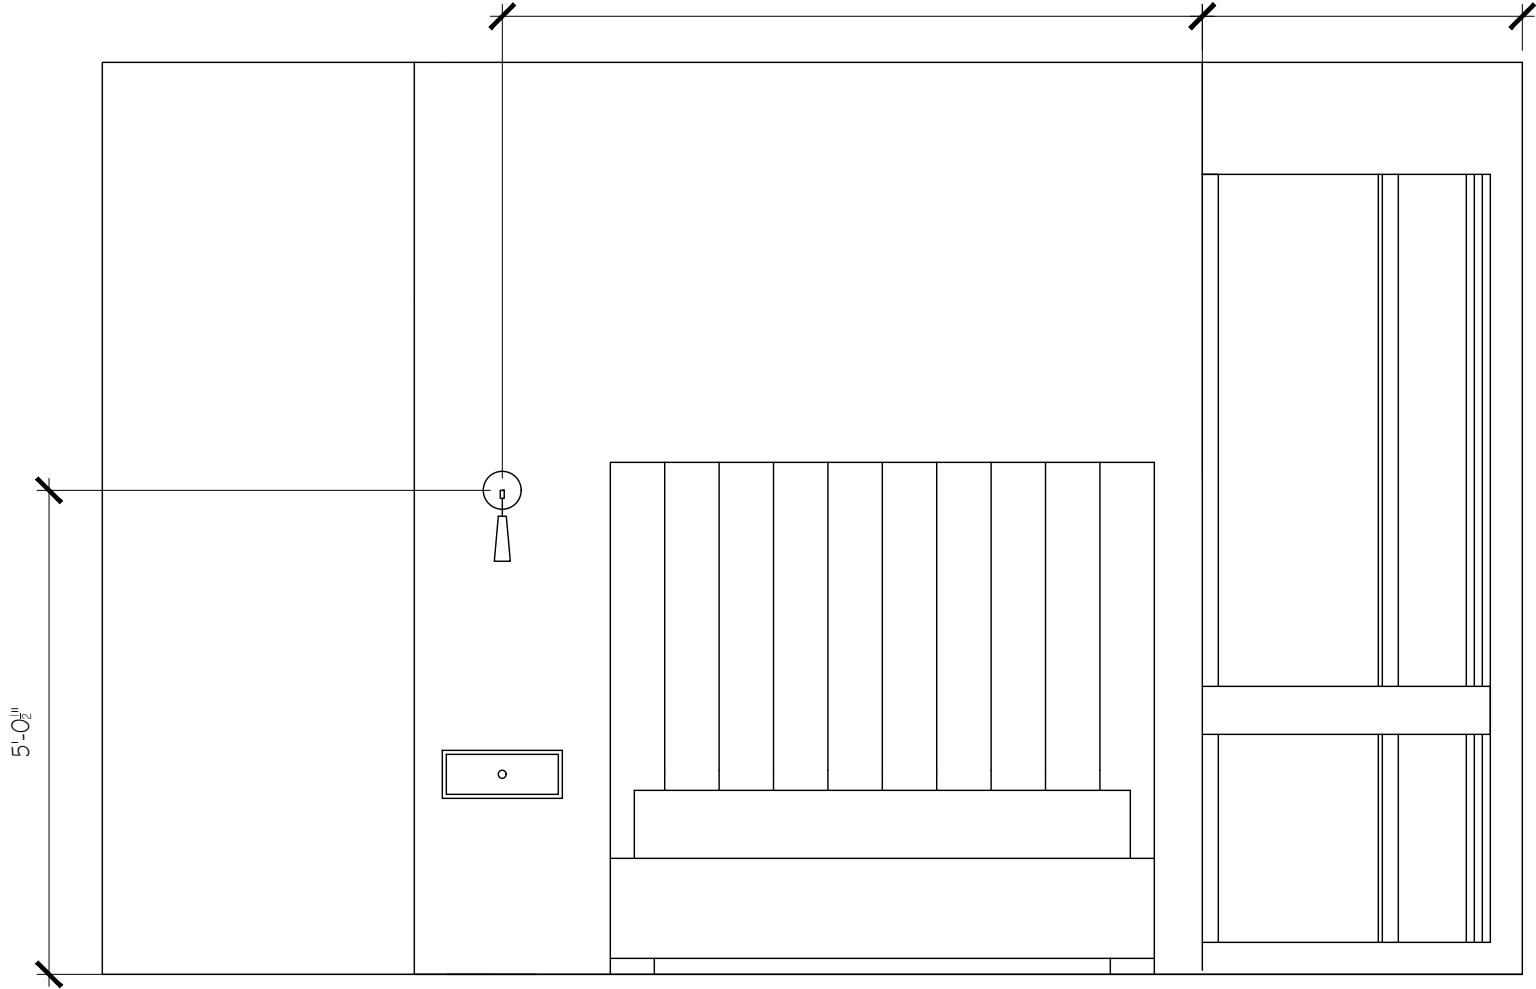



SCALE: $\frac{1}{2}$ " = 1'-0"

CONTINUUM MIAMI
BEDROOM 2 SCNCE ELEVATION

WEETH HOME

SCALE: $\frac{1}{2}'' = 1'-0''$

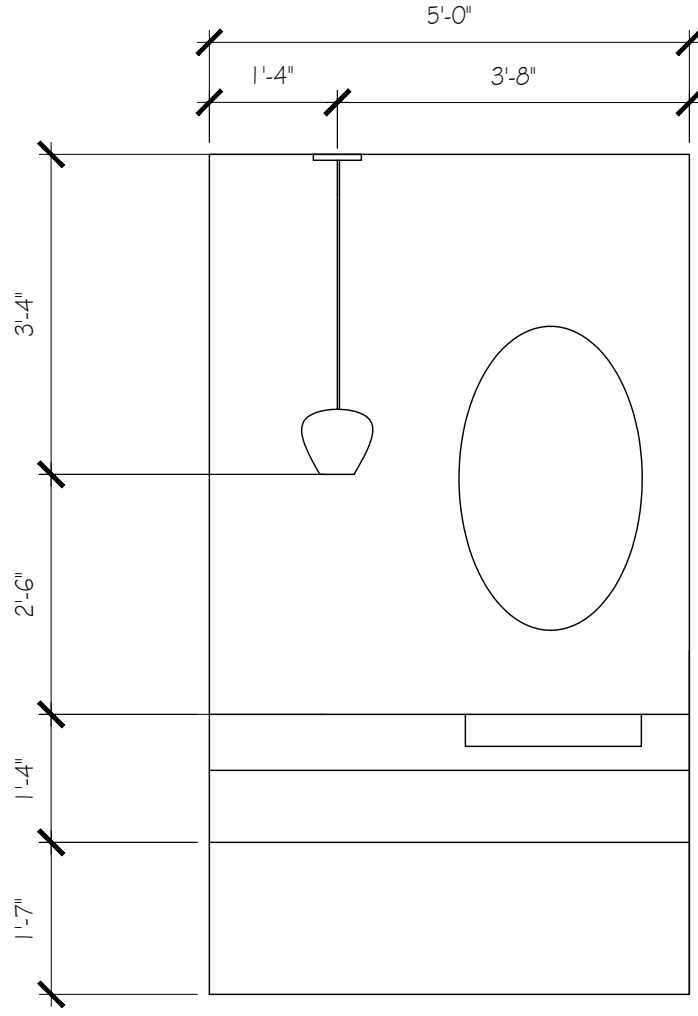


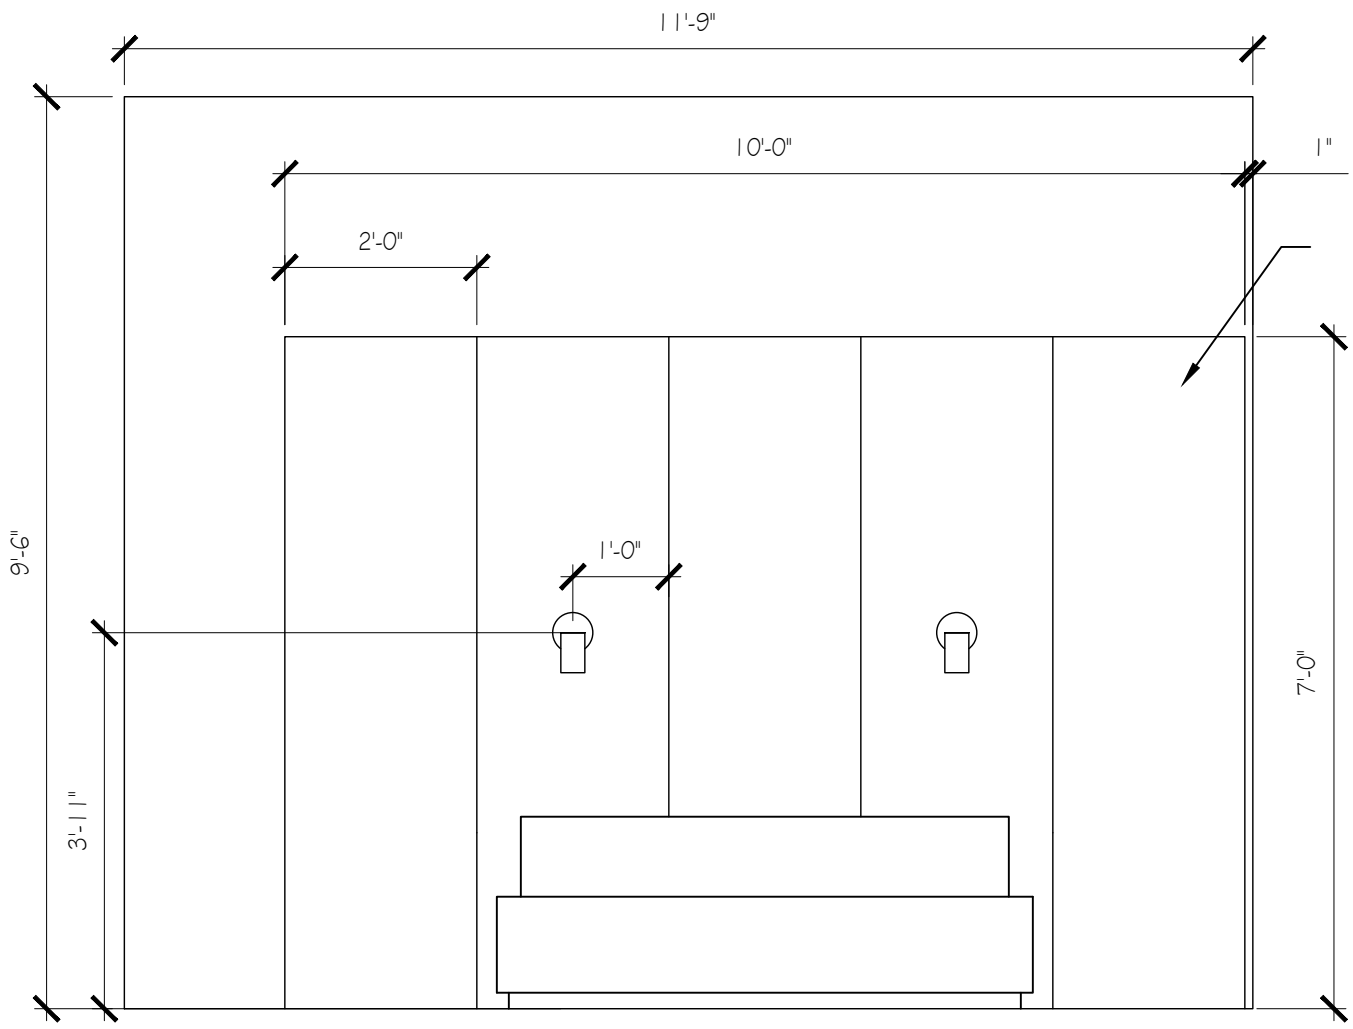


UPHOLSTERED PANELS ON WALL
1" OFF END OF CURVED WALL

SCALE: $\frac{1}{2}$ " = 1'-0"

SCALE: $\frac{1}{2}$ " = 1'-0"

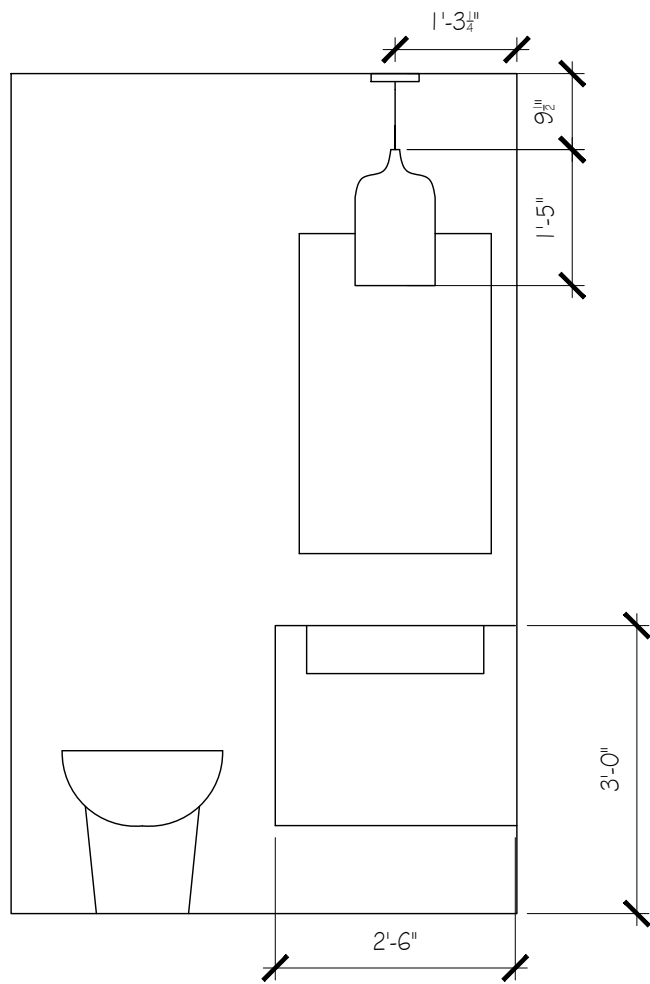

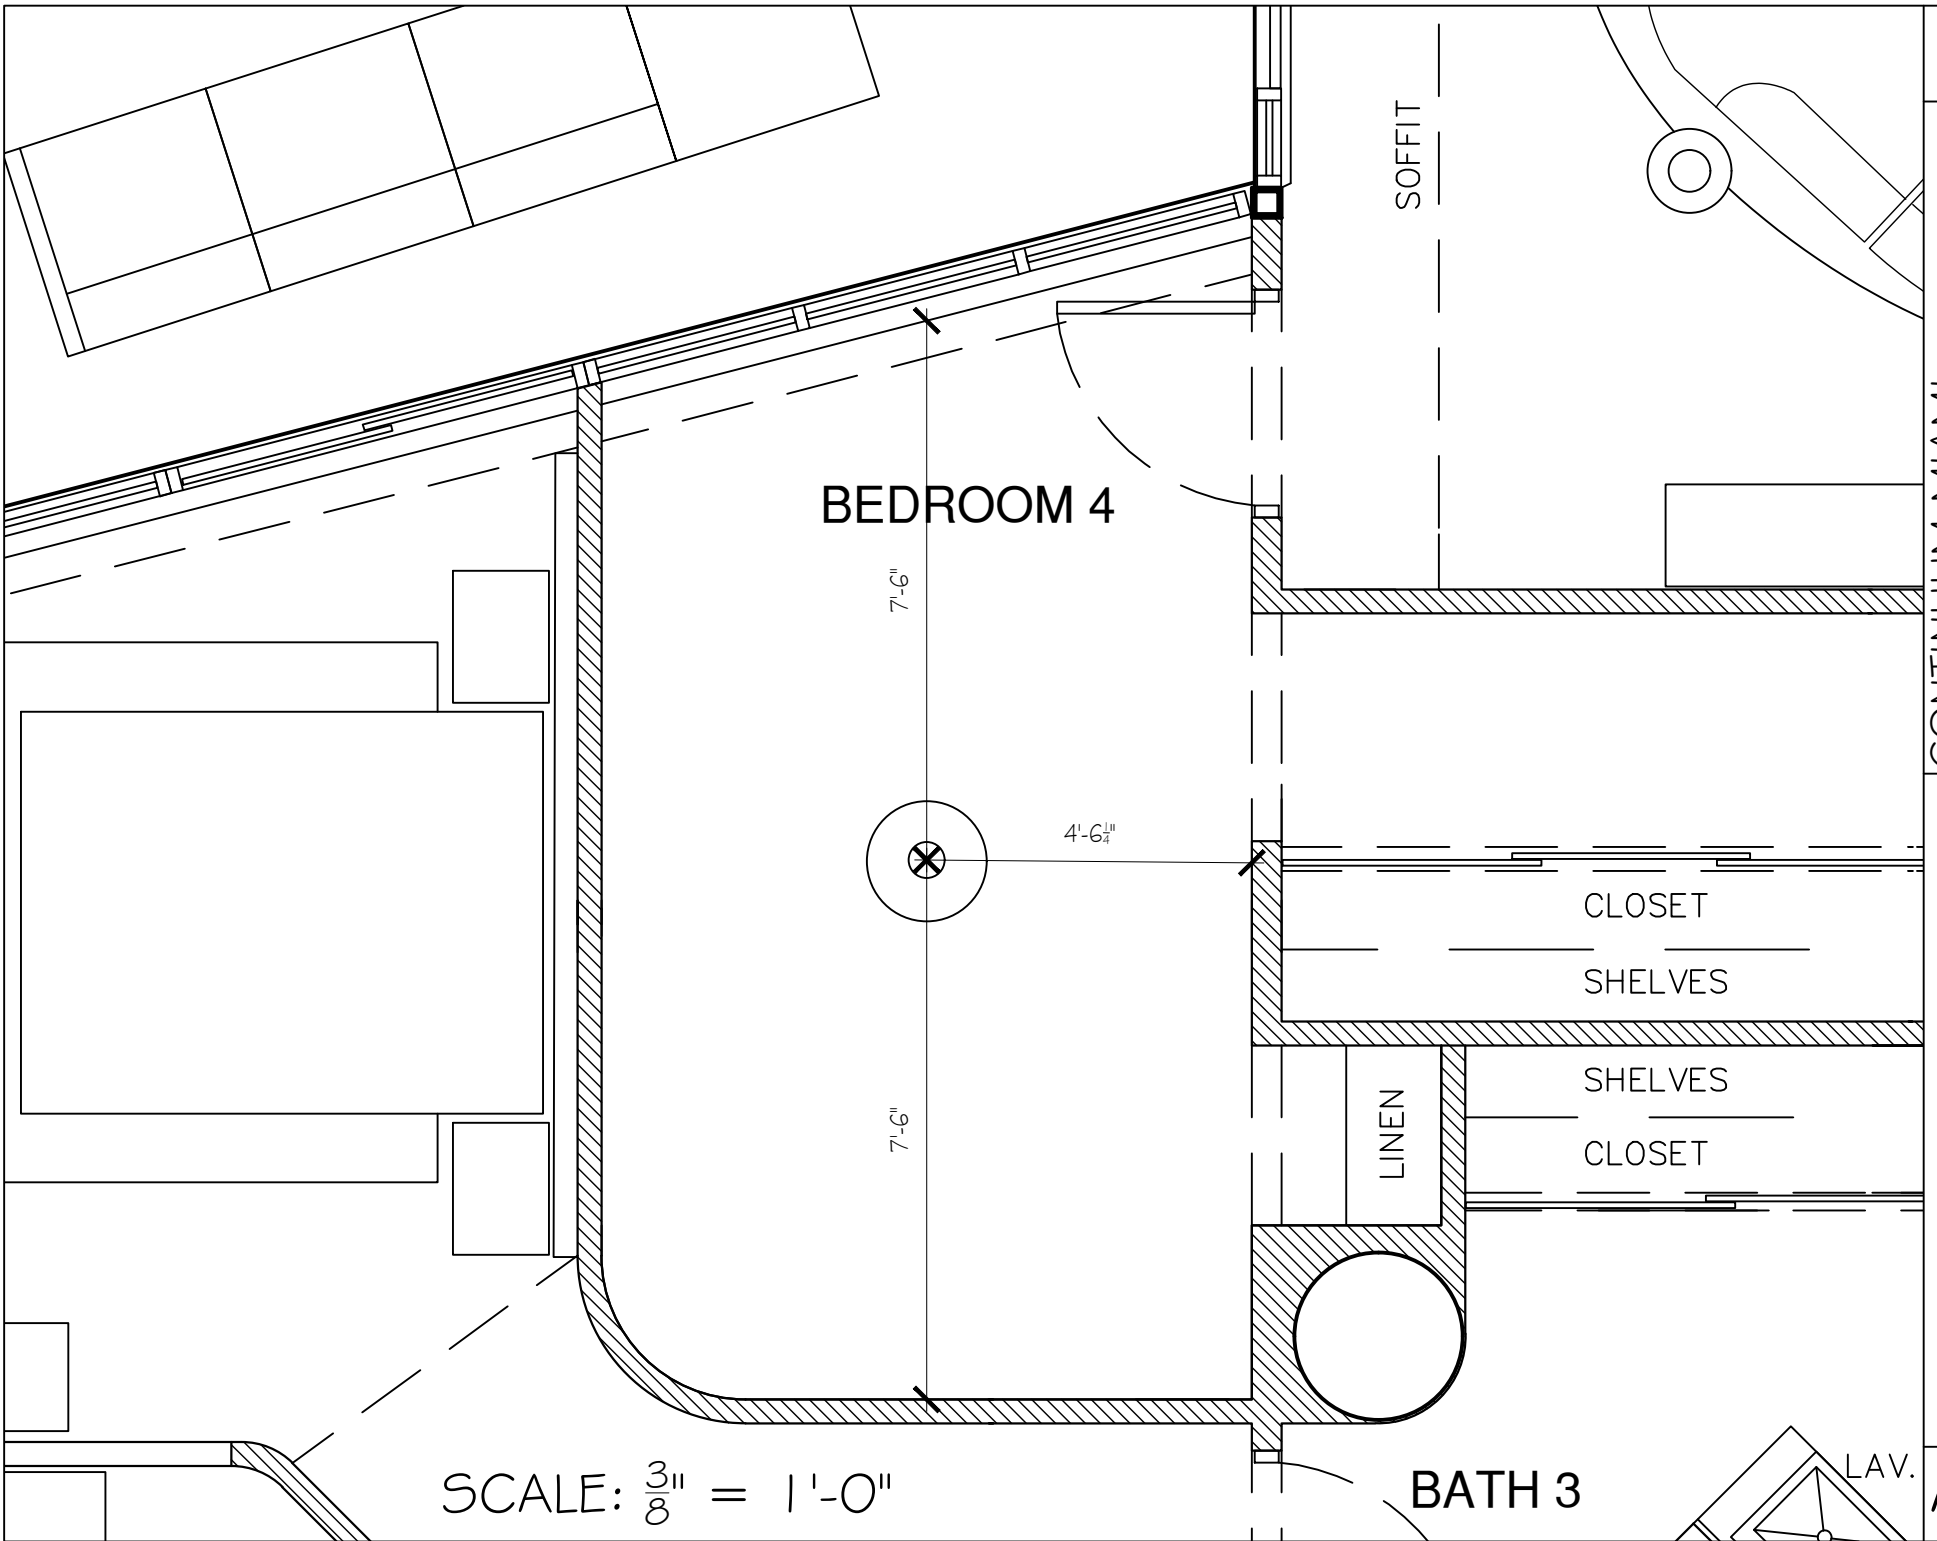

CONTINUUM MIAMI
 BEDROOM 4 CHANDELIER PLAN VIEW

WEETH HOME

A2

SCALE: $\frac{1}{2}'' = 1'-0''$

